
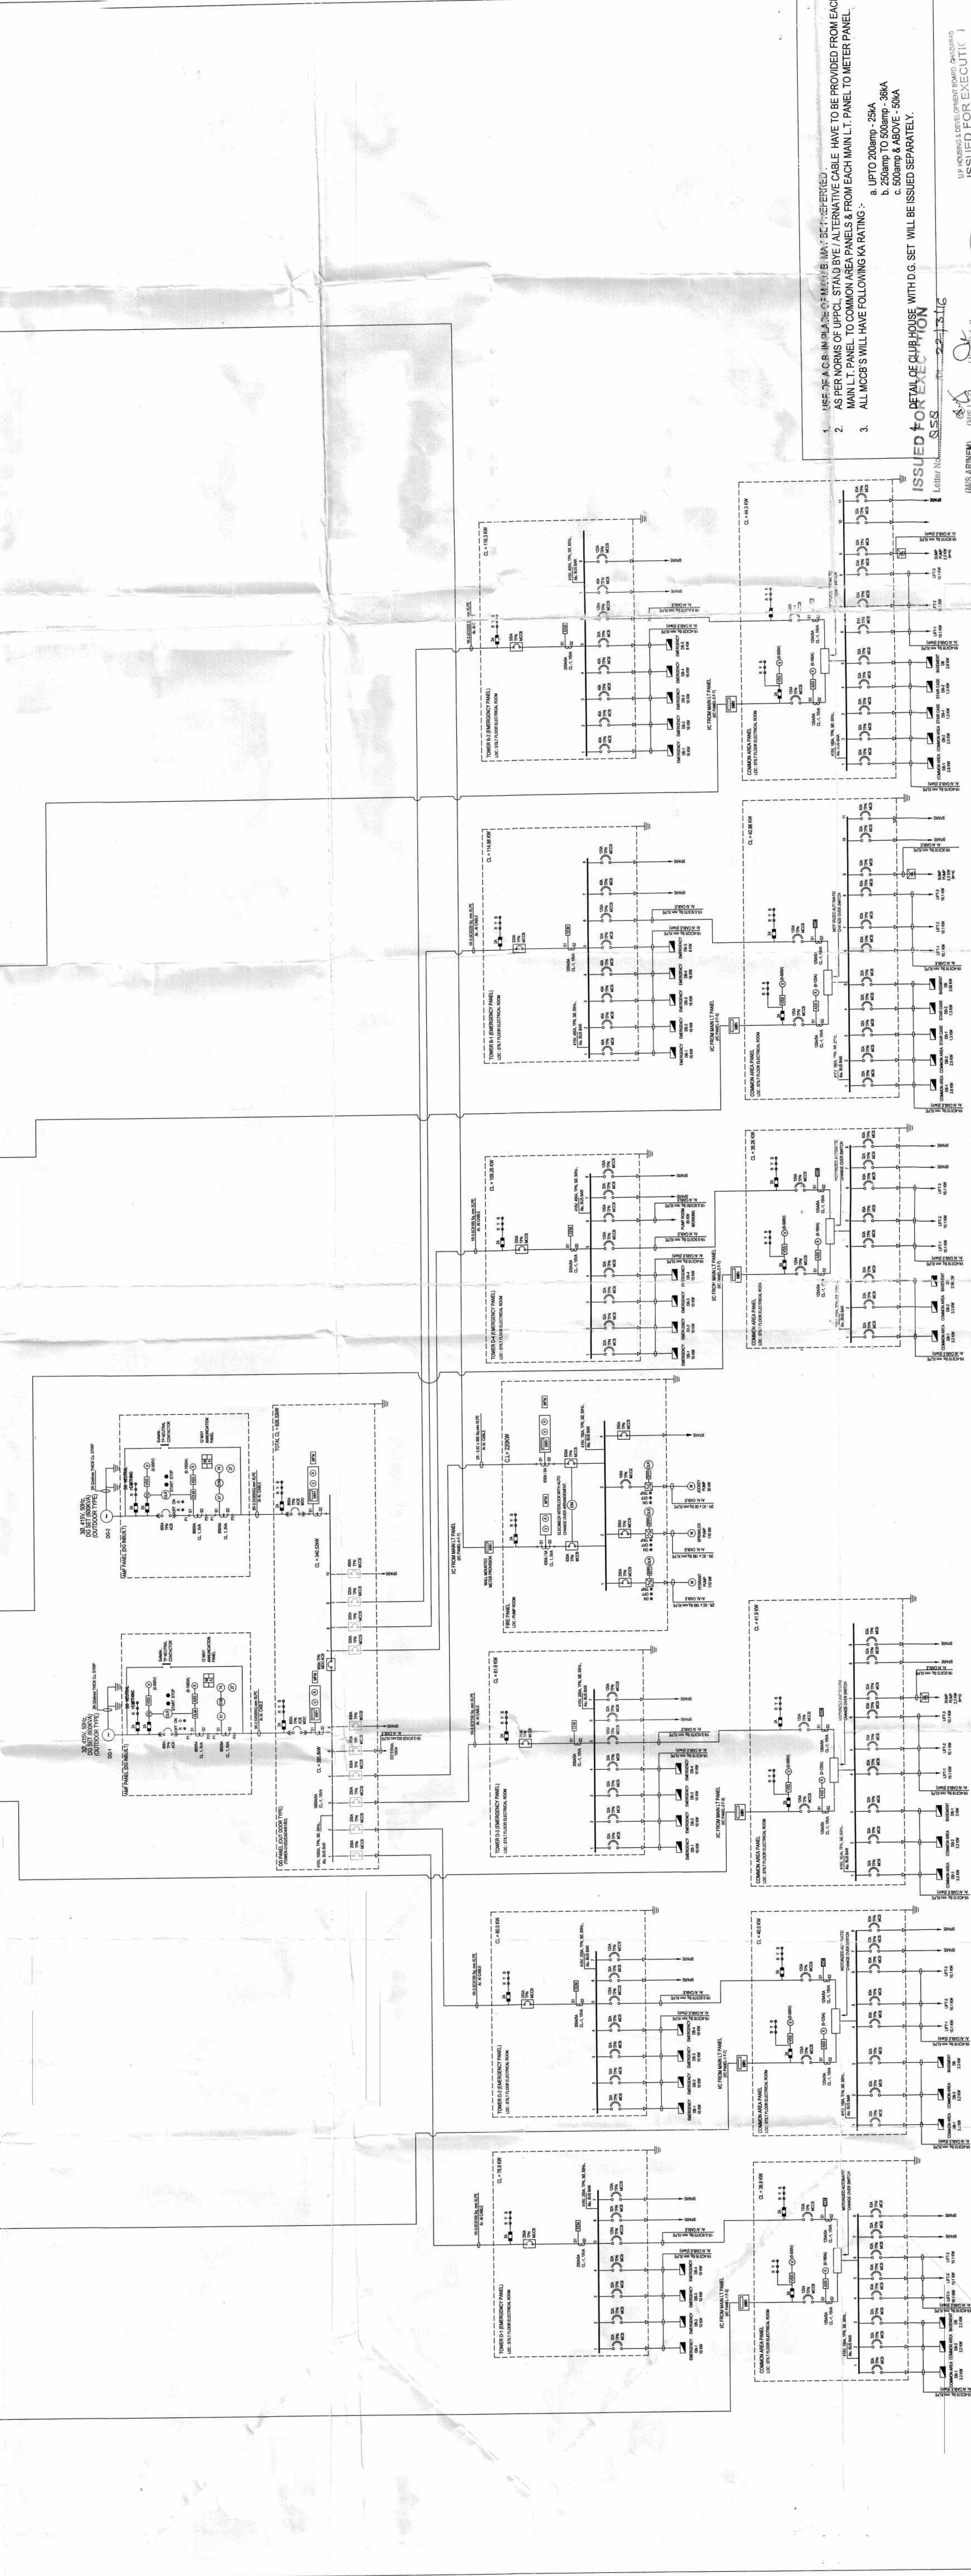


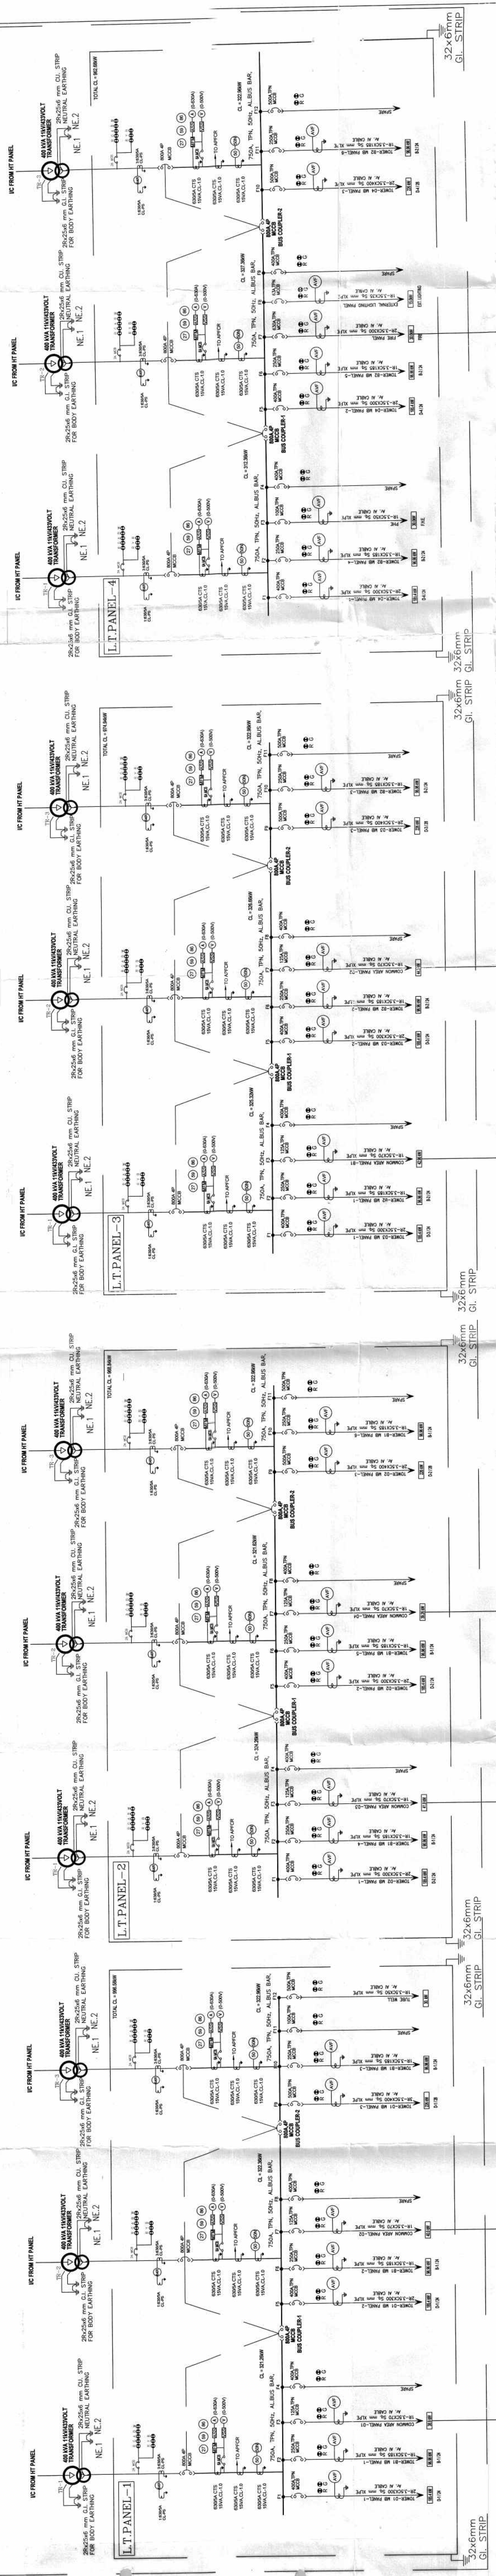

1. USE OF AGING IN PLACE OF METER MAY BE PERMITTED
2. AS PER NORMS OF UPCL, STATIONARY EQUIPMENT HAVE TO BE PROVIDED FROM EACH MAIN L.T. PANEL TO EACH MAIN L.T. PANEL TO METER PANEL
3. ALL ACCESS WILL HAVE FOLLOWING RATING :-
a. UPTO 200amp - 25KA
b. 250amp TO 500amp - 35KA
c. 500amp & ABOVE - 50KA

ISSUED FOR FINAL REVIEW
DATE: 22-02-16
BY: [Signature]

UP ANDHRA PRADESH GOVT. ENGINEERING
ISSUED FOR EXECUTION
DATE: 22-02-16
BY: [Signature]

PROJECT TITLE		SIDDHARTH VIHAR YOUNA AT SECTOR-7 GHAZIABAD (GROUP HOUSING)	
DRAWING TITLE		MASTER SINGLE LINE DIAGRAM	
DRAWING NO.		02-01-RG-01-SRE-001.01(A)	
DATE		FEB' 16	
SCALE		NTS	
CLIENT		UP - Housing & Development Board	
CONSTRUCTION USER		LAT Construction	

06					
05					
04					
03					
02	MANOJ	SIDDHARTH	22-02-16	Released for Execution	
01	MANOJ	SIDDHARTH	01-01-16		
REV	DRAWN	APPROVED	BY & DATE	STATUS	DRAWING NO.

NOTES:

1. No dimensions to be scaled off the drawing.
2. Only written dimensions in Millimeters to be followed
3. Any discrepancy found in the drawing to be immediately got clarified with the Architect or his representative at site.
4. All drawings are interrelated and shall be read in conjunction with other drawings.

This drawing is the property of ARINEM Consultancy Pvt. Ltd. and is not to be reproduced, copied, handed over to a third party or used for any other purpose other than for which it has been loaned.