


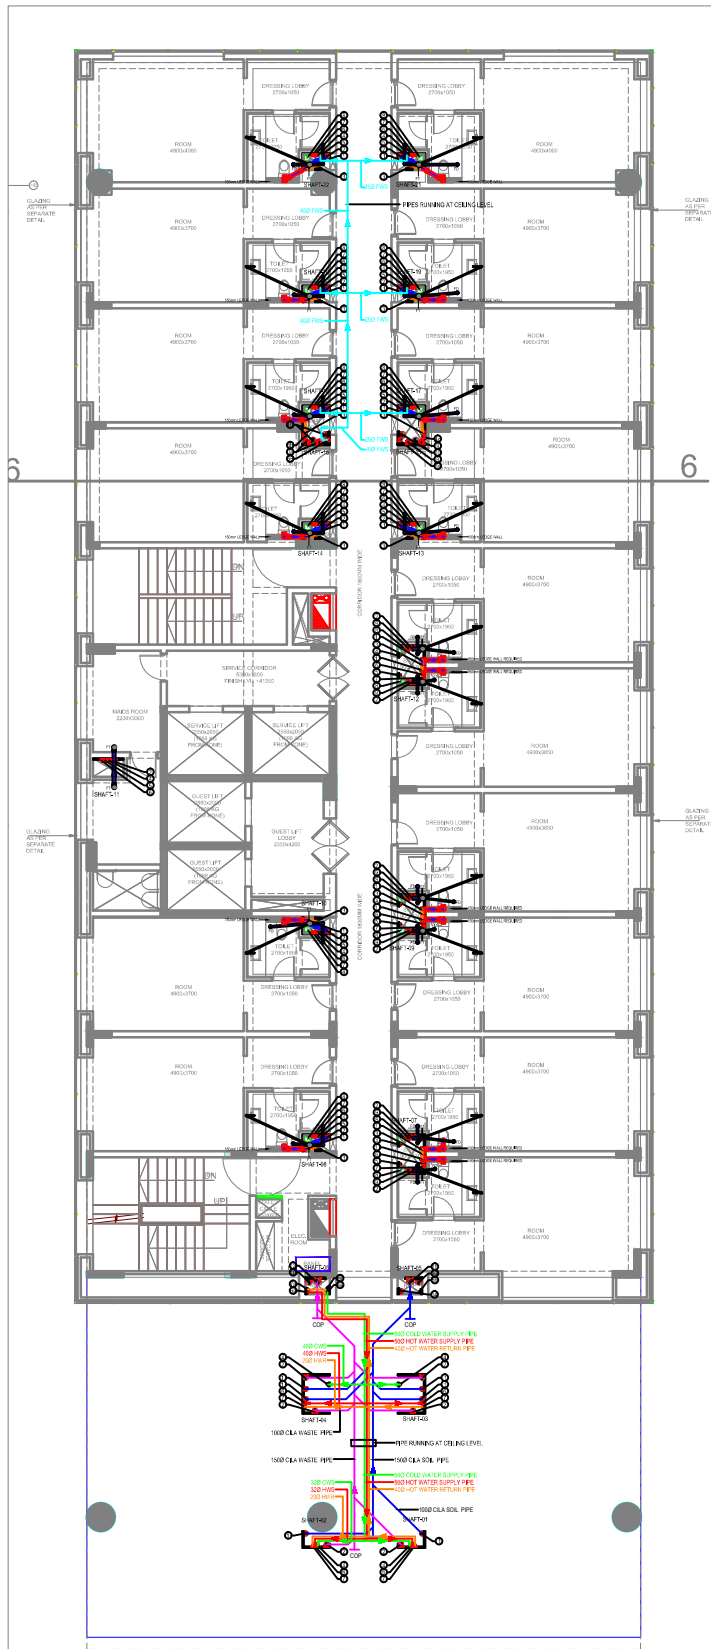

9TH FLOOR
ARCHITECTURAL
SLAB PROFILE

PLUMBING LEGEND	
①	110 (OD) UPVC SOIL VERTICAL & VENT PIPE
②	110 (OD) UPVC WASTE VERTICAL & VENT PIPE
③	75 (OD) UPVC ANTI-SYPHONAGE PIPE
④	COLD WATER SUPPLY PIPE FOR GUEST FLOOR (HYDRO-PNEUMATIC SYSTEM)
⑤	COLD WATER SUPPLY PIPE FROM PUMP ROOM BASEMENT TO GUEST FLOOR
⑥	COLD WATER SUPPLY PIPE FOR SOLAR PANEL FROM O.H. TANK
⑦	COLD WATER SUPPLY PIPE TO O.H. TANK
⑧	FLUSHING WATER SUPPLY PIPE FOR GUEST FLOOR FROM O.H. TANK
⑨	FLUSHING WATER SUPPLY PIPE TO O.H. TANK
⑩	FLUSHING WATER SUPPLY PIPE FOR TOILET FROM O.H. TANK
⑪	HOT WATER SUPPLY PIPE FROM BOILER FOR GUEST FLOOR
⑫	HOT WATER SUPPLY PIPE FROM BOILER ROOM BASEMENT TO SERVICE FLOOR
⑬	HOT WATER SUPPLY PIPE FROM SOLAR PANEL TO BOILER ROOM
⑭	HOT WATER RETURN PIPE TO BOILER FOR GUEST FLOOR
⑮	HOT WATER RETURN PIPE TO BOILER ROOM SERVICE FLOOR TO BASEMENT
⑯	TOILET EXHAUST DUCT SIZE = 200 X 200MM
⑰	CHILLED WATER SUPPLY RETURN PIPE
⑱	180 OD UPVC RAIN WATER PIPE FROM TERRACE
⑲	1500 CILA SOIL VERTICAL & VENT PIPE
⑳	1500 CILA WASTE VERTICAL & VENT PIPE
㉑	SOFT WATER SUPPLY PIPE
● FT	FLOOR TRAP 110X110mm (UPVC SWR 9" TRAP) WITH S.S. GRATING
● FD	FLOOR DRAIN (110X63mm) WITH S.S. GRATING
WB TO FT	40 (OD) UPVC PIPE
FD TO FT	63 (OD) UPVC PIPE
FT TO V. STACK	110 (OD) UPVC PIPE
WC TO V. STACK	110 (OD) UPVC PIPE
—	COLD WATER SUPPLY PIPE
—	HOT WATER SUPPLY PIPE
—	HOT WATER RETURN PIPE
—	FLUSHING WATER SUPPLY PIPE
—	SOIL PIPE
—	WASTE PIPE

00	-----	00/00/00
NO. OF PRINTS	ISSUED TO	DATE
S.N.	DATE	DETAILS
REVISIONS		

PROJECT
ORIZZONTE COMMERCIAL PROJECT
PLOT NO. 22 SECTOR IT, KP-III
GREATER NOIDA

CLIENT

FACILITY PLANNER

STRUCTURAL CONSULTANT

Concept Design Consortium PVT. LTD
STRUCTURAL, MECHANICAL & PROJECT CONSULTANTS
Block 10, 1st Floor, 5-CONCRETE, NEW DELHI, INDIA

ARCHITECT
GENRE OF DESIGN
ARCHITECTURE, MASTER PLANNING
& INTERIOR DESIGN
A-30, BASEMENT FLOOR, SHALAKH, MALVIYA NAGAR, NEW DELHI
TELEPHONE: 011-40544888

MEP CONSULTANTS
C TO C Services Consultants Pvt. Ltd.
F-47, (Basement) Green Park Main,
New Delhi-110016 (INDIA)
Tel.: 41618888, 41618866
E-mail: ctoctoc@ctoctocconsultants.com

STAGE
TENDER DRAWING

DRAWING TITLE
**9th FLOOR PLAN_ HOTEL BLOCK
(PLUMBING LAYOUT)**

Drawn S.P	Checked S.R	Approved H.S
Scale 1:75 @ A1	Date 18.05.2015	Rev. No. R0
Drawing No. CTOC.SEPL.1481.PL.13		