


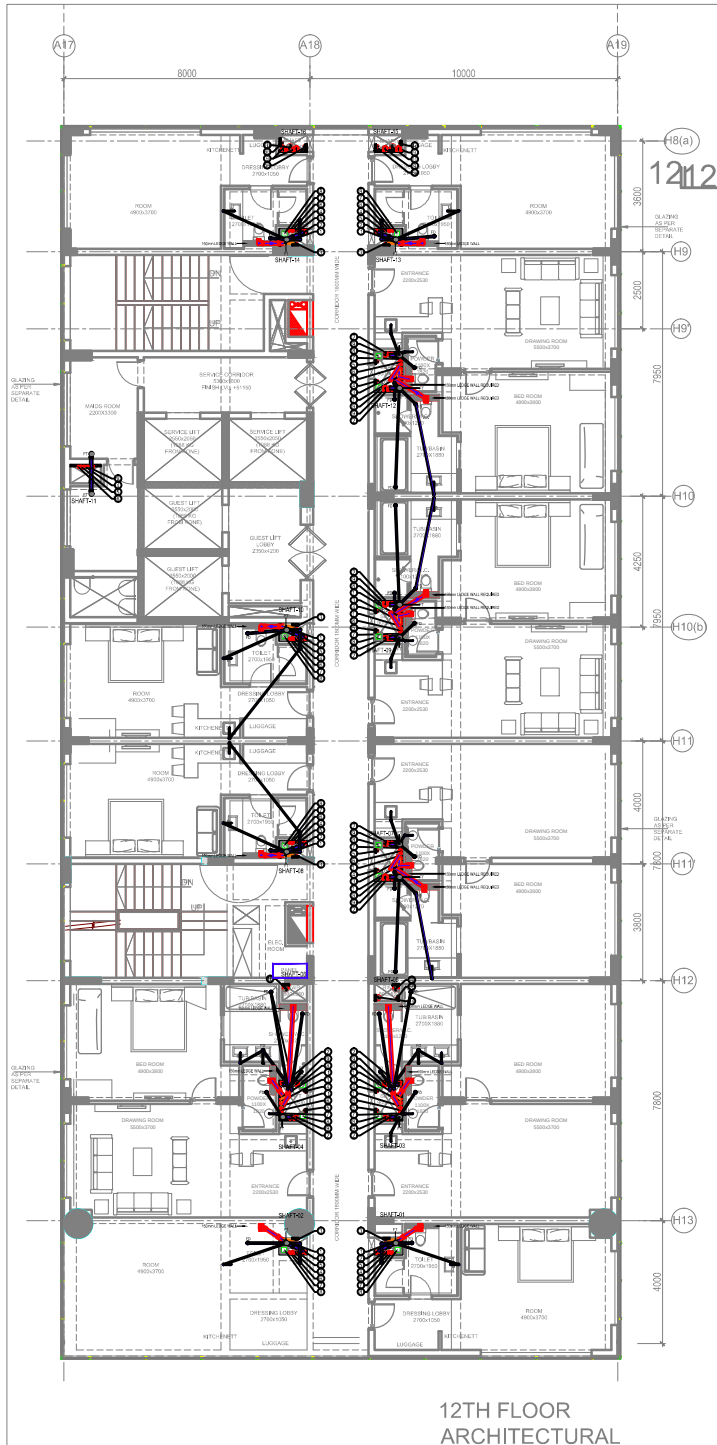

12TH FLOOR
ARCHITECTURAL

PLUMBING LEGEND	
①	110 (OD) UPVC SOL VERTICAL & VENT PIPE
②	110 (OD) UPVC WASTE VERTICAL & VENT PIPE
③	75 (OD) UPVC ANTI SYPHONAGE PIPE
④	COLD WATER SUPPLY PIPE FOR GUEST FLOOR (HYDRO-PNEUMATIC SYSTEM)
④a	COLD WATER SUPPLY PIPE FROM PUMP ROOM BASEMENT TO GUEST FLOOR
④b	COLD WATER SUPPLY PIPE FOR SOLAR PANEL FROM O.H. TANK
⑤	COLD WATER SUPPLY PIPE TO O.H. TANK
⑤a	FLUSHING WATER SUPPLY PIPE FOR GUEST FLOOR FROM O.H. TANK
⑤b	FLUSHING WATER SUPPLY PIPE TO O.H. TANK
⑥	FLUSHING WATER SUPPLY PIPE FOR TOILET FROM O.H. TANK
⑥a	HOT WATER SUPPLY PIPE FROM BOILER ROOM GUEST FLOOR
⑥b	HOT WATER SUPPLY PIPE FROM BOILER ROOM BASEMENT TO SERVICE FLOOR
⑥c	HOT WATER SUPPLY PIPE FROM SOLAR PANEL TO BOILER ROOM
⑦	HOT WATER RETURN PIPE TO BOILER FOR GUEST FLOOR
⑦a	HOT WATER RETURN PIPE TO BOILER ROOM SERVICE FLOOR TO BASEMENT
⑧	TOILET EXHAUST DUCT SIZE = 200 X 200MM
⑨	CHILLED WATER SUPPLY RETURN PIPE
⑩	160 OD UPVC RAIN WATER PIPE FROM TERRACE
⑭	SOFT WATER SUPPLY PIPE
● FT FLOOR TRAP 110X110mm (UPVC 3000 P.T. TRAP) WITH S.S. GRATING ● FD FLOOR DRAIN 110X63mm WITH S.S. GRATING WB TO FT 40 (OD) UPVC PIPE FD TO FT 63 (OD) UPVC PIPE FT TO V. STACK 110 (OD) UPVC PIPE WC TO V. STACK 110 (OD) UPVC PIPE	

00	----	00/00/00
NO. OF PRINTS	ISSUED TO	DATE
S.N.	DATE	DETAILS
REVISIONS		

PROJECT
ORIZZONTE COMMERCIAL PROJECT
PLOT NO. 22 SECTOR IT, KP-III
GREATER NOIDA

CLIENT

FACILITY PLANNER

STRUCTURAL CONSULTANT

Koncept Design Consortium PVT. LTD
STRUCTURAL, MECHANICAL & ELECTRICAL CONSULTANTS
Block 101, 102, 103, 999, 1000

ARCHITECT

GENRE OF DESIGN
ARCHITECTURE, MASTER PLANNING
& INTERIOR DESIGN
4-02, BASEMENT FLOOR, SHALUKH, MALVIYA NAGAR, NEW DELHI
TELEPHONE: 011-40541868

MEP CONSULTANTS
C TO C Services Consultants Pvt. Ltd.
F-47, (Basement) Green Park Main,
New Delhi-110016 (INDIA)
Tel.: 41618888, 41618866
E-mail: ctocto@ctocconsultants.com

STAGE
TENDER DRAWING

DRAWING TITLE
12th FLOOR PLAN_ HOTEL BLOCK
(PLUMBING LAYOUT)

Drawn S.P	Checked S.R	Approved H.S
Scale 1:75 @ A1	Date 18.05.2015	Rev. No. R0

Drawing No.
CTOC, SEPL. 1481.PL. 16