


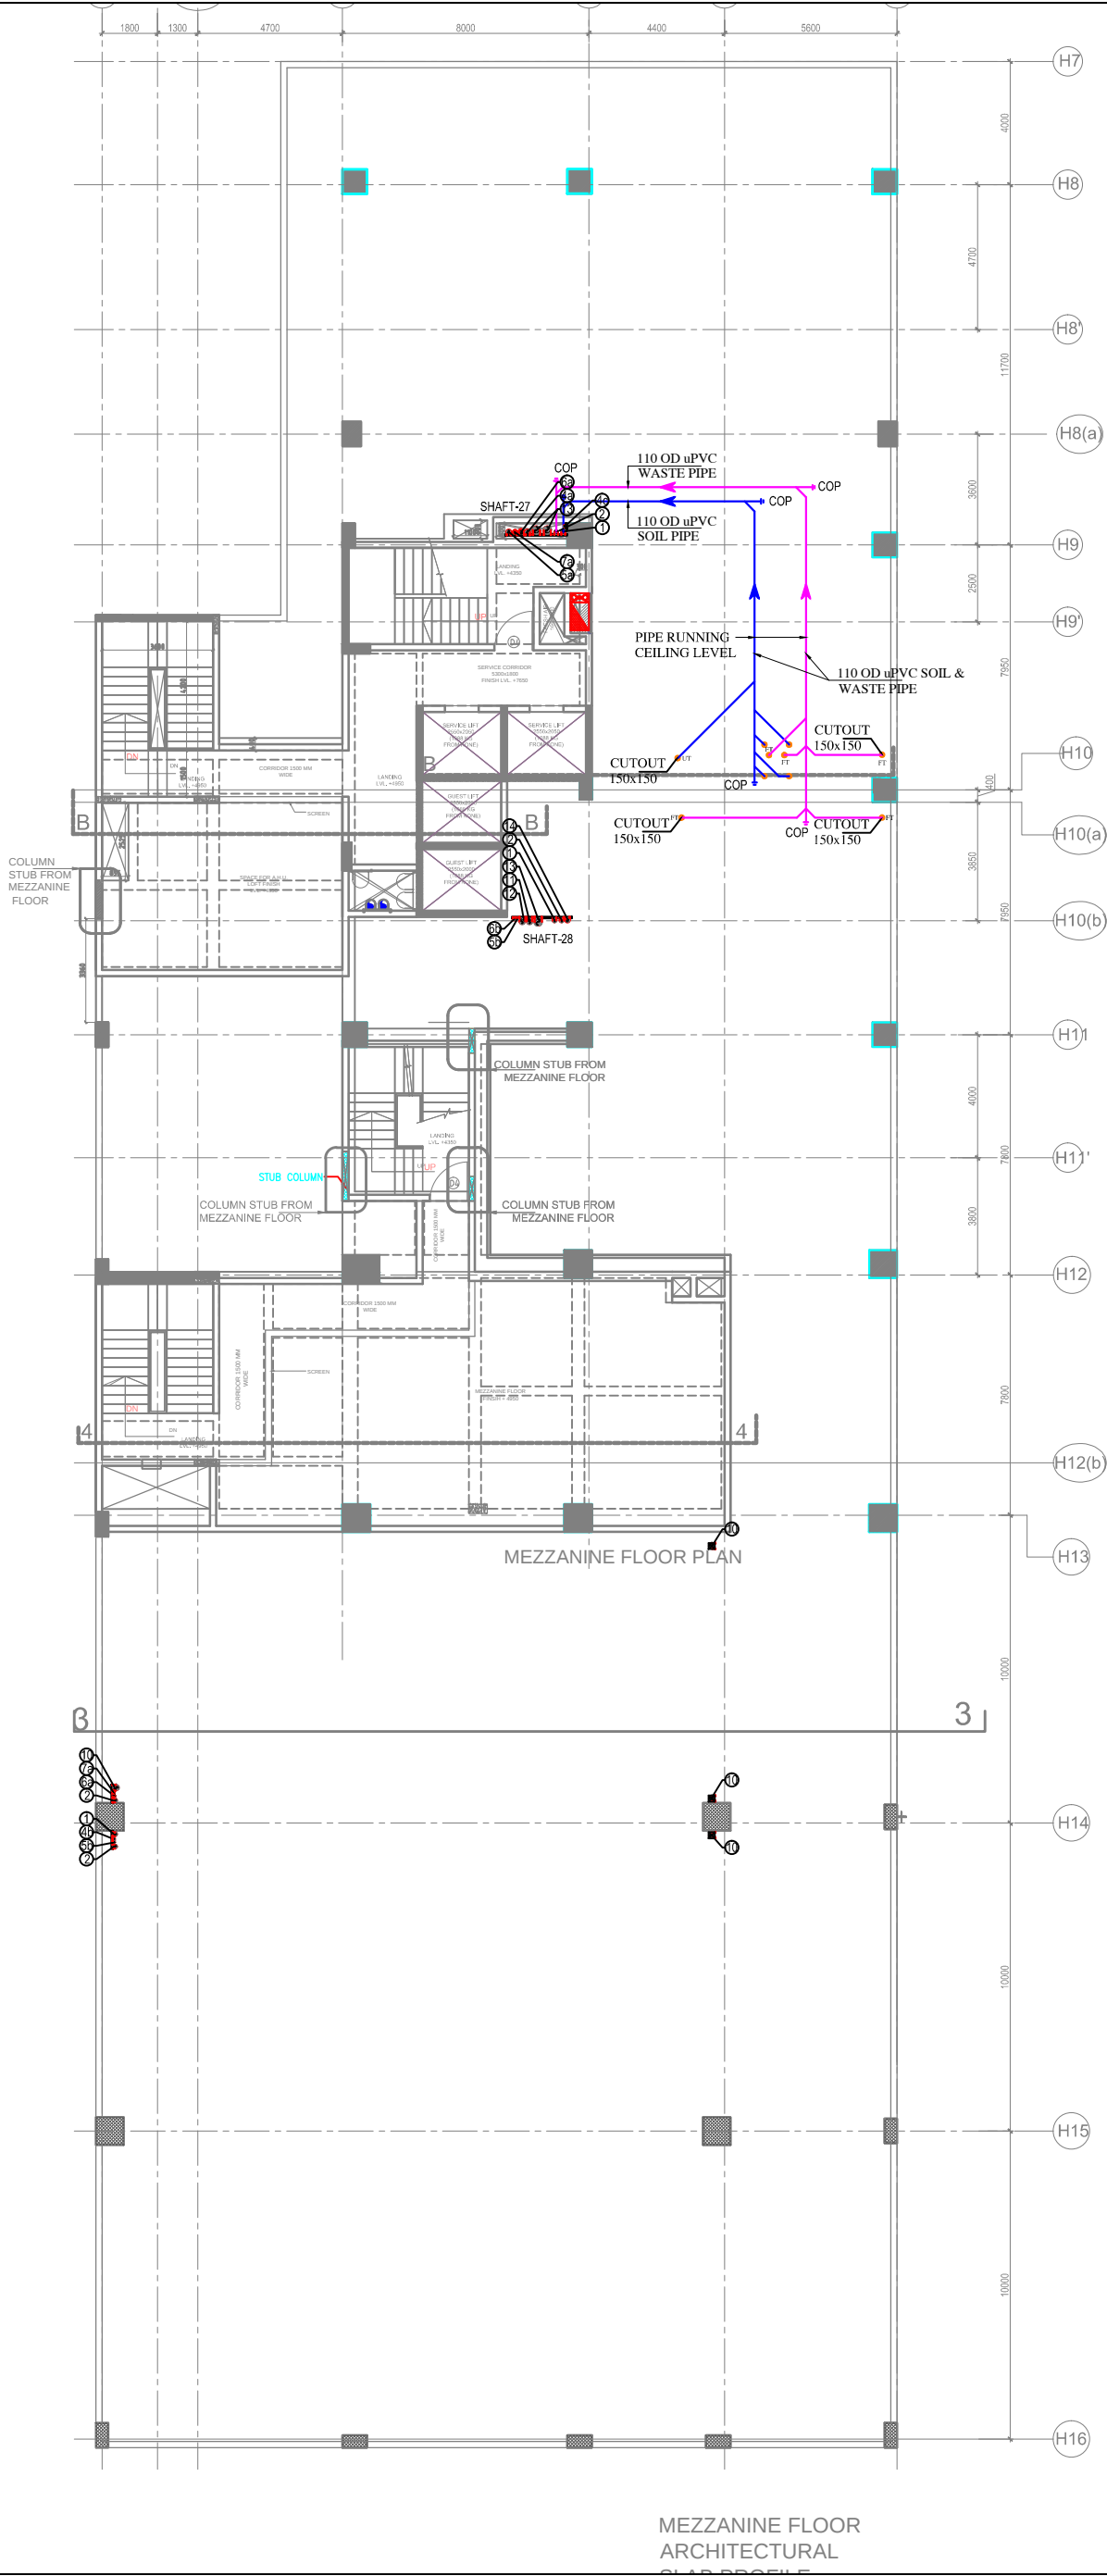

PLUMBING LEGEND	
1	110 (OD) uPVC SOIL VERTICAL & VENT PIPE
2	110 (OD) uPVC WASTE VERTICAL & VENT PIPE
2a	150Ø C.J. KITCHEN WASTE VERTICAL PIPE
3	75 (OD) uPVC ANTI-SYPHONAGE PIPE
4	COLD WATER SUPPLY PIPE FOR GUEST FLOOR (HYDRO-PNEUMATIC SYSTEM)
4a	COLD WATER SUPPLY PIPE FROM PUMP ROOM BASEMENT TO SERVICE FLOOR
4b	COLD WATER SUPPLY PIPE FOR SOLAR PANEL FROM O.H. TANK
4c	COLD WATER SUPPLY PIPE TO O.H. TANK
5	FLUSHING WATER SUPPLY PIPE FOR GUEST FLOOR FROM O.H. TANK
5a	FLUSHING WATER SUPPLY PIPE TO O.H. TANK
5b	FLUSHING WATER SUPPLY PIPE FOR TOILET FROM O.H. TANK
6	HOT WATER SUPPLY PIPE FROM BOILER FOR GUEST FLOOR
6a	HOT WATER SUPPLY PIPE FROM BOILER ROOM BASEMENT TO SERVICE FLOOR
6b	HOT WATER SUPPLY PIPE FROM SOLAR PANEL TO BOILER ROOM
7	HOT WATER RETURN PIPE TO BOILER FOR GUEST FLOOR
7a	HOT WATER RETURN PIPE TO BOILER ROOM SERVICE FLOOR TO BASEMENT
8	TOILET EXHAUST DUCT SIZE = 200 X 200MM
9	CHILLED WATER SUPPLY/ RETURN PIPE
10	160 OD uPVC RAIN WATER PIPE FROM TERRACE
11	150Ø CILA SOIL VERTICAL & VENT PIPE
12	150Ø CILA WASTE VERTICAL & VENT PIPE
13	200Ø CILA RAIN WATER PIPE
14	SOFT WATER SUPPLY PIPE
15	R.O. WATER SUPPLY PIPE
FT	FLOOR TRAP 110X110mm (uPVC SWR 'P' TRAP) WITH S.S. GRATING
FD	FLOOR DRAIN (110X63mm) WITH S.S. GRATING
WB TO FT	40 (OD) uPVC PIPE
FD TO FT	63 (OD) uPVC PIPE
FT TO V.STACK	110 (OD) uPVC PIPE
WC TO V.STACK	110 (OD) uPVC PIPE
—	SOIL PIPE
—	WASTE PIPE
—	RAIN WATER PIPE

00	---	00/00/00
NO. OF PRINTS	ISSUED TO	DATE
S.N.	DATE	DETAILS
REVISIONS		
PROJECT		
ORIZZONTE COMMERCIAL PROJECT PLOT NO. 22 SECTOR IT, KP-III GREATER NOIDA		
CLIENT		
FACILITY PLANNER		
STRUCTURAL CONSULTANT		
 Konzept Design Consortium PVT. LTD STRUCTURAL ENGINEERS & PROJECT CONSULTANTS Branch: 002 : PLOT NO. 2-10, SECTOR 02P, INDIA		
ARCHITECT		
GENRE OF DESIGN ARCHITECTURE, MASTER PLANNING & INTERIOR DESIGN A-57, BASEMENT FLOOR, SHIVAJI, MALVIYA NAGAR, NEW DELHI TELEPHONE: 011-40574968		
MEP CONSULTANTS		
 C to C Services Consultants Pvt. Ltd. F-67, - (Basement) Green Park Main, New Delhi-110016 (INDIA) Tel.: 41618888, 41618866 E-mail: ctocinfo@ctocconsultants.com		
STAGE		
TENDER DRAWING		
DRAWING TITLE		
MEZZANINE FLOOR PLAN HOTEL BLOCK (PLUMBING CUTOUT)		
Drawn S.P	Checked S.R	Approved H.S
Scale 1:100 @ A1	Date 18.05.2015	Rev. No. R0
Drawing No.		
CTOC.SEP.L.1481.PL.03		