


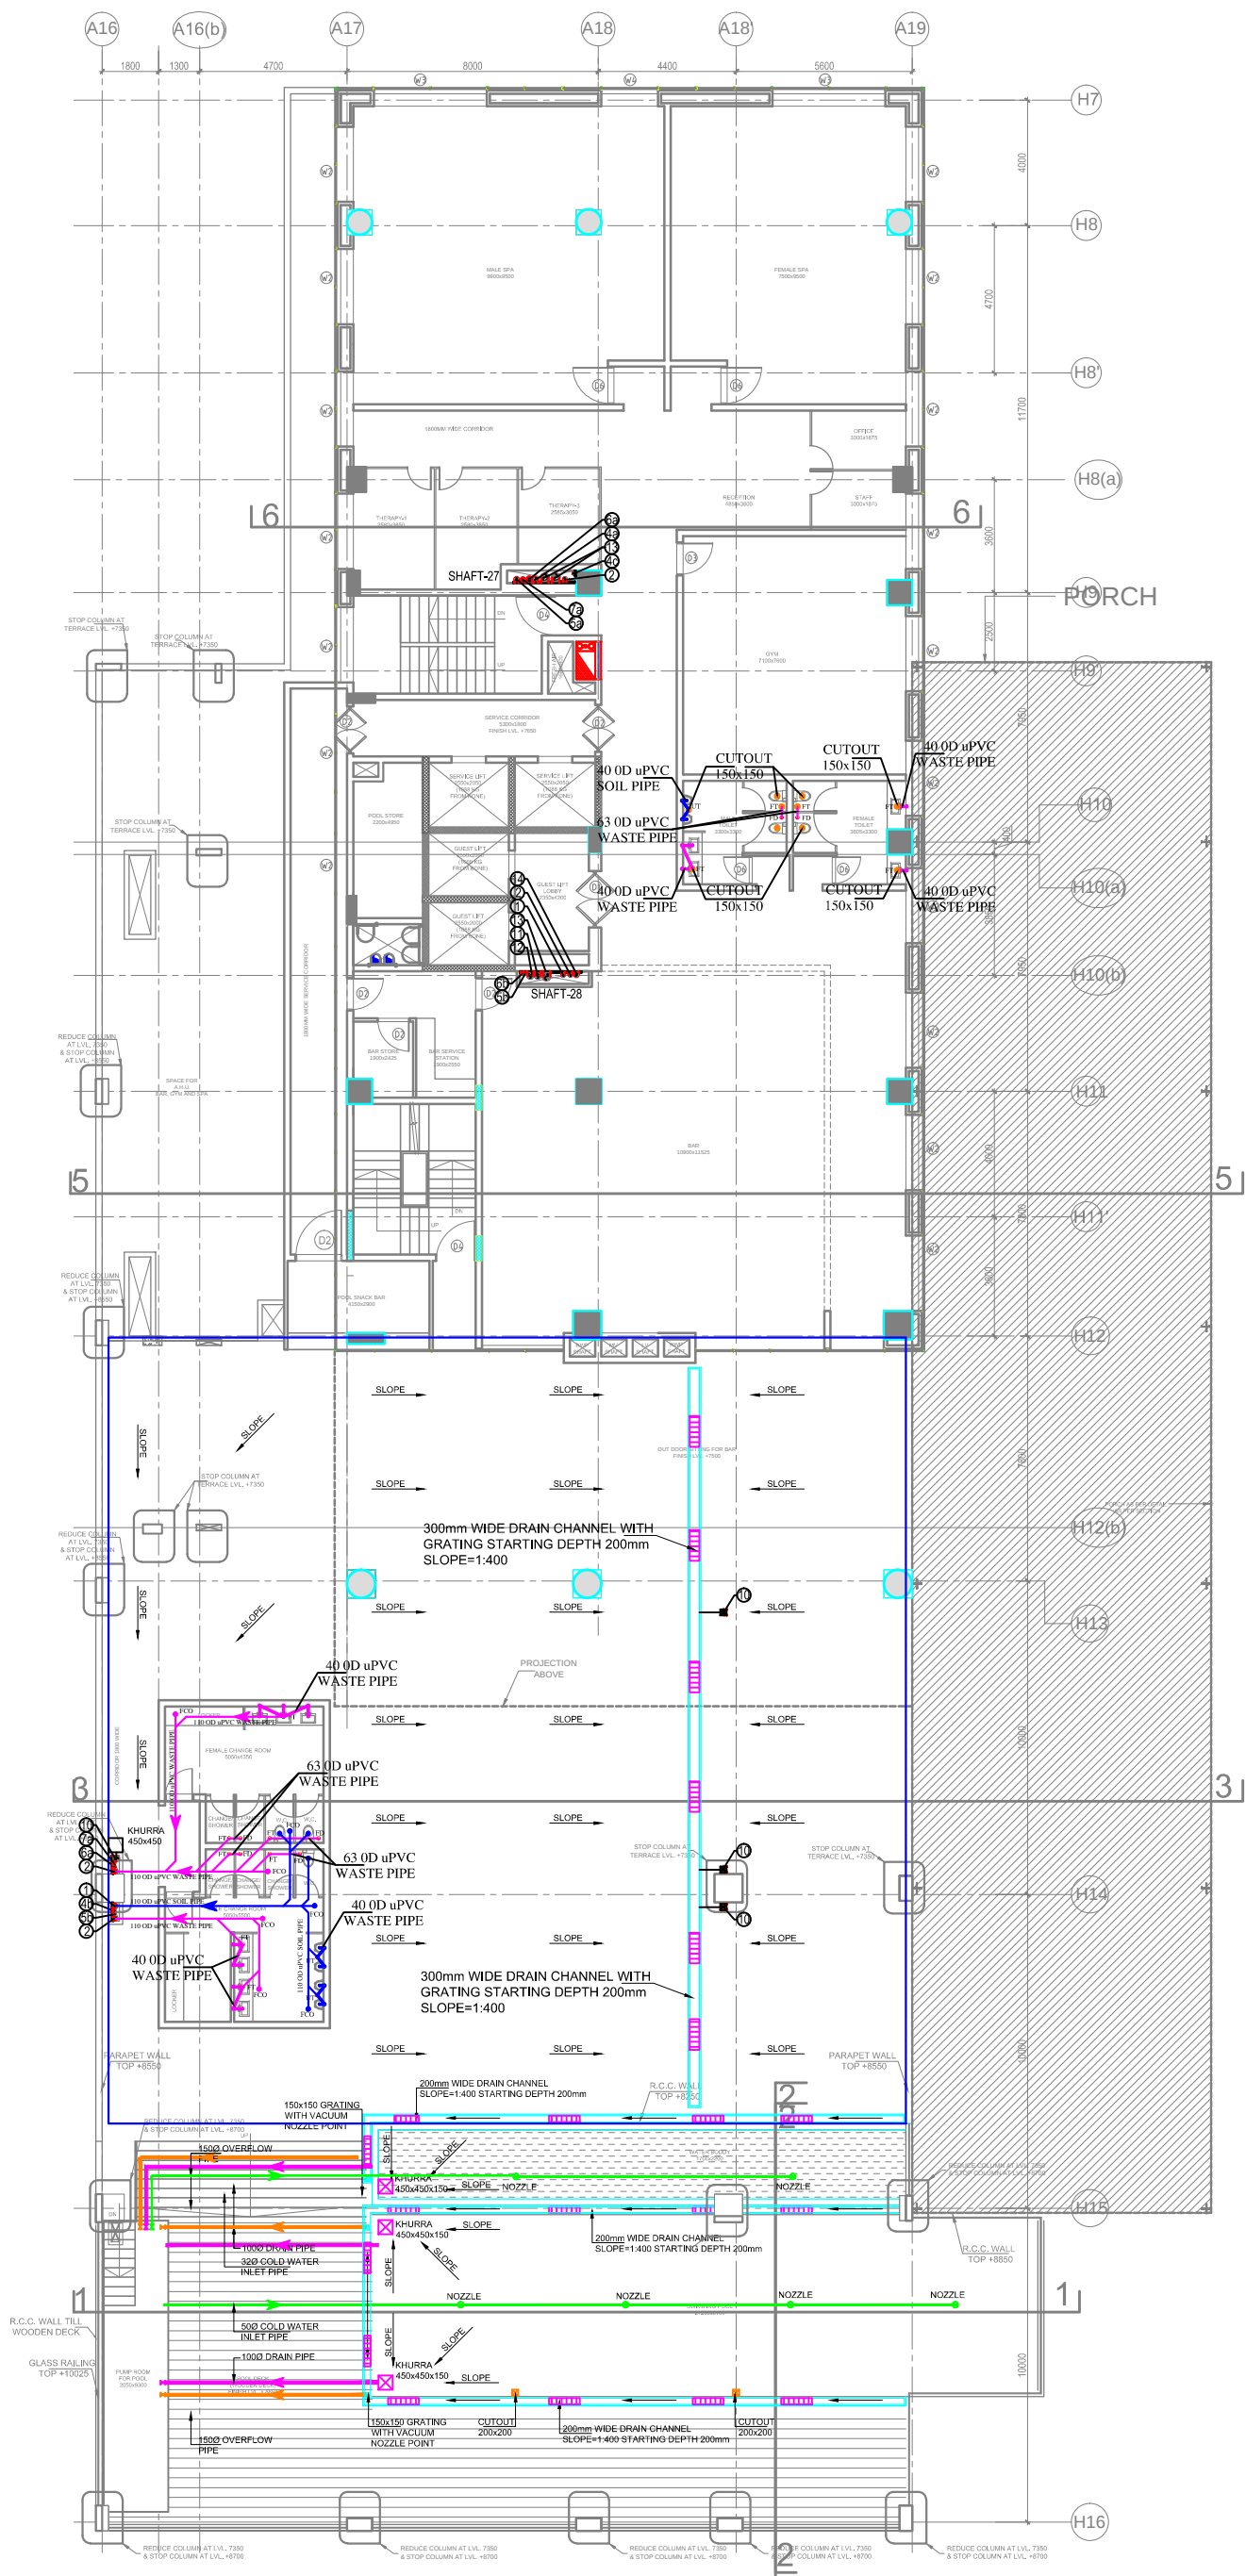

PLUMBING LEGEND	
1	110 (OD) uPVC SOIL VERTICAL & VENT PIPE
2	110 (OD) uPVC WASTE VERTICAL & VENT PIPE
2a	150Ø C.I. KITCHEN WASTE VERTICAL PIPE
3	75 (OD) uPVC ANTI-SYPHONAGE PIPE
4	COLD WATER SUPPLY PIPE FOR GUEST FLOOR (HYDRO-PNEUMATIC SYSTEM)
4a	COLD WATER SUPPLY PIPE FROM PUMP ROOM BASEMENT TO SERVICE FLOOR
4b	COLD WATER SUPPLY PIPE FOR SOLAR PANEL FROM O.H. TANK
4c	COLD WATER SUPPLY PIPE TO O.H. TANK
5	FLUSHING WATER SUPPLY PIPE FOR GUEST FLOOR FROM O.H. TANK
5a	FLUSHING WATER SUPPLY PIPE TO O.H. TANK
5b	FLUSHING WATER SUPPLY PIPE FOR TOILET FROM O.H. TANK
6	HOT WATER SUPPLY PIPE FROM BOILER FOR GUEST FLOOR
6a	HOT WATER SUPPLY PIPE FROM BOILER ROOM BASEMENT TO SERVICE FLOOR
6b	HOT WATER SUPPLY PIPE FROM SOLAR PANEL TO BOILER ROOM
7	HOT WATER RETURN PIPE TO BOILER FOR GUEST FLOOR
7a	HOT WATER RETURN PIPE TO BOILER ROOM SERVICE FLOOR TO BASEMENT
8	TOILET EXHAUST DUCT SIZE = 200 X 200MM
9	CHILLED WATER SUPPLY/ RETURN PIPE
10	160 OD uPVC RAIN WATER PIPE FROM TERRACE
11	150Ø C.I.A. SOIL VERTICAL & VENT PIPE
12	150Ø C.I.A. WASTE VERTICAL & VENT PIPE
13	200Ø C.I.A. RAIN WATER PIPE
14	SOFT WATER SUPPLY PIPE
15	R.O. WATER SUPPLY PIPE
FT	FLOOR TRAP 110X110mm (uPVC SWR 'P' TRAP) WITH S.S. GRATING
FD	FLOOR DRAIN (110X63mm) WITH S.S. GRATING
WB TO FT	40 (OD) uPVC PIPE
FD TO FT	63 (OD) uPVC PIPE
FT TO V. STACK	110 (OD) uPVC PIPE
WC TO V. STACK	110 (OD) uPVC PIPE
—	SOIL PIPE
—	WASTE PIPE
—	RAIN WATER PIPE

00	---	00/00/00
NO. OF PRINTS	ISSUED TO	DATE

S.N.	DATE	DETAILS
REVISIONS		

PROJECT
ORIZZONTE COMMERCIAL PROJECT
PLOT NO. 22 SECTOR II, KP-III
GREATER NOIDA

CLIENT

FACILITY PLANNER

STRUCTURAL CONSULTANT
Koncept Design Consortium PVT. LTD
STRUCTURAL ENGINEERS & PROJECT CONSULTANTS
Branch: 022 : PLOT NO. 2-150, SECTOR 17, GATEWAY-40, NOIDA

ARCHITECT
GENRE OF DESIGN
ARCHITECTURE, MASTER PLANNING
& INTERIOR DESIGN
A-57, BASEMENT FLOOR, SHIVAJI, MALVIYA NAGAR, NEW DELHI
TELEPHONE: 011-40574968

MEP CONSULTANTS
C TO C Services Consultants Pvt. Ltd.
F-67, - (Basement) Green Park Main,
New Delhi-110016 (INDIA)
Tel.: 41618888, 41618866
E-mail: ctocinfo@ctocconsultants.com

STAGE
TENDER DRAWING

DRAWING TITLE
**1st FLOOR PLAN_ HOTEL BLOCK
(PLUMBING CUTOUT)**

Drawn S.P	Checked S.R	Approved H.S
Scale 1:100 @ A1	Date 18.05.2015	Rev. No. R0

Drawing No.
CTOC.SEP1.1481.PL.04