


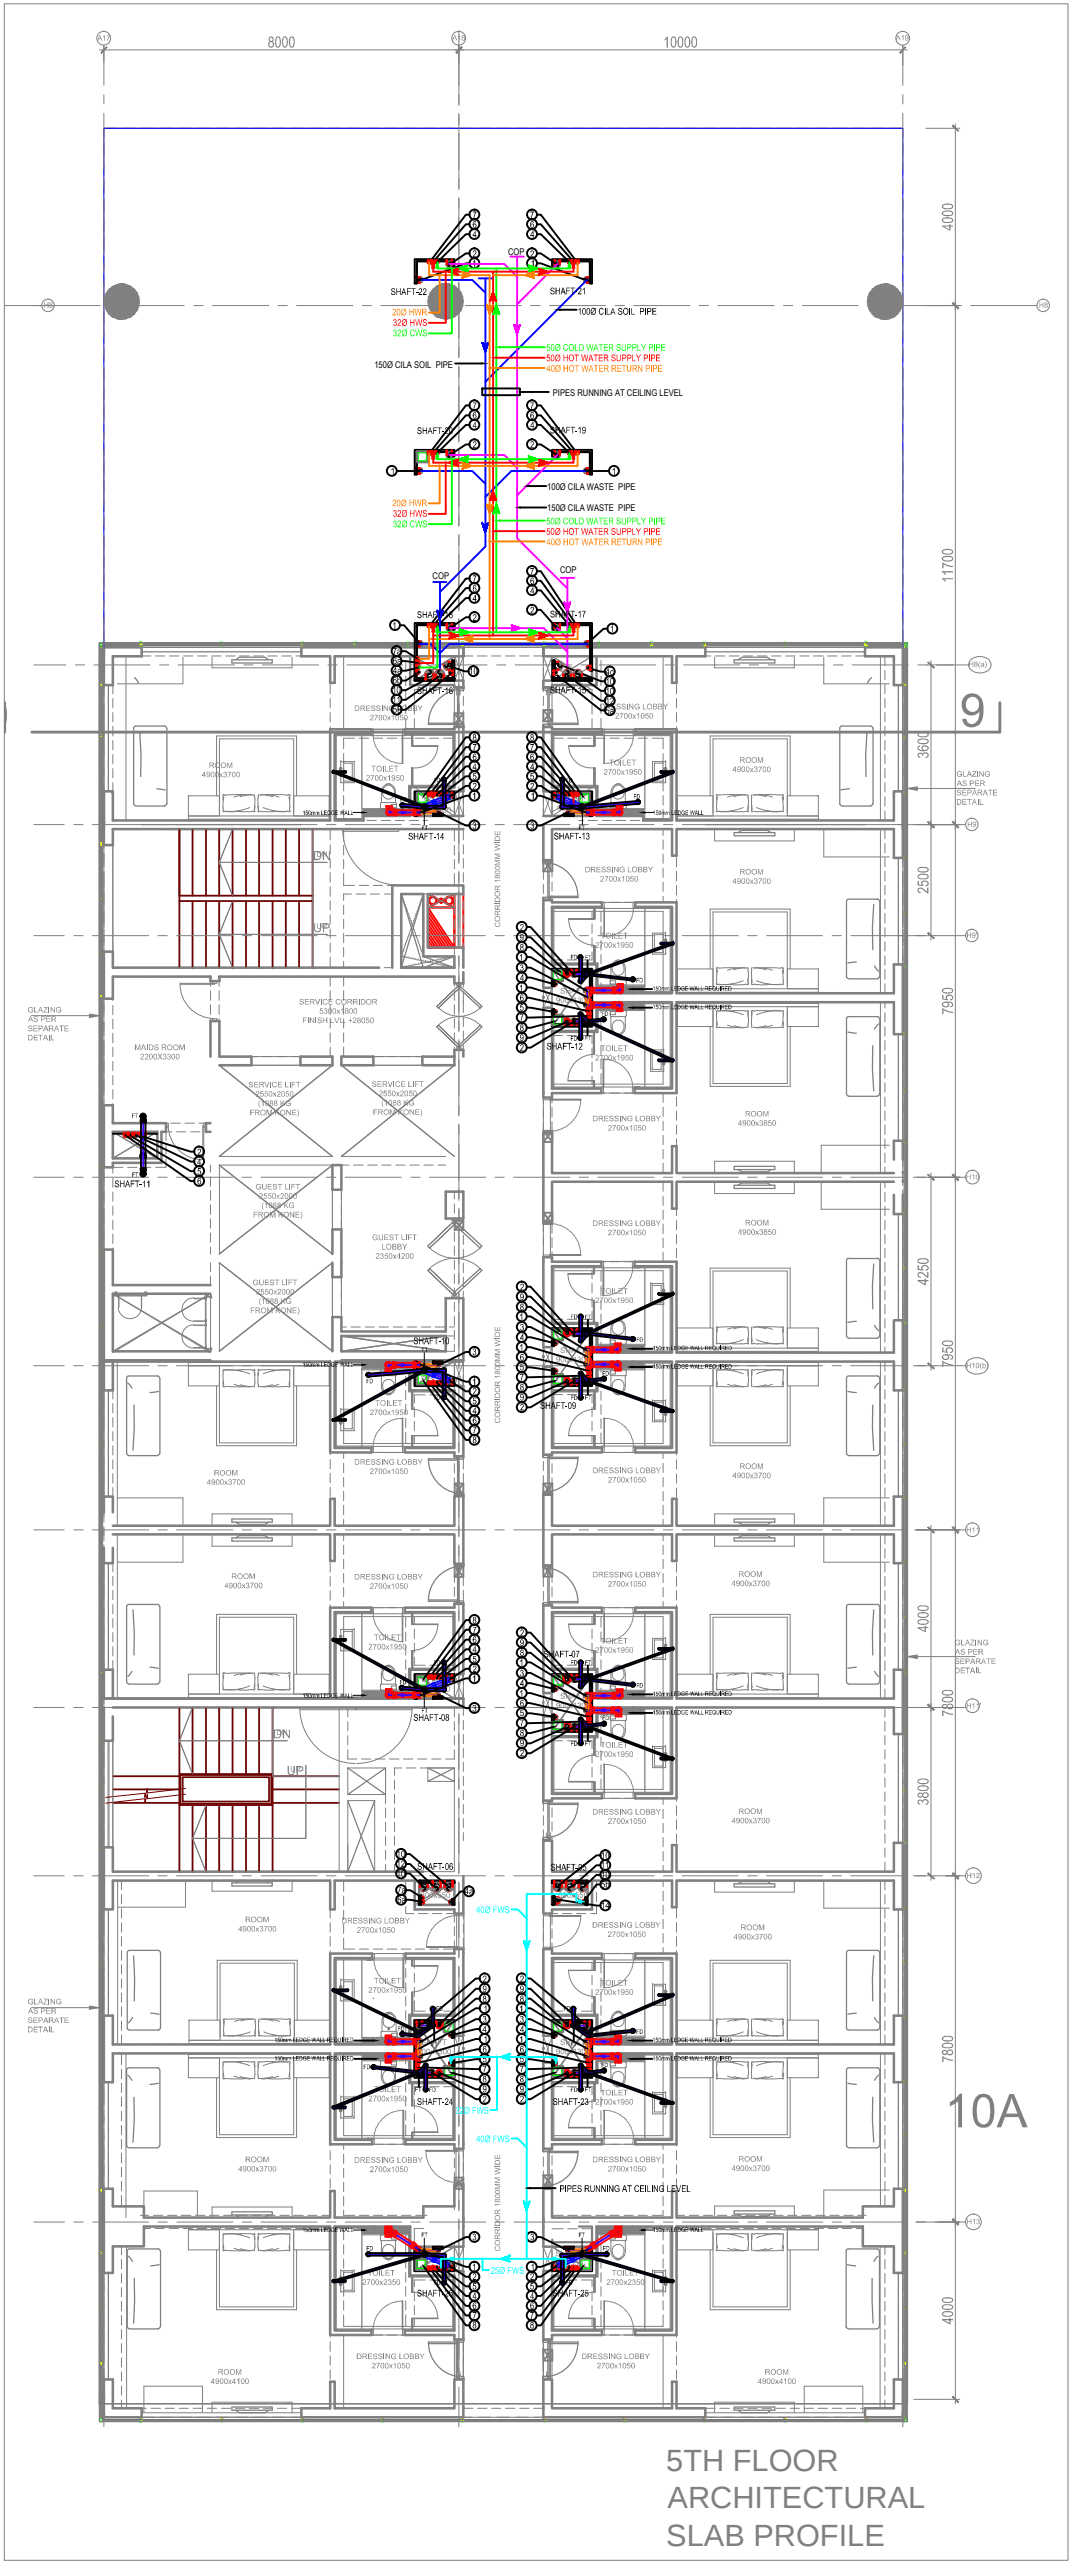

5TH FLOOR
ARCHITECTURAL
SLAB PROFILE

PLUMBING LEGEND	
①	110 (OD) uPVC SOIL VERTICAL & VENT PIPE
②	110 (OD) uPVC WASTE VERTICAL & VENT PIPE
③	75 (OD) uPVC ANTI-SYPHONAGE PIPE
④	COLD WATER SUPPLY PIPE FOR GUEST FLOOR (HYDROPUNNETIC SYSTEM)
④a	COLD WATER SUPPLY PIPE FROM PUMP ROOM BASEMENT TO GUEST FLOOR
④b	COLD WATER SUPPLY PIPE FOR SOLAR PANEL FROM O.H. TANK
④c	COLD WATER SUPPLY PIPE TO O.H. TANK
⑤	FLUSHING WATER SUPPLY PIPE FOR GUEST FLOOR FROM O.H. TANK
⑤a	FLUSHING WATER SUPPLY PIPE TO O.H. TANK
⑤b	FLUSHING WATER SUPPLY PIPE FOR TOILET FROM O.H. TANK
⑥	HOT WATER SUPPLY PIPE FROM BOILER FOR GUEST FLOOR
⑥a	HOT WATER SUPPLY PIPE FROM BOILER ROOM BASEMENT TO SERVICE FLOOR
⑥b	HOT WATER SUPPLY PIPE FROM SOLAR PANEL TO BOILER ROOM
⑦	HOT WATER RETURN PIPE TO BOILER FOR GUEST FLOOR
⑦a	HOT WATER RETURN PIPE TO BOILER ROOM SERVICE FLOOR TO BASEMENT
⑧	TOILET EXHAUST DUCT SIZE = 200 X 200MM
⑨	CHILLED WATER SUPPLY/RETURN PIPE
⑩	160 OD uPVC RAIN WATER PIPE FROM TERRACE
⑪	1500 CILA SOIL VERTICAL & VENT PIPE
⑫	1500 CILA WASTE VERTICAL & VENT PIPE
⑭	SOFT WATER SUPPLY PIPE
● FT	FLOOR TRAP 110X110mm (uPVC SWR 'P' TRAP) WITH S.S. GRATING
● FD	FLOOR DRAIN (110X63mm) WITH S.S. GRATING
WB TO FT	40 (OD) uPVC PIPE
FD TO FT	63 (OD) uPVC PIPE
FT TO V. STACK	110 (OD) uPVC PIPE
WC TO V. STACK	110 (OD) uPVC PIPE
—	COLD WATER SUPPLY PIPE
—	HOT WATER SUPPLY PIPE
—	HOT WATER RETURN PIPE
—	FLUSHING WATER SUPPLY PIPE
—	SOIL PIPE
—	WASTE PIPE

00	---	00/00/00
NO. OF PRINTS	ISSUED TO	DATE
S.N.	DATE	DETAILS
REVISIONS		
PROJECT		
ORIZZONTE COMMERCIAL PROJECT PLOT NO. 22 SECTOR IT, KP-III GREATER NOIDA		
CLIENT		
FACILITY PLANNER		
STRUCTURAL CONSULTANT		
 Konzept Design Consortium PVT. LTD STRUCTURAL ENGINEERS & PROJECT CONSULTANTS Branch: 002 : PLOT NO. 2-100, SECTOR 10, GATE NO. 10, NOIDA		
ARCHITECT		
GENRE OF DESIGN ARCHITECTURE, MASTER PLANNING & INTERIOR DESIGN A-57, BASEMENT FLOOR, SHIVAJI, MALVIYA NAGAR, NEW DELHI TELEPHONE: 011-40574968		
MEP CONSULTANTS		
 C TO C Services Consultants Pvt. Ltd. F-67, - (Basement) Green Park Main, New Delhi-110016 (INDIA) Tel.: 41618888, 41618866 E-mail: ctocinfo@ctocconsultants.com		
STAGE		
TENDER DRAWING		
DRAWING TITLE		
5th FLOOR PLAN_ HOTEL BLOCK (PLUMBING LAYOUT)		
Drawn S.P	Checked S.R	Approved H.S
Scale 1:75 @ A1	Date 18.05.2015	Rev. No. R0
Drawing No.		
CTOC.SEP.L.1481.PL.09		