

	VISITORS PARKING
	NORMAL PARKING

PLOT LINE

—S.T.P. BELOW

SETBACK LINE 12.00 MT

SETBACK LINE 14.00 MT

SETBACK LINE 12.00 MT

BASEMENT LINE

6.0 MT. WIDE FIRE
TENDER PATH

6.0 MT. WIDE FIRE TENDER PATH

6.0 MT. WIDE FIRE TENDER PATH

6.0 MT. WIDE FIRE
TENDER PATH

EXIT

ENTRY

U.G.TANK BELOW


— BASEMENT LINE AT 6.0 MT

— SETBACK LINE 12.00 MT

— SETBACK LINE 14.00 MT

SITE PLAN

LEGEND:-		
S.NO	DESCRIPTION	SYMBOL
1	RCC SHOWERAGE PIPING LINE	

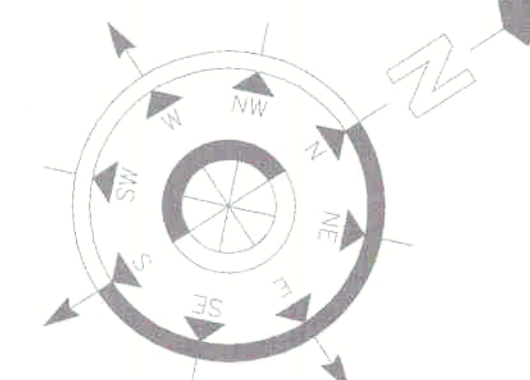

PROJECT :-

PROPOSED GROUP HOUSING
"WINDSOR - MAJESTY"

AT KHASRA NO. 527 MIN, NOOR NAGAR,
RAJ NAGAR EXTENSION, GHAZIABAD

BUILDERS & PROMOTERS :-

M/S WINDSOR PARADISE HEIGHTS PVT. LTD.

DRAWING TITLE :-
SEWERAGE LAYOUT PLAN



ARCHITECTS :
Space Designers International
B-34, Sector-67, NOIDA-201301
PH :91-9711633717,18
e-mail : info@spacedi.com, www.spacedi.com

CHECKED BY :- VISHAL	SCALE :- 1:210@A1	DATE :- 03/02/2025
--------------------------------	-----------------------------	------------------------------

OWNER'S SIGNATURE	ARCHITECT'S SIGNATURE
	DRG. No. :-PL-02

MEP CONSULTANT:



PKV Consulting Engineers (P) Ltd.
C-815, DDA Flats, Loni Road, Delhi -110093
TELEFAX - 011-22816297
E-mail:- pramod@pkv.co.in
info@pkv.co.in

	VISITORS PARKING
	NORMAL PARKING

[illegible]

PLAN OF 12" DIA. TING CHAMBER WITH 12" DIA. WELL

DETAIL - A

DETAIL - B


DETAIL - C

LEGEND

1. 12" DIA. INLET PIPE
2. 12" DIA. OUTLET PIPE (12" DIA. INLET PIPE)
3. 12" DIA. TING CHAMBER
4. 12" DIA. WELL
5. 12" DIA. INLET PIPE
6. 12" DIA. OUTLET PIPE
7. 12" DIA. TING CHAMBER
8. 12" DIA. WELL
9. 12" DIA. INLET PIPE
10. 12" DIA. OUTLET PIPE
11. 12" DIA. TING CHAMBER
12. 12" DIA. WELL
13. 12" DIA. INLET PIPE
14. 12" DIA. OUTLET PIPE
15. 12" DIA. TING CHAMBER
16. 12" DIA. WELL
17. 12" DIA. INLET PIPE
18. 12" DIA. OUTLET PIPE
19. 12" DIA. TING CHAMBER
20. 12" DIA. WELL
21. 12" DIA. INLET PIPE
22. 12" DIA. OUTLET PIPE
23. 12" DIA. TING CHAMBER
24. 12" DIA. WELL
25. 12" DIA. INLET PIPE
26. 12" DIA. OUTLET PIPE
27. 12" DIA. TING CHAMBER
28. 12" DIA. WELL
29. 12" DIA. INLET PIPE
30. 12" DIA. OUTLET PIPE
31. 12" DIA. TING CHAMBER
32. 12" DIA. WELL
33. 12" DIA. INLET PIPE
34. 12" DIA. OUTLET PIPE
35. 12" DIA. TING CHAMBER
36. 12" DIA. WELL
37. 12" DIA. INLET PIPE
38. 12" DIA. OUTLET PIPE
39. 12" DIA. TING CHAMBER
40. 12" DIA. WELL
41. 12" DIA. INLET PIPE
42. 12" DIA. OUTLET PIPE
43. 12" DIA. TING CHAMBER
44. 12" DIA. WELL
45. 12" DIA. INLET PIPE
46. 12" DIA. OUTLET PIPE
47. 12" DIA. TING CHAMBER
48. 12" DIA. WELL
49. 12" DIA. INLET PIPE
50. 12" DIA. OUTLET PIPE
51. 12" DIA. TING CHAMBER
52. 12" DIA. WELL
53. 12" DIA. INLET PIPE
54. 12" DIA. OUTLET PIPE
55. 12" DIA. TING CHAMBER
56. 12" DIA. WELL
57. 12" DIA. INLET PIPE
58. 12" DIA. OUTLET PIPE
59. 12" DIA. TING CHAMBER
60. 12" DIA. WELL
61. 12" DIA. INLET PIPE
62. 12" DIA. OUTLET PIPE
63. 12" DIA. TING CHAMBER
64. 12" DIA. WELL
65. 12" DIA. INLET PIPE
66. 12" DIA. OUTLET PIPE
67. 12" DIA. TING CHAMBER
68. 12" DIA. WELL
69. 12" DIA. INLET PIPE
70. 12" DIA. OUTLET PIPE
71. 12" DIA. TING CHAMBER
72. 12" DIA. WELL
73. 12" DIA. INLET PIPE
74. 12" DIA. OUTLET PIPE
75. 12" DIA. TING CHAMBER
76. 12" DIA. WELL
77. 12" DIA. INLET PIPE
78. 12" DIA. OUTLET PIPE
79. 12" DIA. TING CHAMBER
80. 12" DIA. WELL
81. 12" DIA. INLET PIPE
82. 12" DIA. OUTLET PIPE
83. 12" DIA. TING CHAMBER
84. 12" DIA. WELL
85. 12" DIA. INLET PIPE
86. 12" DIA. OUTLET PIPE
87. 12" DIA. TING CHAMBER
88. 12" DIA. WELL
89. 12" DIA. INLET PIPE
90. 12" DIA. OUTLET PIPE
91. 12" DIA. TING CHAMBER
92. 12" DIA. WELL
93. 12" DIA. INLET PIPE
94. 12" DIA. OUTLET PIPE
95. 12" DIA. TING CHAMBER
96. 12" DIA. WELL
97. 12" DIA. INLET PIPE
98. 12" DIA. OUTLET PIPE
99. 12" DIA. TING CHAMBER
100. 12" DIA. WELL

LEGEND:-		
S.NO	DESCRIPTION	SYMBOL
1.	DRAINAGE CHAMBER (CIRCULAR)	
2.	RCC DRAINAGE PIPE LINE	
3.	RECHARGE WELL WITH DE-SULTING CHAMBER	

Type of Manhole	Size(mm)	Shape	Depth
A	900 DIA	CIRCULAR	900 TO 1650
B	1200 DIA	CIRCULAR	1651 TO 2300
C	1500 DIA	CIRCULAR	2301 TO 9000

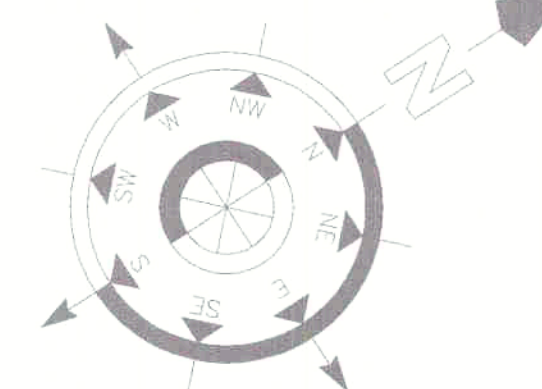

PROJECT :-
PROPOSED GROUP HOUSING
"WINDSOR - MAJESTY"
 AT KHASRA NO. 527 MIN, NOOR NAGAR,
 RAJ NAGAR EXTENSION, GHAZIABAD

BUILDERS & PROMOTERS :-

M/S WINDSOR PARADISE HEIGHTS PVT. LTD.

DRAWING TITLE :-

EXTERNAL DRAINAGE LAYOUT PLAN



ARCHITECTS :
Space Designers International
B-34, Sector-67, NOIDA-201301
PH :91-9711633717,18
e-mail : info@spacedi.com, www.spacedi.com

CHECKED BY :- ASHISH	SCALE :- 1:210@A1	DATE :- 03/02/2025
--------------------------------	-----------------------------	------------------------------


OWNER'S SIGNATURE	ARCHITECT'S SIGNATURE
	DRG. No. :-PL-03

MEP CONSULTANT:




PKV Consulting Engineers (P) Ltd.
C-815, DDA Flats, Loni Road, Delhi -110093
TELEFAX - 011-22816297
E-mail:- pramod@pkv.co.in
info@pkv.co.in

 LEGEND:

	VISITORS PARKING
	NORMAL PARKING

TOWER-1 2B+G+15 FLOOR

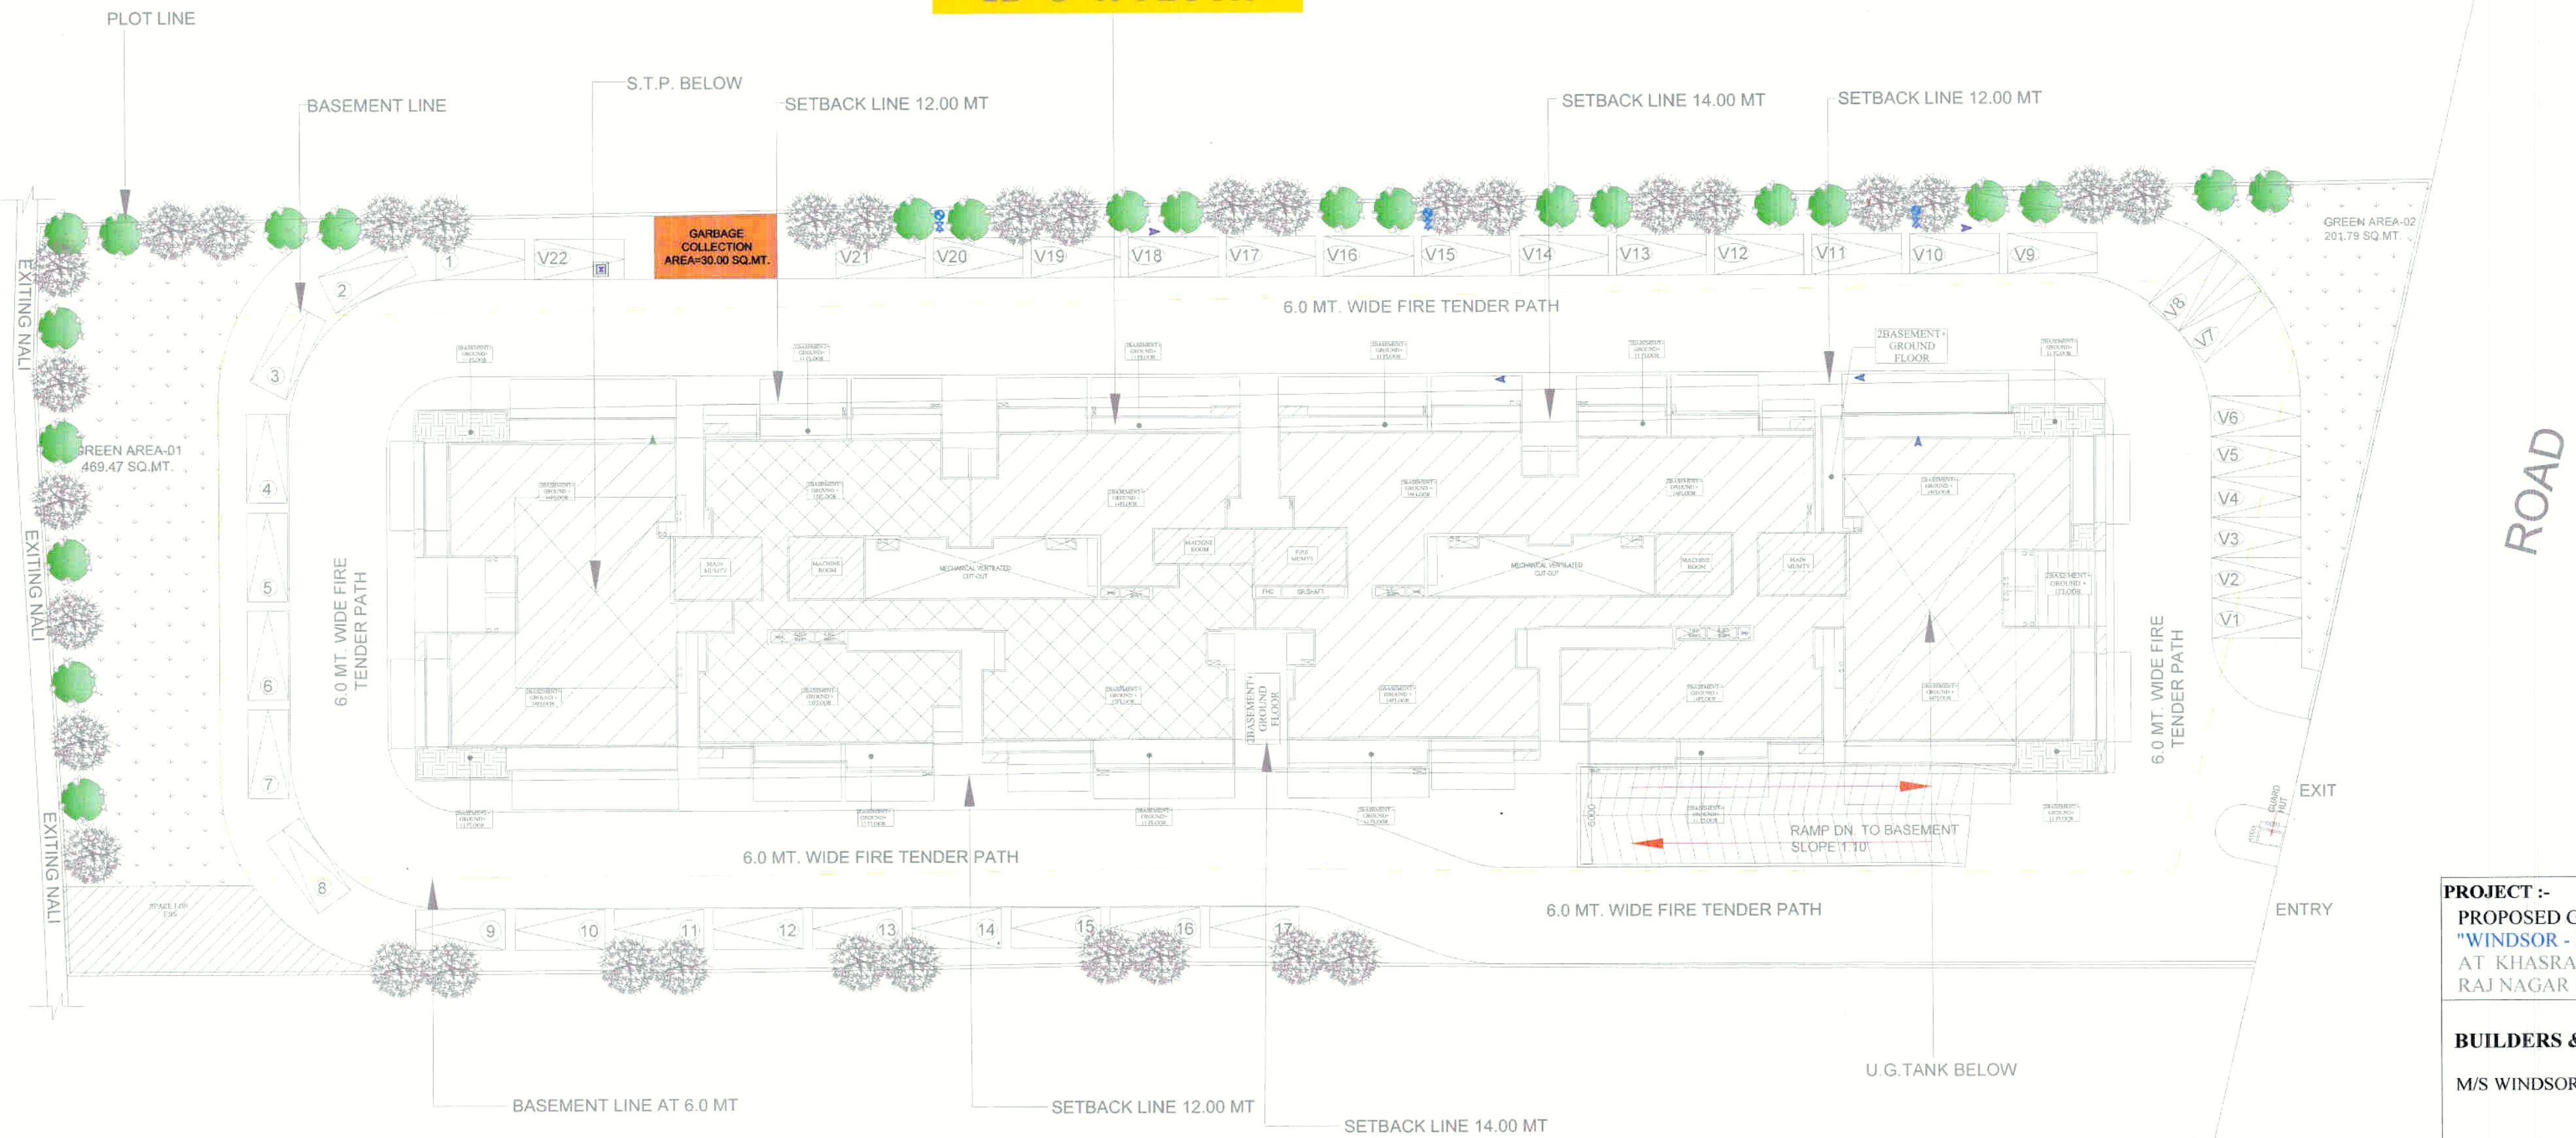

SITE PLAN

PROJECT :-
PROPOSED GROUP HOUSING
"WINDSOR - MAJESTY"
 AT KHASRA NO. 527 MIN, NOOR NAGAR,
 RAJ NAGAR EXTENSION, GHAZIABAD

BUILDERS & PROMOTERS :-
 M/S WINDSOR PARADISE HEIGHTS PVT. LTD.

DRAWING TITLE :-
 GARBAGE COLLECTION PLAN

ARCHITECTS :-
 Space Designers International
 B-34, Sector-67, NOIDA-201301
 PH: 91-8711633717, 18
 e-mail: info@spacedi.com, www.spacedi.com

CHECKED BY :- ASHISH
SCALE :- 1:210@A1
DATE :- 03/02/2025



ARCHITECT'S SIGNATURE
OWNER'S SIGNATURE DRG. No.: PL-06

MEP CONSULTANT:
PKV Consulting Engineers (P) Ltd.
 C-815, DDA Flats, Loni Road, Delhi - 110093
 TELEFAX - 011-22816297
 E-mail: pramod@pkv.co.in
 info@pkv.co.in

LEGEND:

	VISITORS PARKING
	NORMAL PARKING

TOWER-1 2B+G+15 FLOOR

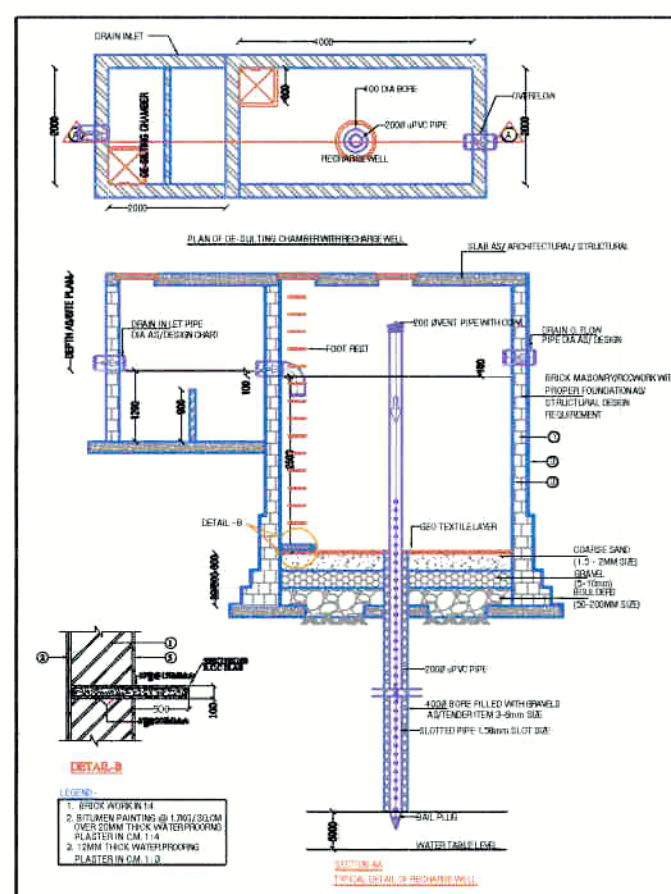
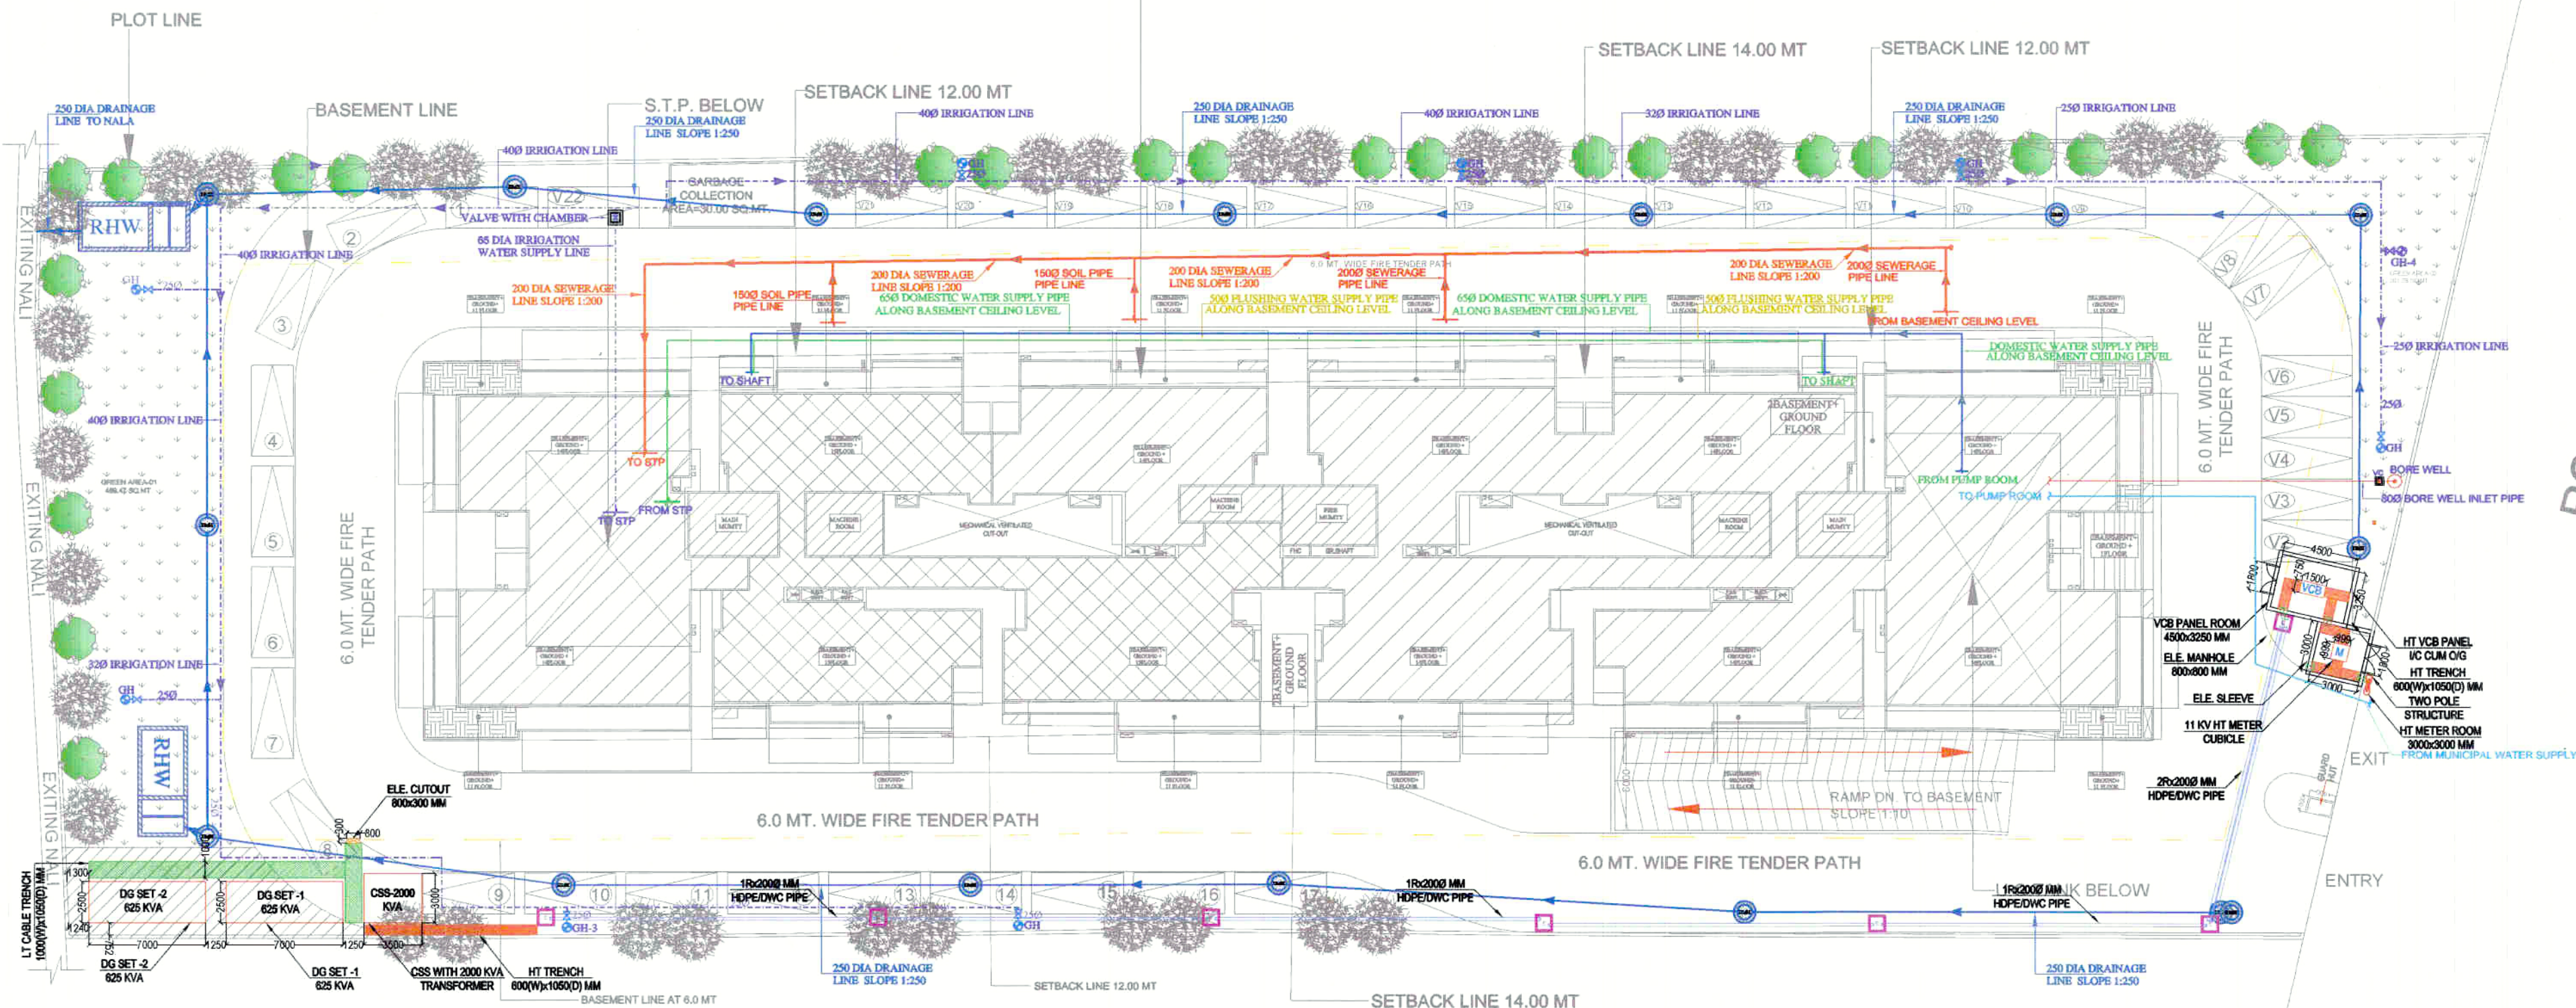


LEGENTS:-	DISCRIPTION
	HT CABLE TRENCH
	HT CABLE
	LT CABLE TRENCH
	CABLE TRAY
	HUME / HDPE PIPE
	ELE. MANHOLE
	LADDER TYPE CABLE TRAY
	PANEL / FEEDER PILLAR
	PERFORATED TYPE CABLE TRAY

SITE PLAN

Type of Manhole	Size(mm)	Shape	Depth
A	900 DIA	CIRCULAR	900 TO 1600
B	1200 DIA	CIRCULAR	1601 TO 2300
C	1500 DIA	CIRCULAR	2301 TO 3000

S.NO	DESCRIPTION	SYMBOL
1.	SEWERAGE MANHOLE	
2.	DRAINAGE CHAMBER (CIRCULAR)	
3.	RCC SEWERAGE PIPE LINE	
4.	RCC DRAINAGE PIPE LINE	
5.	DOMESTIC WATER SUPPLY RISER LINE	
6.	FLUSHING WATER SUPPLY RISER LINE	
7.	MUNICIPAL WATER SUPPLY LINE	
8.	BORE WELL WATER SUPPLY LINE	
9.	IRRIGATION WATER SUPPLY LINE	
10.	RECHARGE WELL WITH DE-SULTING CHAMBER	
11.	GARDEN HYDRANT	

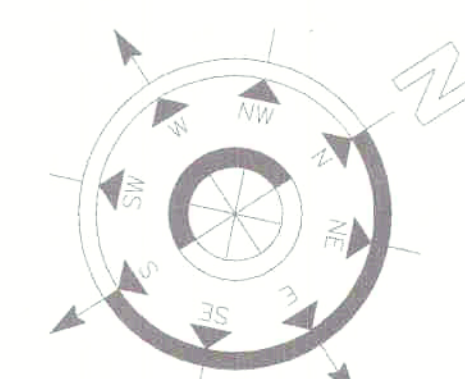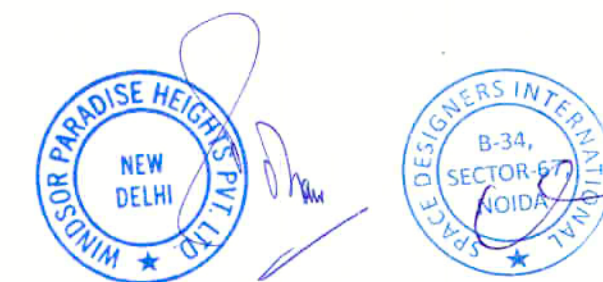

PROJECT :-
PROPOSED GROUP HOUSING
"WINDSOR - MAJESTY"
 AT KHASRA NO. 527 MIN, NOOR NAGAR,
 RAJ NAGAR EXTENSION, GHAZIABAD
BUILDERS & PROMOTERS :-
 M/S WINDSOR PARADISE HEIGHTS PVT. LTD.

DRAWING TITLE :-
EXTERNAL PLUMBING
SUBMISSION LAYOUT

ARCHITECTS :- Space Designers International B-34, Sector-67, NOIDA-201301 PH: 91-9711633717, 18 e-mail: info@spacedsi.com, www.spacedsi.com	CHECKED BY :- KAMAL	SCALE :- 1:210	DATE :- 03.02.2025
OWNER'S SIGNATURE	ARCHITECT'S SIGNATURE		
DRG. No.: -PL-01			

MEP CONSULTANT:
PKV Consulting Engineers (P) Ltd.
 C-815, DDA Flats, Loni Road, Delhi -110093
 TELEFAX - 011-22816297
 E-mail: pramod@pkv.co.in
 info@pkv.co.in