
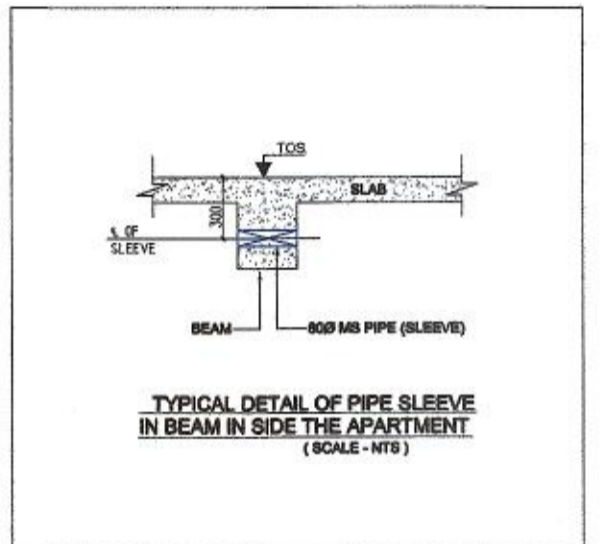


FIRE LEGEND:- AS PER NBC OF INDIA-2016	
C	150Ø SPRINKLER RISER FOR HIGH ZONE (23TH TO 27TH FLOOR)
C1	150Ø SPRINKLER RISER FOR LOW ZONE (BASEMENT TO 22TH FLOOR)
A	100Ø HYDRANT RISER FOR LOW ZONE (BASEMENT TO 22TH FLOOR)
A1	100Ø HYDRANT RISER FOR HIGH ZONE (23TH TO 27TH FLOOR)
B	80Ø M.S. DRAIN PIPE
FHC	FIRE HOSE CABINET

SYMBOL:-	
	PENDENT SPRINKLER
	UPRIGHT SPRINKLER
	SIDE WALL SPRINKLER
	EXTENDED THROW SIDE WALL SPRINKLER
	FLOW SWITCH
	4.5kg CO ₂ GAS TYPE FIRE EXTINGUISHER
	9 Ltr. WATER TYPE FIRE EXTINGUISHER
	FLOOR DRAIN
	FIRE DOOR
	M.S. SLEEVE FOR SPRINKLER PIPES
A	UP TO 50Ø PIPE = 80Ø SLEEVE
B	65Ø TO 100Ø PIPE = 150Ø SLEEVE

	6.0 METER HEIGHT POLE WITH 60W LED LIGHT
	40W POST TOP LANTERN
	HT U/G CABLE
	HUME PIPE
	MAN HOLE-900X900X900MM
	CABLE TRENCH
	BODY EARTHPIT FOR G.I. EARTHING
	NEUTRAL EARTHPIT FOR C.U. EARTHING
	EXTERNAL LIGHTING FEEDER PILLAR

PLUMBING LEGEND:-	
	STORM LINE
	SEWER LINE
	GARDEN HYDRANT LINE
GL	GROUND LEVEL
IL	INVERT LEVEL
CL	CONNECTION LEVEL
RWH	RAIN WATER HARVESTING PIT
	GARDEN HYDRANT
	VALVE
	DRAINAGE MANHOLE
	SEWER MANHOLE
	CATCH BASIN

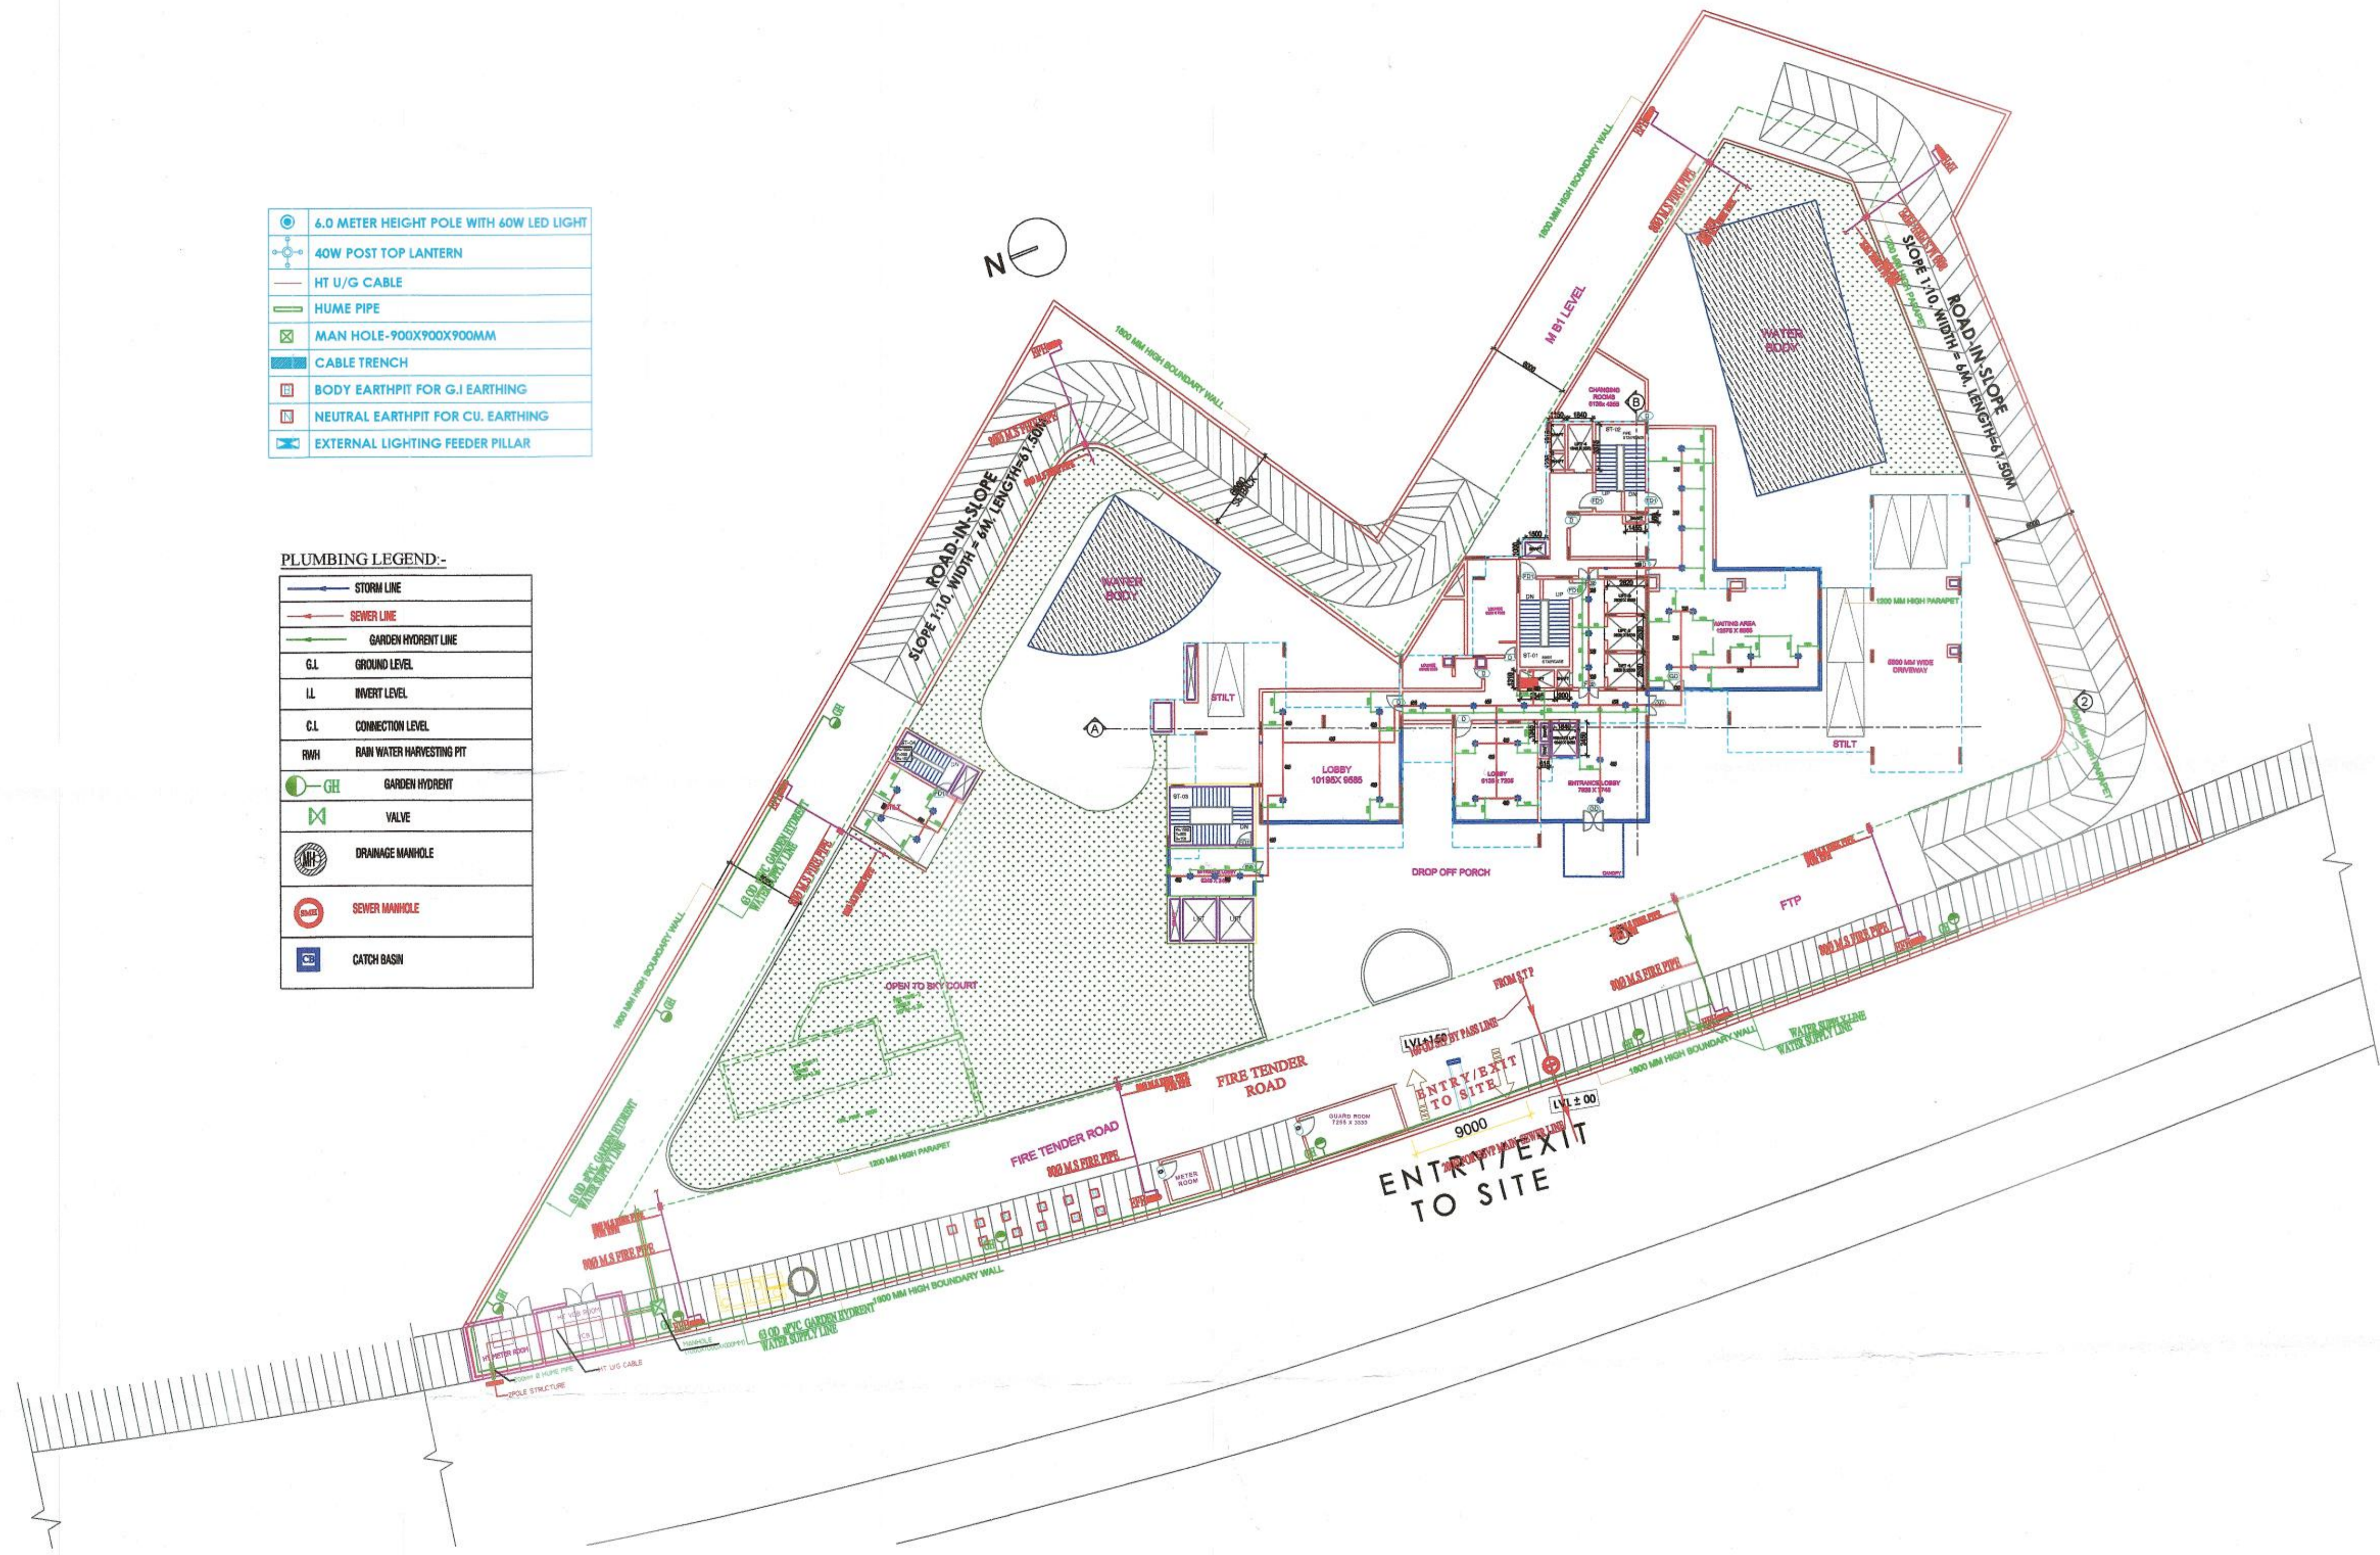

KEY PLAN

SUBMISSION		
PROJECT: KINGS LANDING WISH TOWN, SECTOR -128, NOIDA FOR JAYPEE INFRA TECH LTD		
DRAWING TITLE: GROUND FLOOR PLAN, WATER SUPPLY DRAWING		
For Goodliving Infrastructure Pvt. Ltd. Auth. Sign. / Director	 ROHIT SAINI CA/2020/121021	
OWNER'S SIGN	ARCHITECT'S SIGN	
SCALE 1:100	DEALT BY	DATE 08.06.2020
DESIGN BY	CHECKED BY	DRG. No. A-02