


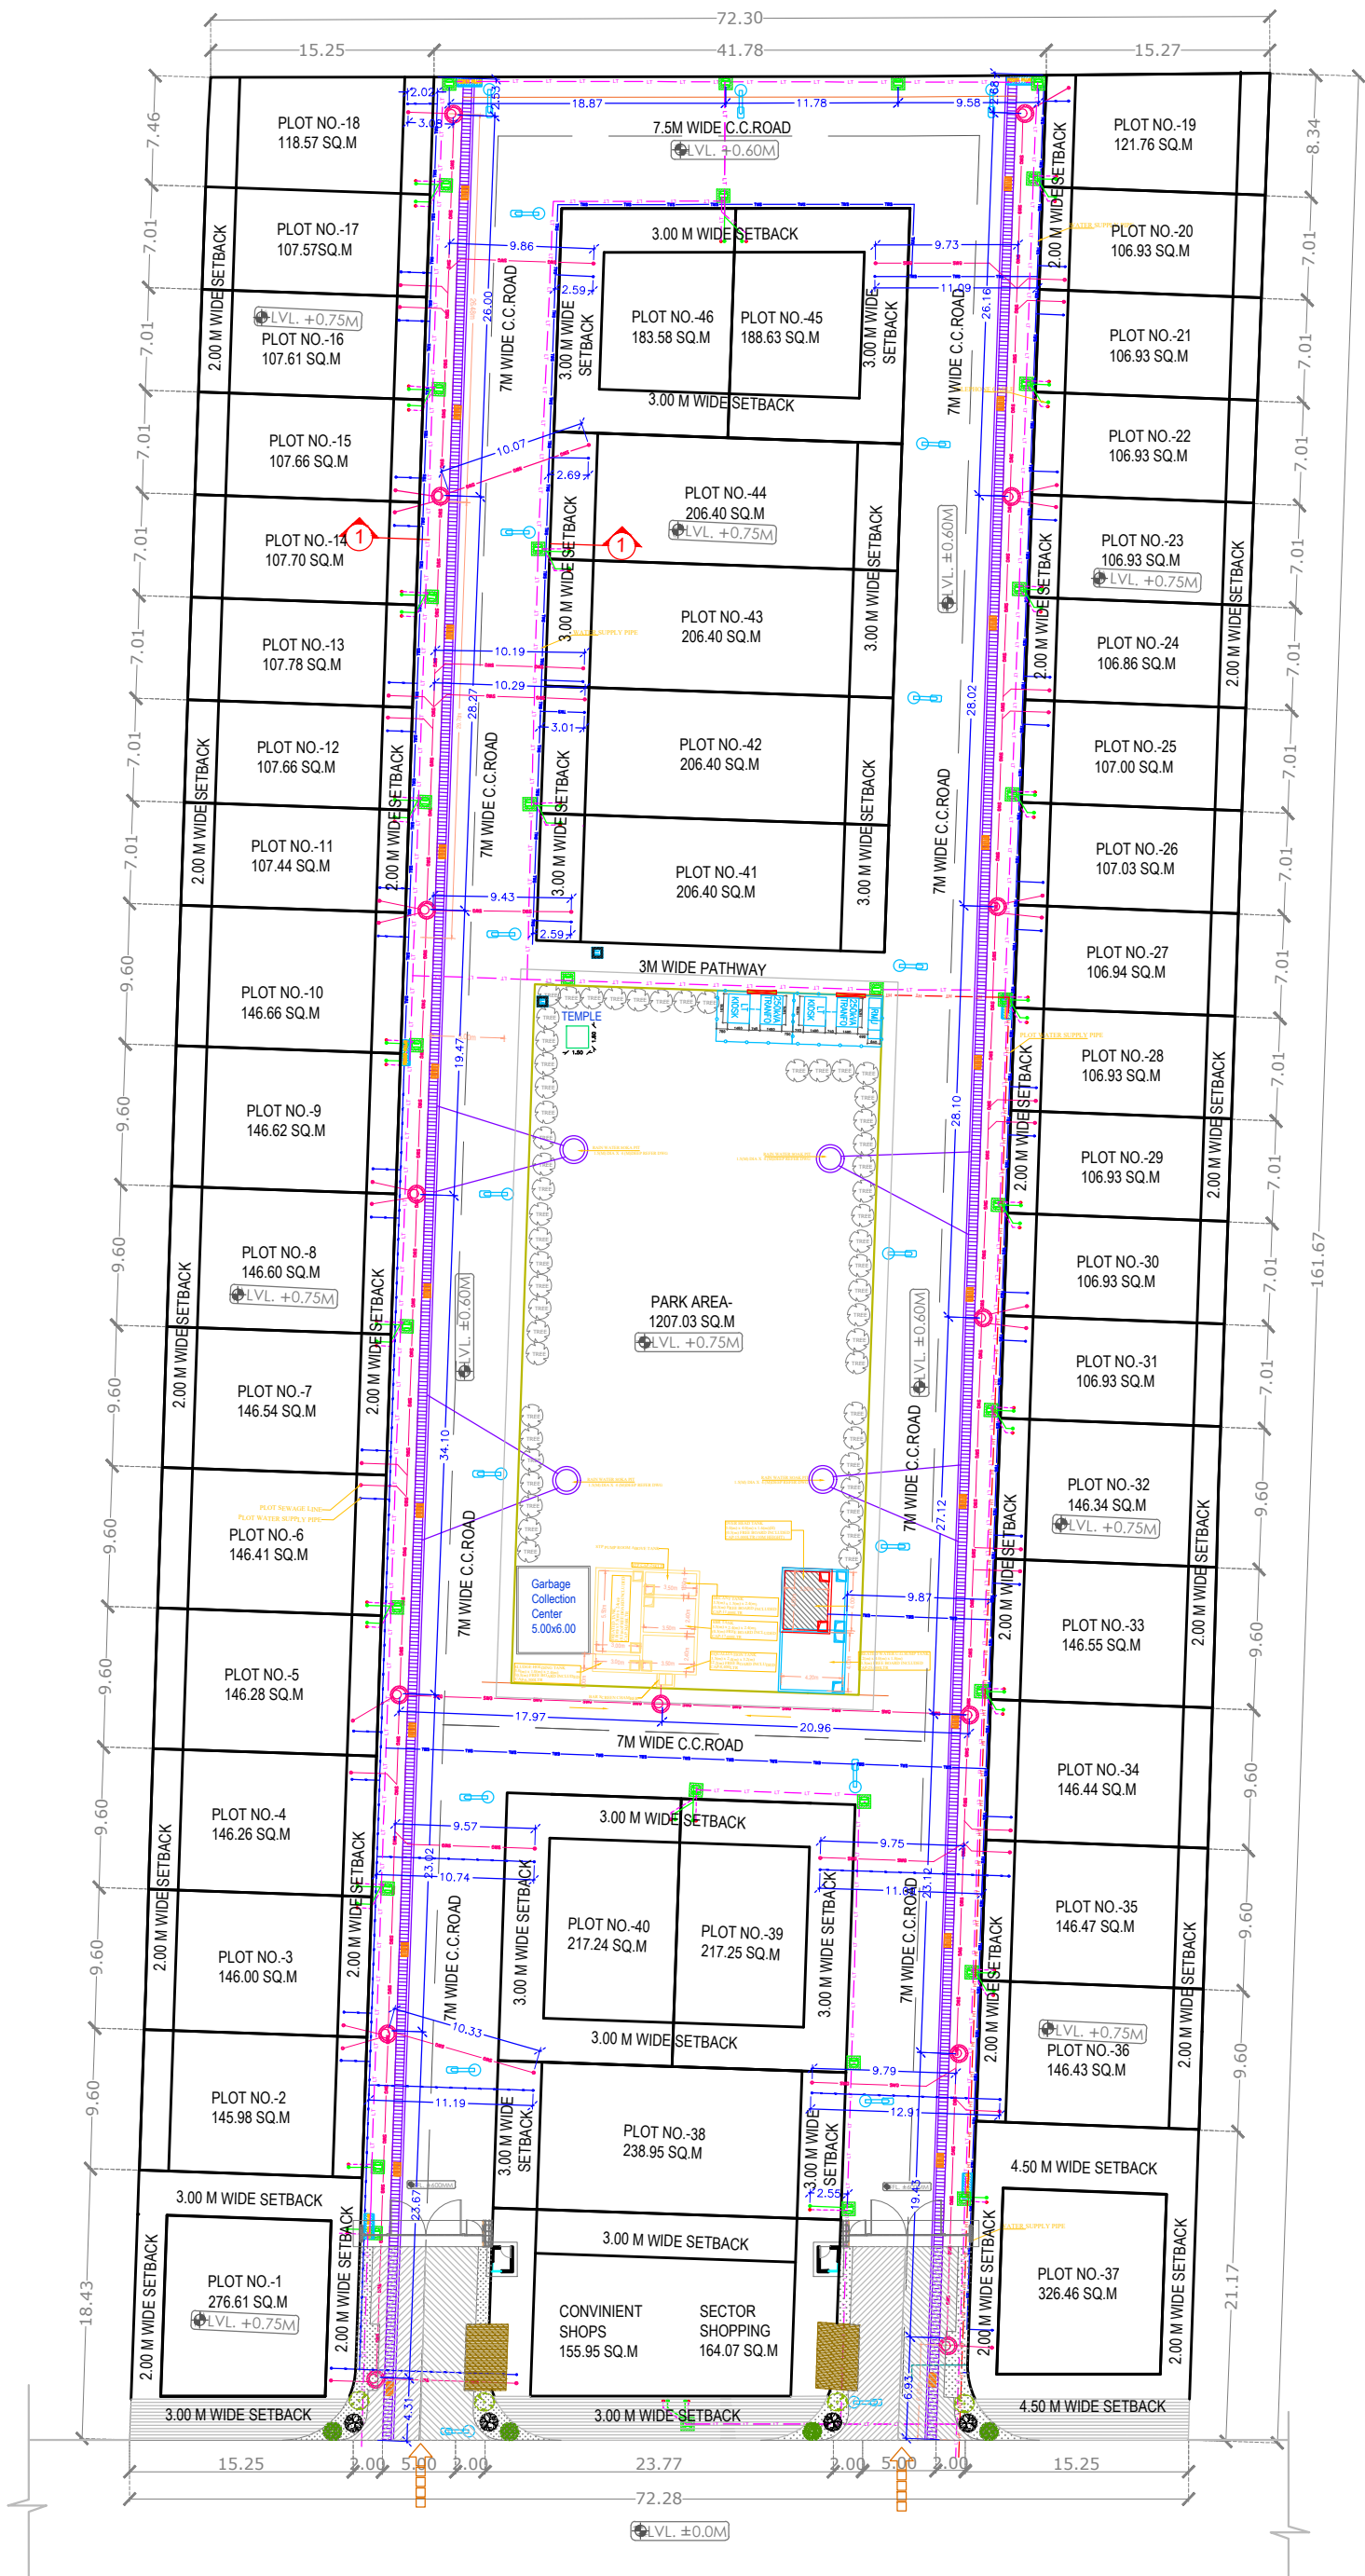

LEGEND		
1.	IL	INVERT LEVEL
2.	GL	GROUND LEVEL
3.		450 X 450MM VALVE CHAMBER
4.	HT HT	HIGH TENSION WIRE
5.	LT LT	LOW TENSION WIRE
6.		TELEPHONE CABLE
7.	SWG	1500 ECODRAIN PIPE
8.	TWS	TREATED WATER SUPPLY PIPE LINE
9.		12000 DIA MANHOLE CHAMBER
10.		600X700MM ELECTRIC CHAMBER
11.		RAIN-WATER SOAK PIT
12.		STREET LIGHT
13.		RAIN WATER DRAIN

ARCHITECTURE CONSULTANT		PROJECT TITLE		CLIENT NAME	DWG. REFERENCE	DRAWING NUMBER	REV
Drawn By		GROUP HOUSING		MR.	SS-103	11	ORIENTATION
Checked By				DRAWING TITLE			
Drawing Status				SITE PLAN-CO-ORDINATED LAYOUT			
				DATE	SCALE	UNIT	STATUS
				26.07.2021	1:100	MILLIMETERS	IN PROCESS