



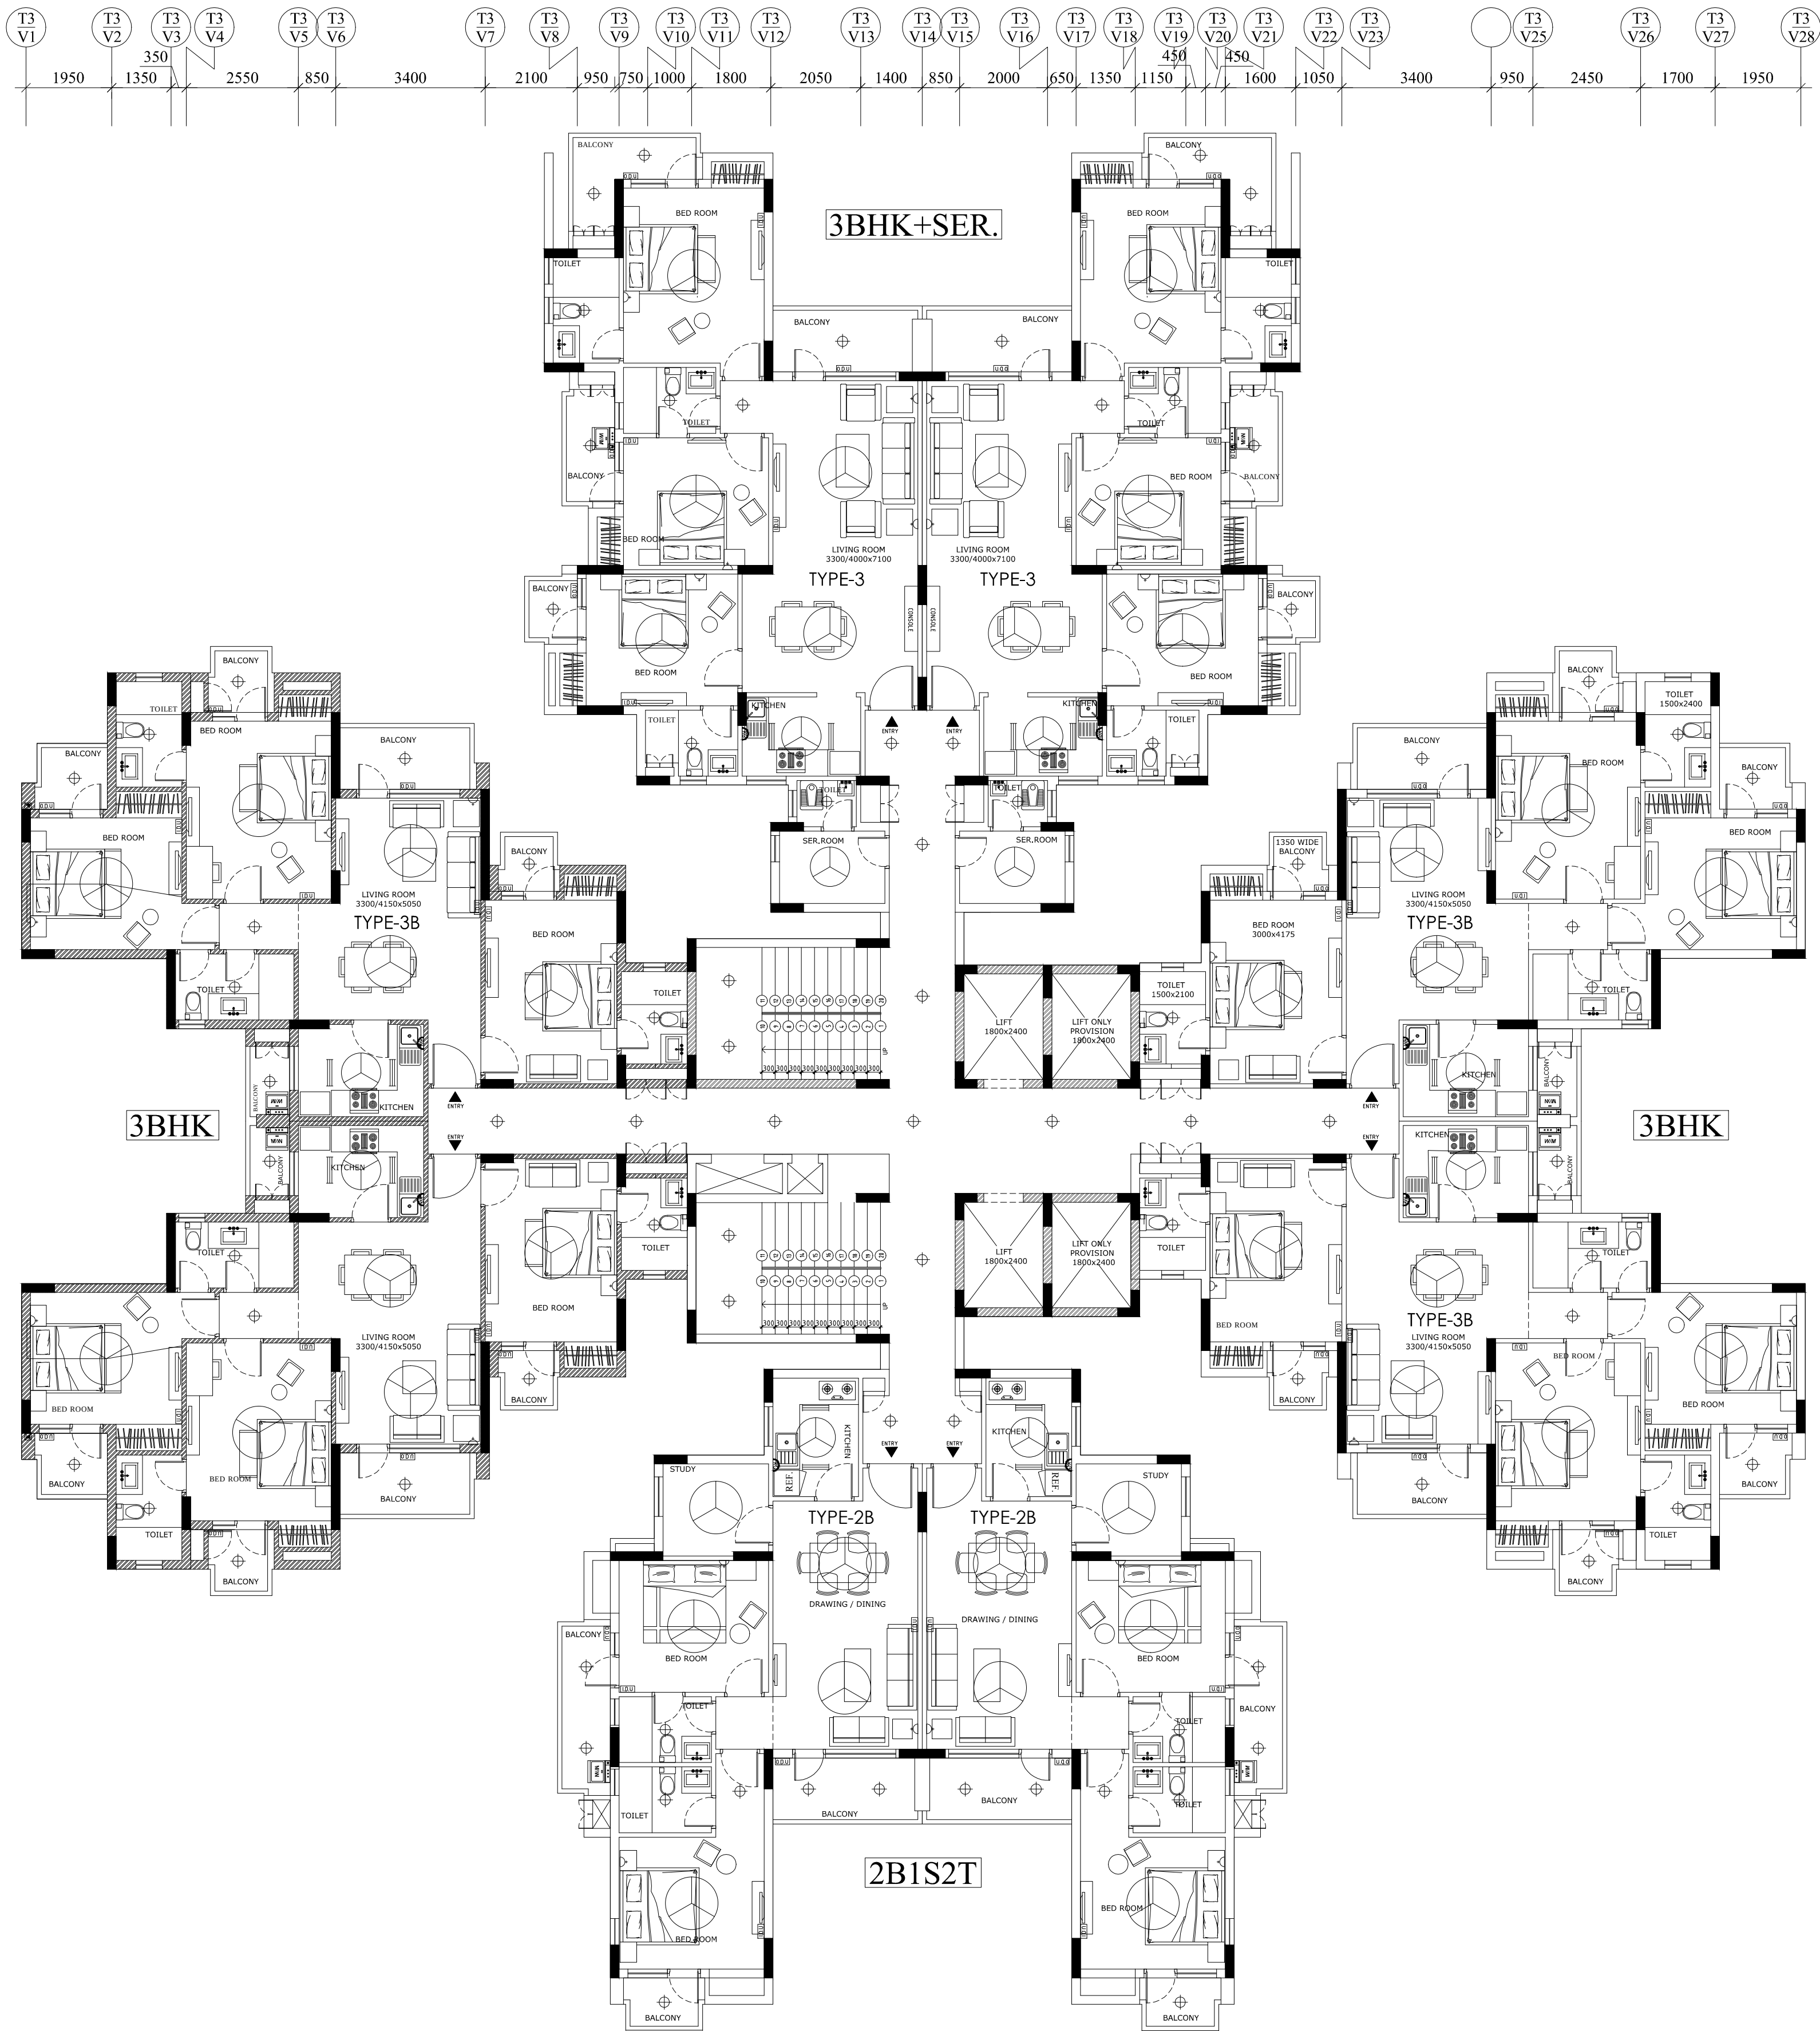

SYMBOL	DESCRIPTION	HEIGHT
	SWITCH BOARD FOR GYSER	1050 MM
	ONE WAY SWITCH	1050 MM
	TWO WAY SWITCH	1050 MM
	FAN REGULATOR	1050 MM
	2nos. 6A SOCKET CONTROLLED BY 1 nos. SWITCH (FOR TV)	900 MM
	6A SWITCH SOCKET OUTLET (FOR CHIMNEY)	2150 MM
	6A PLUG POINT	1050 MM
	6/16A POWER POINT	1050 MM
	25AMP SWITCH SOCKET FOR AC	200 MM
	16A SWITCH SOCKET (KITCHEN GYSR)	2200 MM
	16A SWITCH SOCKET (TOILET GYSR)	1550 MM
	6A PLUG POINT (BED SIDE)	550 MM
	6A, SOCKET	AS/DWG
	EXHAUST FAN	2150 MM
	MIRROR LIGHT AT WASHBASIN	2000 MM
	TELEPHONE (BED SIDE)	550 MM
	FINAL DISTRIBUTION BOARD	1500 MM
	CALL BELL BUZZER	2250 MM
	DOOR CALL BELL SWITCH	1050 MM
	CEILING LIGHT	CEILING LIGHT
	WALL MOUNTED FIXTURE	2100 MM
	1x18W T5 TUBE LIGHT	
	TV OUTLET	900 MM
	DATA POINT	
	OUT DOOR UNIT	
	INDOOR UNIT	2250 MM
	1200mm DIA CEILING FAN	CEILING
	900mm DIA CEILING FAN	CEILING
	DG DISPLAY UNIT	AS/DWG
	BULK HEAD LIGHT	1800 MM
	"L" INDICATION ON EMERGENCY LIGHT	
	POWER CONDUIT IN WALL/SLAB	25/32MM DIA
	TV CONDUIT IN SLAB	25/32MM DIA
	TELEPHONE CONDUIT IN SLAB	25/32MM DIA
	PULL BOX IN CEILING SLAB	
	32mm DIA SUBMAIN CONDUIT	25/32MM DIA
	LIGHT CONDUIT IN WALL/SLAB	25/32MM DIA
	EMERGENCY CONDUIT IN WALL/SLAB	25/32MM DIA
	LIGHT LOOPING	
	EMERGENCY LIGHT LOOPING	
	NO. OF CIRCUIT	
	NO. OF SWITCH	
	NAME OF PHASE	

FIRE SYMBOL		
SYMBOL	DESCRIPTION	HEIGHT
	HEAT DETECTOR	CEILING
	SMOKE DETECTOR	CEILING
	HOOTER	2200 MM
	CONTROL MODULE	2200 MM
	MANUAL CALL POINT	1050 MM
	ZONE MODULE UNIT	1050 MM
	FIRE CONDUIT IN SLAB	25 MM DIA
	FIRE LOOPING	

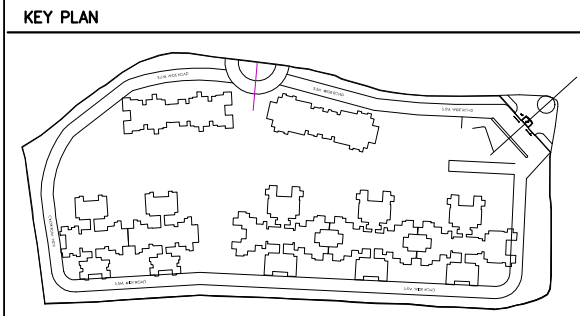

ARCHITECTS
GENRE OF DESIGN
ARCHITECTURE, MASTER PLANNING & INTERIOR DESIGN
A-57, BASEMENT FLOOR, SHIVALIK,
MALVIYA NAGAR, NEW DELHI
TELEPHONE : 011-40574968

M.E.P. CONSULTANT :-
ACROBAT ENGINEERS & ASSOCIATES
H.No. 19/18, Basement Lvl.
Spring Field Colony
Faridabad (Haryana)
Tel. : 0129-4056009
customerservice@acrobotengineers.com

PURPOSE OF DRAWING
C.F.C. F.I.O. TENDER

THIS DRAWING HAS TO BE READ IN CONJUNCTION WITH
DRG. NO.
RES-AR-01 RES-AR-02 RES-AR-03

CLIENT :- HORIZON BUILDCON PVT.LTD.

PROJECT :- HOUSING
SECTOR-86, NOIDA

DRAWING TITLE: TOWER-E
CEILING LAYOUT

SHEET TITLE
TOWER-E TYPICAL FLOOR ELECTRICAL PLAN

DRG. NO. AEA/P-109/1ST.FL/EL-01
DATE: 01/06/2014
SCALE: NTS
DETAIL: MANDEEP
CHECKED BY: NK
REV. NO
R0
NORTH

