


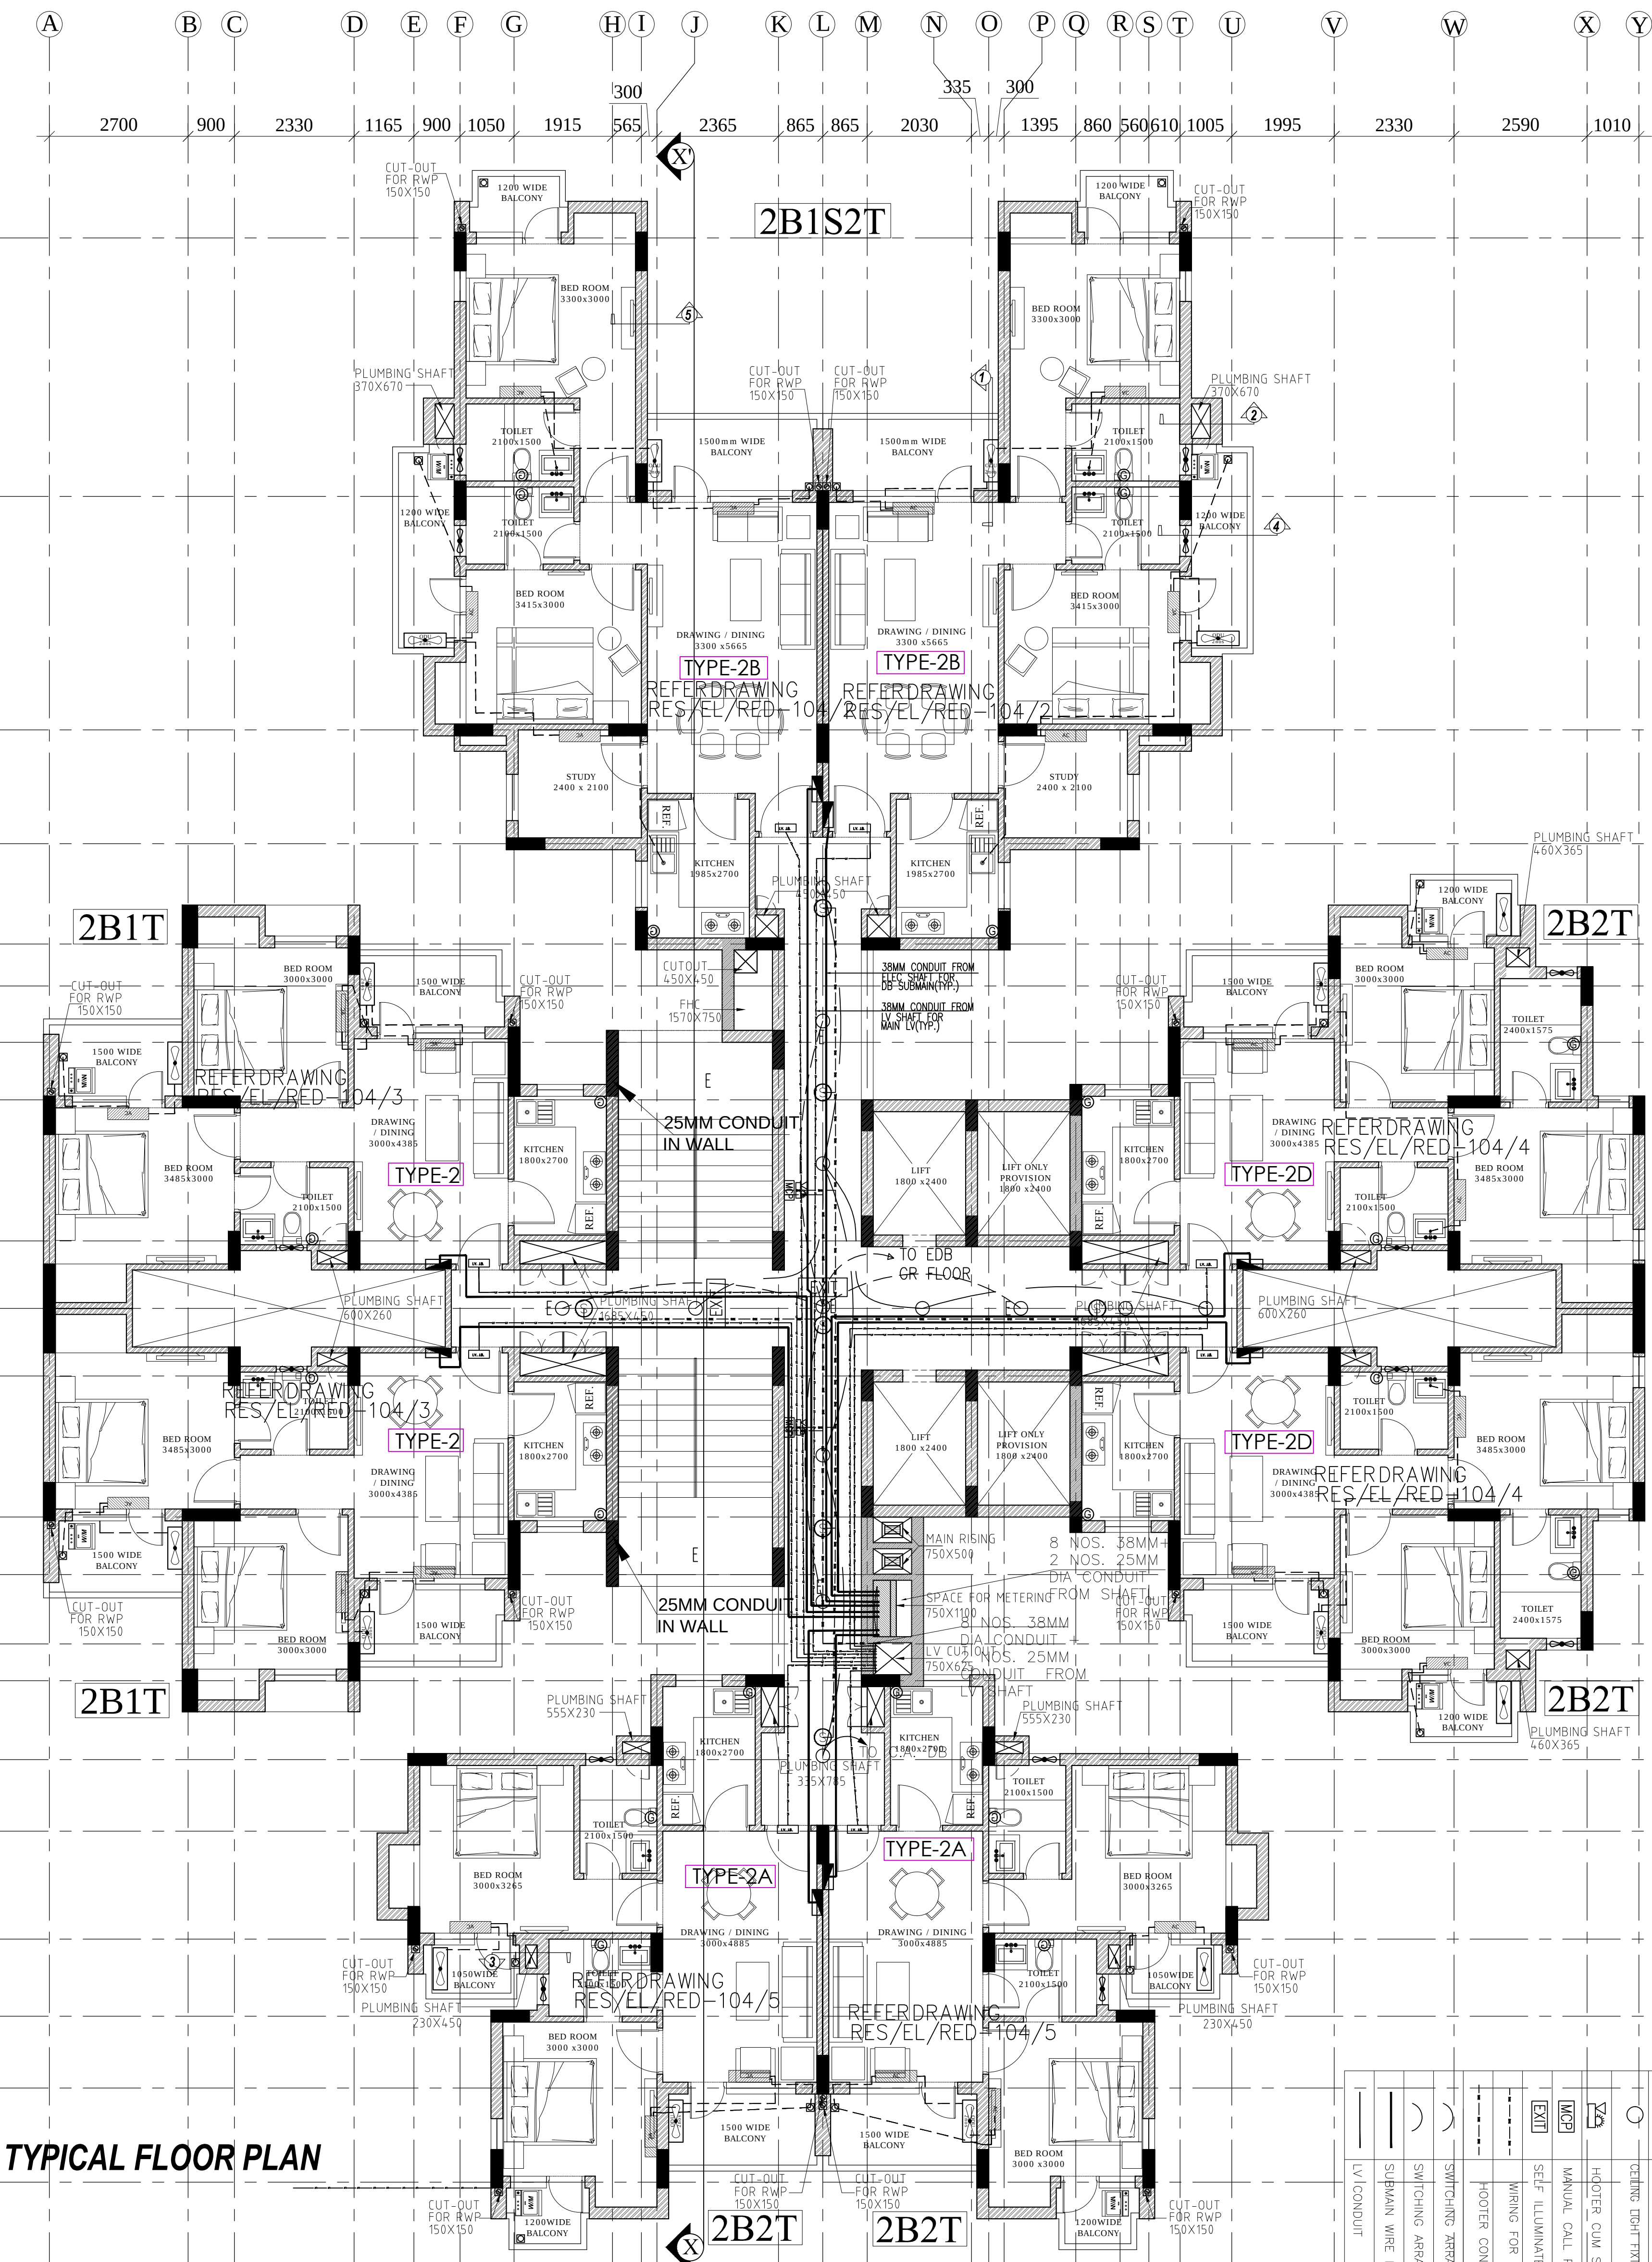

TYPICAL FLOOR PLAN

LEGENDS

①	SMOKE DETECTOR
②	CEILING LIGHT FIXTURE
③	HOOTER CUM STROBE
④	MANUAL CALL POINT
⑤	SELF ILLUMINATED EXIT SIGN
⑥	WIRING FOR FGA SYSTEM
⑦	HOOTER CONDUIT
⑧	SWITCHING ARRANGEMENT (EMERGENCY)
⑨	SWITCHING ARRANGEMENT (NORMAL)
⑩	SUBMAIN WIRE IN CONDUIT
⑪	LV CONDUIT

NOTES

- DRAWING AND DIMENSIONS ARE ONLY TO BE READ AND NOT SCALED.
- UNLESS OTHERWISE SPECIFIED, ALL DIMENSIONS ARE GIVEN IN MILLIMETERS.
- DRAWING SHALL BE READ IN CONJUNCTION WITH RELEVANT ARCHITECTURAL, STRUCTURAL, MECHANICAL, ELECTRICAL, AND PLUMBING DRAWINGS.
- ALL DIMENSIONS IN DRAWINGS ARE WITH REFERENCE TO THE TELL AS BENCHMARK AT SITE.
- ANY DISCREPANCY BETWEEN THE ARCHITECTURAL, STRUCTURAL, OR SERVICES DRAWINGS MUST BE BROUGHT TO THE ATTENTION OF THE ARCHITECT BY THE CONTRACTOR OR PROJECT MANAGER, BEFORE EXECUTION OF THE SAME.

IMPORTANT NOTES

- SPECIFICATION
- 2
- 3
- 4
- 5
- 6
- 7
- 8
- 9
- 10
- 11
- 12
- 13
- 14
- 15
- 16
- 17
- 18
- 19
- 20
- 21

CONSULTANTS	NAME	PHONE NO.
PROJECT MANAGER	ROBERT DESIGN	
STRUCTURE	ARCHITECTS	
PLUMBING	MECHANICAL	
ELECTRICAL	MECHANICAL	
MECHANICAL	MECHANICAL	
LANDSCAPE	MECHANICAL	

OBJECTIVE OF THIS DRAWING

A	THIS DRAWING IS TO BE READ FOR:
A1	ELECTRICAL LAYOUT ONLY
A2	
A3	
B	THIS DRAWING NOT TO BE READ FOR:
B1	LAYOUT PLAN
B2	
B3	

- NOTE:-
- THIS DRAWING SHALL BE READ IN CONJUNCTION WITH ALL RELEVANT ARCHITECTURAL, STRUCTURAL AND ELECTRICAL DRAWINGS.
 - ALL CONDUITING SHALL BE RECESSED/ CONCEALED SYSTEM WITH PVC HEAVY DUTY CONDUIT.
 - MINIMUM SIZE OF CONDUIT SHALL BE 25mm.
 - ALL SWITCH SOCKET SHALL BE MODULAR TYPE.
 - ALL FAN SHALL HAVE SWITCH AND STEPPED FAN REGULATOR.
 - ALL BOX SHALL BE OF GI.
 - LIFT WELL LIGHT SHALL BE CONTROLLED BY LIFT MACHINE ROOM DB.
 - IN LIFT WELL, LIGHT POINT ON EACH FLOOR & POWER POINT ON ALTERNATING FLOOR SHALL BE PROVIDED.
 - STAIRCASE & LIFT LOBBY LIGHTING HAVE SEPARATE CIRCUITING AND SHALL BE ON INVERTOR.
 - THE BOTTOM OF SWITCH PLATES MAY BE CHECKED WITH SKIRTING LEVEL HEIGHT AND LOCATION & SIZE OF TILES IN BATHROOM & KITCHEN AS PER SITE.

PURPOSE OF DRAWING	REVISION	DATE
G.F.C. F.I.O. TENDER	1	14.12.12
	2	
	3	

THIS DRAWING HAS TO BE READ IN CONJUNCTION WITH

DRG. NO. RES-AR-01 RES-AR-02 RES-AR-03

CLIENT :- HORIZON BUILDCON PVT.LTD.

PROJECT :- HOUSING SECTOR-86, NODA

SHEET TITLE TOWER-C TYPICAL LAYOUT PL

DRG. NO. RES/EL/ORANGE-104/1
DATE: 16/04/13
SCALE: 1:100
DESIGN: RO
CHECKED BY: PRAKASH
APPROVED BY: PRAKASH
ARCHITECTURE: MASTERS PLANNING & INTERIOR DESIGN
P.L. SINGH
TELEPHONE: 011-4257888