



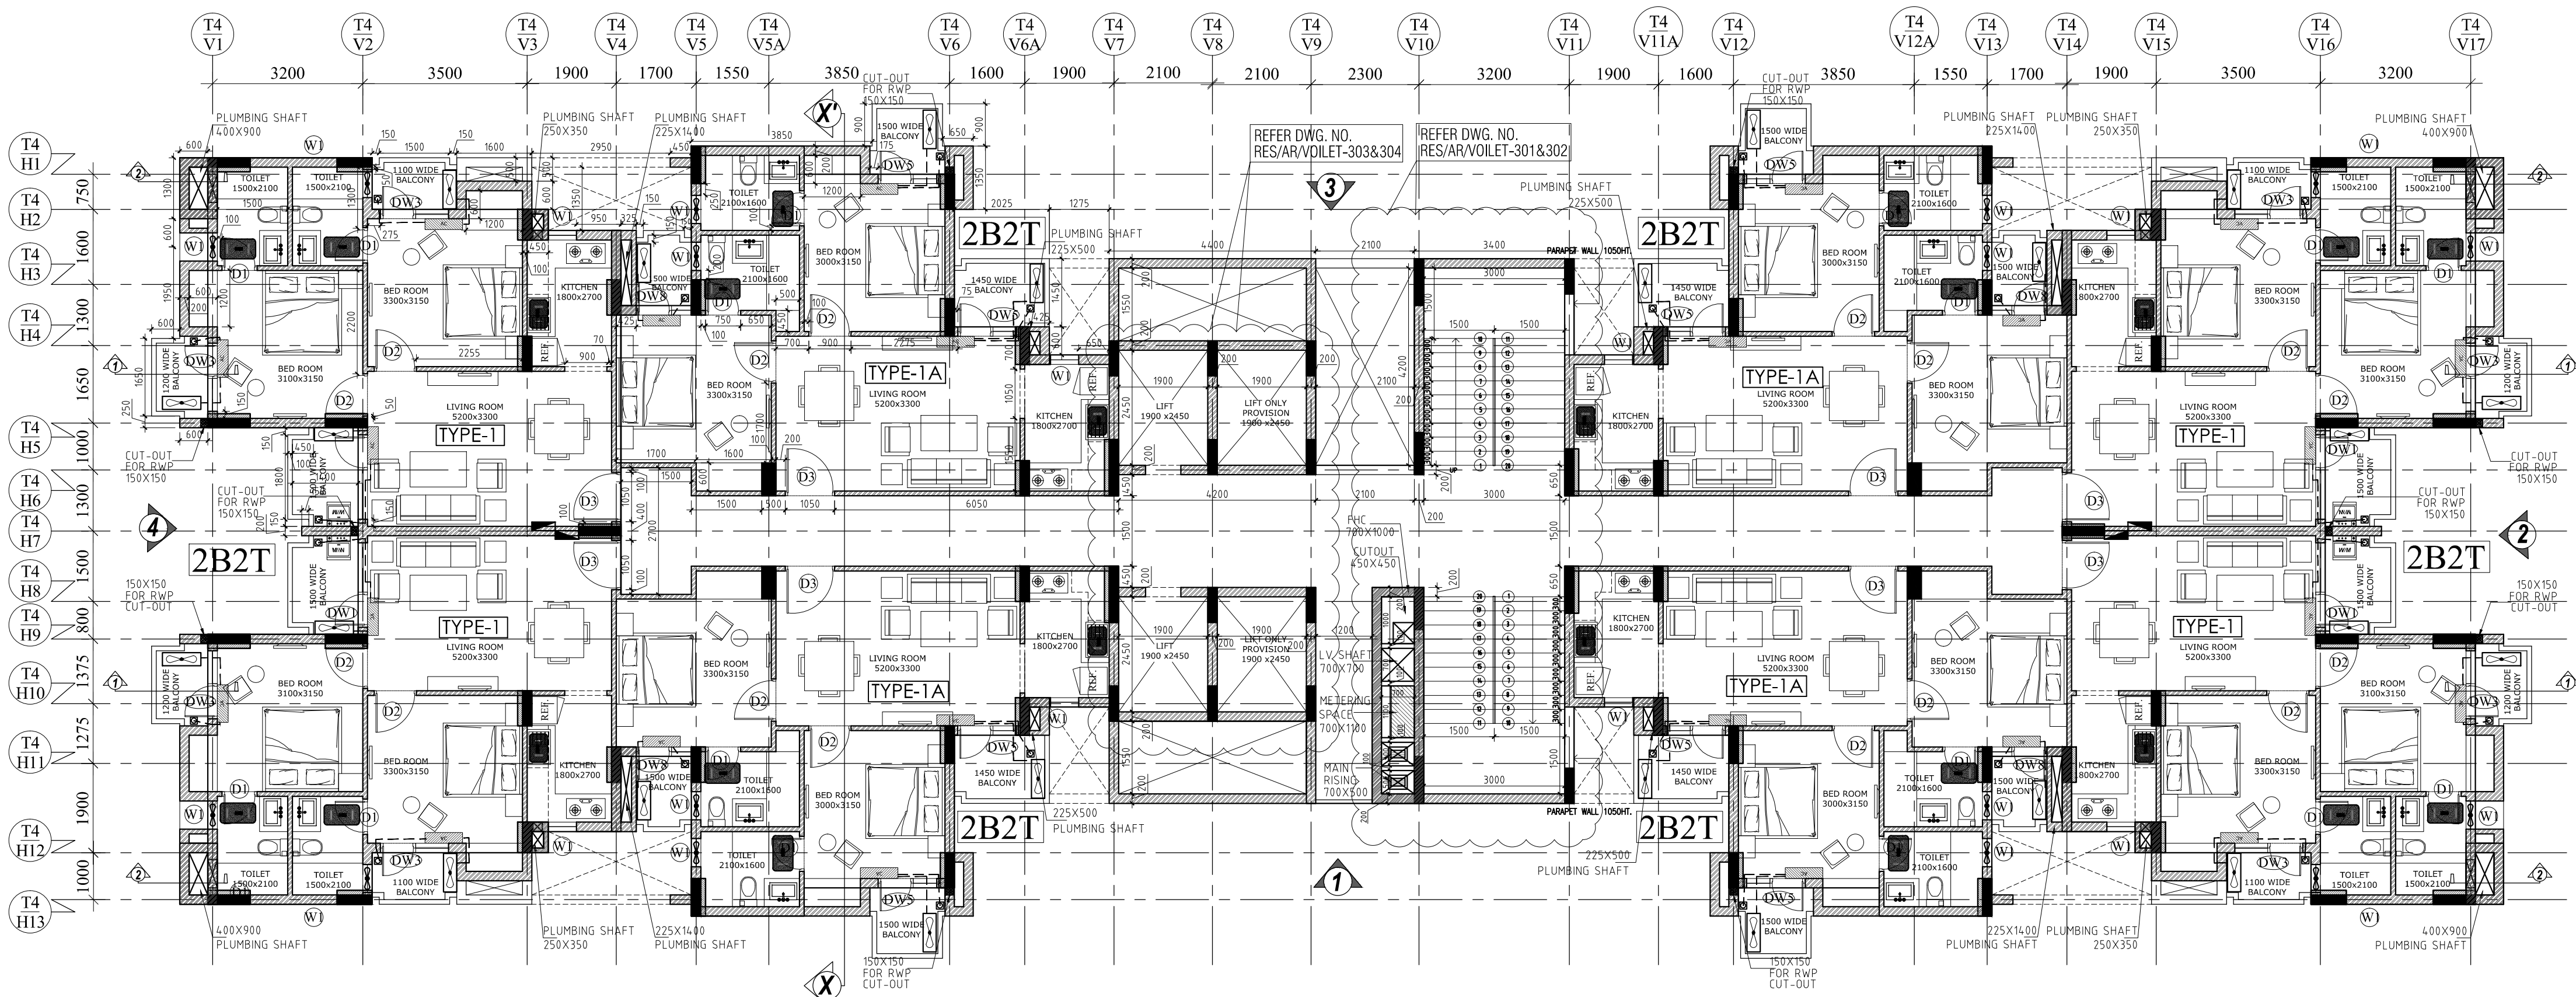

TYPICAL LEVEL FLOOR PLAN FOR PODIUM,1ST, 2ND, 7TH, 8TH, 13TH & 14TH FLOOR

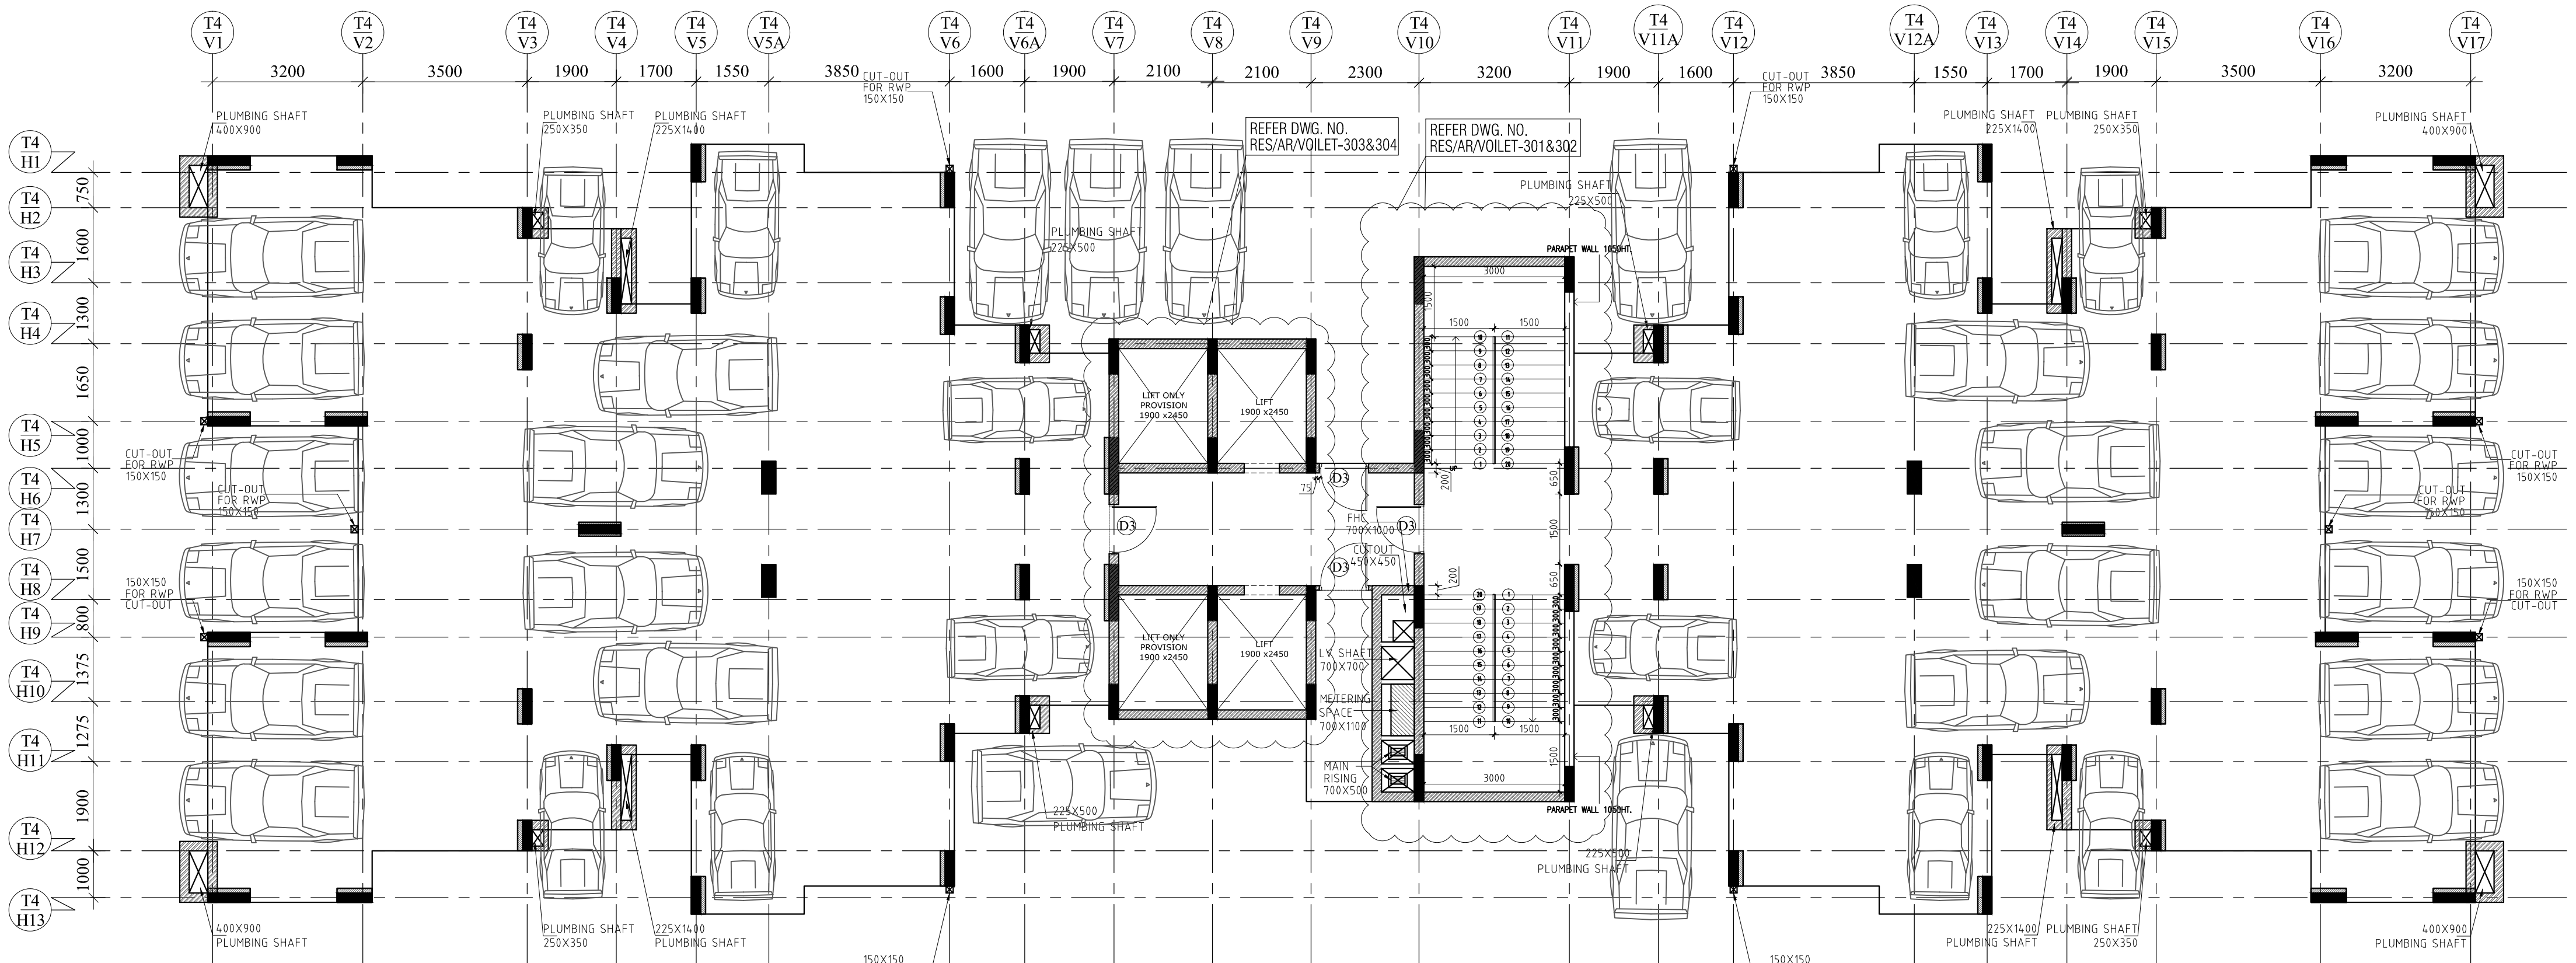

STILT LEVEL FLOOR PLAN

DOOR AND WINDOW SCHEDULE OF UNIT-TYPE-1(2B2T) FOR TOWER-G(VOLLET)						
S.NO.	TAG	SIZE	CILL	LINTEL	NOS.	NO.OF UNITS
1.	D1	750X2100	+00	2100	2	
2.	D2	900X2100	+00	2100	2	
3.	D3	1050X2100	+00	2100	1	
1.	DW1	750+1050X2100	+150	2100	1	
2.	DW2	750+1350X2100	+150	2100	NA	
3.	DW3	750+700X2100	+150	2100	2	
4.	DW4	750+780X2100	+150	2100	NA	
5.	DW5	750+500X2100	+150	2100	NA	
6.	DW6	750+900X2100	+150	2100	NA	
7.	DW7	750+1600X2100	+150	2100	NA	

DOOR AND WINDOW SCHEDULE OF UNIT-TYPE-1A(2B2T) FOR TOWER-G(VOLLET)						
S.NO.	TAG	SIZE	CILL	LINTEL	NOS.	NO.OF UNITS
1.	D1	750X2100	+00	2100	2	
2.	D2	900X2100	+00	2100	2	
3.	D3	1050X2100	+00	2100	1	
1.	DW1	750+1050X2100	+150	2100	NA	
2.	DW2	750+1350X2100	+150	2100	NA	
3.	DW3	750+700X2100	+150	2100	NA	
4.	DW4	750+780X2100	+150	2100	NA	
5.	DW5	750+500X2100	+150	2100	2	
6.	DW6	750+900X2100	+150	2100	NA	
7.	DW7	750+1600X2100	+150	2100	NA	
8.	DW8	750+425X2100	+150	2100	1	
1.	W1	600X1050	+1050	2100	3	
2.	W1A	600X600	+1500	2100	NA	
3.	W2	900X1050	+1050	2100	NA	
4.	W2A	900X1950	+150	2100	NA	
5.	W3	1200X1950	+150	2100	NA	

NOTES

1. DRAWING AND DIMENSIONS ARE ONLY TO BE READ AND NOT SCALED.

2. UNLESS OTHERWISE MENTIONED, ALL DIMENSIONS ARE GIVEN IN MILLIMETERS.

3. THIS DRAWING SHALL BE READ IN CONJUNCTION WITH RELEVANT ARCHITECTURAL, STRUCTURAL AND SERVICES DRAWINGS.

4. ALL LEVELS GIVEN IN DRAWING ARE WITH REFERENCE TO THE M.S.L. AS BENCHMARKED AT SITE.

5. ANY DISCREPANCY BETWEEN THE ARCHITECTURAL/STRUCTURAL OR SERVICES DRAWINGS MUST BE BROUGHT TO THE ATTENTION OF THE ARCHITECT BY THE CONTRACTOR OR PROJECT MANAGER, BEFORE EXECUTION OF THE SAME.

IMPORTANT NOTES

1. SPECIFICATION

2. PROJECT MANAGER

3. STRUCTURE

4. PLUMBING

5. ELECTRICAL

6. HVAC

7. LANDSCAPE

8. OBJECTIVE OF THIS DRAWING

9. THIS DRAWING IS TO BE READ FOR:

10. ARCHITECTURAL DETAIL ONLY

11. THIS DRAWING IS TO BE READ FOR:

12. LAYOUT PLAN

CONSULTANTS

NAME	PHONE NO.
PROJECT MANAGER	NONCEPT DESIGN
STRUCTURE	NONCEPT DESIGN
PLUMBING	NONCEPT DESIGN
ELECTRICAL	MR. SHEKHAR SINGH
HVAC	MR. SHEKHAR SINGH
LANDSCAPE	MR. SHEKHAR SINGH

KEY PLAN

REVISION

REV.	REVISION	DATE
1		16.10.13

PURPOSE OF DRAWING

G.P.C. F.I.O. TENDER

THIS DRAWING HAS TO BE READ IN CONJUNCTION WITH DRG. NO.

RES-AR-01 RES-AR-02 RES-AR-03

CLIENT: HORIZON BUILDCON PVT.LTD.

PROJECT: HOUSING SECTOR-86, NOIDA

SHEET TITLE: TOWER-G STILT FLOOR PLAN & TYPICAL FLOOR PLAN

DRG. NO. RES/AR/VOILET-103&104

DATE: 16/10/2014

SCALE: 1:100

CHECKED BY: PROJECT MANAGER

ARCHITECT: R0

GENRE OF DESIGN: ARCHITECTURE, MASTER PLANNING & INTERIOR DESIGN

A-17, BANGSAR FLOOR, BANGSAR, MALAYSIAN, NEW DELHI

TELEPHONE: 011-4551-4551