


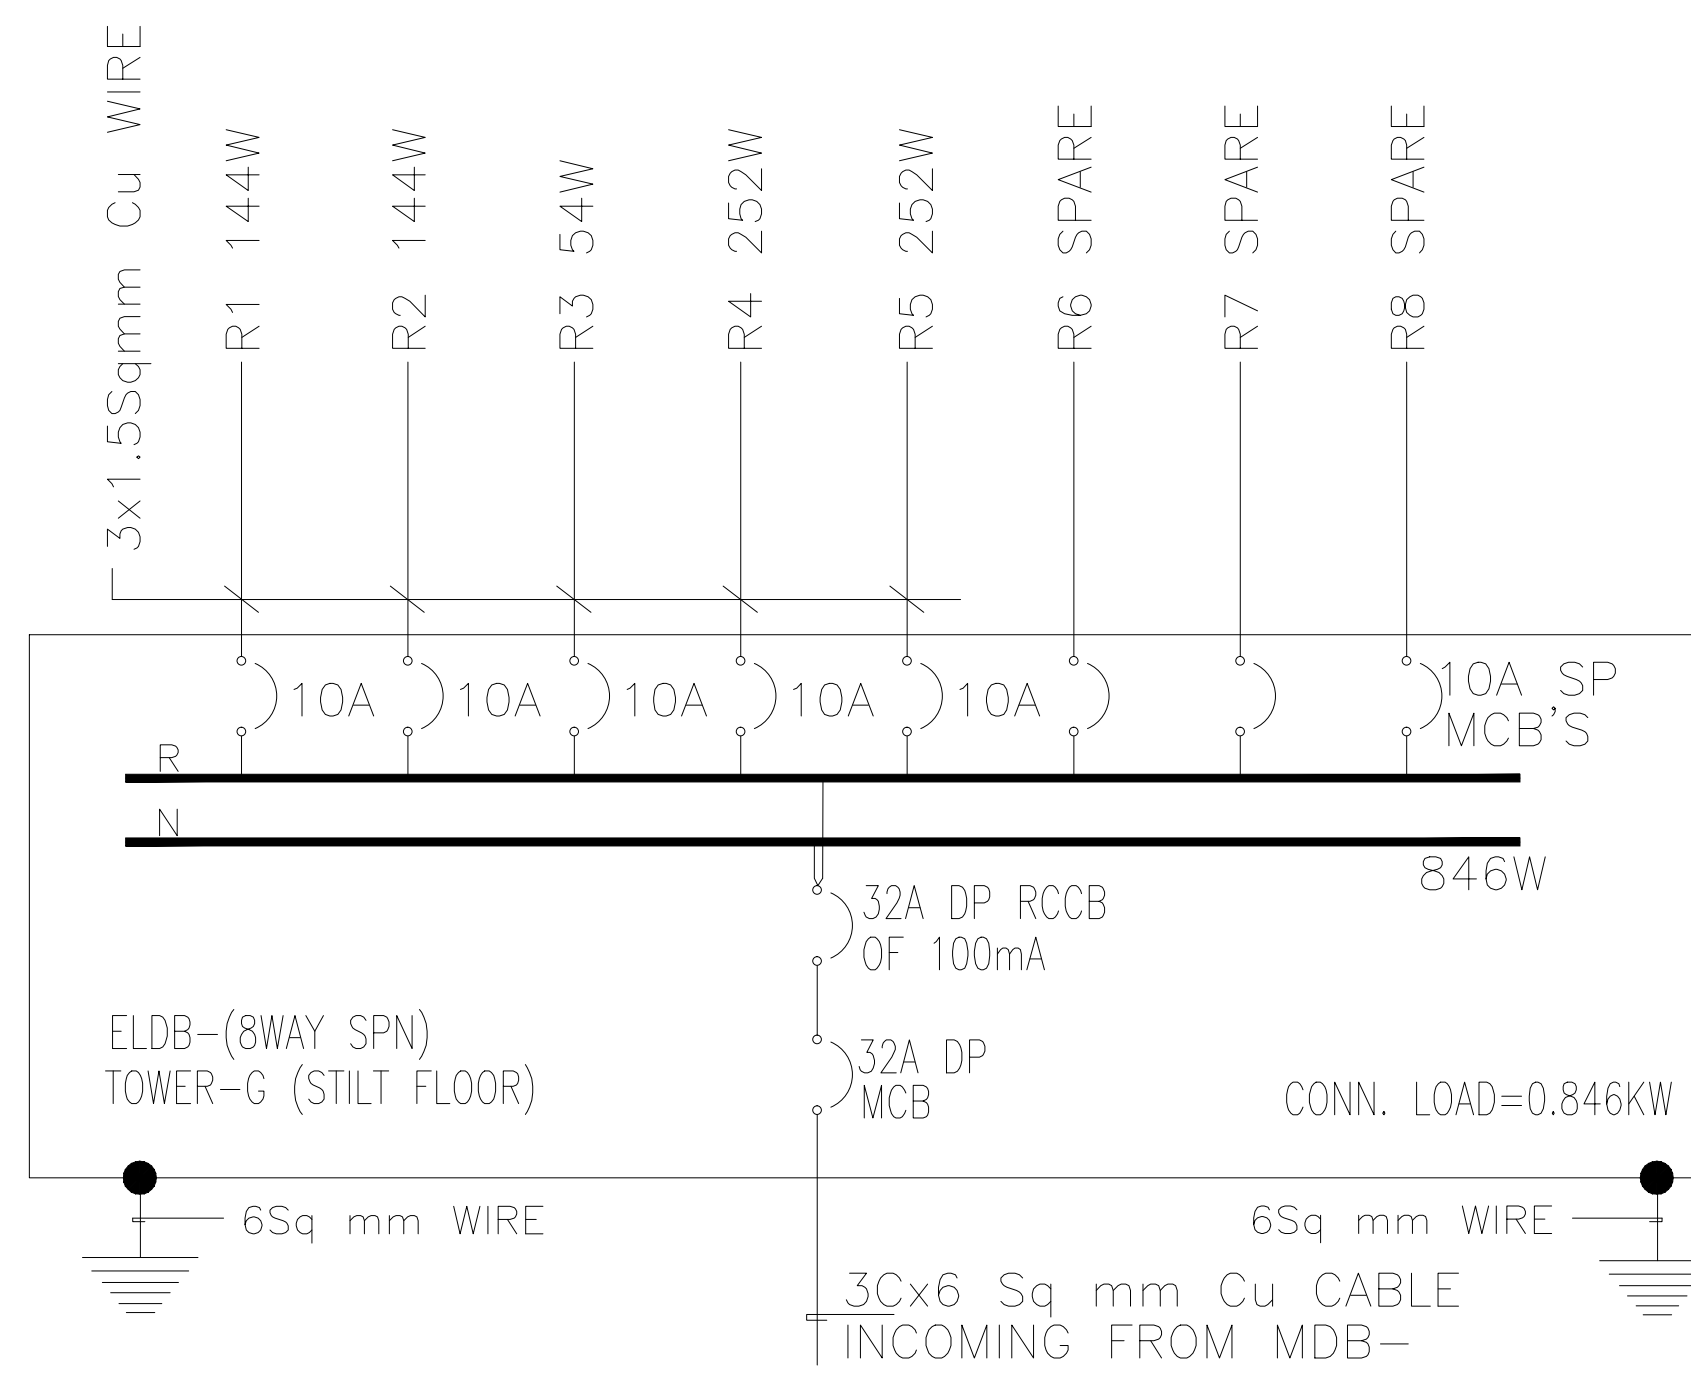

LEGEND:-	
	1x36W FLUORESCENT FIXTURE(CEILING)
	CEILING LIGHT (1X18W)
	DISTRIBUTION BOARD
	32MM DIA CONDUIT IN SLAB/WALL
	25MM DIA SUB MAIN CONDUIT
	EMERGENCY CONDUIT
	LIGHT LOOPING
	EMERGENCY LOOPING
	NO. OF CIRCUIT
	NAME OF PHASE
	HOOTER
	CONTROL MODULE
	MANUAL CALL POINT
	TELEPHONE FIRE JACK

GOOD FOR CONSTRUCTION

PURPOSE OF DRAWING

THIS DRAWING HAS TO BE READ IN CONJUNCTION WITH
DRG. NO.

```

graph LR
    A[RES=AR=01] --> B[RES=AR=02]
    B --> C[RES=AR=03]
    C --> D[ ]

```

CLIENT :- HORIZON BUILDCON PVT.LTD.

PROJECT :-HOUSING
SECTOR-86, NOIDA

SHEET TITLE
TOWER-G STILT FLOOR PLAN

ELECTRICAL LAYOUT

DRG. NO. AEA/P-109/TW-G/S-FP/EL-			
DATE -	13/03/2014	REV. NO	NORTH

SCALE -	A1@1:75
DEALT -	RAVINDER

CHECKED BY - BS
ARCHITECTS

ARCHITECTURE, MASTER PLANNING & INTERIOR DESIGN
A-57, BASEMENT FLOOR, SHIVAJI,

VALVIYA NAGAR, NEW DELHI
TELEPHONE : 011-40574958

ACROBAT ENGINEERS & ASSOCIATES
H No. 19, Block 18, Basement level

Spring field colony, Sector -31,
Faridabad-121002
Email id: customerservice@acnholsteinears.com