


SYMBOL	DESCRIPTION	HEIGHT
	SWITCH BOARD FOR GYSER	1050 MM
	ONE WAY SWITCH	1050 MM
	TWO WAY SWITCH	1050 MM
	FAN REGULATOR	1050 MM
	2nos 6A SOCKET CONTROLLED BY 1 Nos SWITCH (FOR T.V)	900 MM
	6A SWITCH SOCKET OUTLET (FOR CHIMNEY)	2150 MM
	6A PLUG POINT	1050 MM
	6/16A POWER POINT	1050 MM
	25AMP SWITCH SOCKET FOR AC	200 MM
	16A SWITCH SOCKET (KITCHEN GYSER)	2200 MM
	16A SWITCH SOCKET (TOILET GYSER)	1550 MM
	6A PLUG POINT (BED SIDE)	550 MM
	6A, SOCKET AS/DWG	AS/DWG
	EXHAUST FAN	2150 MM
	MIRROR LIGHT AT WASHBASIN	2000 MM
	TELEPHONE (BED SIDE)	550 MM
	FINAL DISTRIBUTION BOARD	1500 MM
	CALL BELL BUZZER	2250 MM
	DOOR CALL BELL SWITCH	1050 MM
	CEILING LIGHT	CEILING LIGHT
	WALL MOUNTED FIXTURE	2100 MM
	1X18W T5 TUBE LIGHT	
	TV OUTLET	900 MM
	DATA POINT	
	OUT DOOR UNIT	
	INDOOR UNIT	2250 MM
	1200mm DIA CEILING FAN	CEILING
	900mm DIA CEILING FAN	CEILING
	DG DISPLAY UNIT	AS/DWG
	BULK HEAD LIGHT	1800 MM
	"E" INDICATION ON EMERGENCY LIGHT	
	POWER CONDUIT IN WALL/SLAB	25/32MM DIA
	TV CONDUIT IN SLAB	25/32MM DIA
	TELEPHONE CONDUIT IN SLAB	25/32MM DIA
	PULL BOX IN CEILING SLAB	
	32mm DIA SUBMAIN CONDUIT	25/32MM DIA
	LIGHT CONDUIT IN WALL/SLAB	25/32MM DIA
	EMERGENCY CONDUIT IN WALL/SLAB	25/32MM DIA
	LIGHT LOOPING	
	EMERGENCY LIGHT LOOPING	
	NO. OF CIRCUIT	
	NO. OF SWITCH	
	NAME OF PHASE	
	TELEPHONE FIRE JACK	
	HOOSTER	2200 MM
	CONTROL MODULE	2200 MM
	MANUAL CALL POINT	1050 MM

KEY PLAN

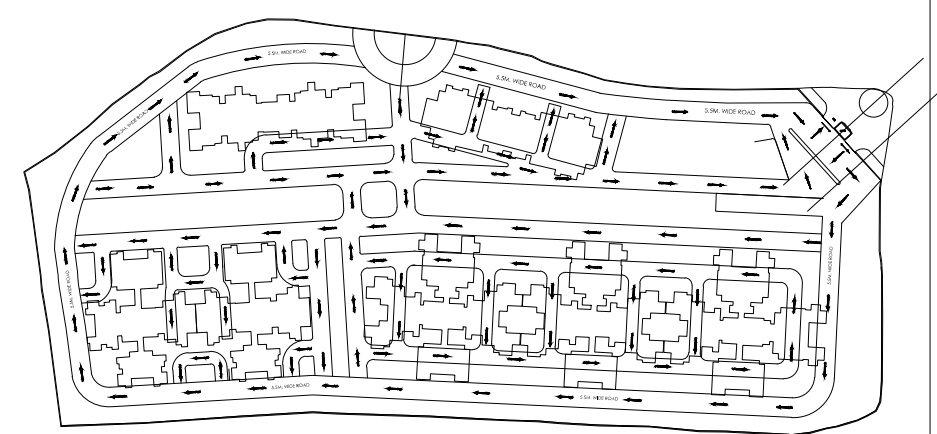

ARCHITECTS
GENRE OF DESIGN
ARCHITECTURE, MASTER PLANNING & INTERIOR DESIGN
A-57, BASEMENT FLOOR, SHIVALIK,
MALVIYA NAGAR, NEW DELHI
TELEPHONE : 011-40574968

M.E.P. CONSULTANT :-

ACROBAT ENGINEERS & ASSOCIATES
H.No. 19/18, Basement Lvl.
Spring Field Colony
Faridabad (Haryana)
Tel. : 0129-4056009
customerservice@acrobatengineers.com

PURPOSE OF DRAWING
G.F.C F.I.O TENDER

THIS DRAWING HAS TO BE READ IN CONJUNCTION WITH
DRG. NO.

RES-AR-01 RES-AR-02 RES-AR-03

CLIENT :- HORIZON BUILDCON PVT.LTD.

PROJECT :- HOUSING
SECTOR-86, NOIDA


DRAWING TITLE. TOWER-G
ELECTRICAL LAYOUT

SHEET TITLE
TOWER-G TYPICAL FLOOR
ELECTRICAL CONDUIT LAYOUT

DRG. NO. AEA/P-109/1ST.FL/EL-01

DATE -	09/05/2014	REV. NO		NORTH
SCALE -	NTS			
DETAIL -	MANDEEP			
CHECKED BY -	NK			

T4 V1 3200 T4 V2 3500 T4 V3 1900 T4 V4 1700 T4 V5 1550 T4 V5A 3850 T4 V6 1600 T4 V6A 1900 T4 V7 2100 T4 V8 2100 T4 V9 2300 T4 V10 3200 T4 V11 1900 T4 V11A 1600 T4 V12 3850 T4 V12A 1550 T4 V13 1700 T4 V14 1900 T4 V15 3500 T4 V16 3200 T4 V17

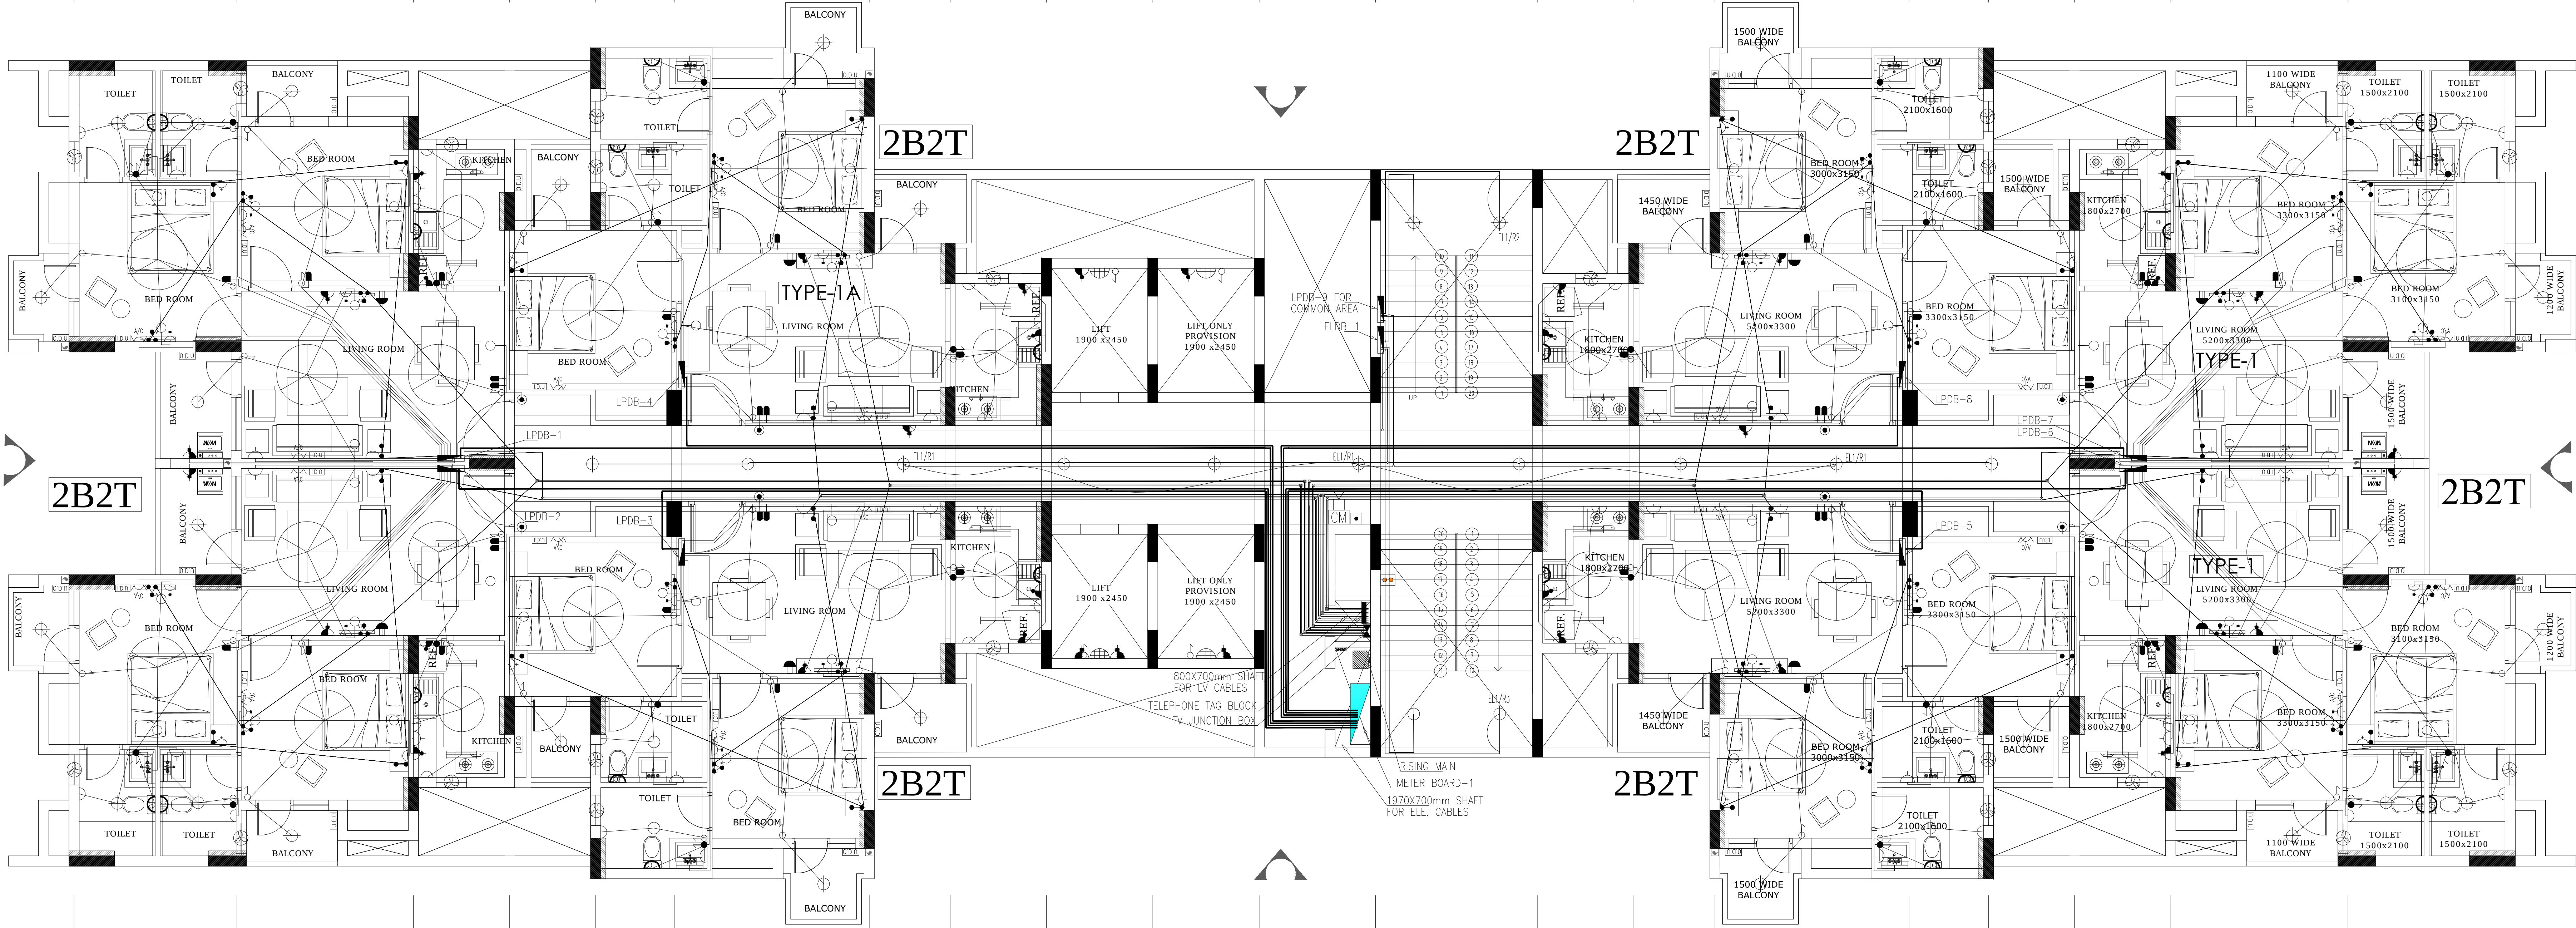

TYPICAL LEVEL FLOOR PLAN