

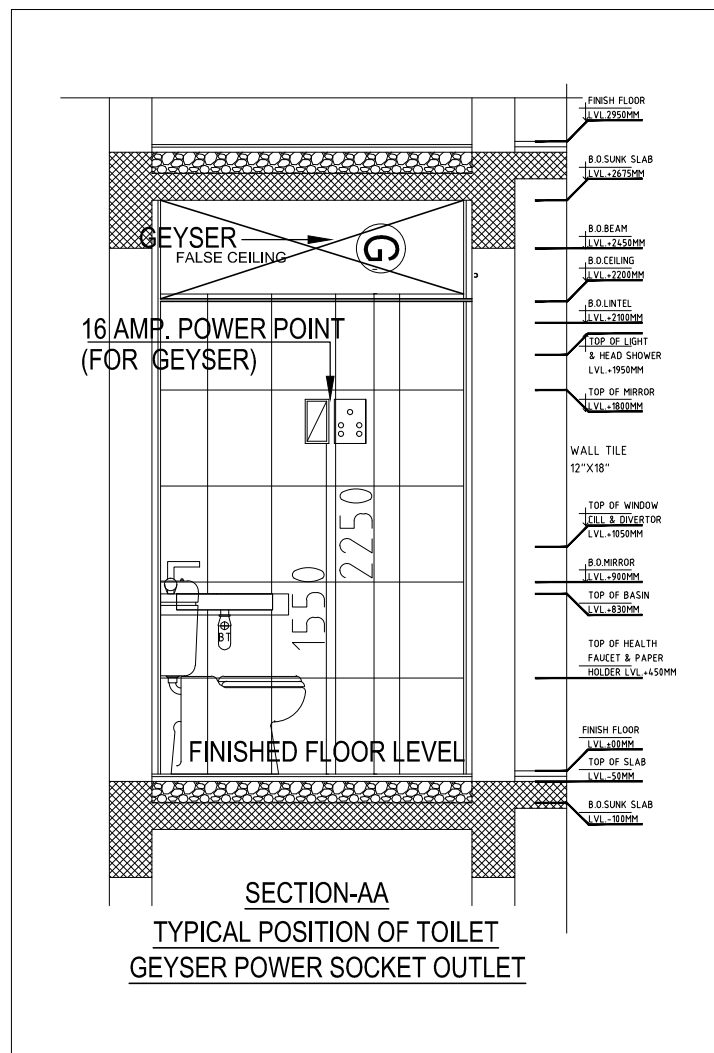
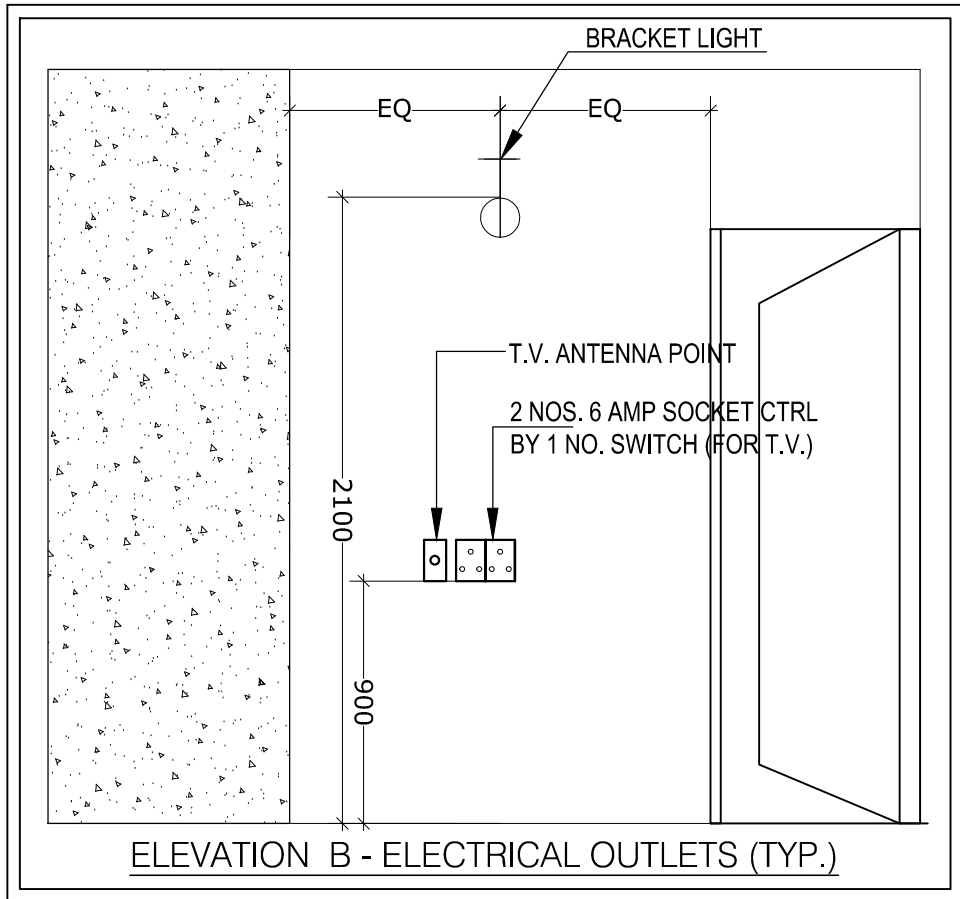
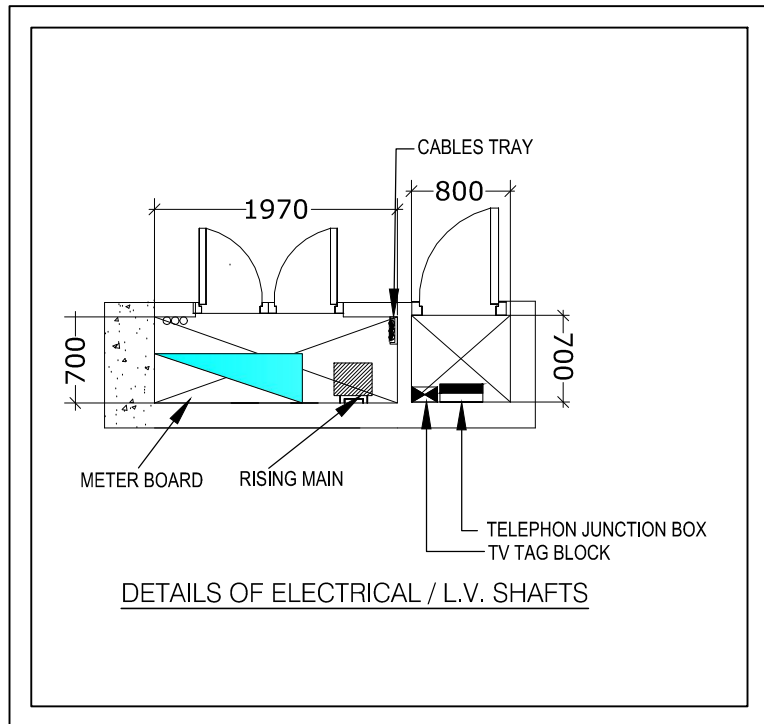
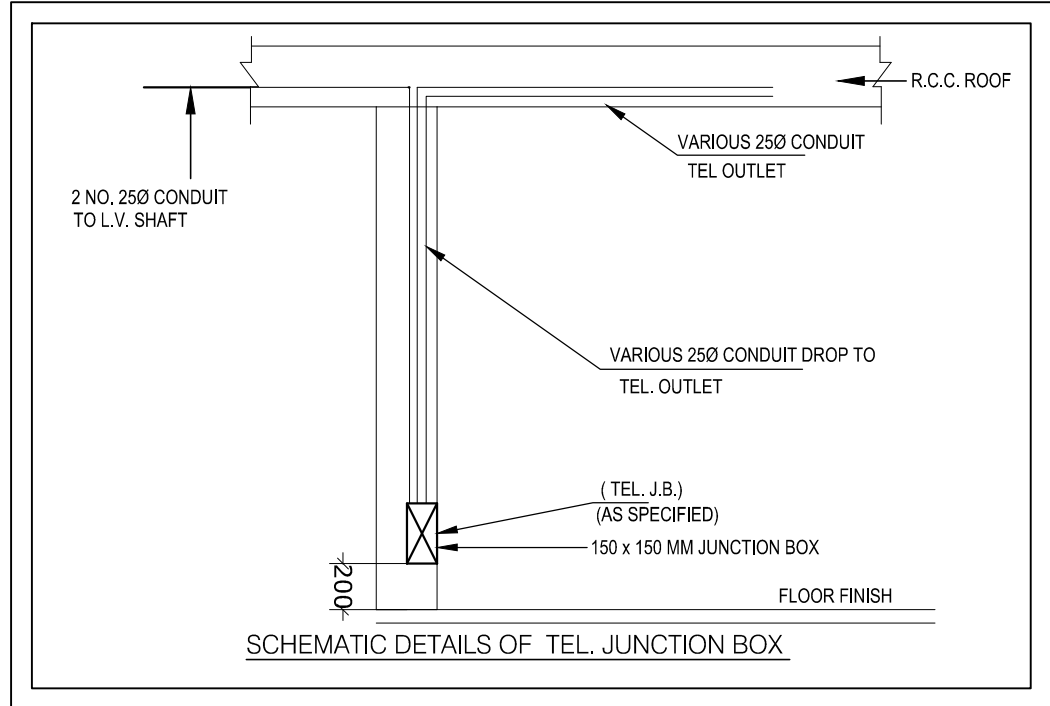
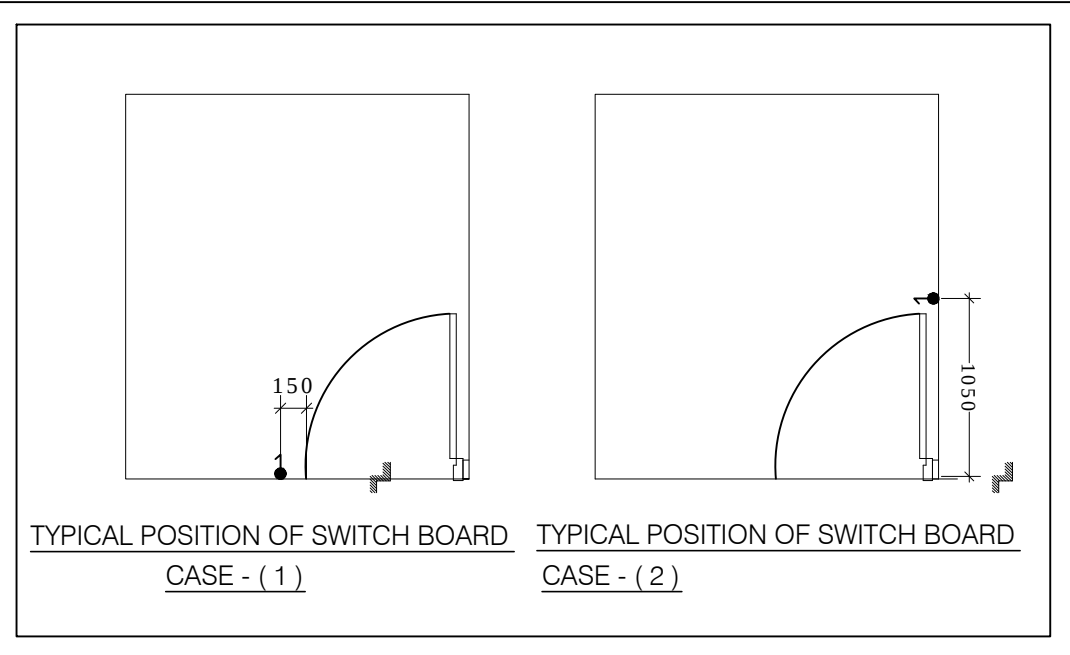


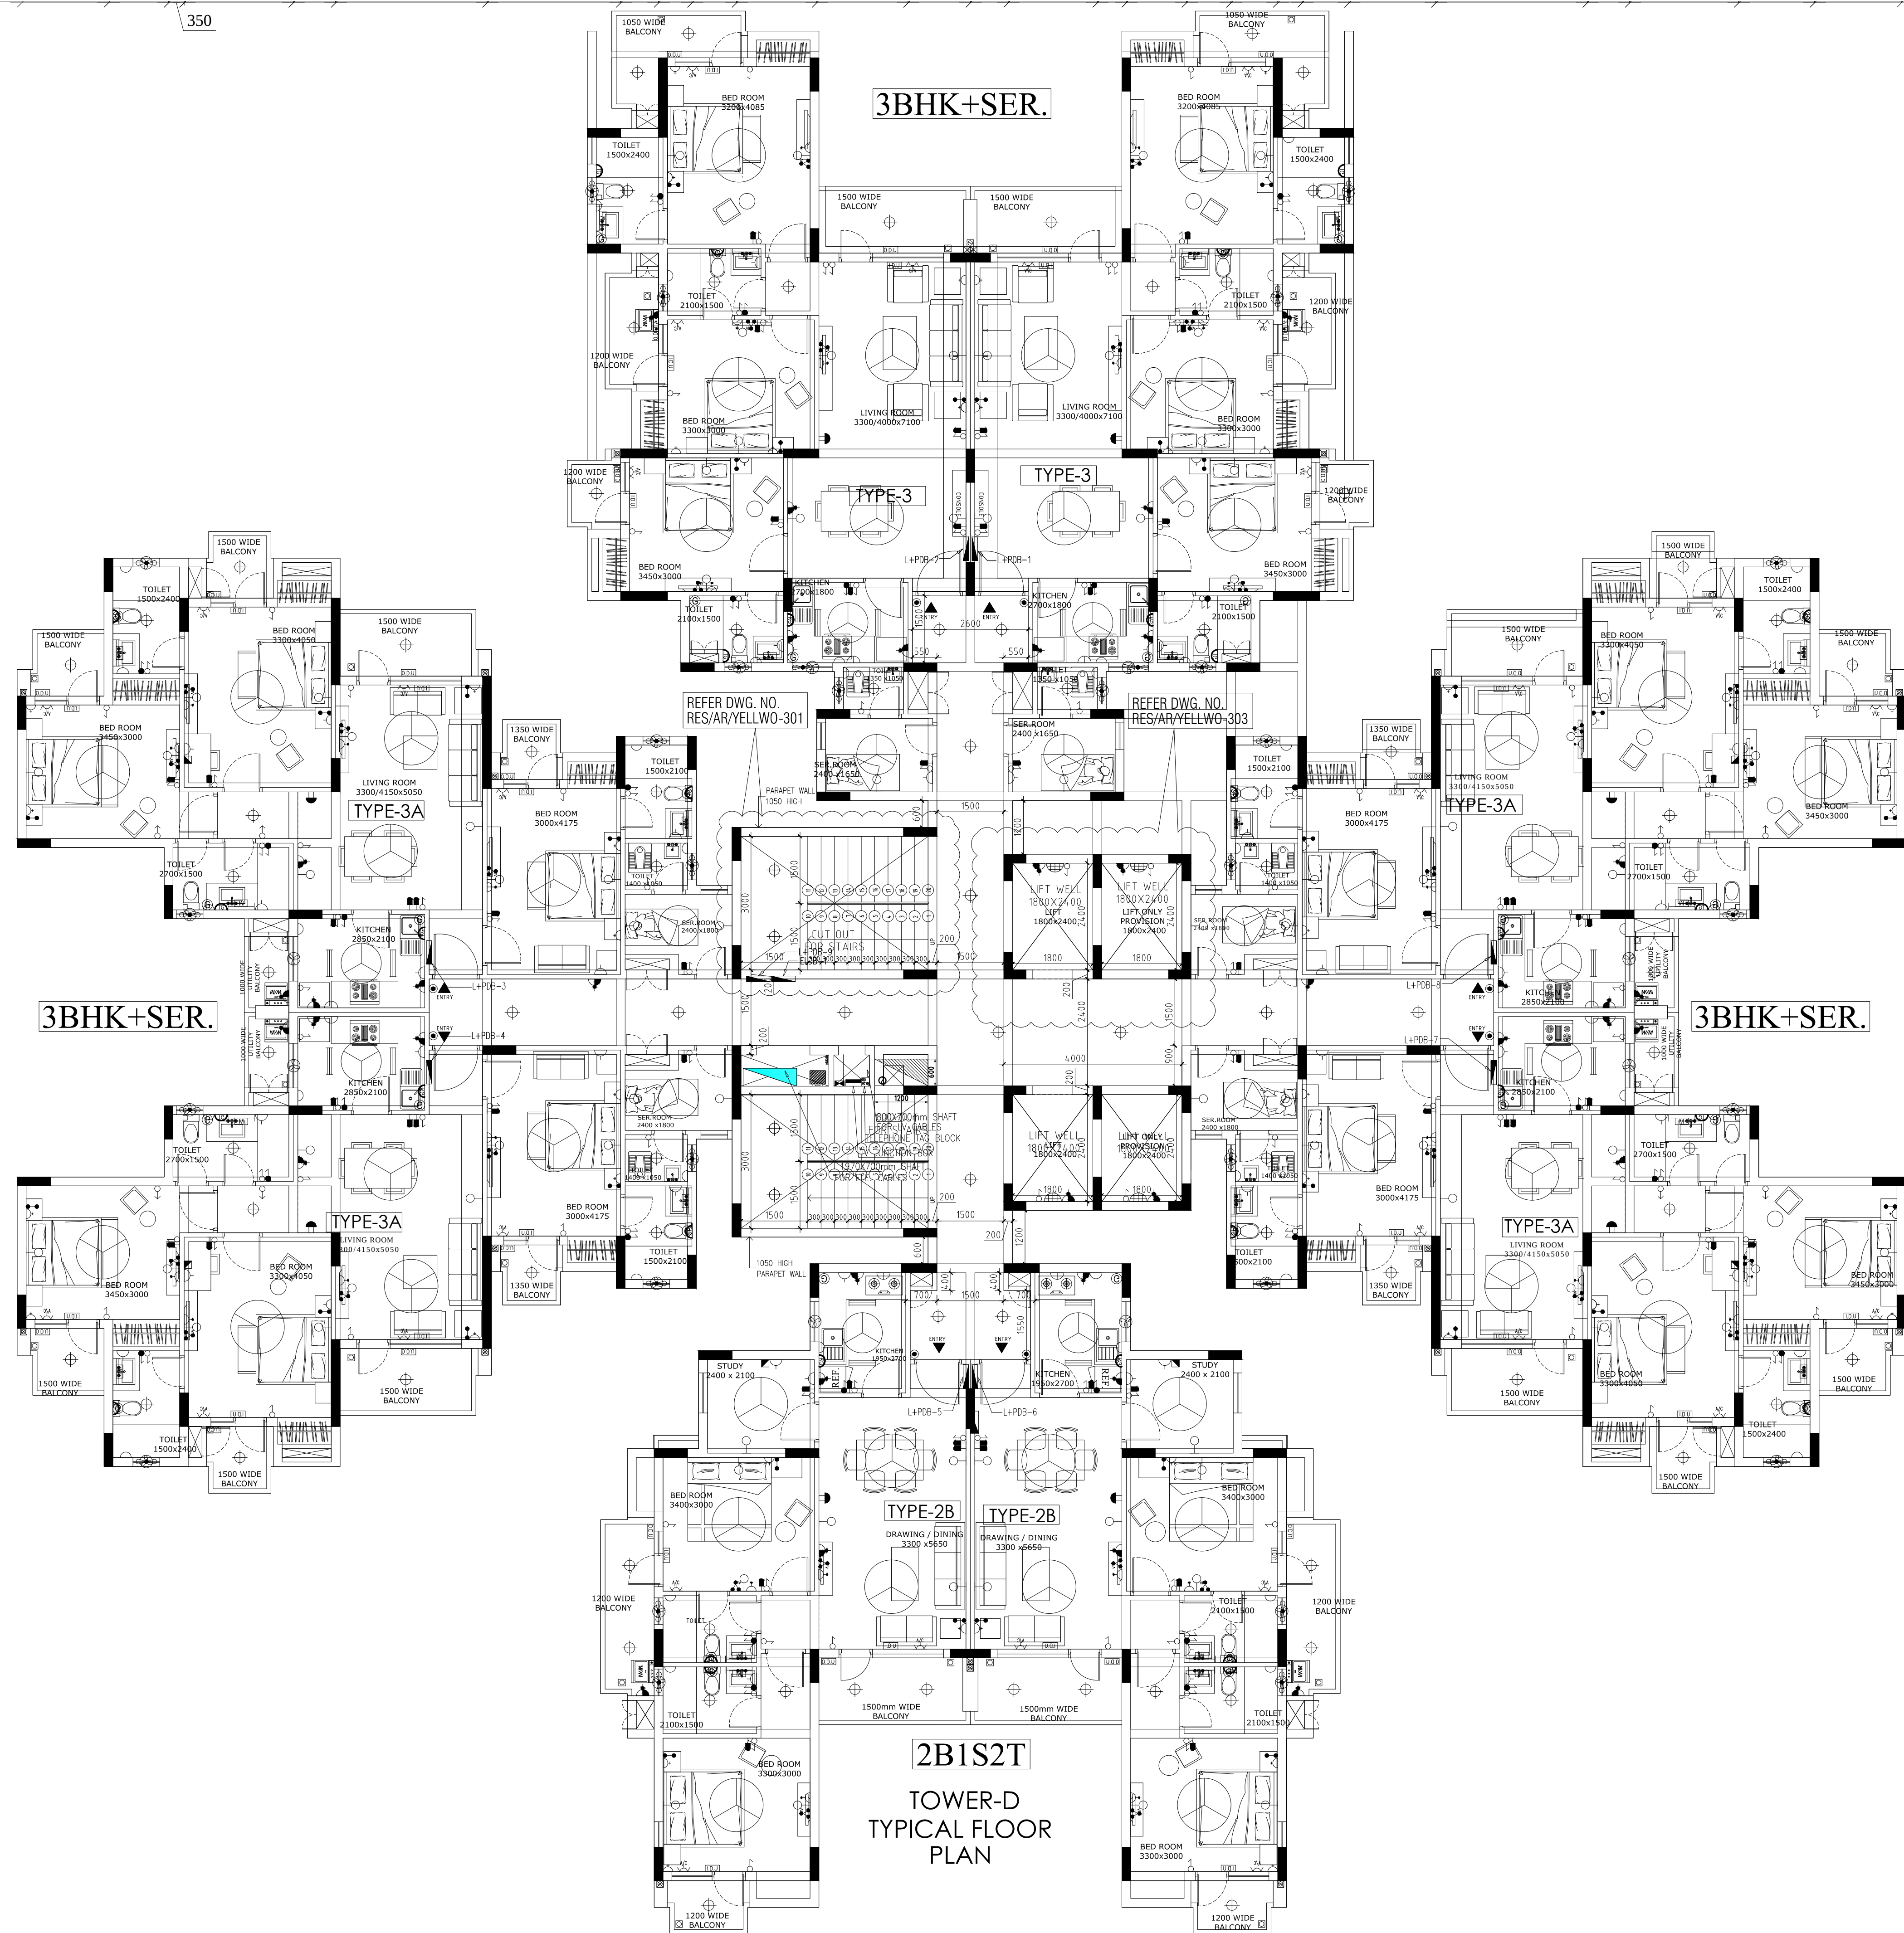

SYMBOL	DESCRIPTION	HEIGHT
⚡	SWITCH BOARD FOR GEYSER	1050 MM
⚡	ONE WAY SWITCH	1050 MM
⚡	TWO WAY SWITCH	1050 MM
⚡	FAN REGULATOR	1050 MM
⚡	2Nos. 6A SOCKET CONTROLLED BY 1 Nos. SWITCH (FOR T.V.)	900 MM
⚡	6A SWITCH SOCKET OUTLET(FOR CHIMNEY)	2150 MM
⚡	6A PLUG POINT	1050 MM
⚡	6/16A POWER POINT	1050 MM
⚡	25AMP SWITCH SOCKET FOR AC	200 MM
⚡	16A SWITCH SOCKET (KITCHEN GYER)	2200 MM
⚡	16A SWITCH SOCKET (TOILET GYER)	1550 MM
⚡	6A PLUG POINT (BED SIDE)	550 MM
⚡	6A, SOCKET AS/DWG	2150 MM
⚡	EXHAUST FAN	2150 MM
⚡	MIRROR LIGHT AT WASHBASIN	2000 MM
⚡	TELEPHONE (BED SIDE)	550 MM
⚡	FINAL DISTRIBUTION BOARD	1500 MM
⚡	CALL BELL BUZZER	2250 MM
⚡	DOOR CALL BELL SWITCH	1050 MM
⚡	CEILING LIGHT	CEILING LIGHT
⚡	WALL MOUNTED FIXTURE	2100 MM
⚡	1X18W T5 TUBE LIGHT	
⚡	TV OUTLET	900 MM
⚡	DATA POINT	
⚡	OUT DOOR UNIT	
⚡	INDOOR UNIT	2250 MM
⚡	1200mm DIA CEILING FAN	CEILING
⚡	900mm DIA CEILING FAN	CEILING
⚡	DG DISPLAY UNIT	AS/DWG
⚡	BULK HEAD LIGHT	1800 MM
⚡	"E" INDICATION ON EMERGENCY LIGHT	
⚡	POWER CONDUIT IN WALL/SLAB	25/32MM DIA
⚡	TV CONDUIT IN SLAB	25/32MM DIA
⚡	TELEPHONE CONDUIT IN SLAB	25/32MM DIA
⚡	PULL BOX IN CEILING SLAB	
⚡	32mm DIA SUBMAIN CONDUIT	25/32MM DIA
⚡	LIGHT CONDUIT IN WALL/SLAB	25/32MM DIA
⚡	EMERGENCY CONDUIT IN WALL/SLAB	25/32MM DIA
⚡	LIGHT LOOPING	
⚡	EMERGENCY LIGHT LOOPING	
⚡	NO. OF CIRCUIT	
⚡	NO. OF SWITCH	
⚡	NAME OF PHASE	
⚡	HOOTER	2200 MM
⚡	CONTROL MODULE	2200 MM
⚡	MANUAL CALL POINT	1050 MM
⚡	ZONE MODULE UNIT	1050 MM

KEY PLAN

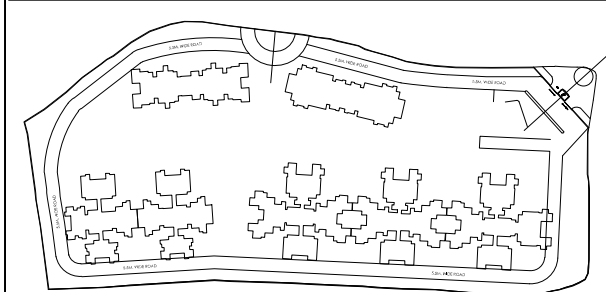

ARCHITECTS

GENRE OF DESIGN
ARCHITECTURE, MASTER PLANNING & INTERIOR DESIGN
A-57, BASEMENT FLOOR, SHIVALIK,
MALVIYA NAGAR, NEW DELHI
TELEPHONE : 011-40574968

M.E.P. CONSULTANT :-

ACROBAT ENGINEERS & ASSOCIATES
H.No. 19/18, Basement Lvl.
Spring Field Colony
Faridabad (Haryana)
Tel : 0129-4056009
customerservice@acrobotengineers.com

PURPOSE OF DRAWING

G.F.C F.I.O TENDER

THIS DRAWING HAS TO BE READ IN CONJUNCTION WITH
DRG. NO.

RES-AR-01 RES-AR-02 RES-AR-03

CLIENT :- HORIZON BUILDCON PVT.LTD.

PROJECT :- HOUSING
SECTOR-86, NOIDA

DRAWING TITLE: TOWER-D
CEILING & WALL POINT LAYOUT

SHEET TITLE: TOWER-D TYPICAL FLOOR ELECTRICAL PLAN

DRG. NO. AEA/P-109/1ST.FL/EL-01

DATE - 12/08/2014 REV. NO NORTH
SCALE - NTS
DETAIL - RAVINDER
CHECKED BY - NK