
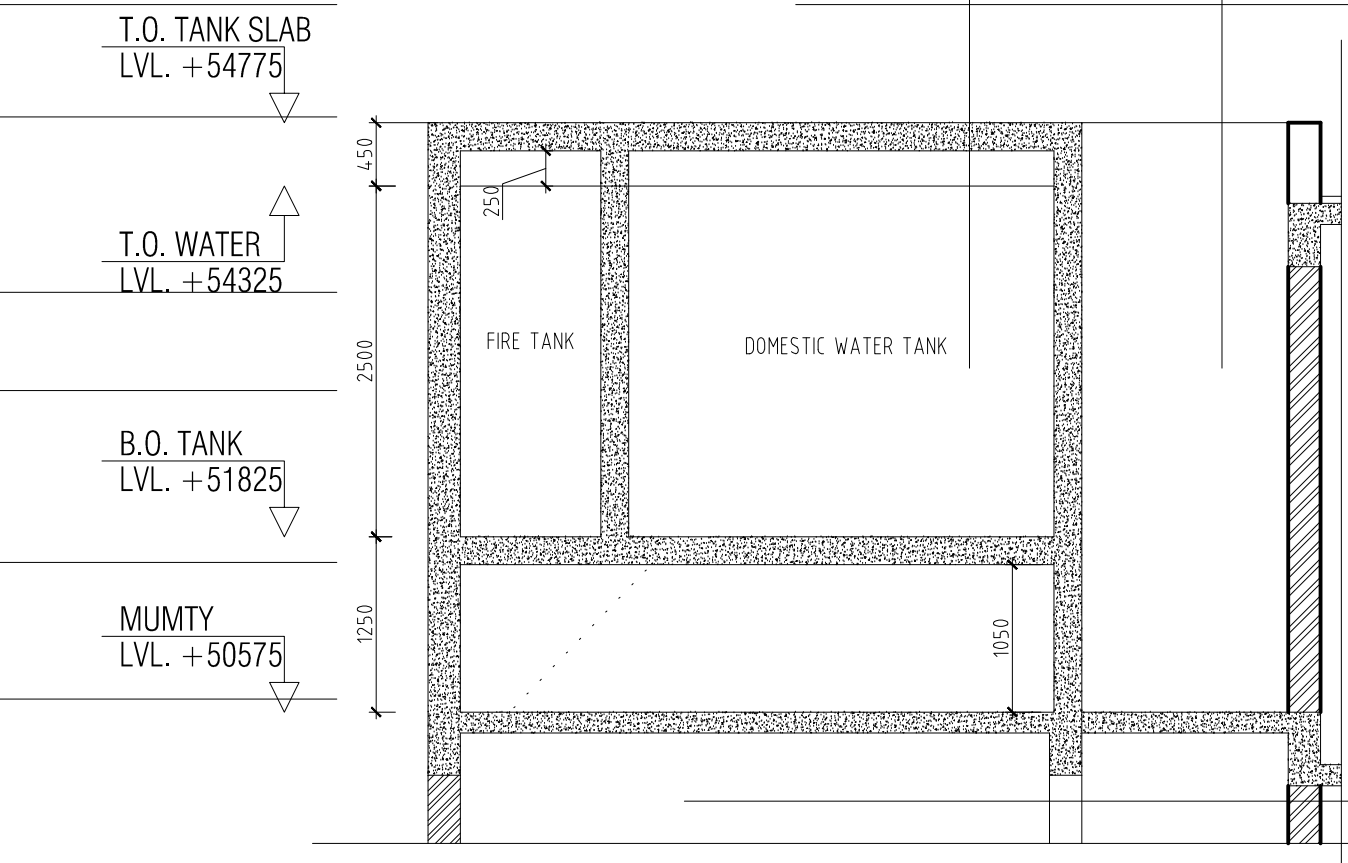
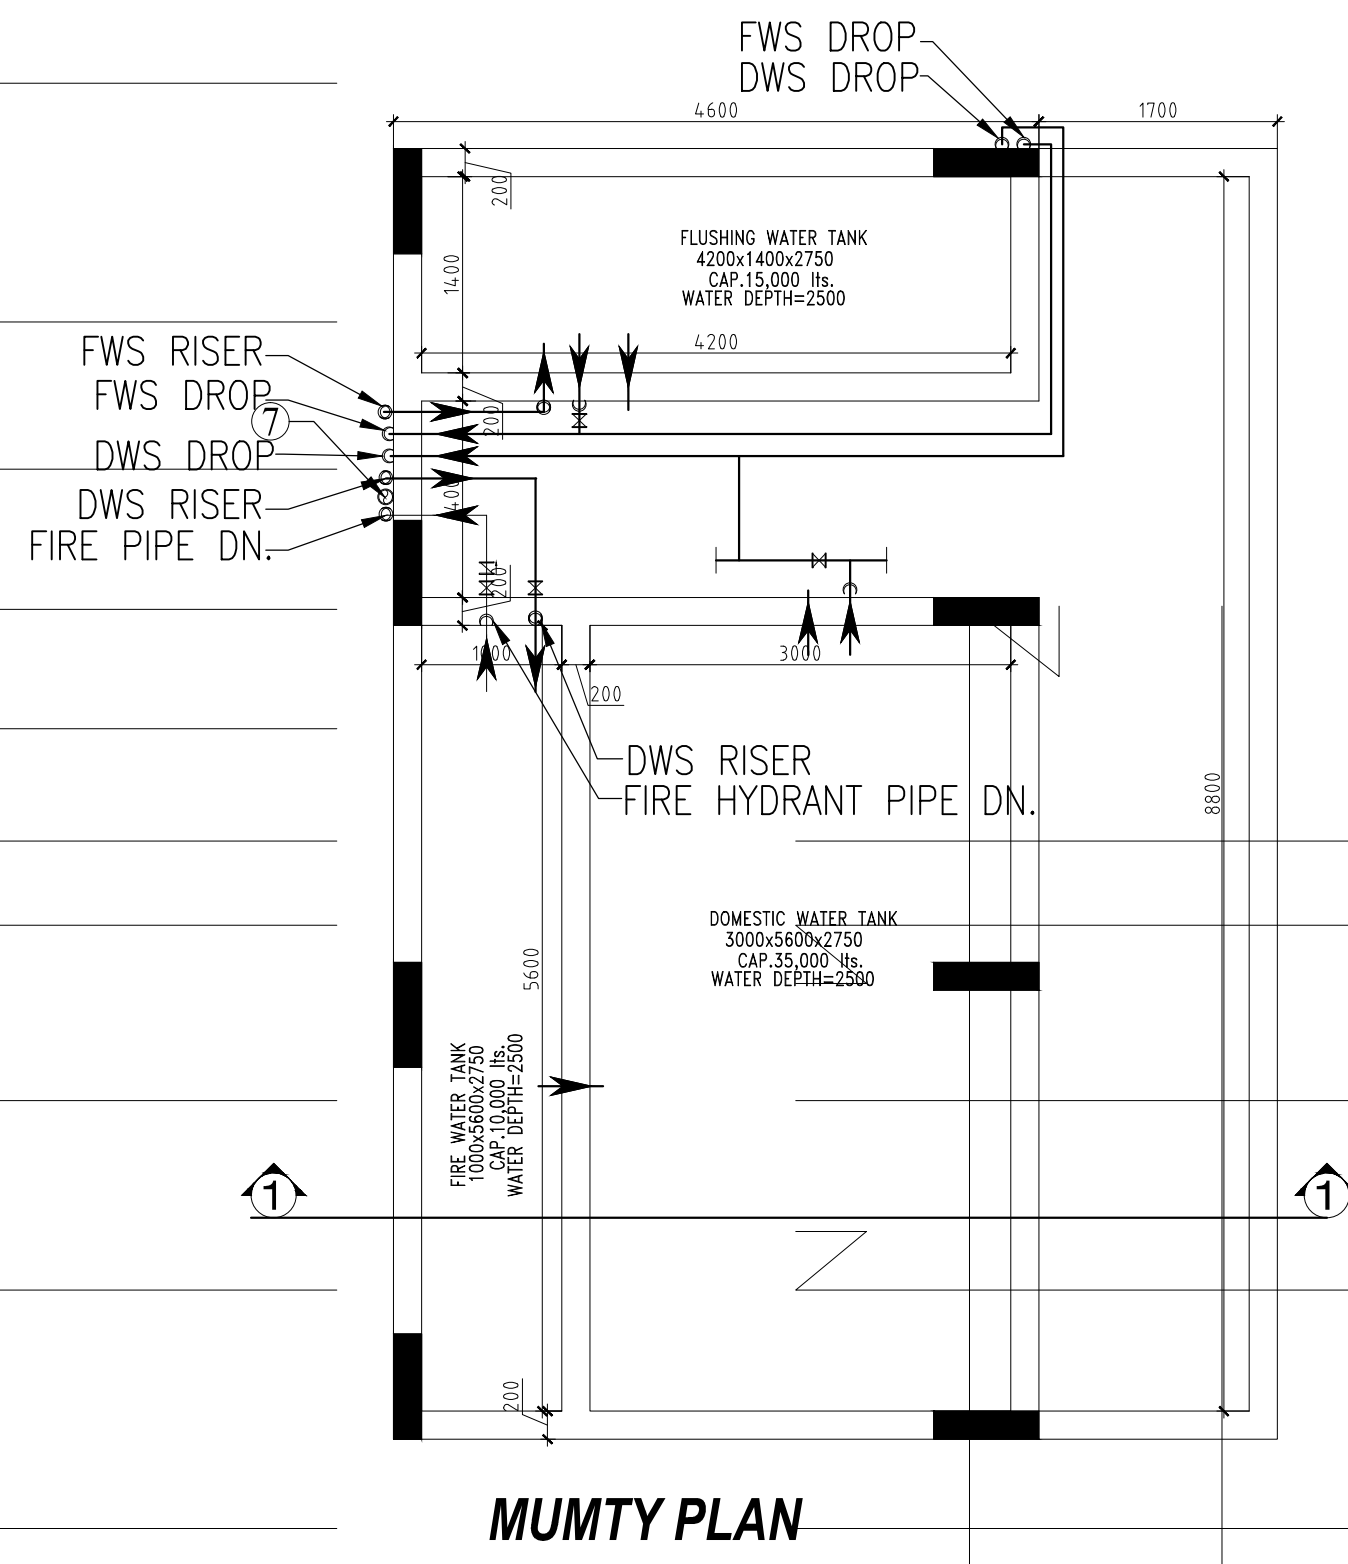


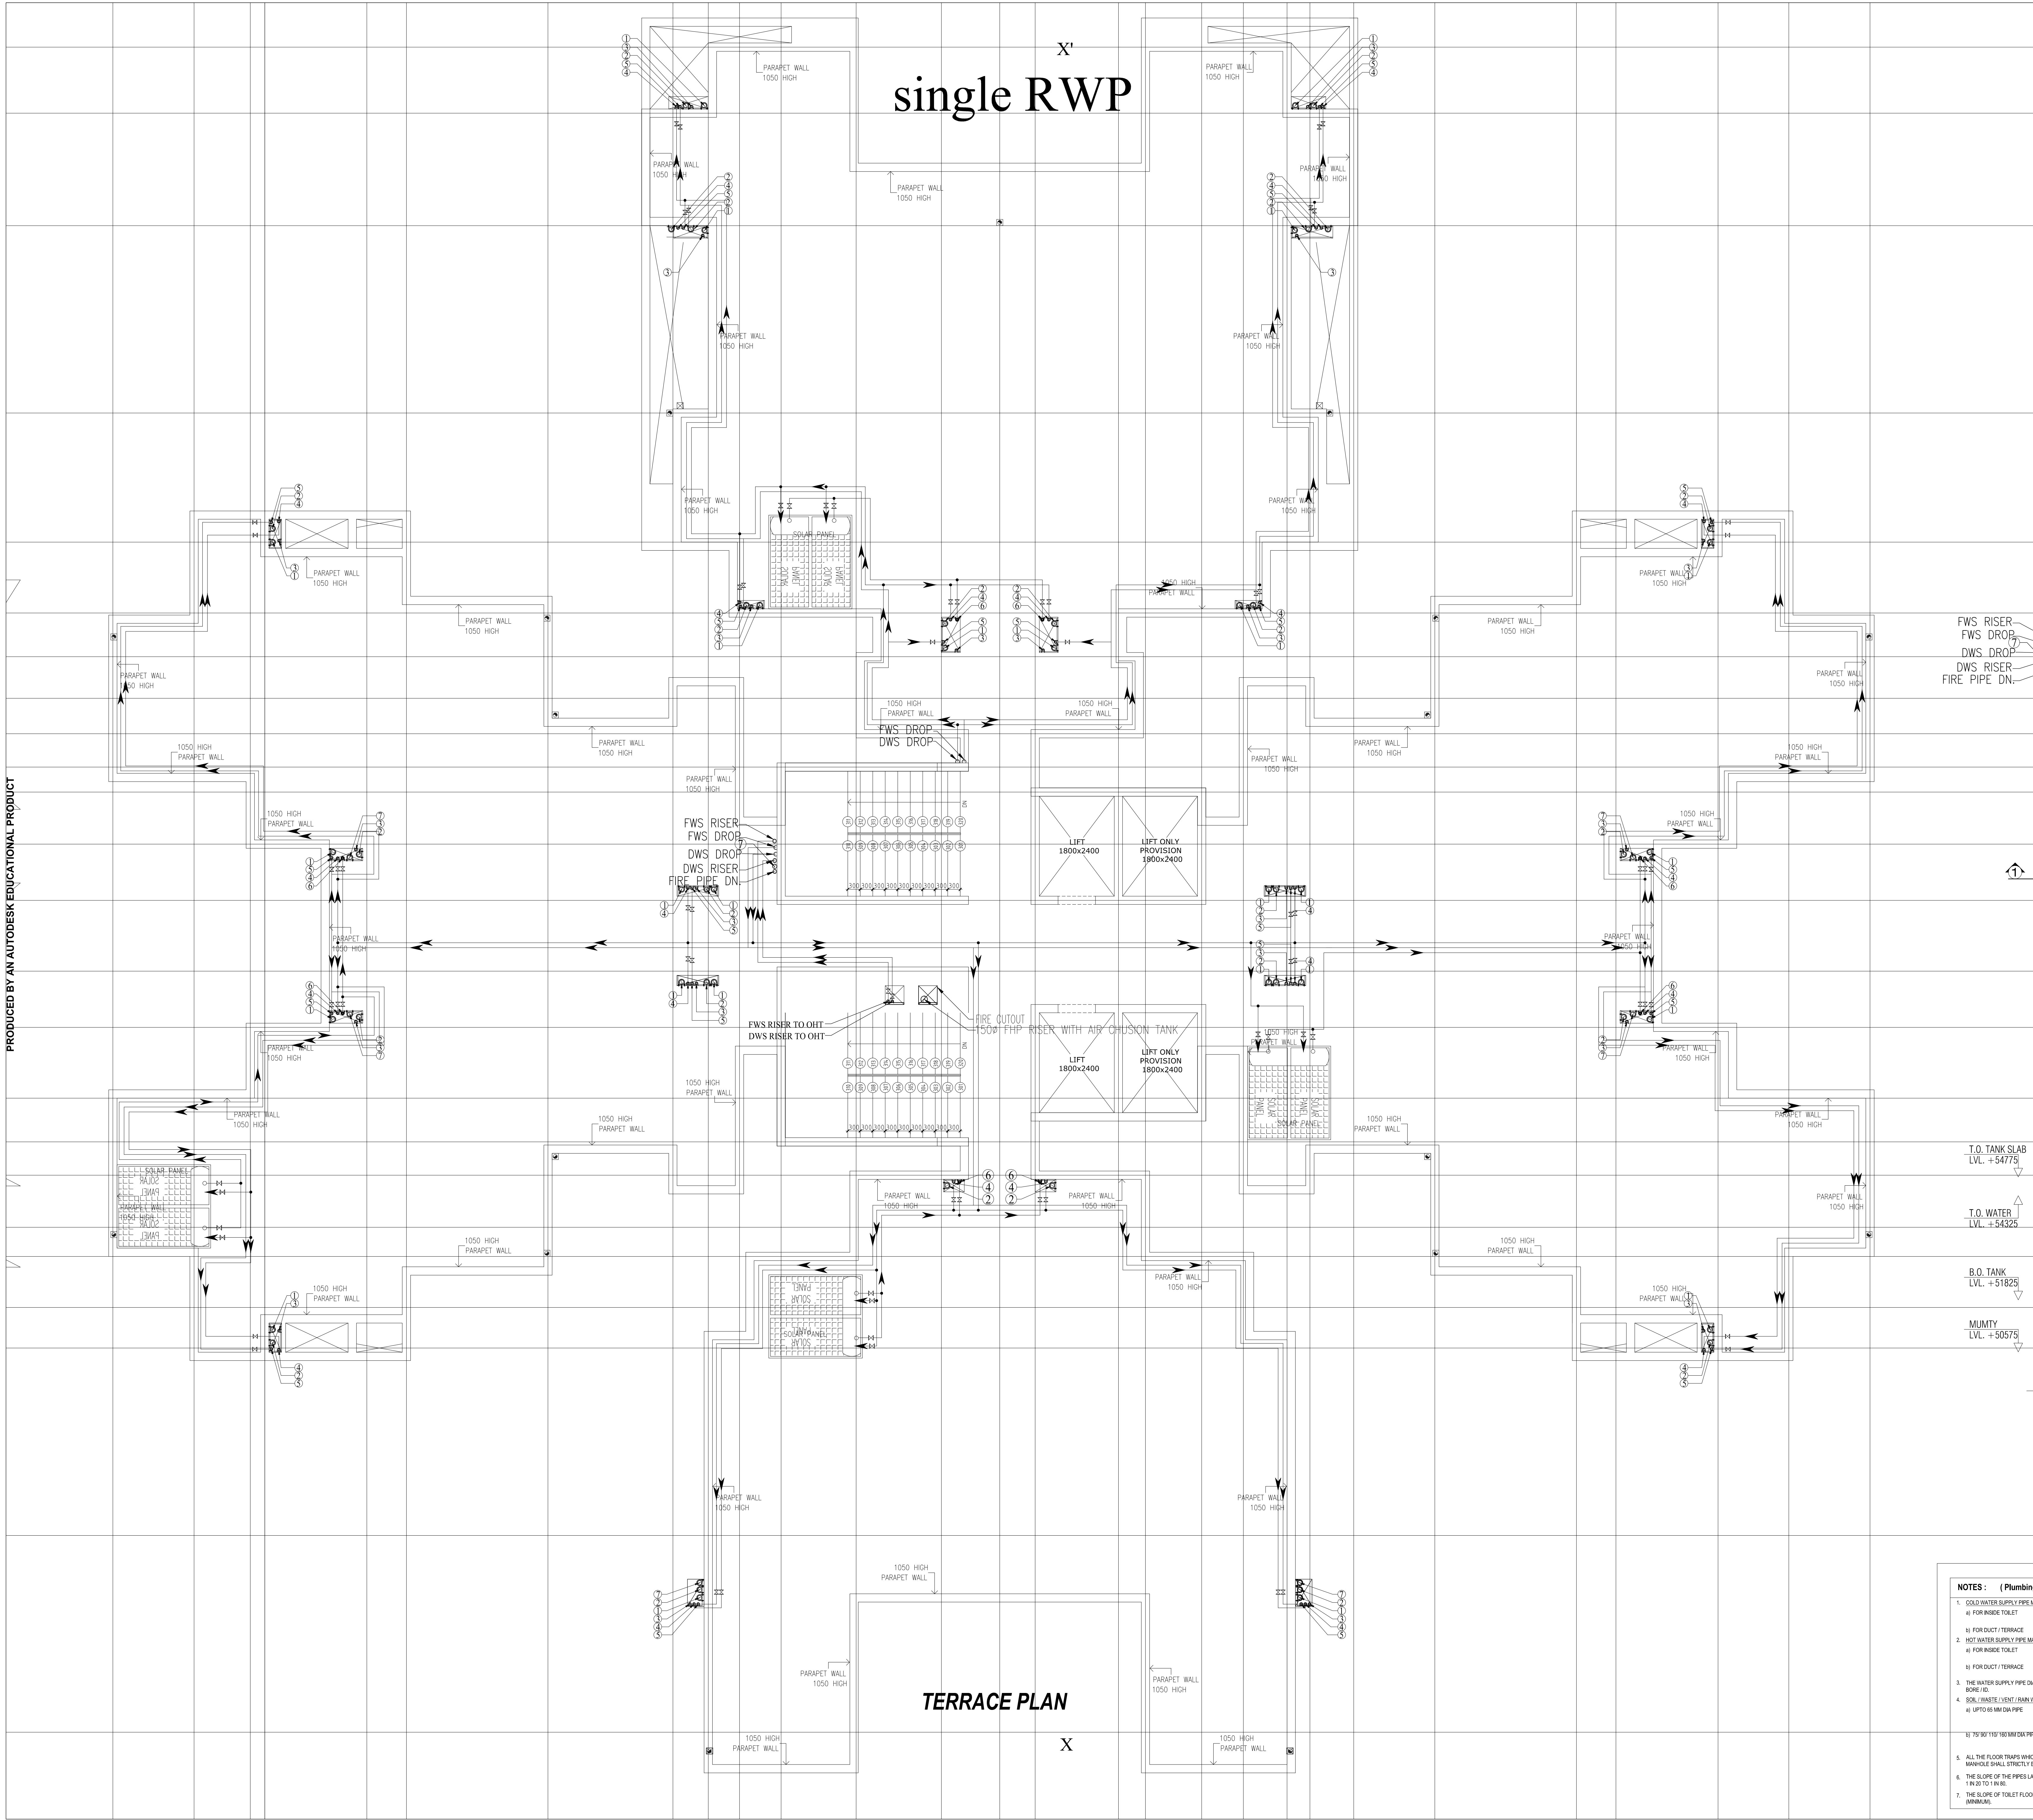

- NOTES : (Plumbing)**
1. THE WATER SUPPLY PIPE MATERIAL SHALL BE 1 IN 1/2 TO 1 IN 2 1/2
 2. THE WATER SUPPLY PIPE MATERIAL SHALL BE 1 IN 1/2 TO 1 IN 2 1/2
 3. THE WATER SUPPLY PIPE MATERIAL SHALL BE 1 IN 1/2 TO 1 IN 2 1/2
 4. THE WATER SUPPLY PIPE MATERIAL SHALL BE 1 IN 1/2 TO 1 IN 2 1/2
 5. THE WATER SUPPLY PIPE MATERIAL SHALL BE 1 IN 1/2 TO 1 IN 2 1/2
 6. THE WATER SUPPLY PIPE MATERIAL SHALL BE 1 IN 1/2 TO 1 IN 2 1/2
 7. THE WATER SUPPLY PIPE MATERIAL SHALL BE 1 IN 1/2 TO 1 IN 2 1/2
 8. THE WATER SUPPLY PIPE MATERIAL SHALL BE 1 IN 1/2 TO 1 IN 2 1/2
 9. THE WATER SUPPLY PIPE MATERIAL SHALL BE 1 IN 1/2 TO 1 IN 2 1/2
 10. THE WATER SUPPLY PIPE MATERIAL SHALL BE 1 IN 1/2 TO 1 IN 2 1/2
 11. THE WATER SUPPLY PIPE MATERIAL SHALL BE 1 IN 1/2 TO 1 IN 2 1/2

PLUMBING LEGEND:-

①	1100 UPVC SOIL & VENT PIPE
②	1100 UPVC PIPE WASTE & VENT PIPE
③	630 UPVC ANTISYPHONAGE PIPE
④	DWS DN.TAKE
⑤	FWS DN.TAKE
⑥	HWS DN.TAKE
⑦	110 UPVC PIPE RAIN WATER.
DWS	= DOMESTIC WATER SUPPLY
FWS	= FLUSHING WATER SUPPLY
HWS	= HOT WATER SUPPLY
FT	= FLOOR TRAP
FD	= FLOOR DRAIN
AT	= ABLUTION TAP
SH	= SHOWER
SP	= SOIL PIPE
WP	= WASTE PIPE
COP	= CLEAN OUT PLUG
FG	= FLOOR GRATING

DETAIL OF PIPE CONNECTIONS

FROM WC TO STACK 1100 UPVC SOIL PIPE
FROM UT TO STACK 1100 UPVC SOIL PIPE
FROM FT TO STACK 1100 UPVC WASTE PIPE
FROM URINAL WASTE TO UT 500 UPVC PIPE
FROM WB WASTE TO FT 400 UPVC PIPE
FROM SINK WASTE TO FT 500 UPVC PIPE

PURPOSE OF DRAWING

G.F.C	F.I.O	TENDER
-------	-------	--------

THIS DRAWING HAS TO BE READ IN CONJUNCTION WITH DRG. NO.

RES-AR-01	RES-AR-02	RES-AR-03
-----------	-----------	-----------

CLIENT :- HORIZON BUILDCON PVT.LTD.

PROJECT :- HOUSING SECTOR-86, NOIDA

SHEET TITLE TOWER-D TERRACE PLAN WATER SUPPLY LAYOUT

DRG. NO. RES-TW-D-109-PL-T-R-C

DATE	18/09/2013	REV. NO		NORTH
SCALE	1:75			
DEALT	SK			

CHECKED BY: AG ARCHITECTS

GENRE OF DESIGN ARCHITECTURE, MASTER PLANNING & INTERIOR DESIGN

A-51, BASMENT FLOOR, CHAWAL, WALIYA NAGAR, NEW DELHI

TELEPHONE: 011-40574968

M&P SERVICES CONSULTANTS

ACROBAT ENGINEERS & ASSOCIATES

A/No. 19, Block 18, Basement level, Spring field colony Sector-35

Paridbab-121002

Email id- customerservice@acrobotengineers.com