


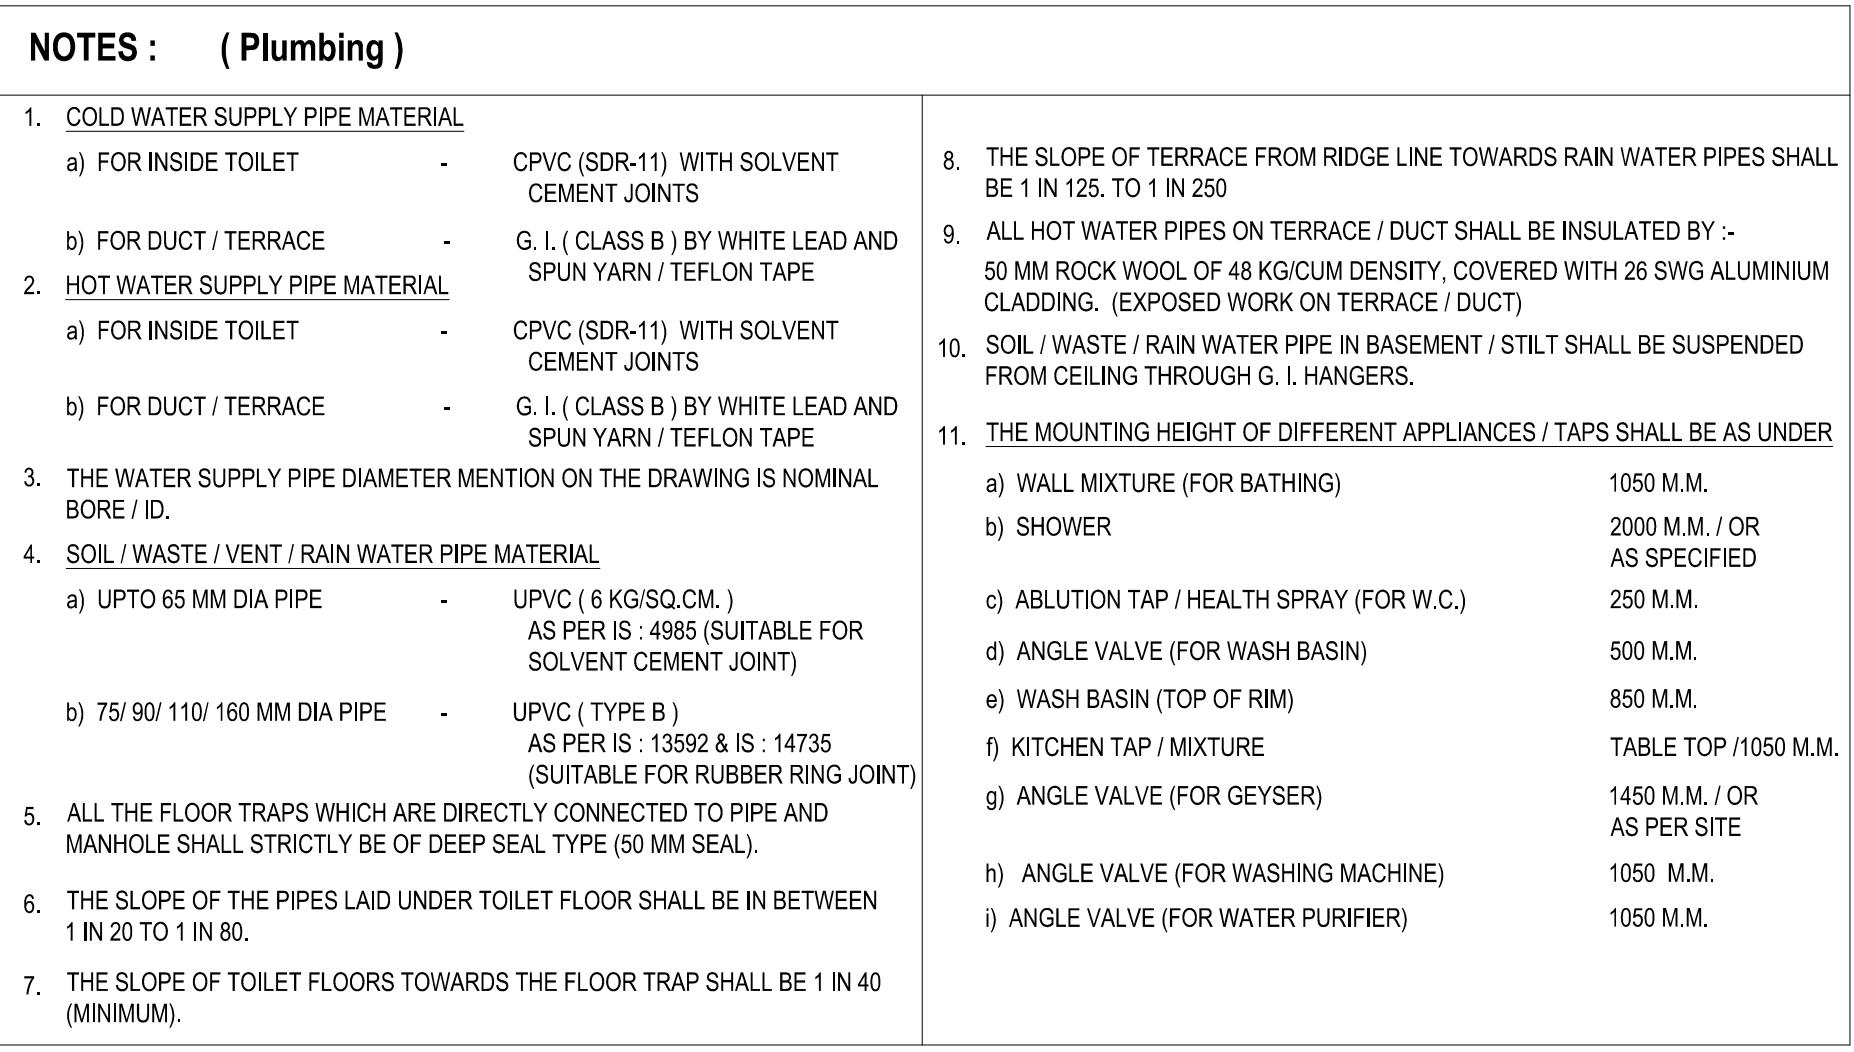

PLUMBING LEGEND:-	
①	110B UPVC SOIL & VENT PIPE
②	110B UPVC PIPE WASTE & VENT PIPE
③	630 UPVC ANTISYPHONAGE PIPE
④	DWS DN.TAKE
⑤	FWS DN.TAKE
⑥	HWS DN.TAKE
⑦	110 UPVC PIPE RAIN WATER.
DWS = DOMESTIC WATER SUPPLY	
FWS = FLUSHING WATER SUPPLY	
HWS = HOT WATER SUPPLY	
FT = FLOOR TRAP	
FD = FLOOR DRAIN	
AT = ABLUTION TAP	
SH = SHOWER	
SP = SOIL PIPE	
WP = WASTE PIPE	
COP = CLEAN OUT PLUG	
FG = FLOOR GRATING	
_____	FWS PIPE
_____	DWS PIPE
_____	HWS PIPE
_____	WASTE PIPE
_____	SOIL PIPE
DETAIL OF PIPE CONNECTIONS	
FROM WC TO STACK 110B UPVC SOIL PIPE	
FROM UT TO STACK 110B UPVC SOIL PIPE	
FROM FT TO STACK 110B UPVC WASTE PIPE	
FROM URINAL WASTE TO UT 50B UPVC PIPE	
FROM WB WASTE TO FT 40B UPVC PIPE	
FROM SINK WASTE TO FT 50B UPVC PIPE	

2		
1	column sizes	14.12.12
REV.NO.	REVISION	DATE

PURPOSE OF DRAWING	
--------------------	--



THIS DRAWING HAS TO BE READ IN CONJUNCTION WITH
DRG. NO.

```

graph LR
    A[RES=AR-01] --> B[RES=AR-02]
    B --> C[RES=AR-03]
    C --> D[ ]

```

CLIENT :- HORIZON BUILDCON PVT.LTD.

PROJECT :-	HOUSING SECTOR-86, NOIDA
SHEET TITLE	TOWER-E 2ND / 6TH / 9TH & TOWER-E STILE FLOOR PLAN WATER SUPPLY LAYOUT

DRG. NO. RES-TW-E-109-PL-TYFP-02			
DATE -	21/09/2013	REV. NO	NORTH
SCALE -	1:75	R0	
DEALT -	SK		
CHECKED BY -	AG		
APPROVED			

GENRE OF DESIGN
ARCHITECTURE, MASTER PLANNING & INTERIOR DESIGN
A-57, BASEMENT FLOOR, SHIVALIK
MULYANAGAR, NEW DELHI
TELEPHONE : 011-40574968

MEP SERVICES CONSULTANTS
ACROBAT ENGINEERS & ASSOCIATES
H.No. 19, Block 18, Basement level,
Spring field colony ,Sector -31,
Faridabad-121002
Email id- customerservice@acrobatengeers.com