



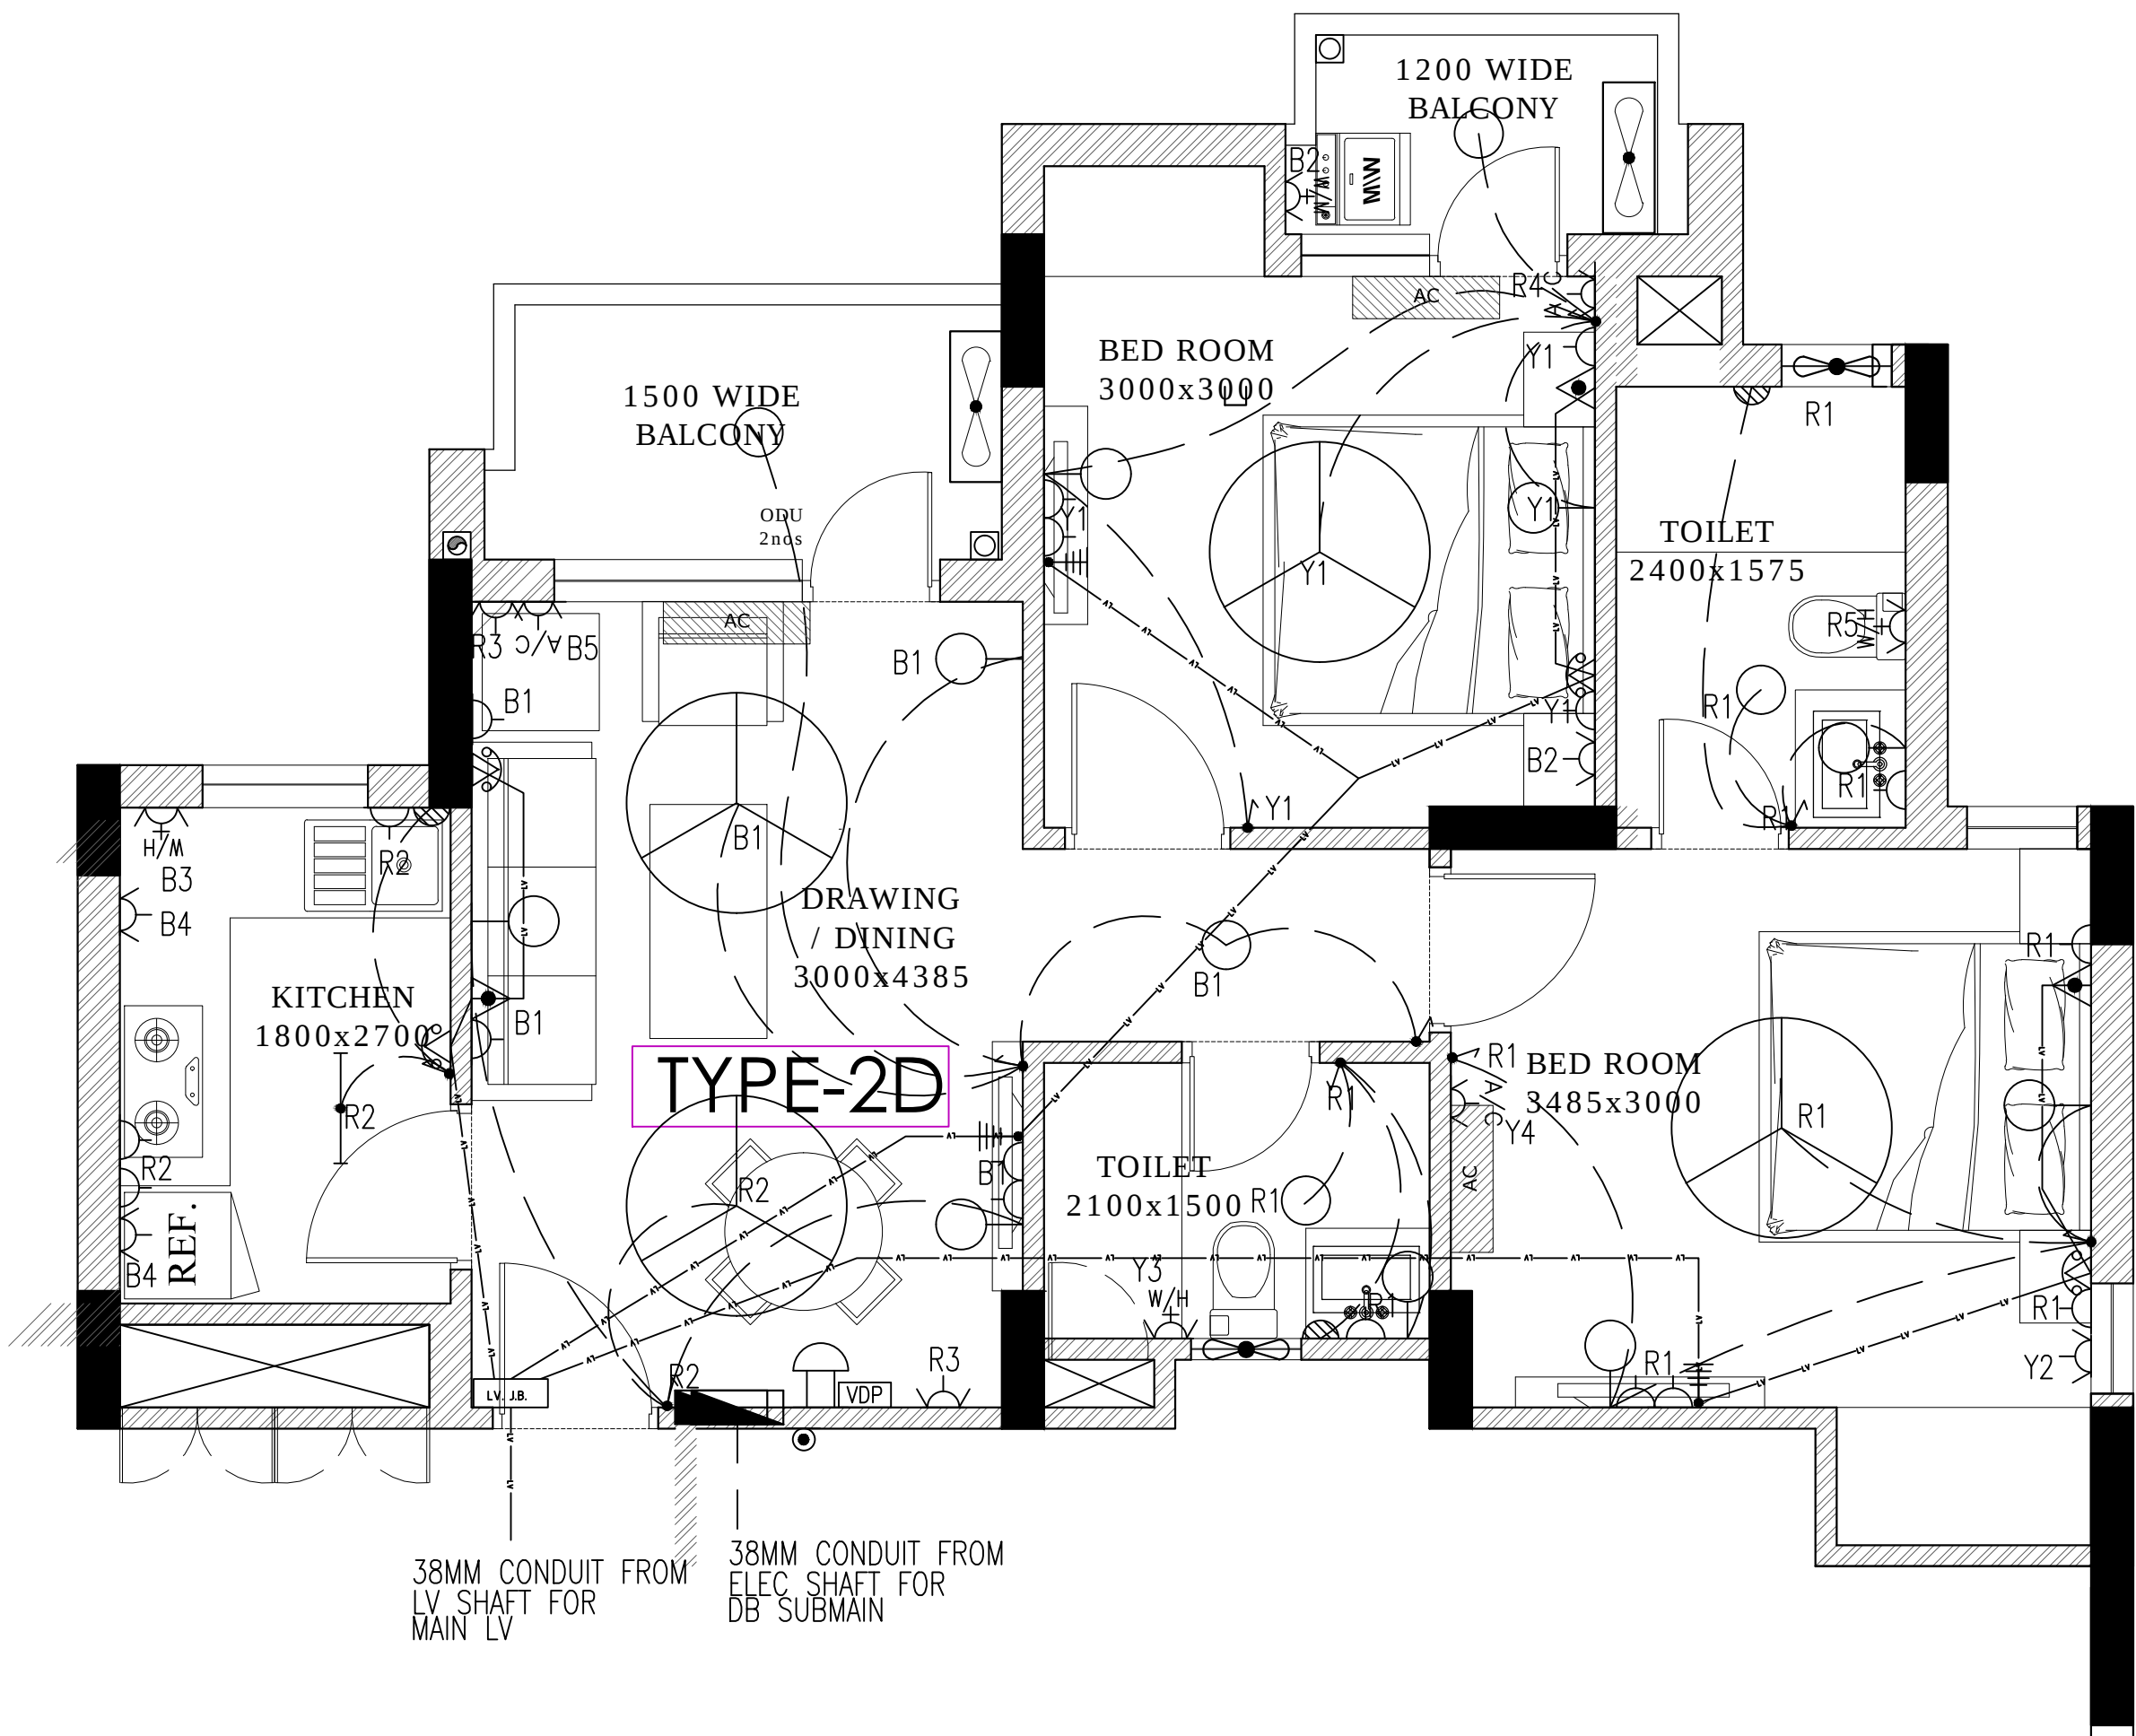

TYPICAL TYPE 2 D FLAT ELECTRICAL LAYOUT

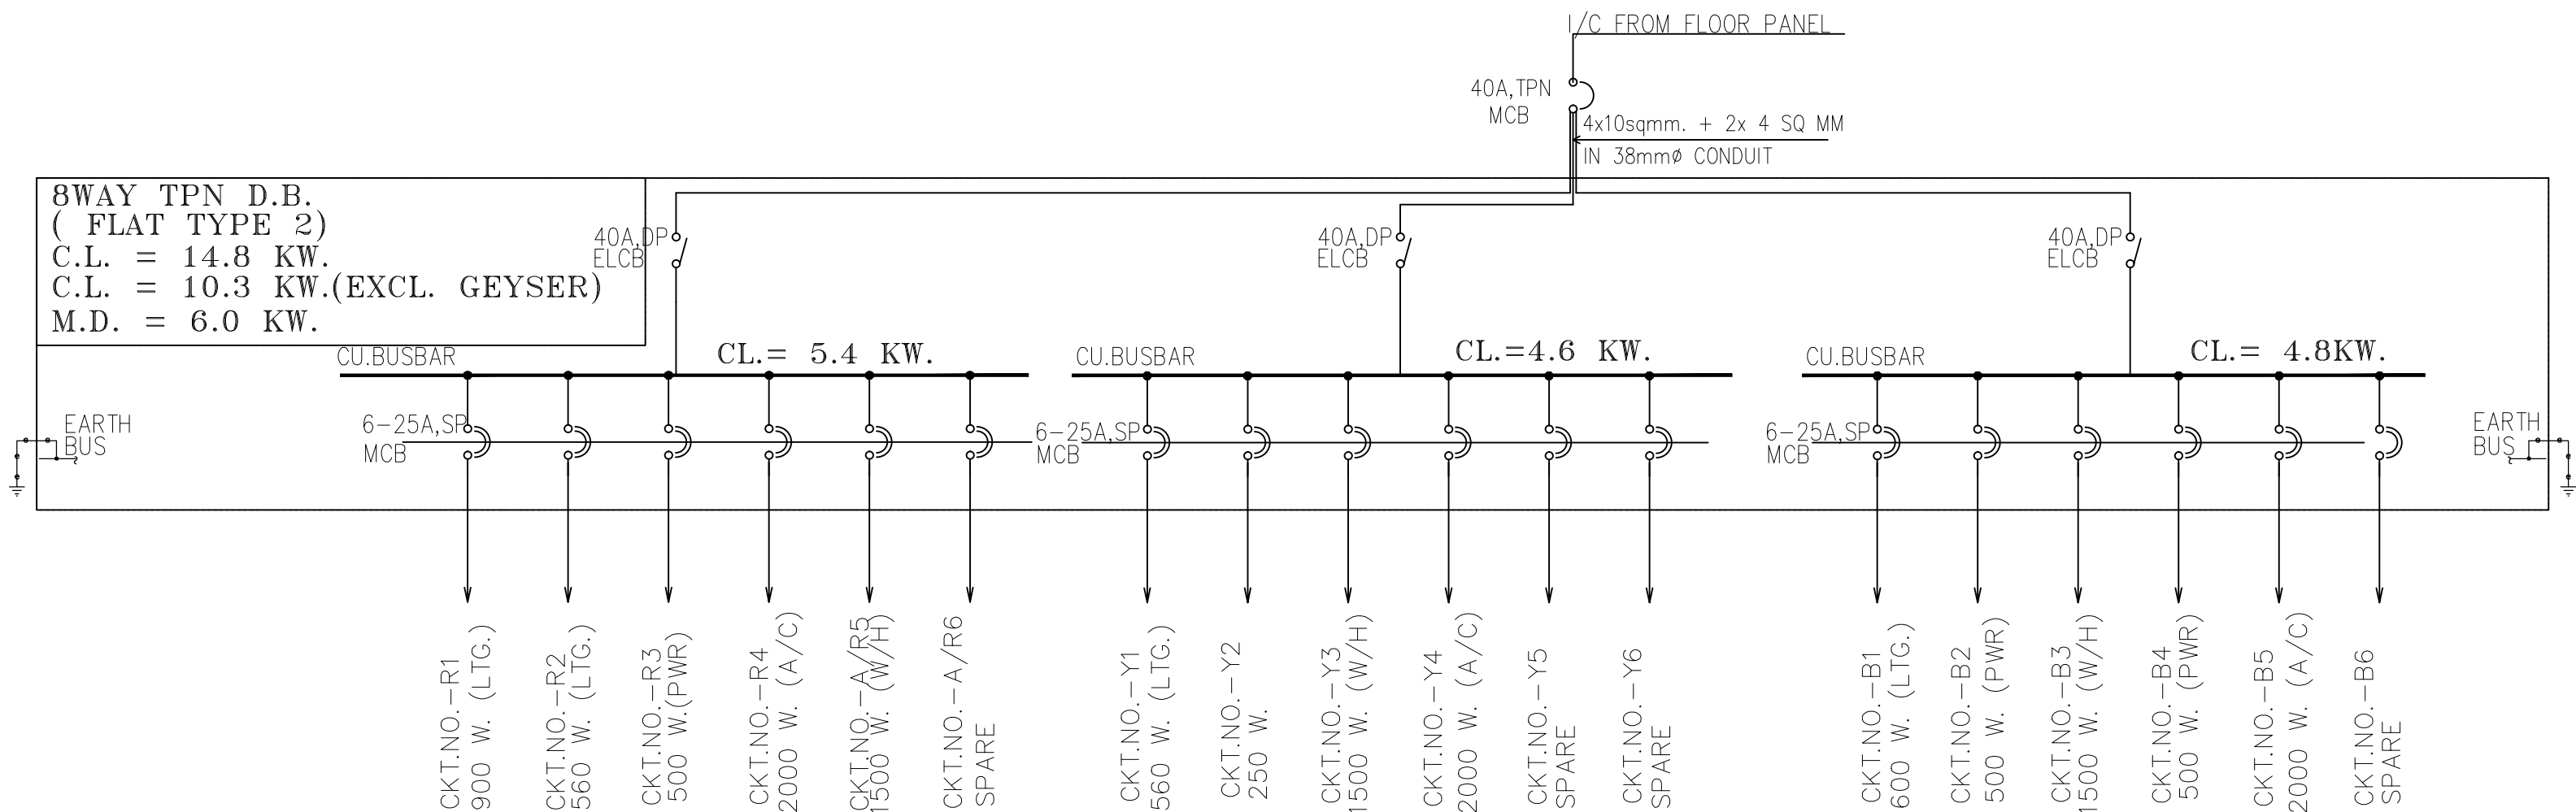

DB DETAILS

LEGEND:-

SYB.	DESCRIPTION	MOUNTING HEIGHT FROM FIN. FLR. LVL. IN mm. UP TO BOTTOM SWITCH PLATE/ AS PER SITE REQUIRED.
	6A SWITCH FOR CONTROL OF LIGHTS & FANS.	1000
	6A. 2/3PIN SOCKET OUTLET WITH 6A. SWITCH.	350
	16A. 6PIN SOCKET OUTLET WITH 16A. SWITCH.	350
	16A. 6PIN SOCKET OUTLET WITH 16A. SWITCH FOR GEYSER.	AS PER TILE LYT
	DATA OUTLET	350
	TV ANTENNA (COAXIAL TV OUTLET).	350
	20A. 3 PIN SOCKET OUTLET WITH 20A. SINGLE PHASE SWITCH.	AS PER IDU
	TELEPHONE OUTLET (RJ-11).	350
	BELL PUSH.	1000
	CALL BELL/ BUZZER.	2400
	LV JUNCTION BOX CEILING	ON CEILING
	WALL LIGHT FIXTURE.	2100
	6A. 3PIN SOCKET OUTLET CONTROLLED WITH 6A SWITCH ON SWITCHBOARD NEAR DOOR	NEAR EQUIPMENT
	CEILING LIGHT FIXTURE.	ON CEILING
	CEILING MOUNTED FLUORESCENT LIGHT FIXTURE	ON CEILING
	WALL MOUNTED FLUORESCENT LIGHT FIXTURE.	2100
	VIDEO DOOR PHONE	1000
	16A. 3PIN SOCKET OUTLET WITH 16A. SWITCH FOR WASHING MACHINE.	750
	DISTRIBUTION BOARD (DB).	1800(TOP)
	LV CONDUIT	

PLEASE READ THIS DRAWING
WITH TYPICAL FLOOR ELEC LYT
DRAWING NO. RES/EL/RED-104/1

REV.NO.	REVISION	DATE						
PURPOSE OF DRAWING G.F.C F.I.O TENDER THIS DRAWING HAS TO BE READ IN CONJUNCTION WITH DRG. NO. RES-AR-01 RES-AR-02 RES-AR-03 RES/EL/RED-104 CLIENT :- HORIZON BUILDCON PVT.LTD. PROJECT :- HOUSING SECTOR-86, NOIDA SHEET TITLE TYPICAL TYPE 2D FLAT ELECTRIC LAYOUT AND DB DETAILS (TOWER) DRG. NO. RES/EL/RED-104/4 <table><tr><td>DATE - 17/05/2013</td><td rowspan="4">REV. NO R0</td><td rowspan="4"></td></tr><tr><td>SCALE - NTS</td></tr><tr><td>DEALT -</td></tr><tr><td>CHECKED BY - POONAM</td></tr></table> ARCHITECTS GENRE OF DESIGN ARCHITECTURE, MASTER PLANNING & INTERIOR DESIGN A-57, BASEMENT FLOOR, SHIVALIK, MALVIYA NAGAR, NEW DELHI TELEPHONE : 011-40574968			DATE - 17/05/2013	REV. NO R0		SCALE - NTS	DEALT -	CHECKED BY - POONAM
DATE - 17/05/2013	REV. NO R0							
SCALE - NTS								
DEALT -								
CHECKED BY - POONAM								