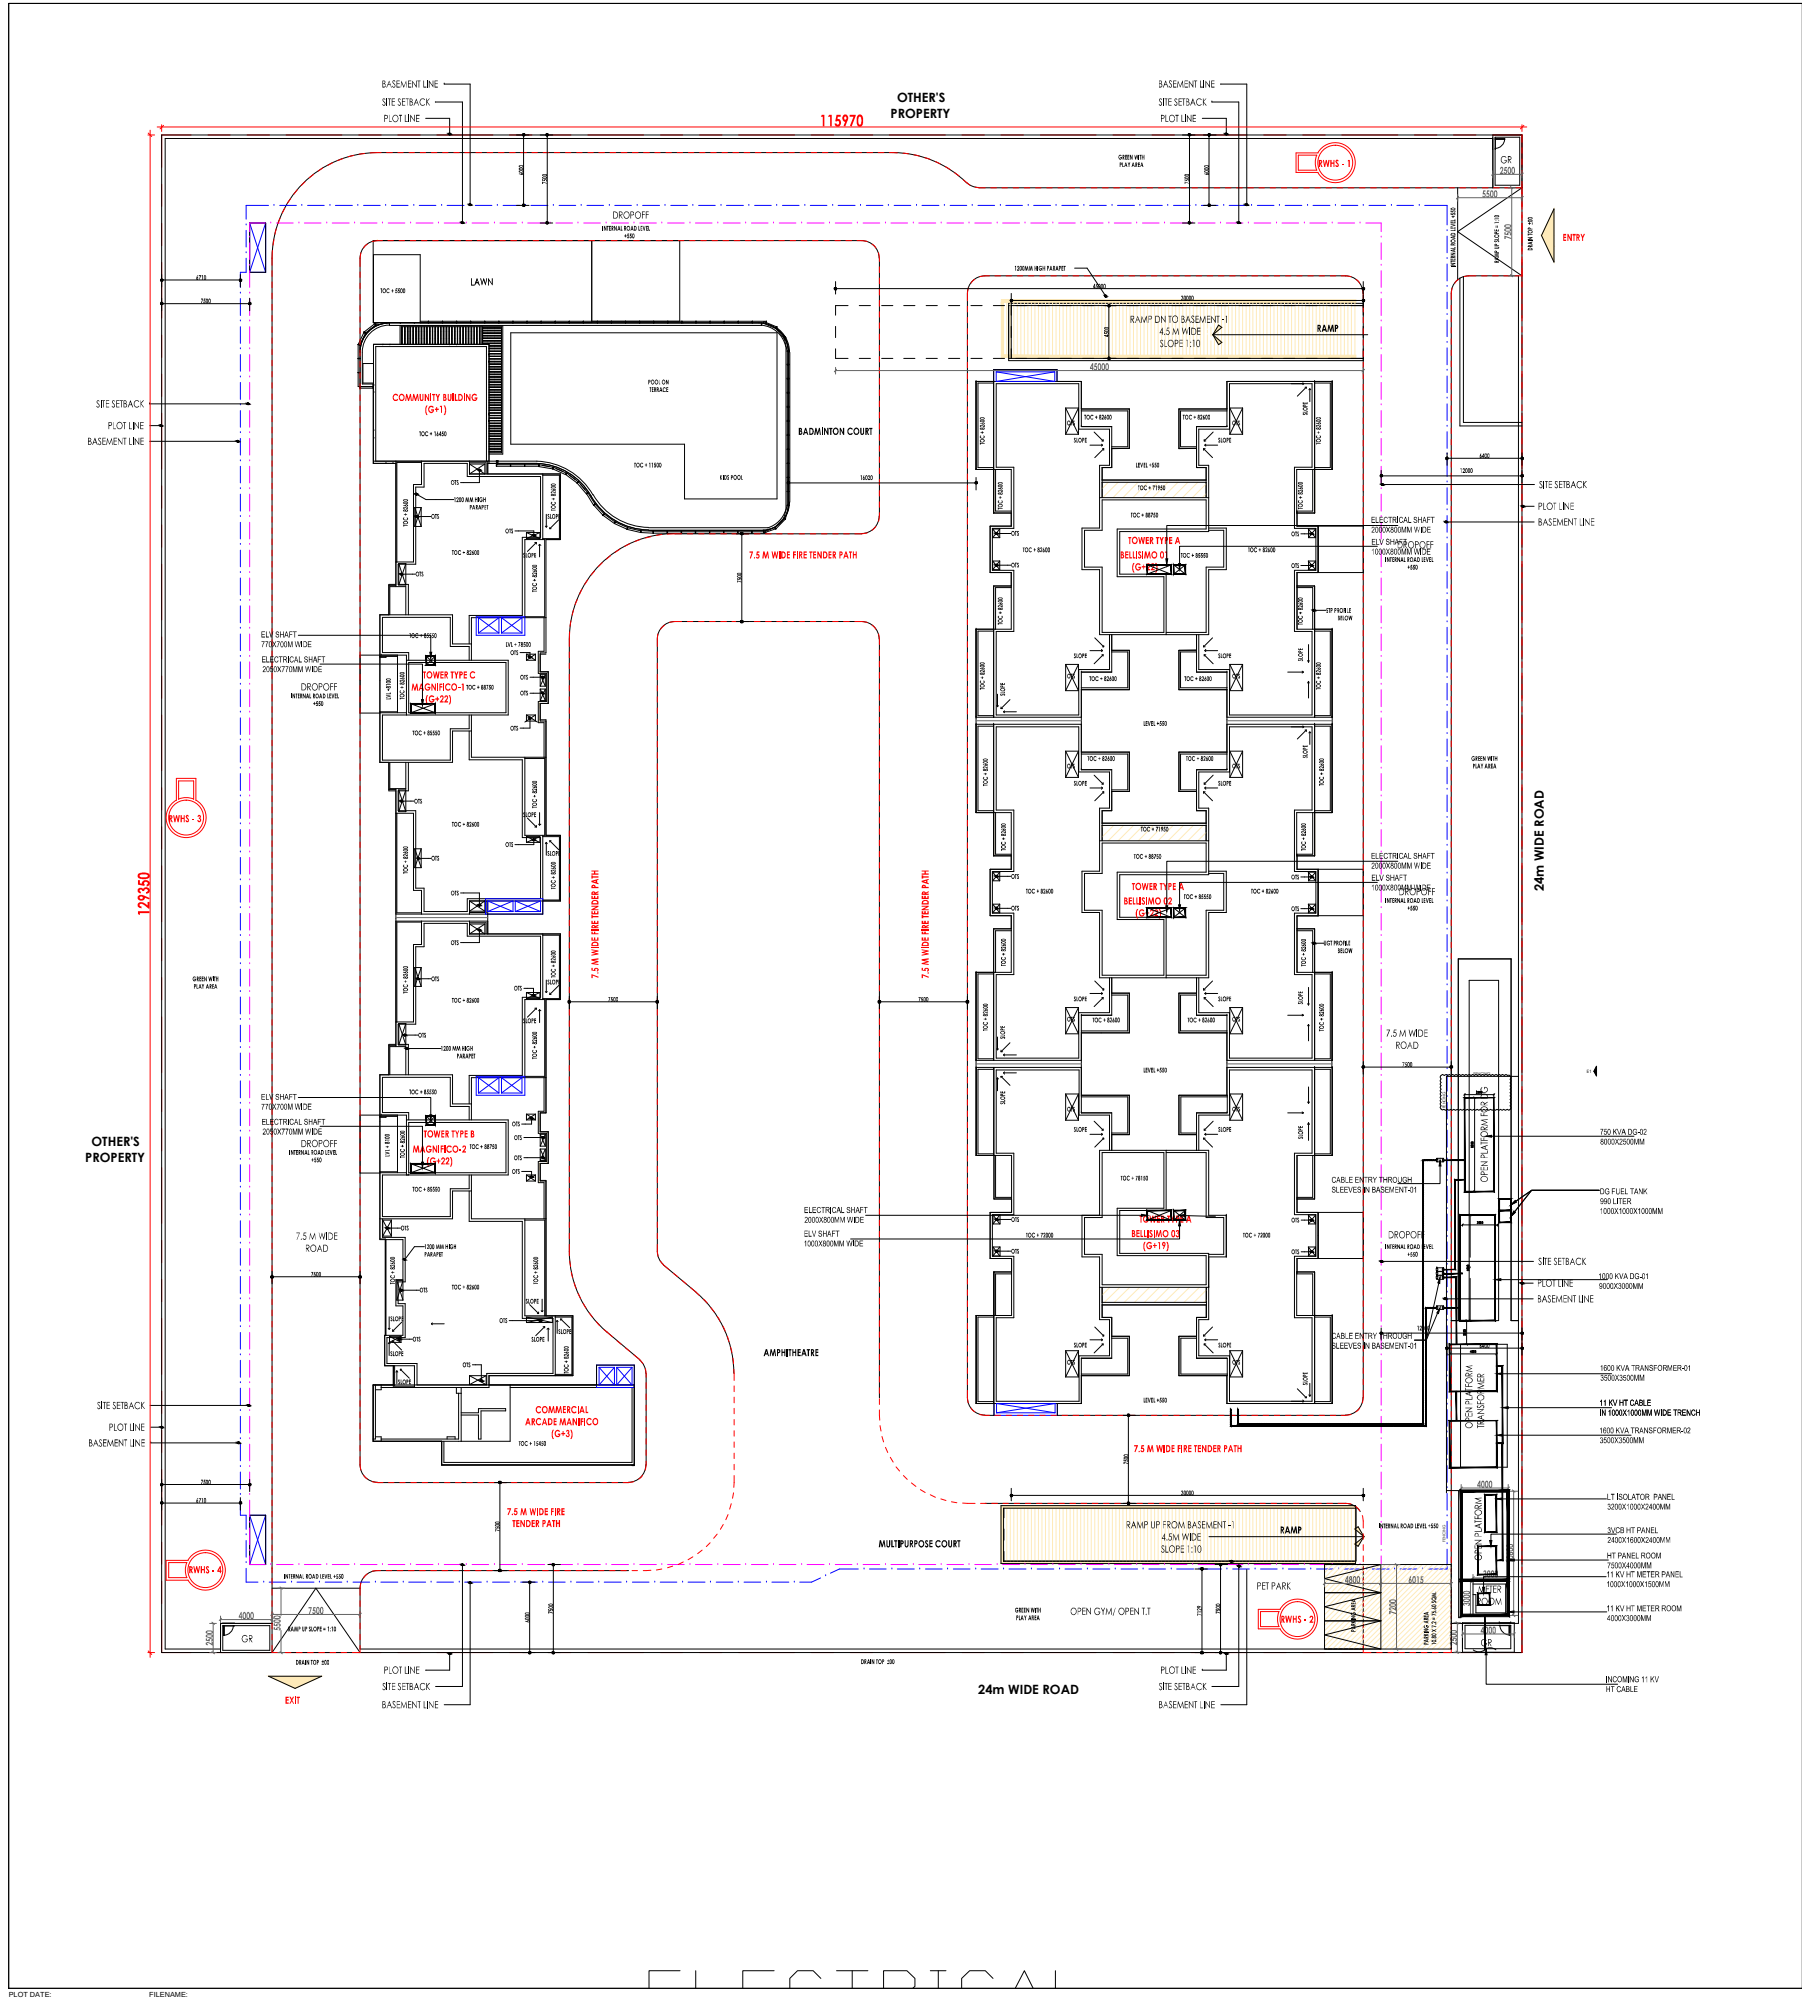


KEY PLAN

NOTES :-

|     |          |           |                      |     |     |
|-----|----------|-----------|----------------------|-----|-----|
| RO  | 25-09-23 | CLIENT    | AUTHORITY SUBMISSION | TSR | MJK |
| Rev | Date     | Issued to | Description          | By  | Chk |

The concepts and information contained in this document are the copyright of Rivulet Engineering Consultancy Pvt. Ltd. Use or copying of the document in whole or in part without the written permission of Rivulet Engineering Consultancy Pvt. Ltd. constitutes an infringement of copyright. Do not scale drawings. If any doubt, please ask!

CLIENT / DEVELOPER :

**Eldeco Real Estate Ltd.**  
201-212, 2nd Floor,  
Splendor Forum,  
Jasola District Centre New Delhi - 110 025 (India)  
Phone: +91 11 4065 5000  
E-mail: contact@eldecoproperties.com

ARCHITECTS :

**BIAS+ARCHITECTURE**  
302, TOWER 12,  
COMMONWEALTH GAMES VILLAGE  
NEW DELHI, 110092

STRUCTURE CONSULTANT :

**TPC**  
B-74 | Sector 57 | Noida 201301  
Uttar Pradesh | India  
Phone : 91 120 4306800  
Website: www.tpc.in

MEPF CONSULTANT :

Delhi Office :- HR-29-B-1, Ground  
Floor, Near Om Shanti, 60 Feet  
Road, Pull Pehlادpur, Badarpur  
New Delhi—110044 ( India )  
Mobile : +91 93503 33474 , +91 98733 38434  
Email : jafar@rivulet-engineering.com  
Website : www.rivulet-engineering.com

Project Name

**PROPOSED GROUP HOUSING**

Project Address

GH 20, SECTOR-12, GREATER NOIDA,  
UTTAR PRADESH

Title

SITE PLAN  
ELECTRICAL LAYOUT

|             |                     |            |                      |
|-------------|---------------------|------------|----------------------|
| Discipline  | MEP SERVICES        | Status     | AUTHORITY SUBMISSION |
| Designed By | TSR                 | Checked By | AJS                  |
| Project No. | P111                | Date       | 25-09-2023           |
| Drawing No. | 23111-EL-A1-SP-1000 | Scale      | 1:300                |
|             |                     | Revision   | R0                   |

Full size on original

0 10 20 30 40 50 60 70 80 90 100mm