



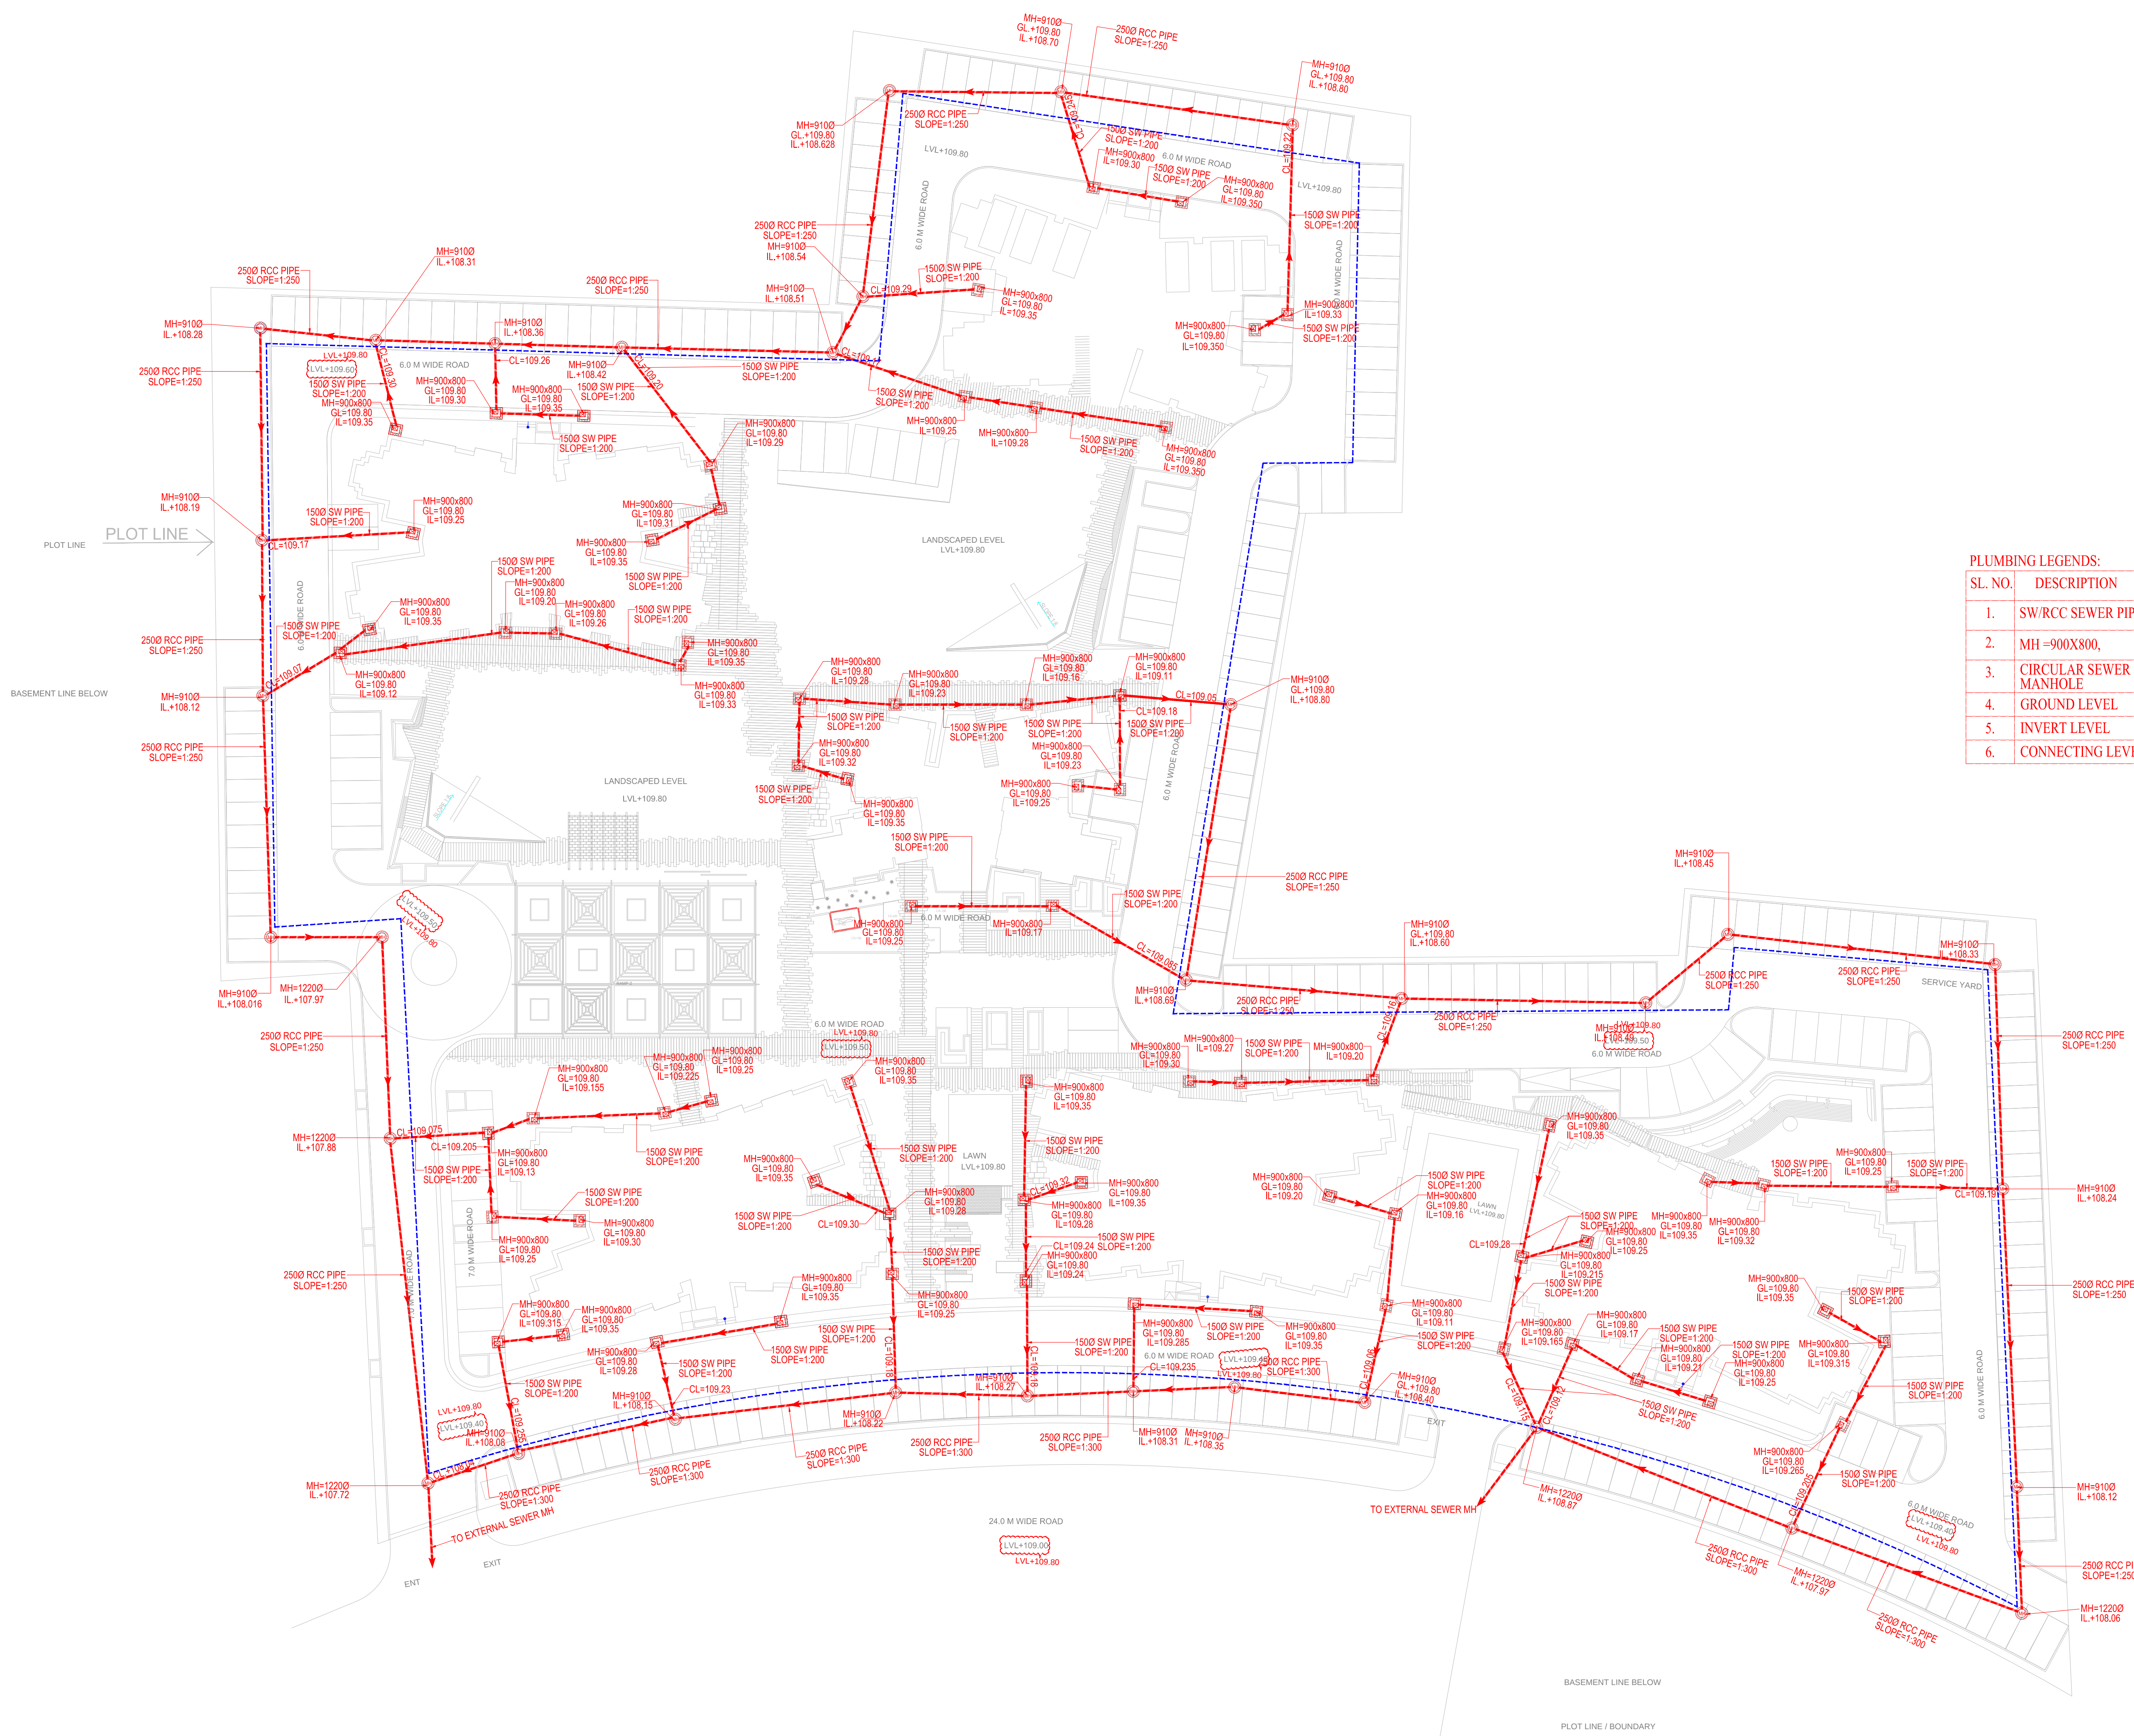

PLUMBING LEGENDS:

SL. NO.	DESCRIPTION	SYMBOL
1.	SW/RCC SEWER PIPE	
2.	MH =900X800,	
3.	CIRCULAR SEWER MANHOLE	
4.	GROUND LEVEL	GL
5.	INVERT LEVEL	IL
6.	CONNECTING LEVEL	CL

KEY PLAN

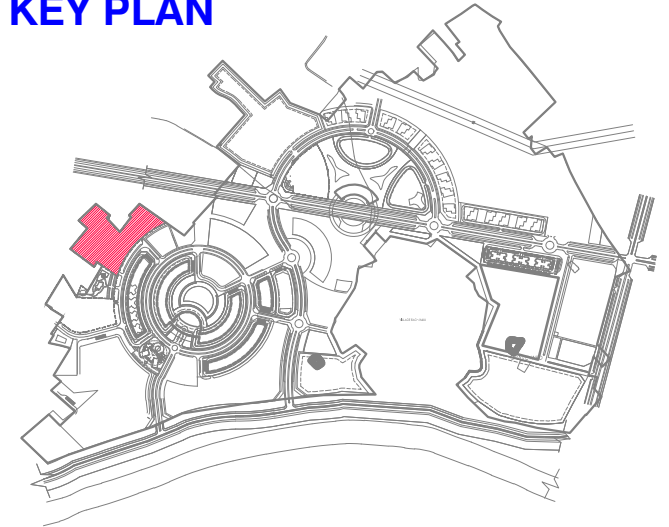

LEGEND

CODE	DESCRIPTION

OWNER

SAS GROUP
SAS Hotels & Properties (P) Ltd.
Shalimar Square,
B N Road , Lalbagh , Lucknow

MASTER PLANNING

ATKINS

COORDINATING ARCHITECT

42mm ARCHITECTURE
D 102 Dr. Ambedkar Colony, Andheria Modh,
New Delhi

ELECTRICAL

M/s Engineering Services Consultants
Plot No. 8, Vardhaman South Plaza,
3rd Floor, L.S.C., Pocket W Market,
Santa Vihar, New Delhi-110 076.
Tel/Fax : 2994 3394, 46575584

MECHANICAL

M/s. Techno Engineering Consultants
Pocket-A, 30 D, Siddhartha Extension
New Delhi - 110014
Phone No. - 91-11-26344668

STRUCTURAL

LANDSCAPE

PROJECT

BAGHAMAU INTEGRATED TOWNSHIP
DEVELOPMENT, LUCKNOW
INDIA

ARCHITECT

SIKKA ASSOCIATES ARCHITECTS
URBAN DESIGN MASTERPLAN | ARCHITECTURES | INTERIORS | ENGINEERING | PROJECT MANAGEMENT
A-2/21, AFRICA AVENUE, SAFDARJUNG ENCLAVE, NEW DELHI, INDIA. 110 029
T: +91-11-4323 5235 (F: +91-11-2623 4461) E: saa@saaarchitects.net | W: www.saaarchitects.net

SEAL

ISSUED FOR

INFORMATION & REVIEW
SUBMISSION
☒ GFC

REVISIONS

#	DATE	DESCRIPTION
RD		

SCALE

1 : 350

DATE ISSUED

16.06.2018

DRAWN BY

SURAJ

CHECKED BY

SS BHATIA

DRAWING

**SITE PLAN-SEWERAGE SYSTEM
PHE DRAWING**

DWG NO.

GH-01-SW-01

NOTES:-

1. ALL DIMENSIONS ARE IN MM.
2. DO NOT SCALE ANY DIMENSIONS.
3. THIS DRAWING SHALL BE READ IN CONJUNCTION WITH RELEVANT ARCHITECTURAL AND STRUCTURAL DRAWINGS.