
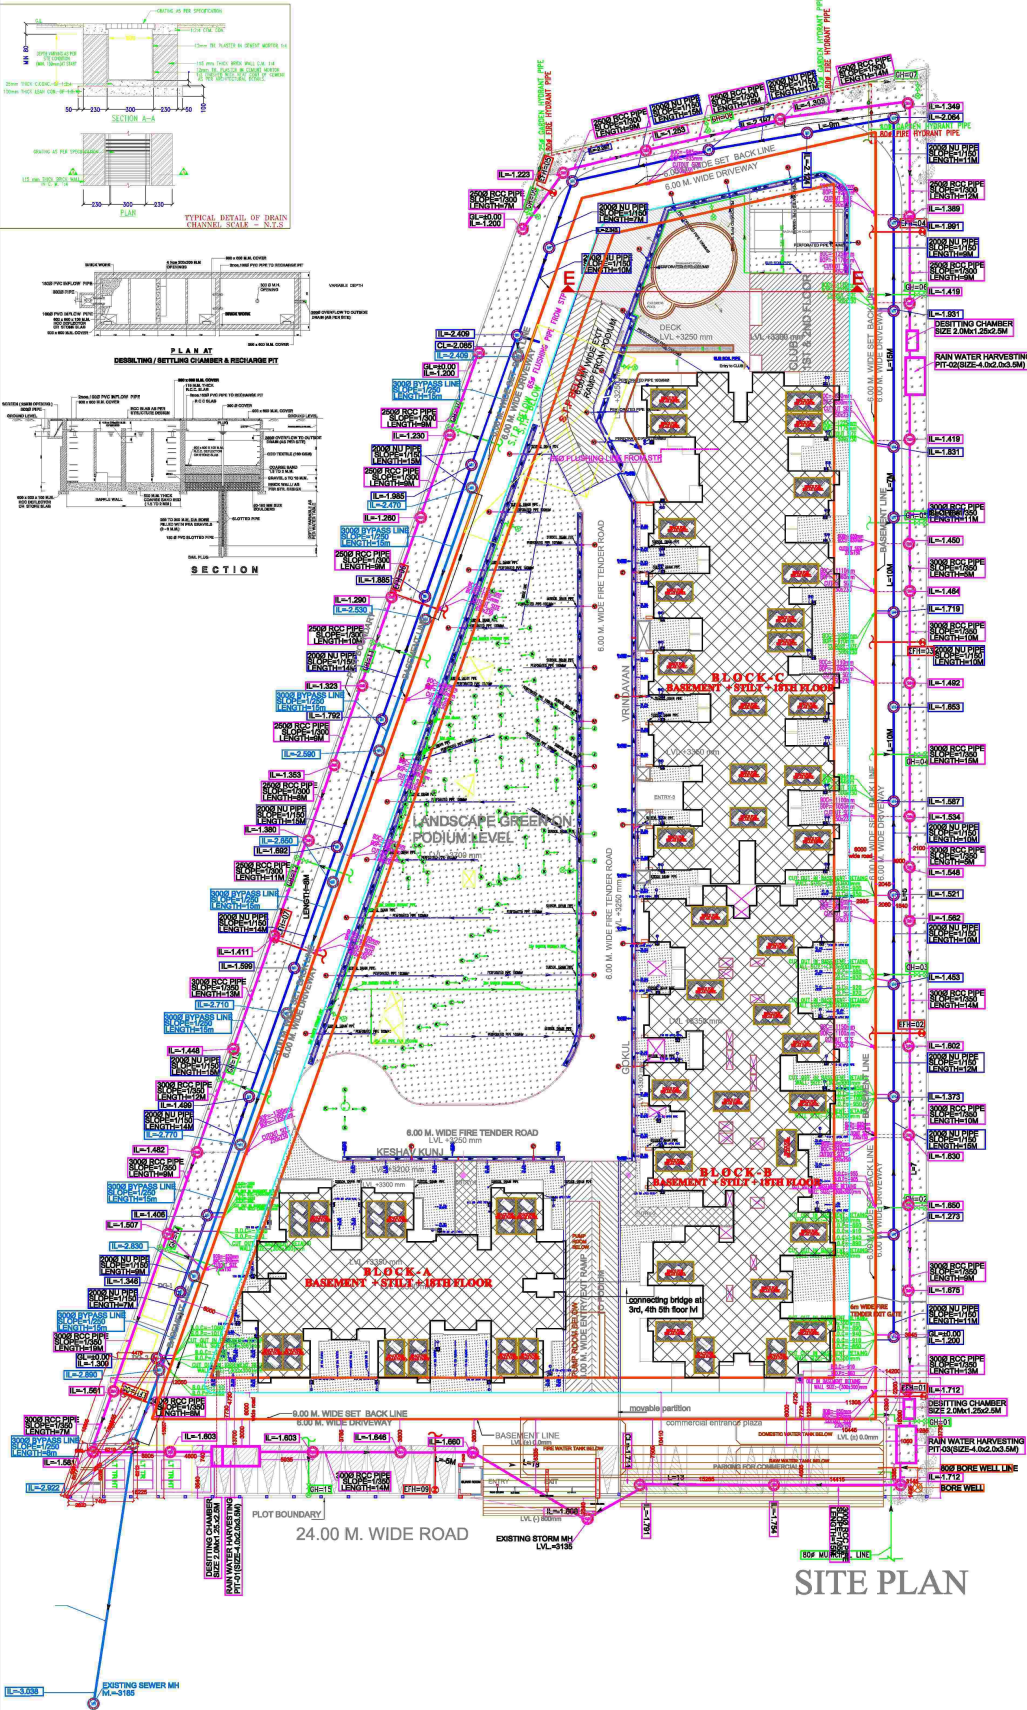
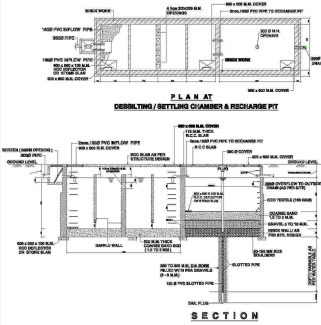


STANDARD CATCH BASIN SIZE & DEPTH	
CATCH BASIN SIZE	DEPTH
CB-450x450MM	0.45M-0.6M
CB-600x600MM	0.6M-0.75M
CB-750x750MM	0.75M-0.9M
CB-900x900MM	0.9M-1.5M

STANDARD MANHOLE SIZE & DEPTH	
MANHOLE SIZE	DEPTH
MH-900x800MM	0.45M-0.9M
MH-910Ø	0.9M-1.65M
MH-1220Ø	1.65M-2.3M
MH-1520Ø	ABOVE-2.3M

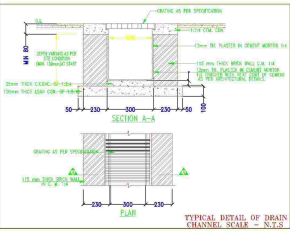

1. BEVERAGE MANHOLE	Ø
2. DRAINAGE MANHOLE	○
3. CATCH BASIN (400x400)	■
4. CATCH BASIN (600x600)	■
5. CATCH BASIN (750x750)	■
6. CATCH BASIN (900x900)	■
7. BEVERAGE PPS LINE	—
8. DRAINAGE PPS LINE	—
9. WASTE PIPE IN BASEMENT CEILING	—
10. BALCONY WASTE PIPE IN BASEMENT CEILING	—
11. BORE WELL	○
12. YARD HYDRANT	○
13. GARDEN HYDRANT	○

LEGEND	
SYMBOL	DESCRIPTION
110 ØØ ØPVC PIPE FOR PODIUM SURFACE WATER	
160 ØØ ØPVC PIPE FOR PODIUM DRAINAGE	
110 ØØ ØPVC PIPE FOR PODIUM SUBSILL WATER FOR GREEN AREA IN FLAT	
300Ø SLEEVE	
100Ø SLEEVE	
150Ø SLEEVE FOR PODIUM TOE WALL	

EXTERNAL FIRE HYDRANT(EH=80Ø)	BOP=850mm
GARDEN HYDRANT(GH=25Ø)	BOP=900mm
	BOP=800mm
	BOP=850mm

PLUMBING LEGEND:	
	RAIN WATER HARVESTING
	SPACE FOR SOLAR PANEL



PROJECT: DRAWING FOR THE GROUP PROJECT AT PLOT NO.GC-03/JGH-03, SECTOR 18C GREATER NOIDA.

OWNER: MRS. PRITHWILK BUILDWELL (P) LTD. THROUGH DIRECTOR-M. BHARAT GOYAL

OWNER SIGN: ARCHITECT SIGN:

DRAWING TITLE: PLAN OF DEVELOPMENT OF WORK

Design Studio
ANU AGARWAL ARCHITECTS
OFFICE: A-244 KAUSHAMBI GHAZIABAD (UP.)
Ph: 0120-4664162, 4168712, TEL. FAX: 2770392
e-mail: arch.anuagarwal@gmail.com

SCALE: NTS
DESIGNED BY: CHECKED BY: DATE: Dwg. No. DG-01