
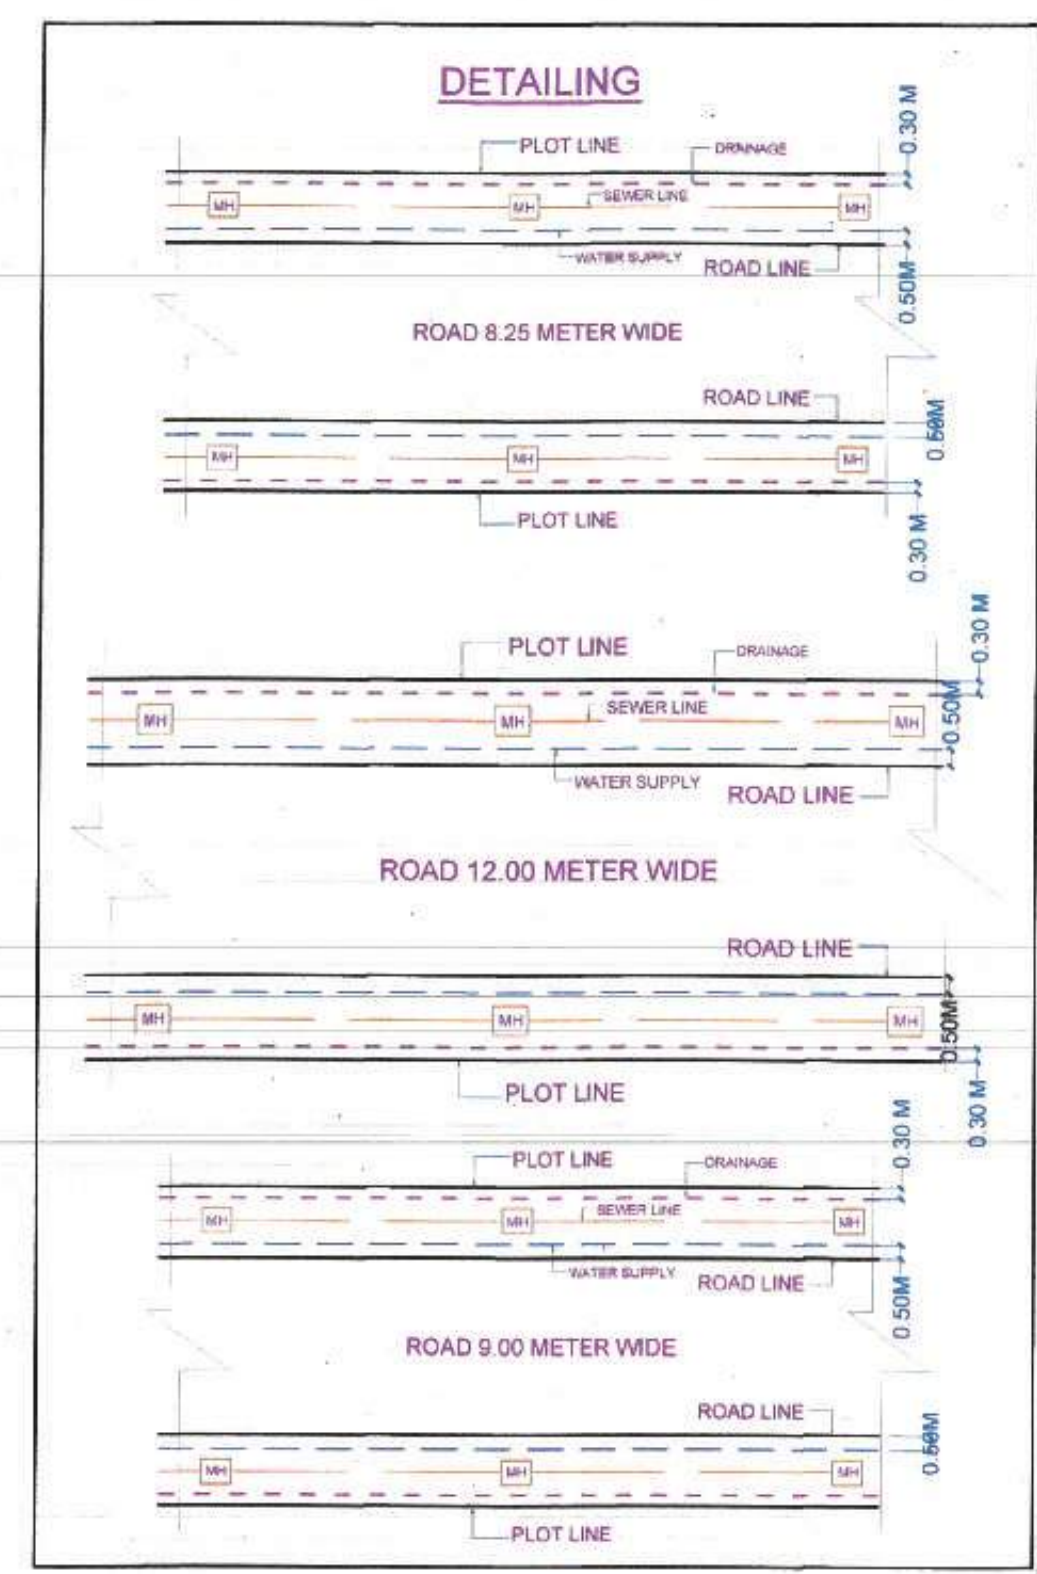
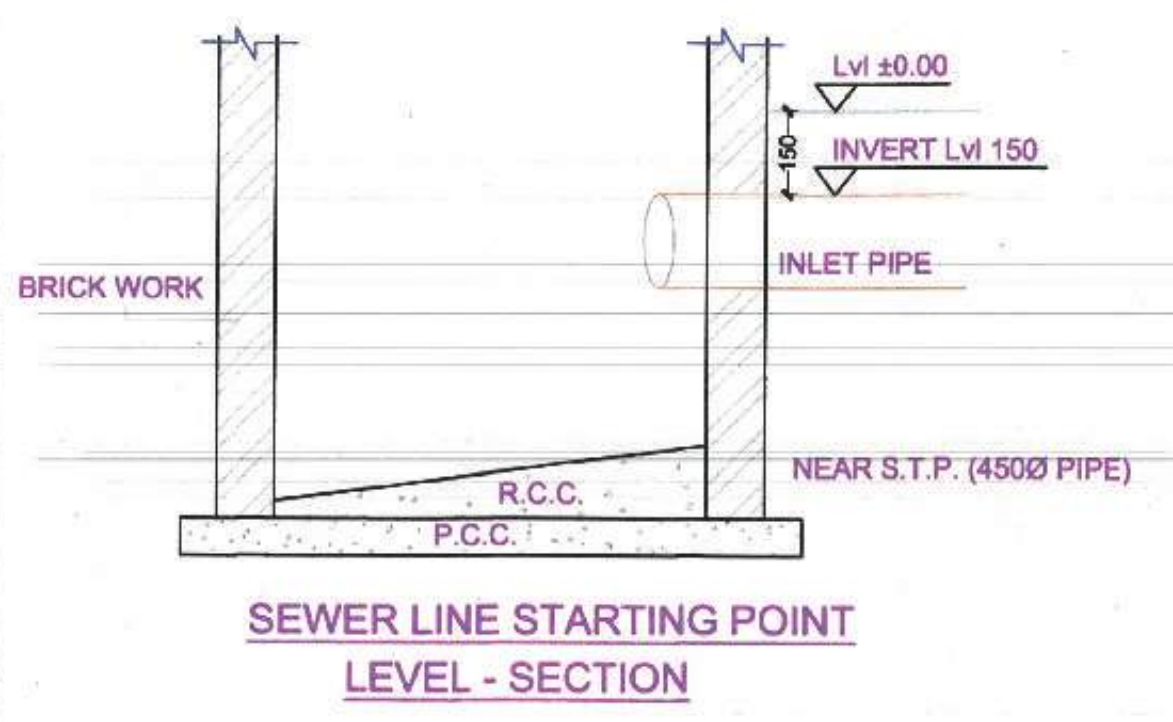
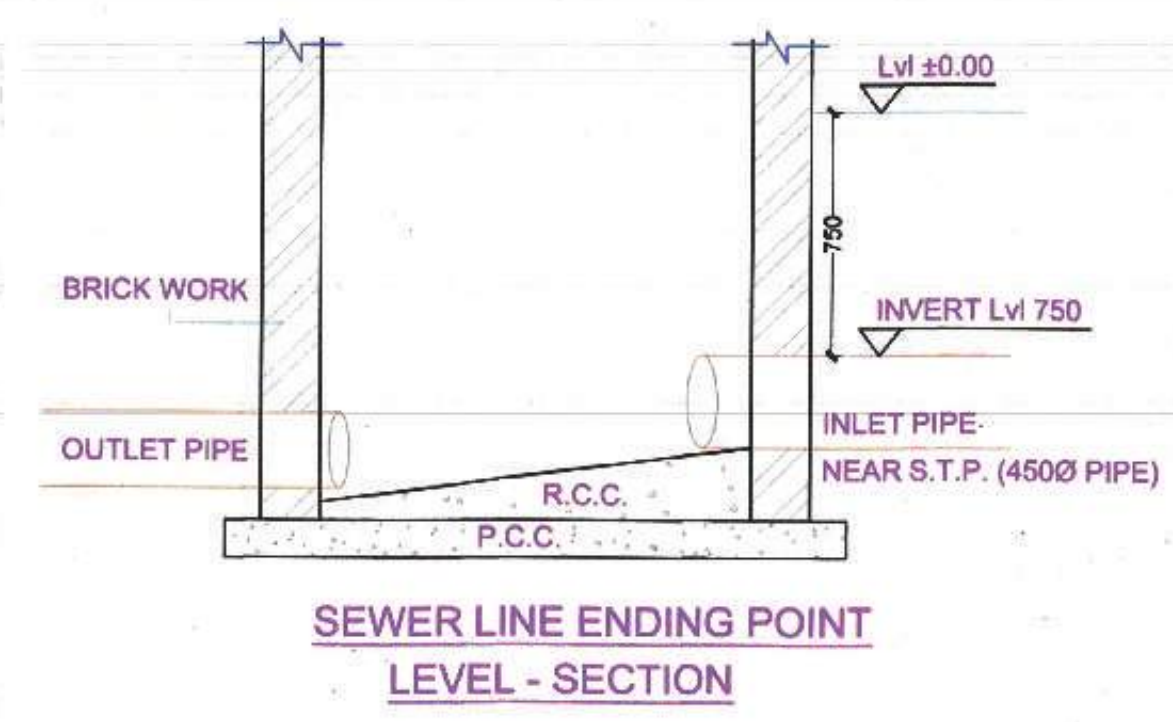


मेरठ विकास प्रा.वकरण
 मेरठ
 M/eda/24-25/P/254-2 दिनांक 20-11-2024
 11-11-2024 से दि. 10-11-2024
 रवीकृत
 प्रभारी अभियंता

दिनांक 20-11-2024
 "धामन शुल्क सहित"

Vijay Kumar Singh
 Digitally signed by Vijay Kumar Singh
 Date: 2024.11.20 13:59:49 +05'30'

Arpit Yadav
 Digitally signed by Arpit Yadav
 Date: 2024.11.20 14:56:03 +05'30'

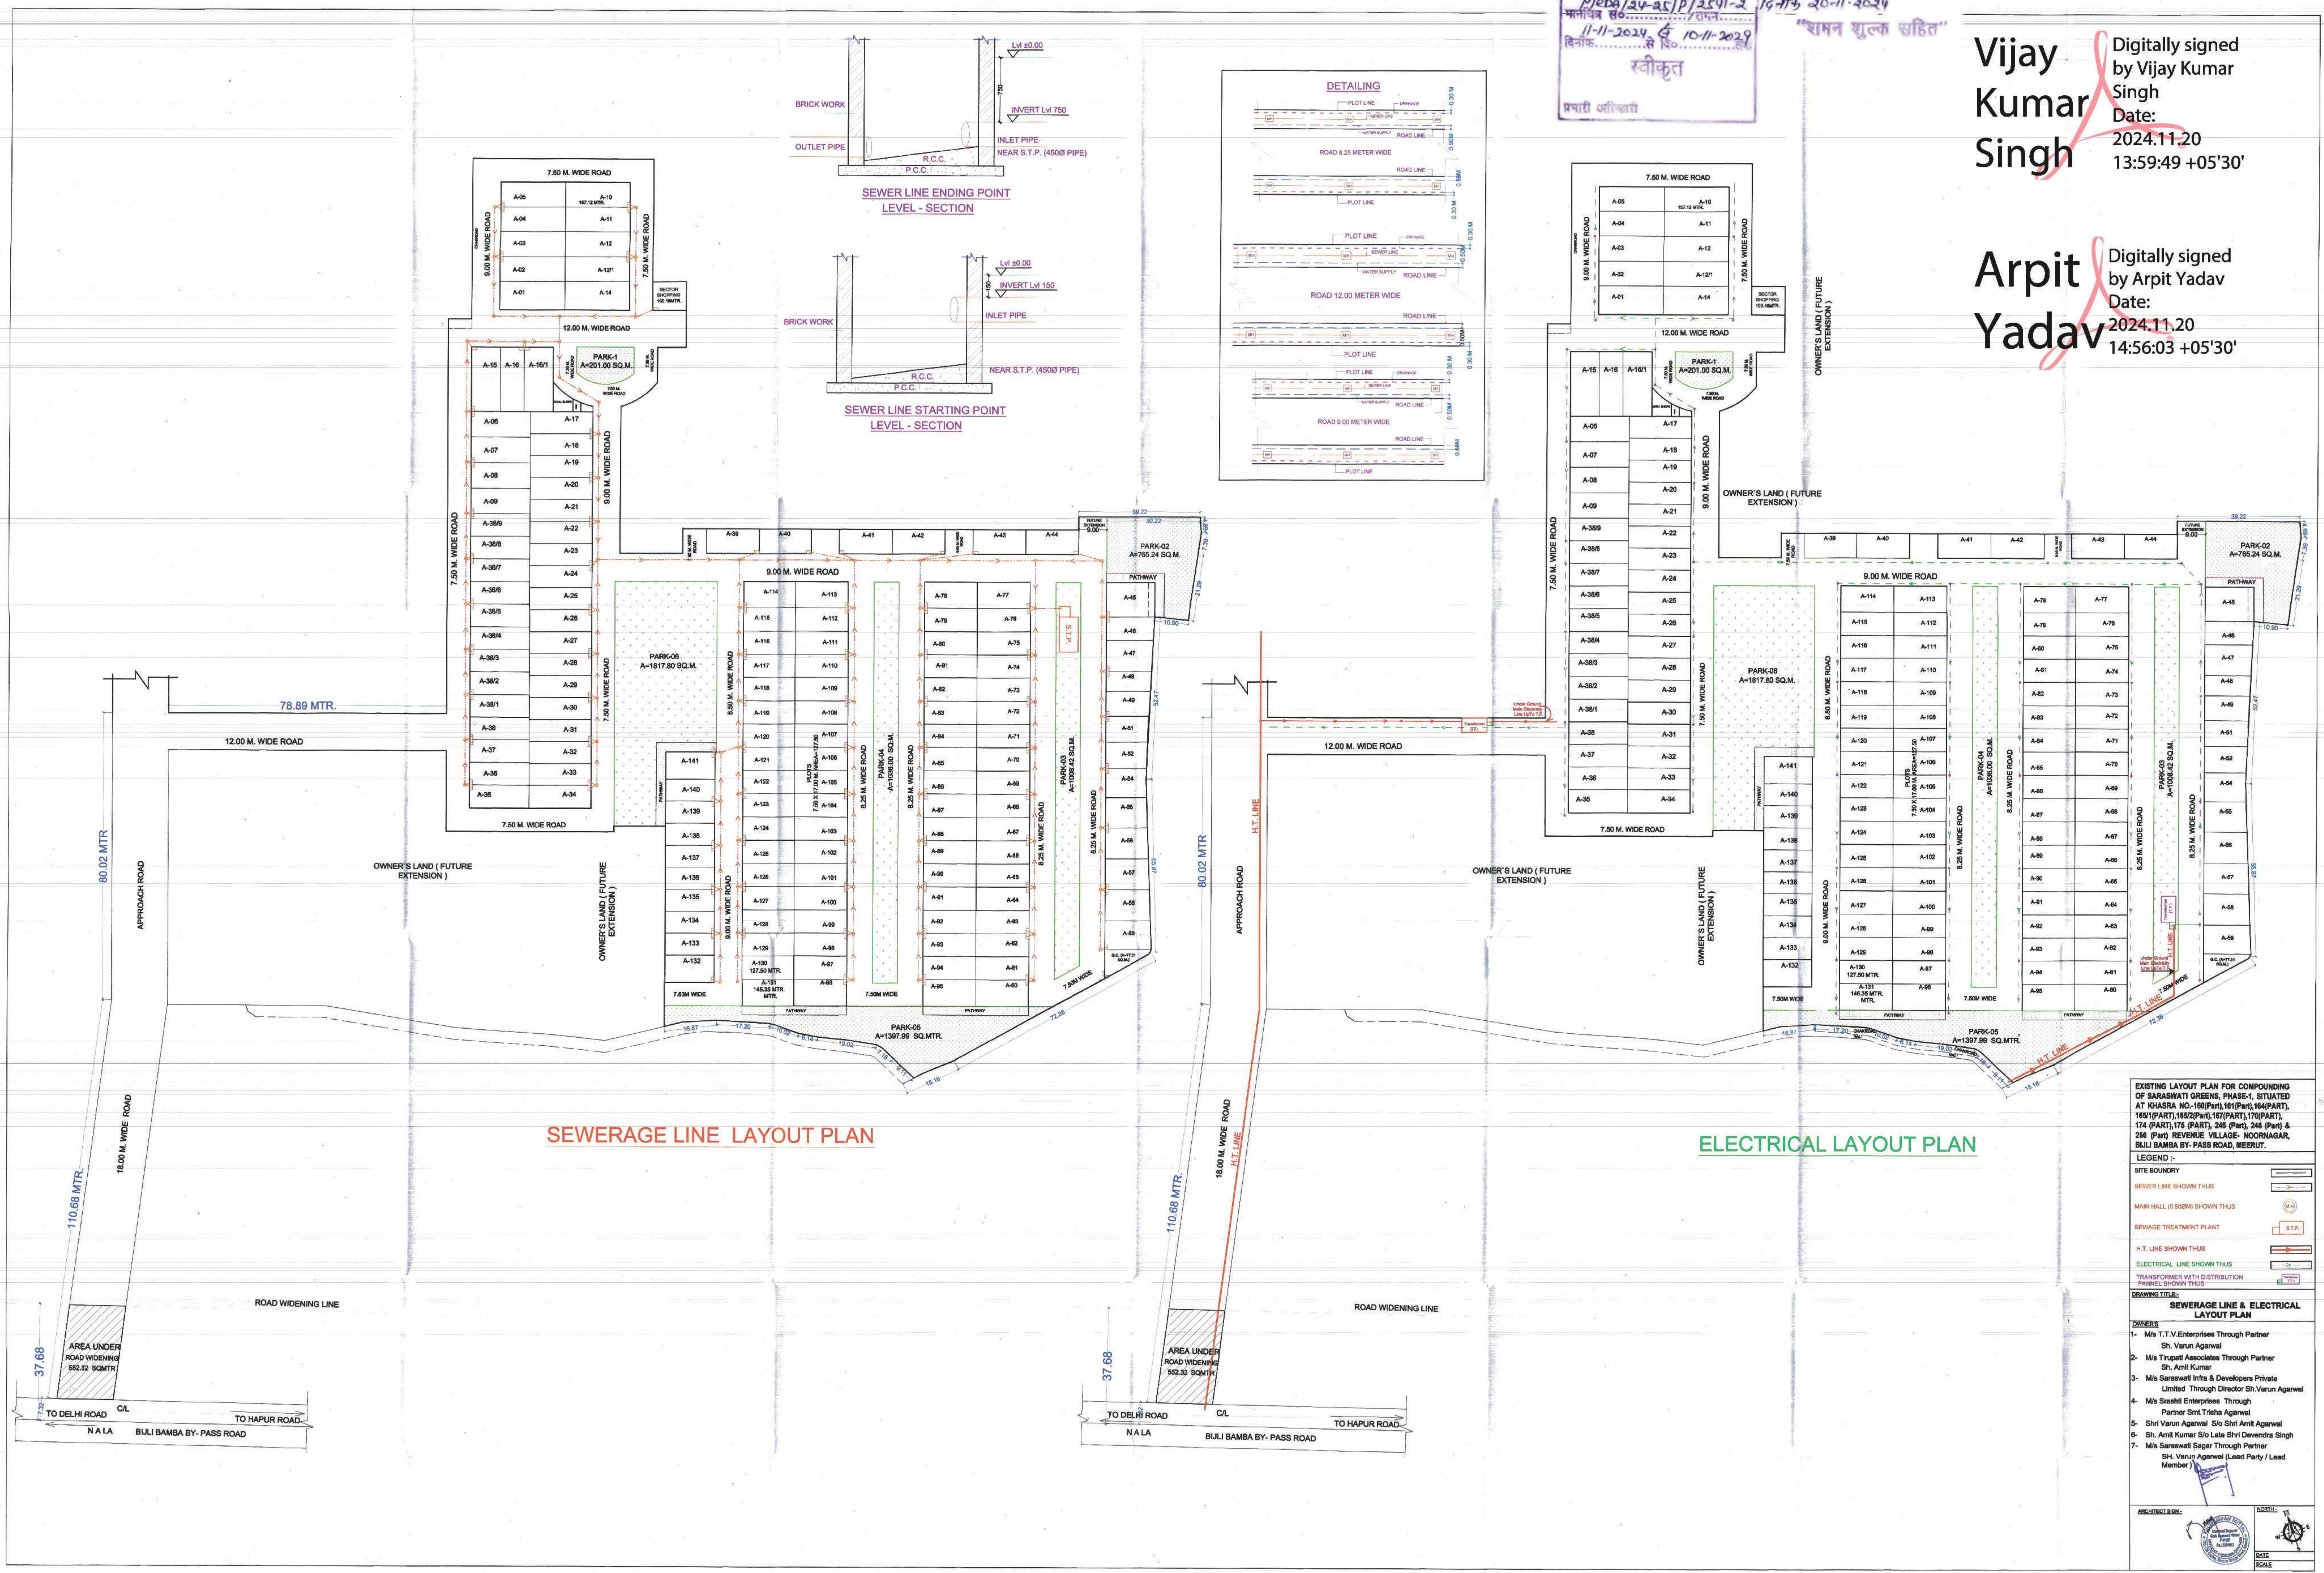

SEWERAGE LINE LAYOUT PLAN

ELECTRICAL LAYOUT PLAN

EXISTING LAYOUT PLAN FOR COMPOUNDING OF SARASWATI GREENS, PHASE-I, SITUATED AT KHARSA NO.-156(PART),161(PART),164(PART), 169(PART),162(PART),167(PART),170(PART), 174 (PART),175 (PART), 245 (Part), 246 (Part) & 250 (Part) REVENUE VILLAGE- NOORNAGAR, BULI BAMBIA BY- PASS ROAD, MEERUT.

LEGEND :-

- SITE BOUNDARY
- SEWER LINE SHOWN THUS
- MAIN HALL (Ø300M) SHOWN THUS
- SEWAGE TREATMENT PLANT
- H.T. LINE SHOWN THUS
- ELECTRICAL LINE SHOWN THUS
- TRANSFORMER WITH DISTRIBUTION PANELS SHOWN THUS

DRAWING TITLE:-
SEWERAGE LINE & ELECTRICAL LAYOUT PLAN

OWNERS

- M/s T.V. Enterprises Through Partner Sh. Varun Agarwal
- M/s Tripathi Associates Through Partner Sh. Amit Kumar
- M/s Sarawati Intra & Developers Private Limited Through Director Sh. Varun Agarwal
- M/s Sreshth Enterprises Through Partner Smt. Tripathi Agarwal
- Shri Varun Agarwal Shri Shri Amit Agarwal
- Sh. Amit Kumar Shri Late Shri Devendra Singh
- M/s Sarawati Sagar Through Partner Sh. Varun Agarwal (Lead Party / Lead Member)

ARCHITECT SIGN: [Signature]

SCALE: [Scale]