



#### GENERAL NOTES:

1. ALL SWITCH BOARD SHALL BE FIXED AT +1200mm (BOTTOM OF BOX) FROM FINISHED FLOOR LEVEL & 200mm FROM WALL EDGE.
2. ALL 6/16 Amp. SWITCH SOCKET SHALL BE FIXED AT +300mm (BOTTOM OF BOX) FROM FINISHED FLOOR LEVEL.
3. ALL DISTRIBUTION BOARD SHALL BE FIXED AT +1400mm (BOTTOM OF BOX) FROM FINISHED FLOOR LEVEL AND CONCEALED IN 230mm THICK BRICK WALL.
4. ALL BRACKET/WALL MOUNTED FIXTURE SHALL BE FIXED AT +2100mm/ ABOVE DOOR, FROM FINISHED FLOOR LEVEL.
5. ALL T.V, TELEPHONE SOCKETS SHALL BE FIXED AT +300mm (BOTTOM OF BOX) FROM FINISHED FLOOR LEVEL.
6. TELEPHONE TAG BLOCK SHALL BE FIXED AT +300mm (BOTTOM OF BOX) FROM FINISHED FLOOR LEVEL.
7. ALL EX.FAN POINT IN TOILET SHALL BE FIXED AT +2250mm (BOTTOM OF BOX) FROM FINISHED FLOOR LEVEL.
8. ALL LIGHTING POWER CONDUIT SHALL BE OF 25mm Ø PVC WITH 2mm WALL THICKNESS (FRLS) TO BE USED IN WALL AND SLAB.
9. ALL T.V/TELEPHONE CONDUIT SHALL BE OF 25mm Ø PVC WITH 2mm WALL THICKNESS (FRLS) TO BE USED IN WALL AND SLAB.
10. ALL SUB MAIN CONDUIT SHALL BE OF 32/40mm Ø PVC WITH 2mm WALL THICKNESS (FRLS) TO BE USED IN WALL AND SLAB.

STRL CONSULTANTS :-

### PROPOSED HOUSING OF PARK SQUARE AT LUCKNOW

| ELECTRICAL LEGEND :- |        |                                             |
|----------------------|--------|---------------------------------------------|
| S.NO.                | SYMBOL | DESCRIPTION                                 |
| 1                    |        | TWO WAY SWITCH BOARD (TWA-2" FROM F.L.V.L.) |
| 2                    |        | SWITCH BOARD (WT-2" FROM F.L.V.L.)          |
| 3                    |        | DEEP                                        |
| 4                    |        | 1x18W BRACKET LIGHT                         |
| 5                    |        | 1x20W WALL MOUNTED TUBE LIGHT               |
| 6                    |        | STREET LIGHT                                |
| 7                    |        | 1x100W EXHAUST FAN                          |
| 8                    |        | 6A SOCKET FOR EXHAUST FAN                   |
| 9                    |        | CEILING FAN                                 |
| 10                   |        | FLOOR MOUNTED LIGHT                         |
| 11                   |        | 6A SWITCH SOCKET                            |
| 12                   |        | 6/16A SPIN SWITCH SOCKET                    |
| 13                   |        | GEYSER SOCKET                               |
| 14                   |        | AC SOCKET                                   |
| 15                   |        | CALL BELL PUSH                              |
| 16                   |        | CALL BELL BUZZER                            |
| 17                   |        | TV OUTLET                                   |
| 18                   |        | TELEPHONE OUTLET                            |
| 19                   |        | TELEPHONE TAG BLOCK                         |
| 20                   |        | DISTRIBUTION BOARD (DB)                     |
| 21                   |        | HANGING LIGHT                               |
| 22                   |        | METER                                       |
| 23                   |        | BOLLARD                                     |
| 24                   |        | WATERPROOF LIGHT (WP)                       |
| 25                   |        | LAN                                         |
| 26                   |        | U.S.B. PORT                                 |
| 27                   |        | FLOOR LIGHTS                                |

#### DRAWING TITLE

#### ELECTRICAL PLAN

#### JOB TITLE

#### GROUND FLOOR PLAN

CLIENT NAME:

MR. JASWANI

SCALE

N.T.S.

DATE

DRAWN BY-

CKD BY-

REVISION DATE-

NORTH

SHEET NO.-



STRL CONSULTANTS :-

**AE** ANPEE-TECH ENGINEERS  
CIVIL & STRUCTURAL CONSULTANTS  
INDRAPRASTH APPT (G. FLOOR)  
11/17 HARSH NAGAR KANPUR  
MOB :- 9415039584, 9335036545

MEP CONSULTANTS:-

**TRIVENI CONSULTING ENGINEERS**

14/34 YAMAN SAHARA ESTATE,  
JANKIPURAM, 226021,  
(LUCKNOW)  
PH :- 0522 - 4333761  
mail us at: triveniconsultants.lko@gmail.com




Firm Name

**VASTU SRAJAN**

OMAXE HEIGHTS, CARLTON T 2, GF 001,  
VIBHUTI KHAND, GOMTI NAGAR,  
LUCKNOW-226010.

ph- 8799419194 ,0522 4103370  
e-mail- vastu.srajan@gmail.com  
www.vastusrajan.com



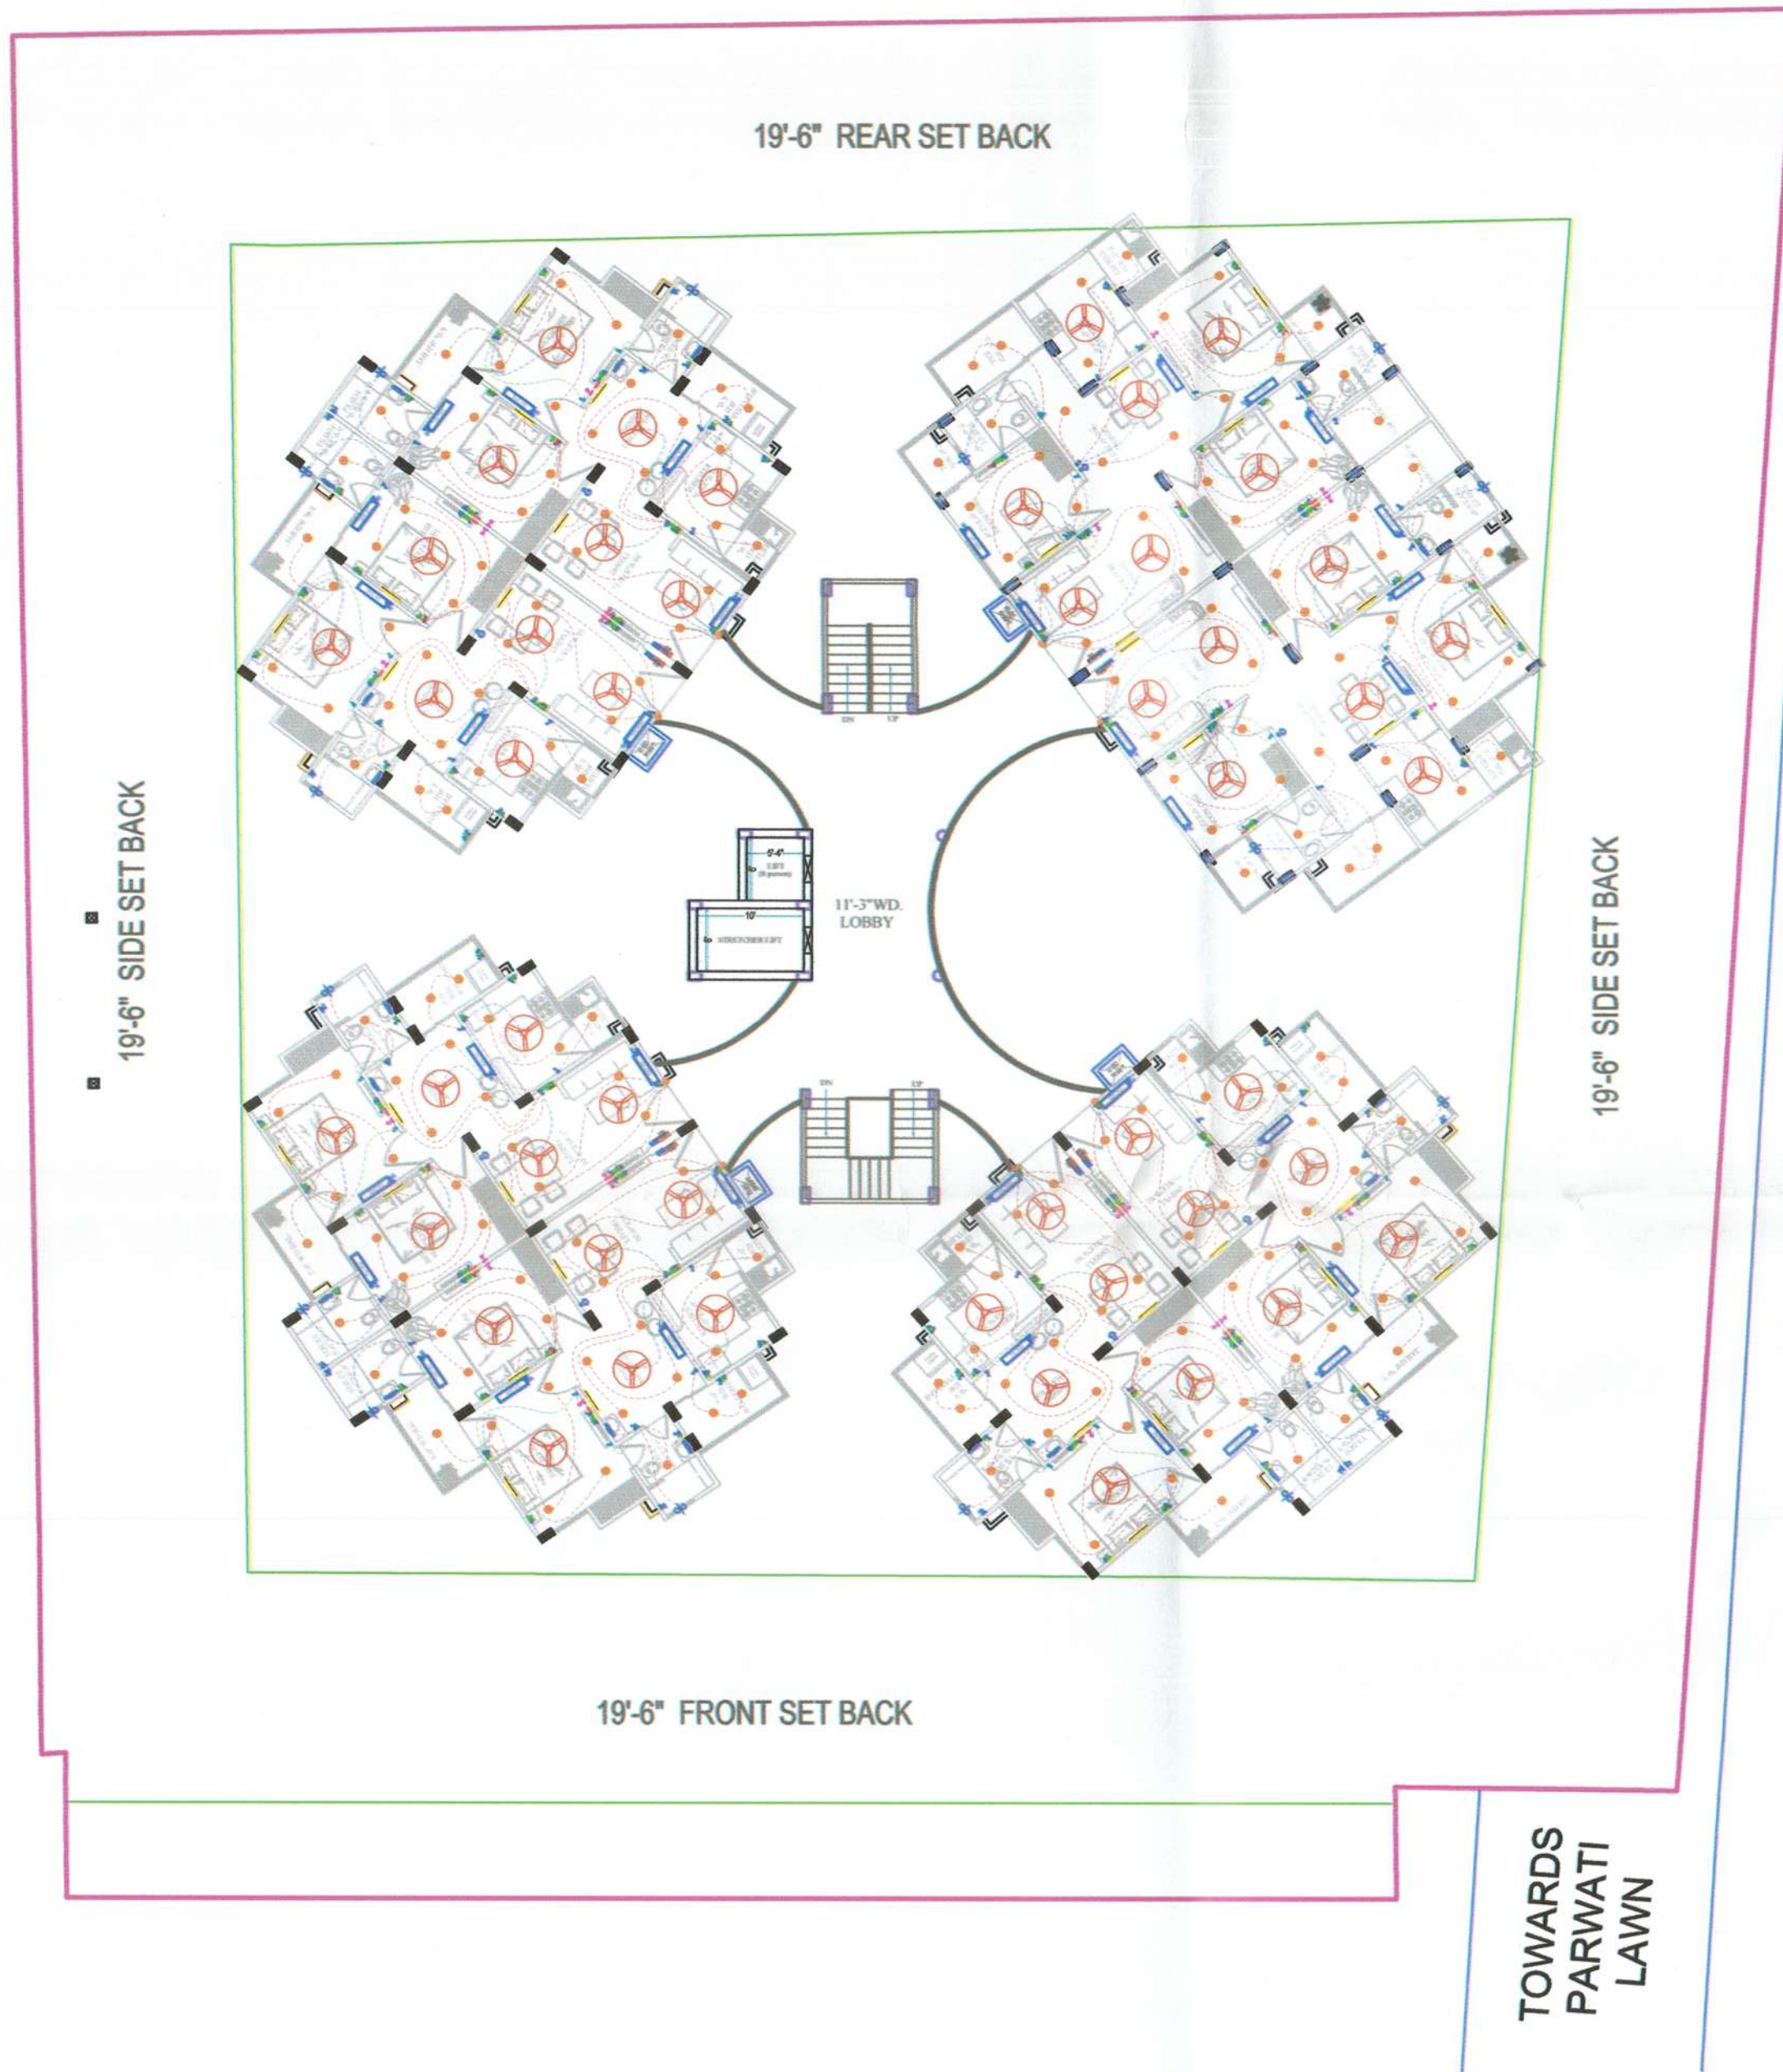

#### GENERAL NOTES:

1. ALL SWITCH BOARD SHALL BE FIXED AT +1200mm (BOTTOM OF BOX) FROM FINISHED FLOOR LEVEL & 200mm FROM WALL EDGE.
2. ALL 6/16 Amp. SWITCH SOCKET SHALL BE FIXED AT +300mm (BOTTOM OF BOX) FROM FINISHED FLOOR LEVEL.
3. ALL DISTRIBUTION BOARD SHALL BE FIXED AT +1400mm (BOTTOM OF BOX) FROM FINISHED FLOOR LEVEL AND CONCEALED IN 230mm THICK BRICK WALL.
4. ALL BRACKET/WALL MOUNTED FIXTURE SHALL BE FIXED AT +2100mm/ ABOVE DOOR, FROM FINISHED FLOOR LEVEL.
5. ALL T.V, TELEPHONE SOCKETS SHALL BE FIXED AT +300mm (BOTTOM OF BOX) FROM FINISHED FLOOR LEVEL.
6. TELEPHONE TAG BLOCK SHALL BE FIXED AT +300mm (BOTTOM OF BOX) FROM FINISHED FLOOR LEVEL.
7. ALL EX.FAN POINT IN TOILET SHALL BE FIXED AT +2250mm (BOTTOM OF BOX) FROM FINISHED FLOOR LEVEL.
8. ALL LIGHTING POWER CONDUIT SHALL BE OF 25mm Ø PVC WITH 2mm WALL THICKNESS (FRLS) TO BE USED IN WALL AND SLAB.
9. ALL T.V/TELEPHONE CONDUIT SHALL BE OF 25mm Ø PVC WITH 2mm WALL THICKNESS (FRLS) TO BE USED IN WALL AND SLAB.
10. ALL SUB MAIN CONDUIT SHALL BE OF 32/40mm Ø PVC WITH 2mm WALL THICKNESS (FRLS) TO BE USED IN WALL AND SLAB.

STR. CONSULTANTS:-

### PROPOSED HOUSING OF PARK SQUARE AT LUCKNOW

#### ELECTRICAL LEGEND :-

| S.NO. | SYMBOL | DESCRIPTION                                    |
|-------|--------|------------------------------------------------|
| 1     |        | TWO WAY SWITCH BOARD (INT. A-0" FROM F.L.V.L.) |
| 2     |        | SWITCH BOARD (INT. A-0" FROM F.L.V.L.)         |
| 3     |        | DEEP                                           |
| 4     |        | 1x18W BRACKET LIGHT                            |
| 5     |        | 1x28W WALL MOUNTED TUBE LIGHT                  |
| 6     |        | STREET LIGHT                                   |
| 7     |        | 1x100W EXHAUST FAN                             |
| 8     |        | 6A SOCKET FOR EXHAUST FAN                      |
| 9     |        | CEILING FAN                                    |
| 10    |        | FLOOR MOUNTED LIGHT                            |
| 11    |        | 6A SWITCH SOCKET                               |
| 12    |        | 6/16A SPN SWITCH SOCKET                        |
| 13    |        | GEYSER SOCKET                                  |
| 14    |        | AC SOCKET                                      |
| 15    |        | CALL BELL PUSH                                 |
| 16    |        | CALL BELL BUZZER                               |
| 17    |        | TV OUTLET                                      |
| 18    |        | TELEPHONE OUTLET                               |
| 19    |        | TELEPHONE TAG BLOCK                            |
| 20    |        | DISTRIBUTION BOARD (DB)                        |
| 21    |        | HANGING LIGHT                                  |
| 22    |        | METER                                          |
| 23    |        | BOLLARD                                        |
| 24    |        | WATERPROOF LIGHTS (IP7)                        |
| 25    |        | LAN                                            |
| 26    |        | U.S.B. PORT                                    |
| 27    |        | FLOOR LIGHTS                                   |

#### DRAWING TITLE

#### ELECTRICAL PLAN

#### JOB TITLE

#### 1 TO 5 FLOOR PLAN

CLIENT NAME:

MR. JASWANI

SCALE

N.T.S.

DATE

DRAWN BY-

CKD BY-

REVISION DATE-

NORTH

SHEET NO.-



STR. CONSULTANTS:-



**ANPEE-TECH ENGINEERS**  
CIVIL & STRUCTURAL CONSULTANTS  
INDRAPRASTH APPT (G. FLOOR)  
111/7 HARSH NAGAR KANPUR  
MOB :- 9415039584, 9335036545

MEP CONSULTANTS:-

#### TRIVENI CONSULTING ENGINEERS

14/34 YAMAN SAHARA ESTATE,  
JANKIPURAM, 226021,  
(LUCKNOW)  
PH :- 0522 - 4333761

mail us at:- [triveniconsultants.iko@gmail.com](mailto:triveniconsultants.iko@gmail.com)



Firm Name

**VASTU SRAJAN**


OMAXE HEIGHTS, CARLTON T 2, GF 001,  
VIBHUTI KHAND, GOMTI NAGAR,  
LUCKNOW-226010.

ph- 8799419194 ,0522 4103370

e-mail- [vastu.srajan@gmail.com](mailto:vastu.srajan@gmail.com)

[www.vastusrajan.com](http://www.vastusrajan.com)



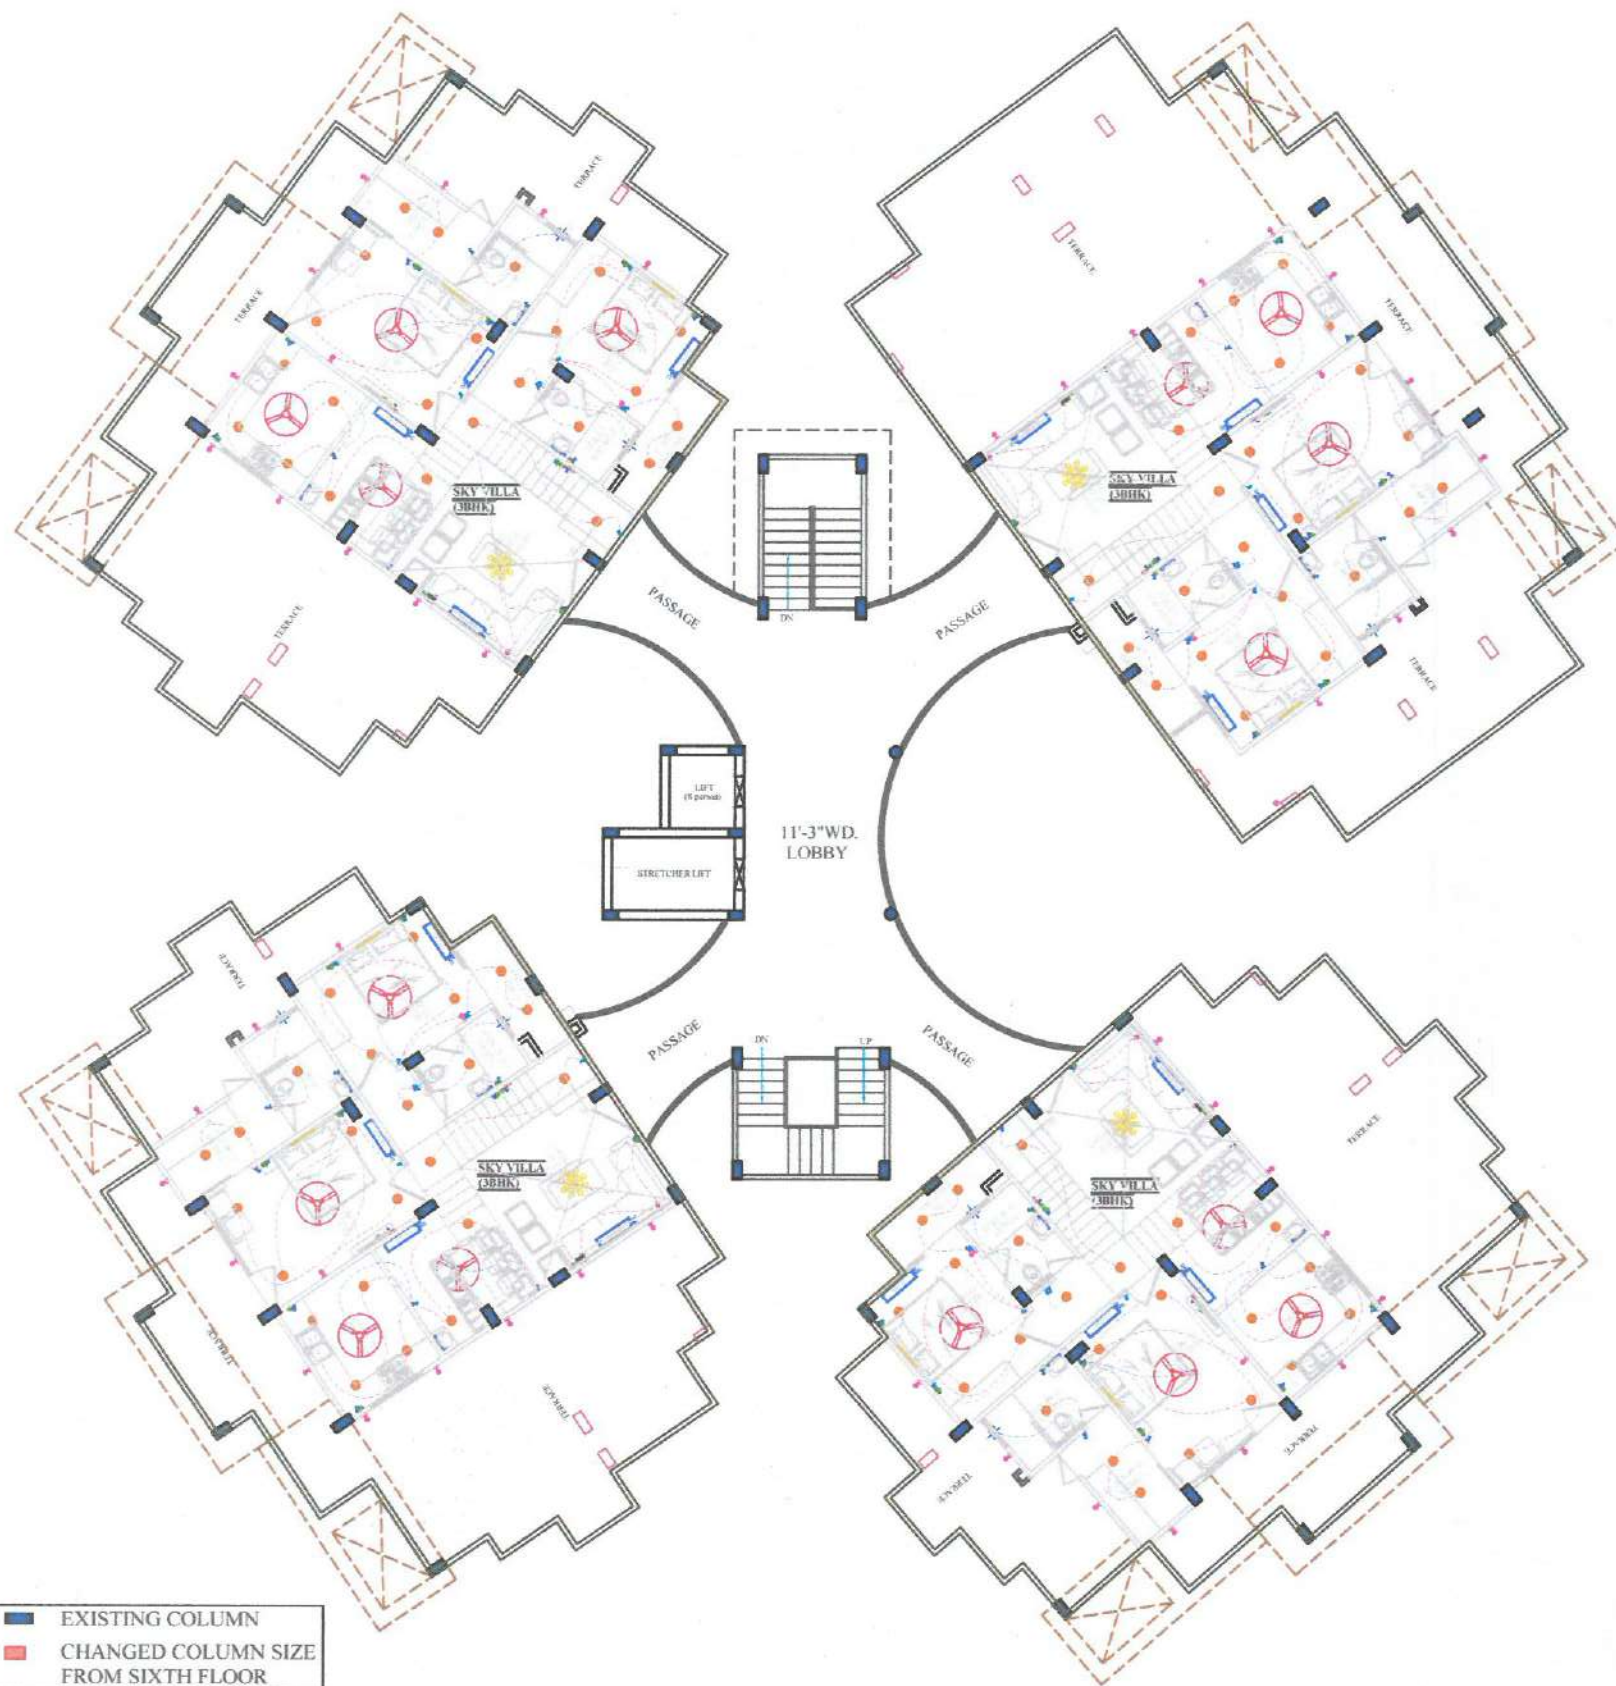

■ EXISTING COLUMN  
 ■ CHANGED COLUMN SIZE FROM SIXTH FLOOR

#### GENERAL NOTES:

1. ALL SWITCH BOARD SHALL BE FIXED AT +1200mm (BOTTOM OF BOX) FROM FINISHED FLOOR LEVEL & 200mm FROM WALL EDGE.
2. ALL 6/16 Amp. SWITCH SOCKET SHALL BE FIXED AT +300mm (BOTTOM OF BOX) FROM FINISHED FLOOR LEVEL.
3. ALL DISTRIBUTION BOARD SHALL BE FIXED AT +1400mm (BOTTOM OF BOX) FROM FINISHED FLOOR LEVEL AND CONCEALED IN 230mm THICK BRICK WALL.
4. ALL BRACKET/WALL MOUNTED FIXTURE SHALL BE FIXED AT +2100mm/ ABOVE DOOR, FROM FINISHED FLOOR LEVEL.
5. ALL T.V, TELEPHONE SOCKETS SHALL BE FIXED AT +300mm (BOTTOM OF BOX) FROM FINISHED FLOOR LEVEL.
6. TELEPHONE TAG BLOCK SHALL BE FIXED AT +300mm (BOTTOM OF BOX) FROM FINISHED FLOOR LEVEL.
7. ALL EX.FAN POINT IN TOILET SHALL BE FIXED AT +2250mm (BOTTOM OF BOX) FROM FINISHED FLOOR LEVEL.
8. ALL LIGHTING POWER CONDUIT SHALL BE OF 25mm Ø PVC WITH 2mm WALL THICKNESS (FRLS) TO BE USED IN WALL AND SLAB.
9. ALL T.V/TELEPHONE CONDUIT SHALL BE OF 25mm Ø PVC WITH 2mm WALL THICKNESS (FRLS) TO BE USED IN WALL AND SLAB.
10. ALL SUB MAIN CONDUIT SHALL BE OF 32/40mm Ø PVC WITH 2mm WALL THICKNESS (FRLS) TO BE USED IN WALL AND SLAB.

STRL CONSULTANTS:-

## PROPOSED HOUSING AT LUCKNOW

| ELECTRICAL LEGEND |        |                                           |
|-------------------|--------|-------------------------------------------|
| S.NO.             | SYMBOL | DESCRIPTION                               |
| 1                 |        | TWO WAY SWITCH BOARD (BT & 4P FROM FLOOR) |
| 2                 |        | SWITCH BOARD (BT & 4P FROM FLOOR)         |
| 3                 |        | DEEP                                      |
| 4                 |        | 1/8W BRACKET LIGHT                        |
| 5                 |        | 1/8W WALL MOUNTED TUBE LIGHT              |
| 6                 |        | STREET LIGHT                              |
| 7                 |        | 1/8W EXHAUST FAN                          |
| 8                 |        | 6A SOCKET FOR EXHAUST FAN                 |
| 9                 |        | CEILING FAN                               |
| 10                |        | FLOOR MOUNTED LIGHT                       |
| 11                |        | 6A SWITCH SOCKET                          |
| 12                |        | 6/16A SPN SWITCH SOCKET                   |
| 13                |        | GEYSER SOCKET                             |
| 14                |        | AC SOCKET                                 |
| 15                |        | CALL BELL PUSH                            |
| 16                |        | CALL BELL BUZZER                          |
| 17                |        | TV OUTLET                                 |
| 18                |        | TELEPHONE OUTLET                          |
| 19                |        | TELEPHONE TAG BLOCK                       |
| 20                |        | DISTRIBUTION BOARD (DB)                   |
| 21                |        | HANGING LIGHT                             |
| 22                |        | METER                                     |
| 23                |        | BOLLARD                                   |
| 24                |        | WATERPROOF LIGHT(SPH)                     |
| 25                |        | LAN                                       |
| 26                |        | U.S.B. POINT                              |
| 27                |        | FLOOR LIGHTS                              |

### DRAWING TITLE

ELECTRICAL PLAN

### JOB TITLE

SIXTH FLOOR PLAN

CLIENT NAME:-

MR. JASWANI

SCALE

N.T.S.

DATE

DRAWN BY:-

CKD BY:-

REVISION DATE:-

NORTH

SHEET NO.-



STRL CONSULTANTS:-

**AE** ANPEE-TECH ENGINEERS  
 CIVIL & STRUCTURAL CONSULTANTS  
 INDRAPRASTH APPT (G. FLOOR)  
 111/7 HARSH NAGAR KANPUR  
 MOB :- 9415039584, 9335036545

MEP CONSULTANTS:-

TRIVENI CONSULTING ENGINEERS

14/34 YAMAN SAHARA ESTATE,  
 JANKIPURAM, 226021,  
 (LUCKNOW)

PR :- 0522 - 433761

mail us at:-triveniconsultants.iko@gmail.com



Firm Name

VASTU SRAJAN


OMAHE HEIGHTS, CARLTON T 2, GP 001,  
 VIBHUTI KHAND, GOMTI NAGAR,  
 LUCKNOW-226010.

ph- 8799419194, 0522 4183370

e-mail- vastu.srajan@gmail.com

www.vastusrajan.com



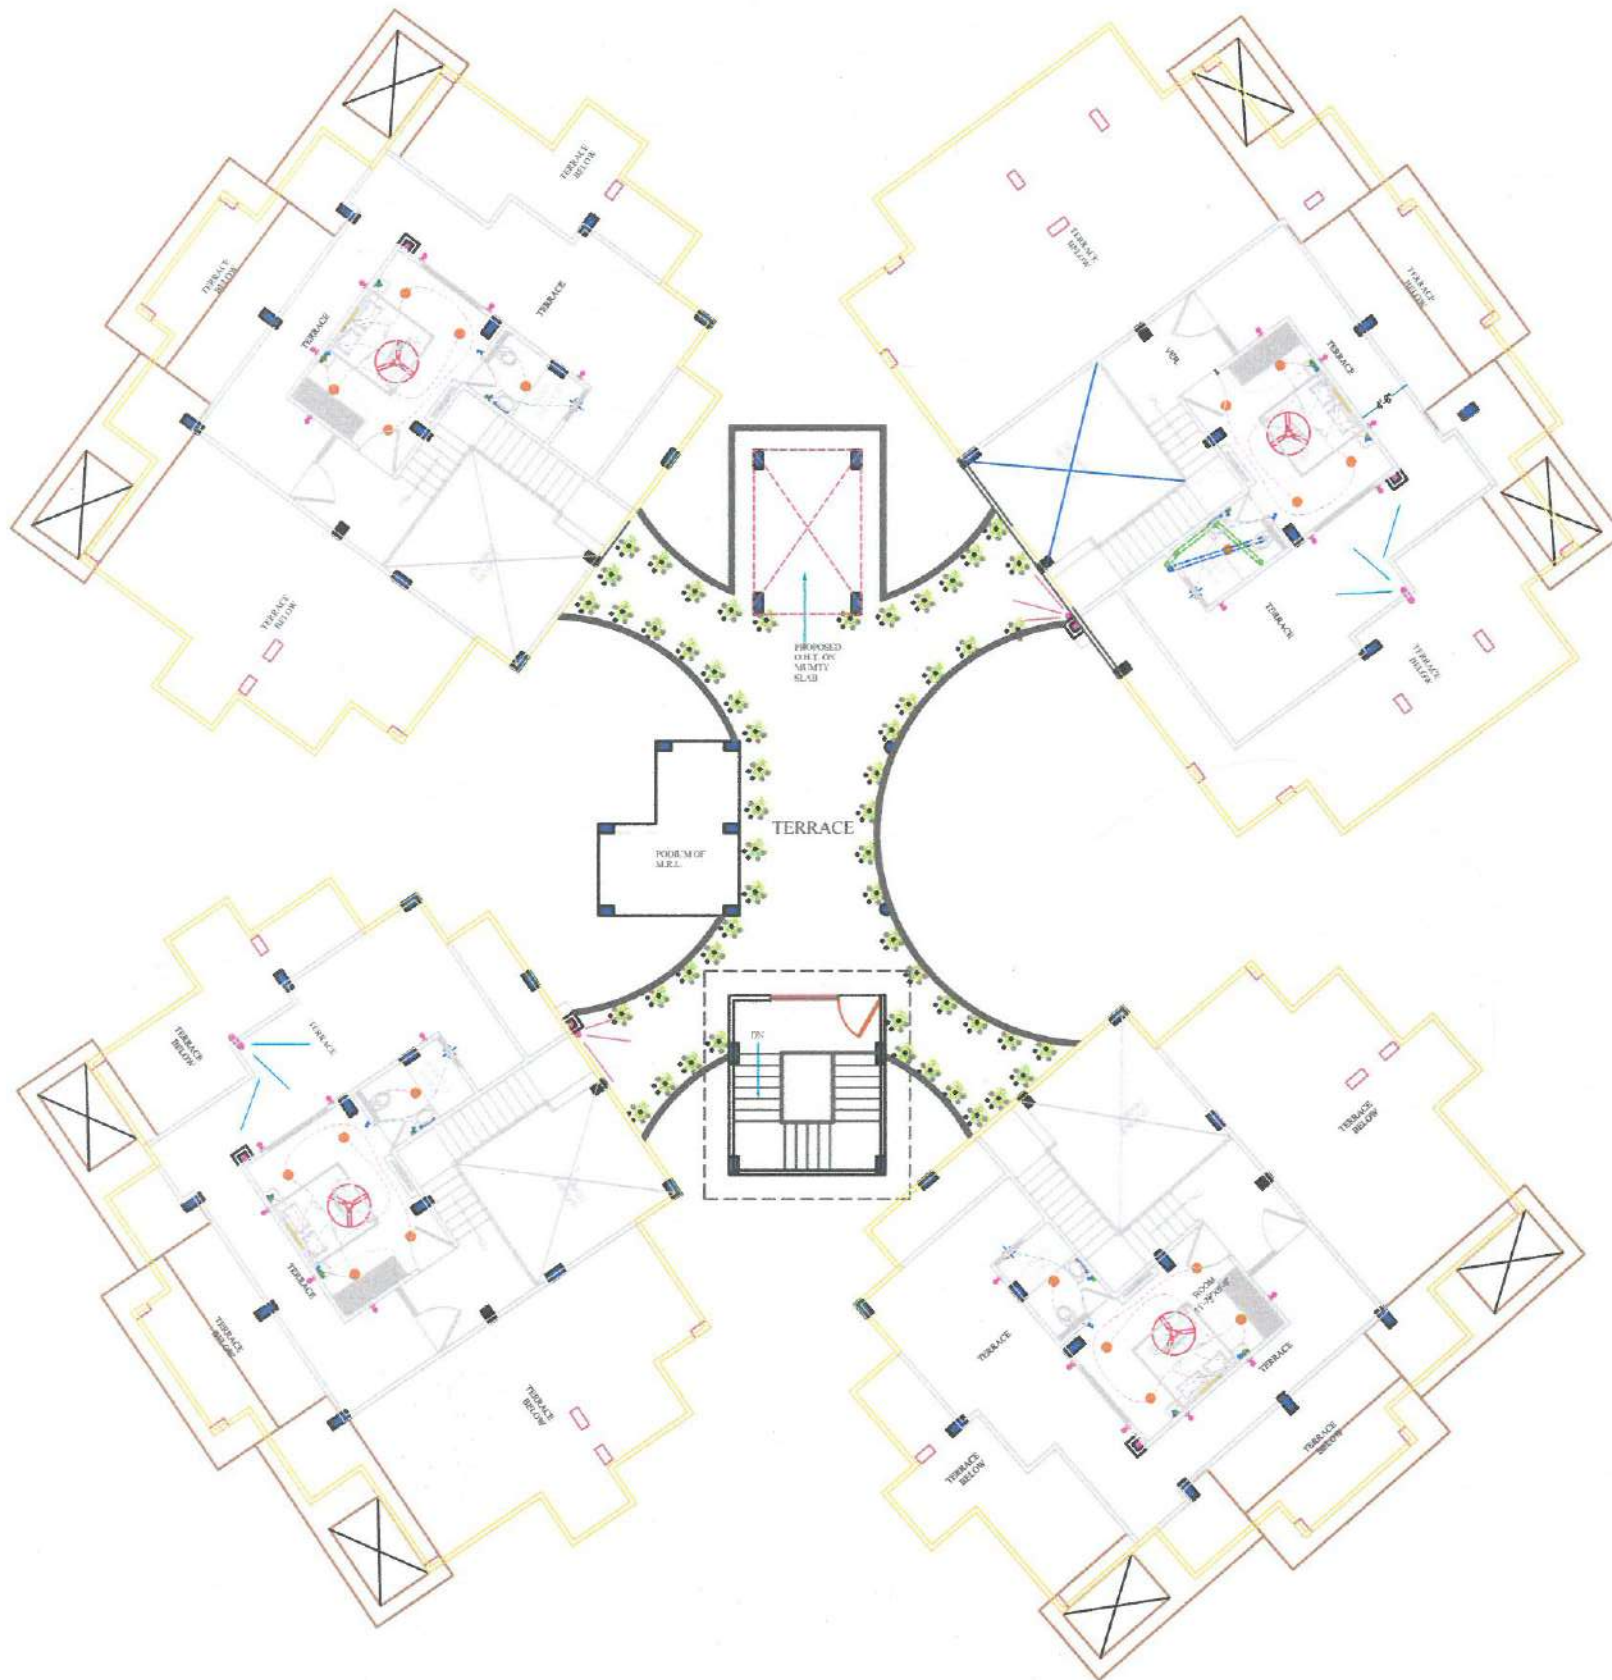

#### GENERAL NOTES:

1. ALL SWITCH BOARD SHALL BE FIXED AT +1200mm (BOTTOM OF BOX) FROM FINISHED FLOOR LEVEL & 200mm FROM WALL EDGE.
2. ALL 6/16 Amp. SWITCH SOCKET SHALL BE FIXED AT +300mm (BOTTOM OF BOX) FROM FINISHED FLOOR LEVEL.
3. ALL DISTRIBUTION BOARD SHALL BE FIXED AT +1400mm (BOTTOM OF BOX) FROM FINISHED FLOOR LEVEL AND CONCEALED IN 230mm THICK BRICK WALL.
4. ALL BRACKET/WALL MOUNTED FIXTURE SHALL BE FIXED AT +2100mm/ ABOVE DOOR, FROM FINISHED FLOOR LEVEL.
5. ALL T.V, TELEPHONE SOCKETS SHALL BE FIXED AT +300mm (BOTTOM OF BOX) FROM FINISHED FLOOR LEVEL.
6. TELEPHONE TAG BLOCK SHALL BE FIXED AT +300mm (BOTTOM OF BOX) FROM FINISHED FLOOR LEVEL.
7. ALL EX.FAN POINT IN TOILET SHALL BE FIXED AT +2250mm (BOTTOM OF BOX) FROM FINISHED FLOOR LEVEL.
8. ALL LIGHTING POWER CONDUIT SHALL BE OF 25mm Ø PVC WITH 2mm WALL THICKNESS (FRLS) TO BE USED IN WALL AND SLAB.
9. ALL T.V/TELEPHONE CONDUIT SHALL BE OF 25mm Ø PVC WITH 2mm WALL THICKNESS (FRLS) TO BE USED IN WALL AND SLAB.
10. ALL SUB MAIN CONDUIT SHALL BE OF 32/40mm Ø PVC WITH 2mm WALL THICKNESS (FRLS) TO BE USED IN WALL AND SLAB.

STR. CONSULTANTS:-

## PROPOSED HOUSING AT LUCKNOW

| ELECTRICAL LEGEND :- |        |                                           |
|----------------------|--------|-------------------------------------------|
| S.NO.                | SYMBOL | DESCRIPTION                               |
| 1                    |        | TWO WAY SWITCH BOARD (W/ 4-UP FROM FLOOR) |
| 2                    |        | SWITCH BOARD (W/ 4-UP FROM FLOOR)         |
| 3                    |        | DEEP                                      |
| 4                    |        | 1x15W BRACKET LIGHT                       |
| 5                    |        | 1x15W WALL MOUNTED TUBE LIGHT             |
| 6                    |        | STREET LIGHT                              |
| 7                    |        | 1x100W EXHAUST FAN                        |
| 8                    |        | 6A SOCKET FOR EXHAUST FAN                 |
| 9                    |        | CEILING FAN                               |
| 10                   |        | FLOOR MOUNTED LIGHT                       |
| 11                   |        | 6A SWITCH SOCKET                          |
| 12                   |        | 6/16A SPIN SWITCH SOCKET                  |
| 13                   |        | GEYSER SOCKET                             |
| 14                   |        | AC SOCKET                                 |
| 15                   |        | CALL BELL PUSH                            |
| 16                   |        | CALL BELL BUZZER                          |
| 17                   |        | TV OUTLET                                 |
| 18                   |        | TELEPHONE OUTLET                          |
| 19                   |        | TELEPHONE TAG BLOCK                       |
| 20                   |        | DISTRIBUTION BOARD (DB)                   |
| 21                   |        | HANGING LIGHT                             |
| 22                   |        | METER                                     |
| 23                   |        | BOLLARD                                   |
| 24                   |        | WATERPROOF LIGHT(SWP)                     |
| 25                   |        | LAN                                       |
| 26                   |        | USB PORT                                  |
| 27                   |        | FLOOR LIGHTS                              |

### DRAWING TITLE

ELECTRICAL PLAN

### JOB TITLE

SEVENTH FLOOR PLAN

CLIENT NAME:-

MR. JASWANI

SCALE

N.T.S.

DATE

DRAWN BY:-

CKD BY:-

REVISION DATE:-

NORTH

SHEET NO.:-



STR. CONSULTANTS:-



ANPEE-TECH ENGINEERS  
CIVIL & STRUCTURAL CONSULTANTS  
INDRAPRASTH APPT (G. FLOOR)  
111/7 HARSH NAGAR KANPUR  
MOB :- 9415039584, 9335039545

MEP CONSULTANTS:-

TRIVENI CONSULTING ENGINEERS

1434 YAMAN SAHARA ESTATE,  
JANKIPURAM, 226021,  
(LUCKNOW)  
PH :- 0522 - 4333761

mail us at:- triveniconsultants.lko@gmail.com



Firm Name

VASTU SRAJAN

OMAXE HEIGHTS, CARLTON T 2, GF 001,  
VIBHUTI KHAND, GOMTI NAGAR,  
LUCKNOW-226010.

ph- 8799419194, 0522 4103370

e-mail- vastu.srajan@gmail.com

www.vastusrajan.com

