


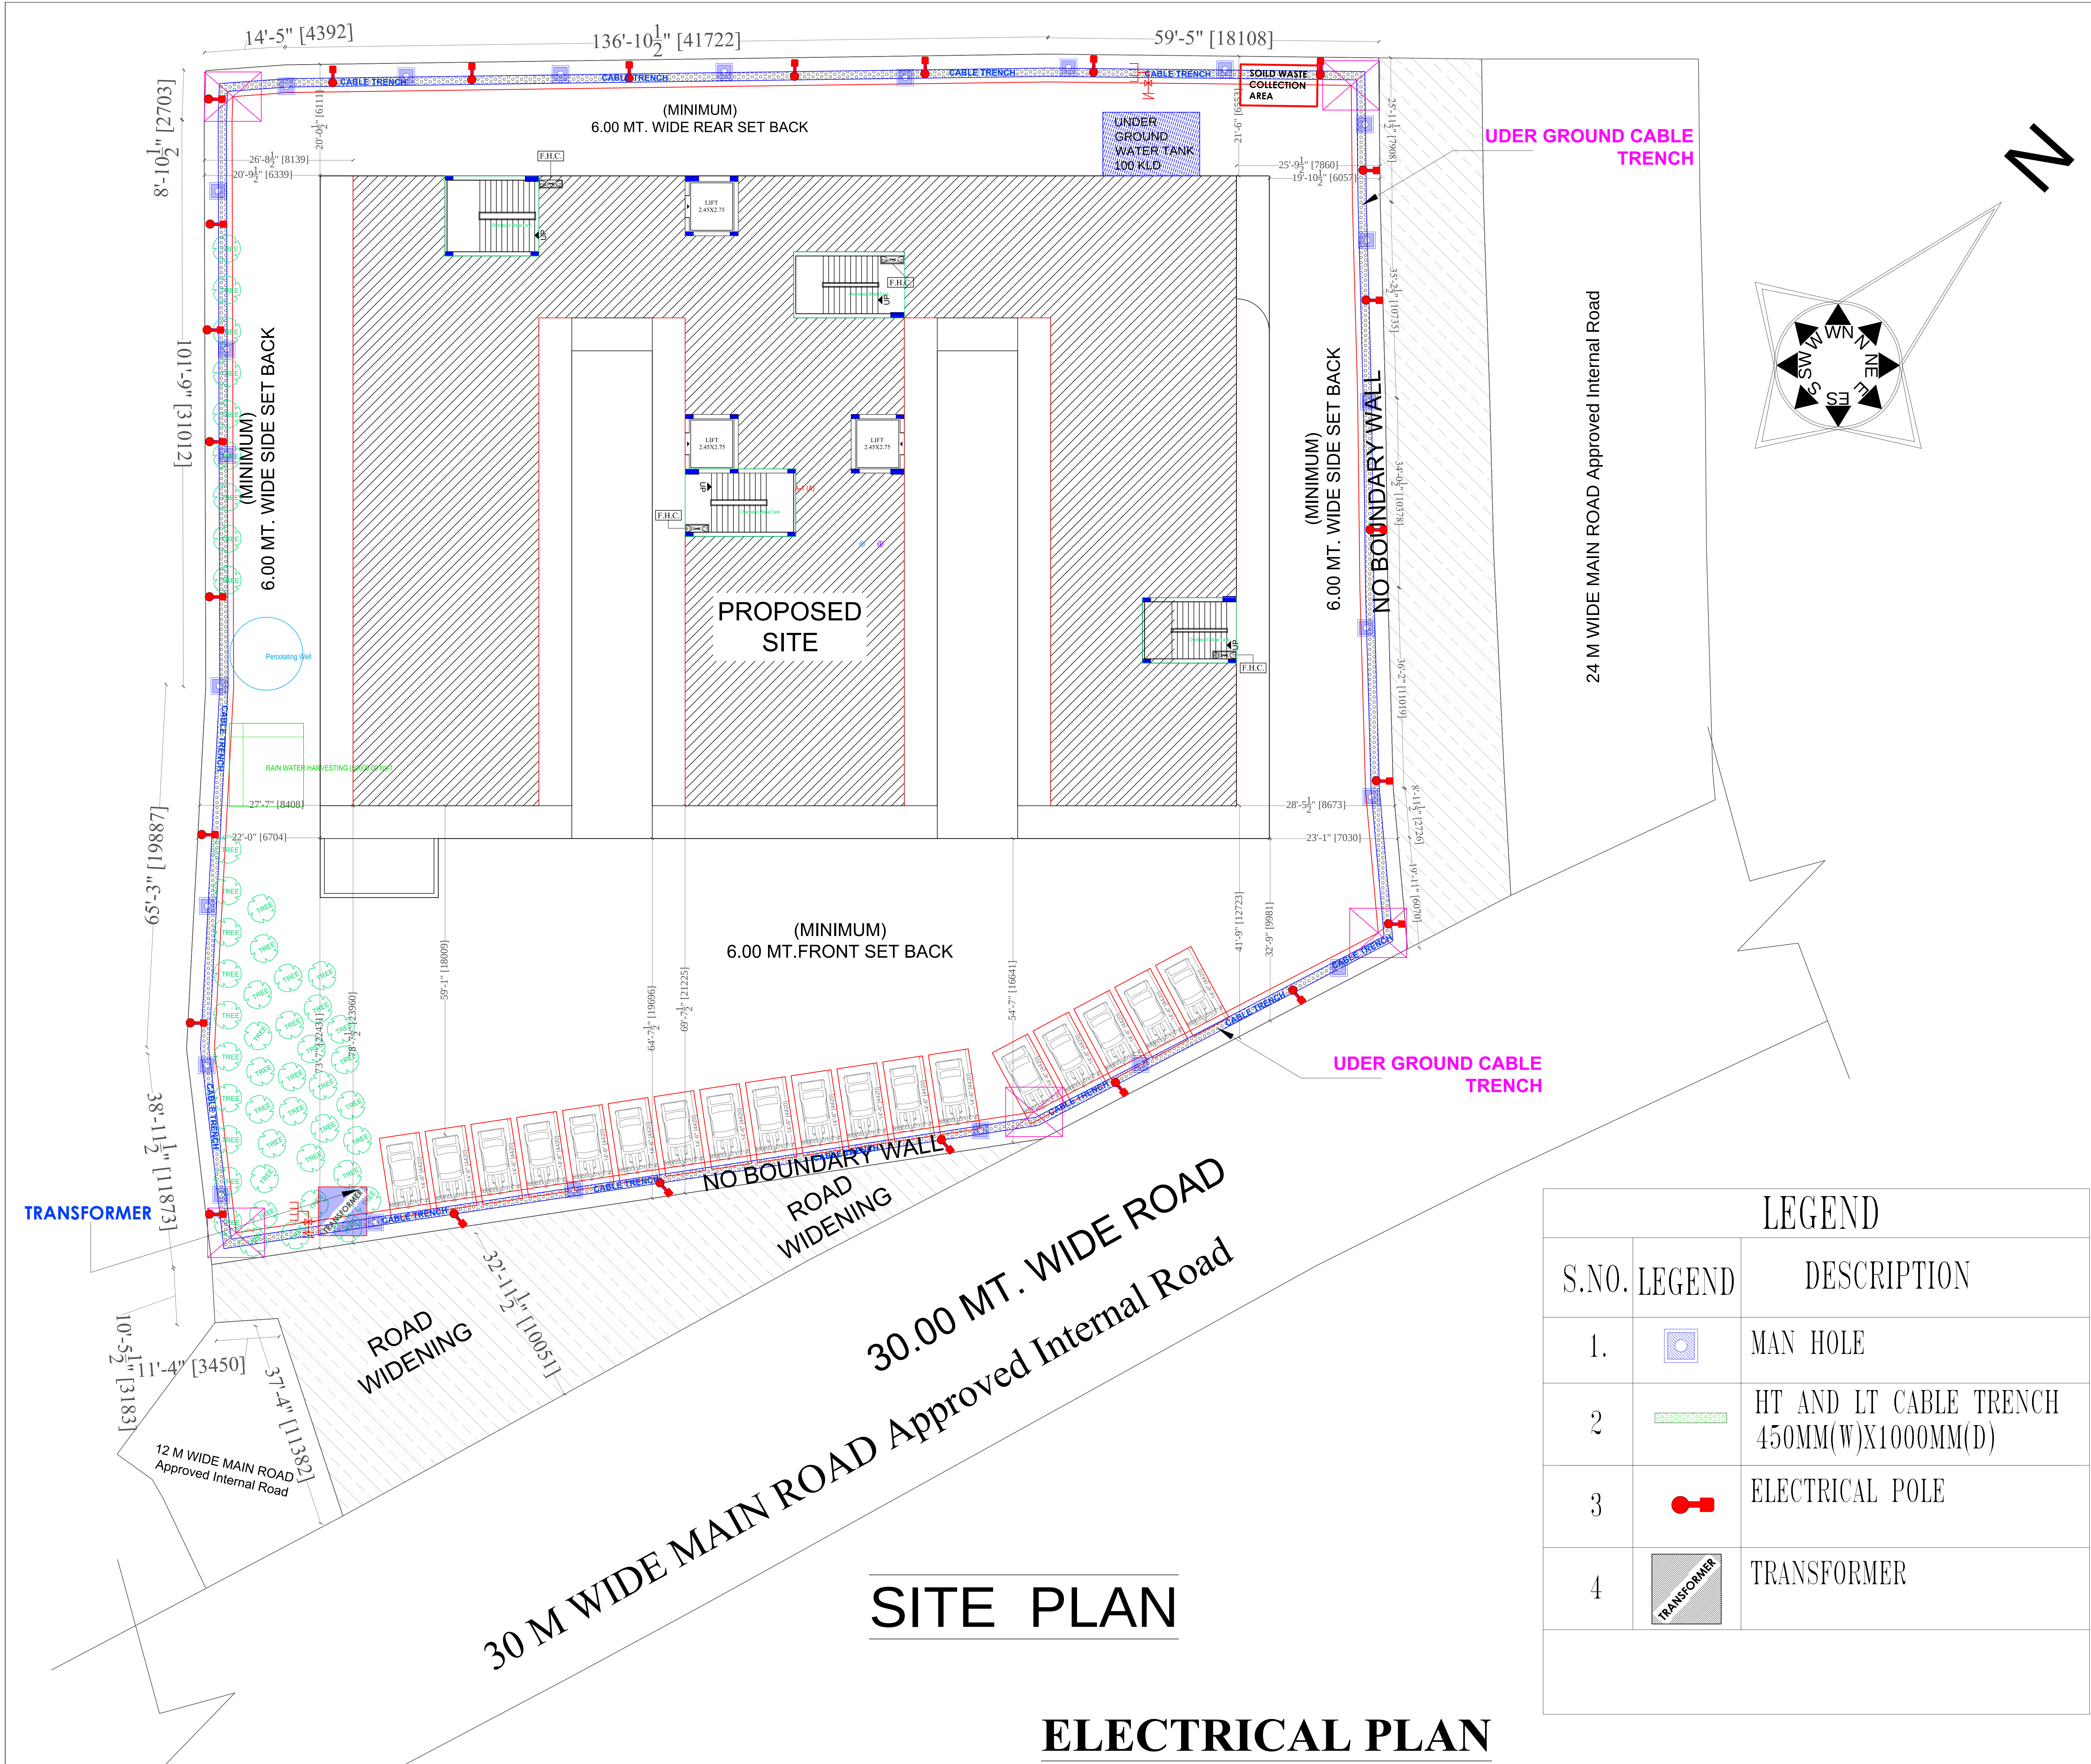

SITE PLAN

ELECTRICAL PLAN

LEGEND		
S.NO.	LEGEND	DESCRIPTION
1.		MAN HOLE
2		HT AND LT CABLE TRENCH 450MM(W)X1000MM(D)
3		ELECTRICAL POLE
4		TRANSFORMER

APPROVAL OF G.D.A.:

PROJECT TITLE:

Density

sheet number 01

DWN BY:

CKD BY:

OWNER SIGN.

ACORE ARCHITECTURAL SERVICES PVT. LTD
ARCHITECT:ASHISH SRIVASTAVA
(B. ARCH)
BRANCH OFFICE : 935/D MATRI ANCHAL NEAR
GORAKHNATH RAILWAY CROSSING GORAKHPUR
TEL: OFF:3294813,RESI:2255290, MOBILE:9415321836.