


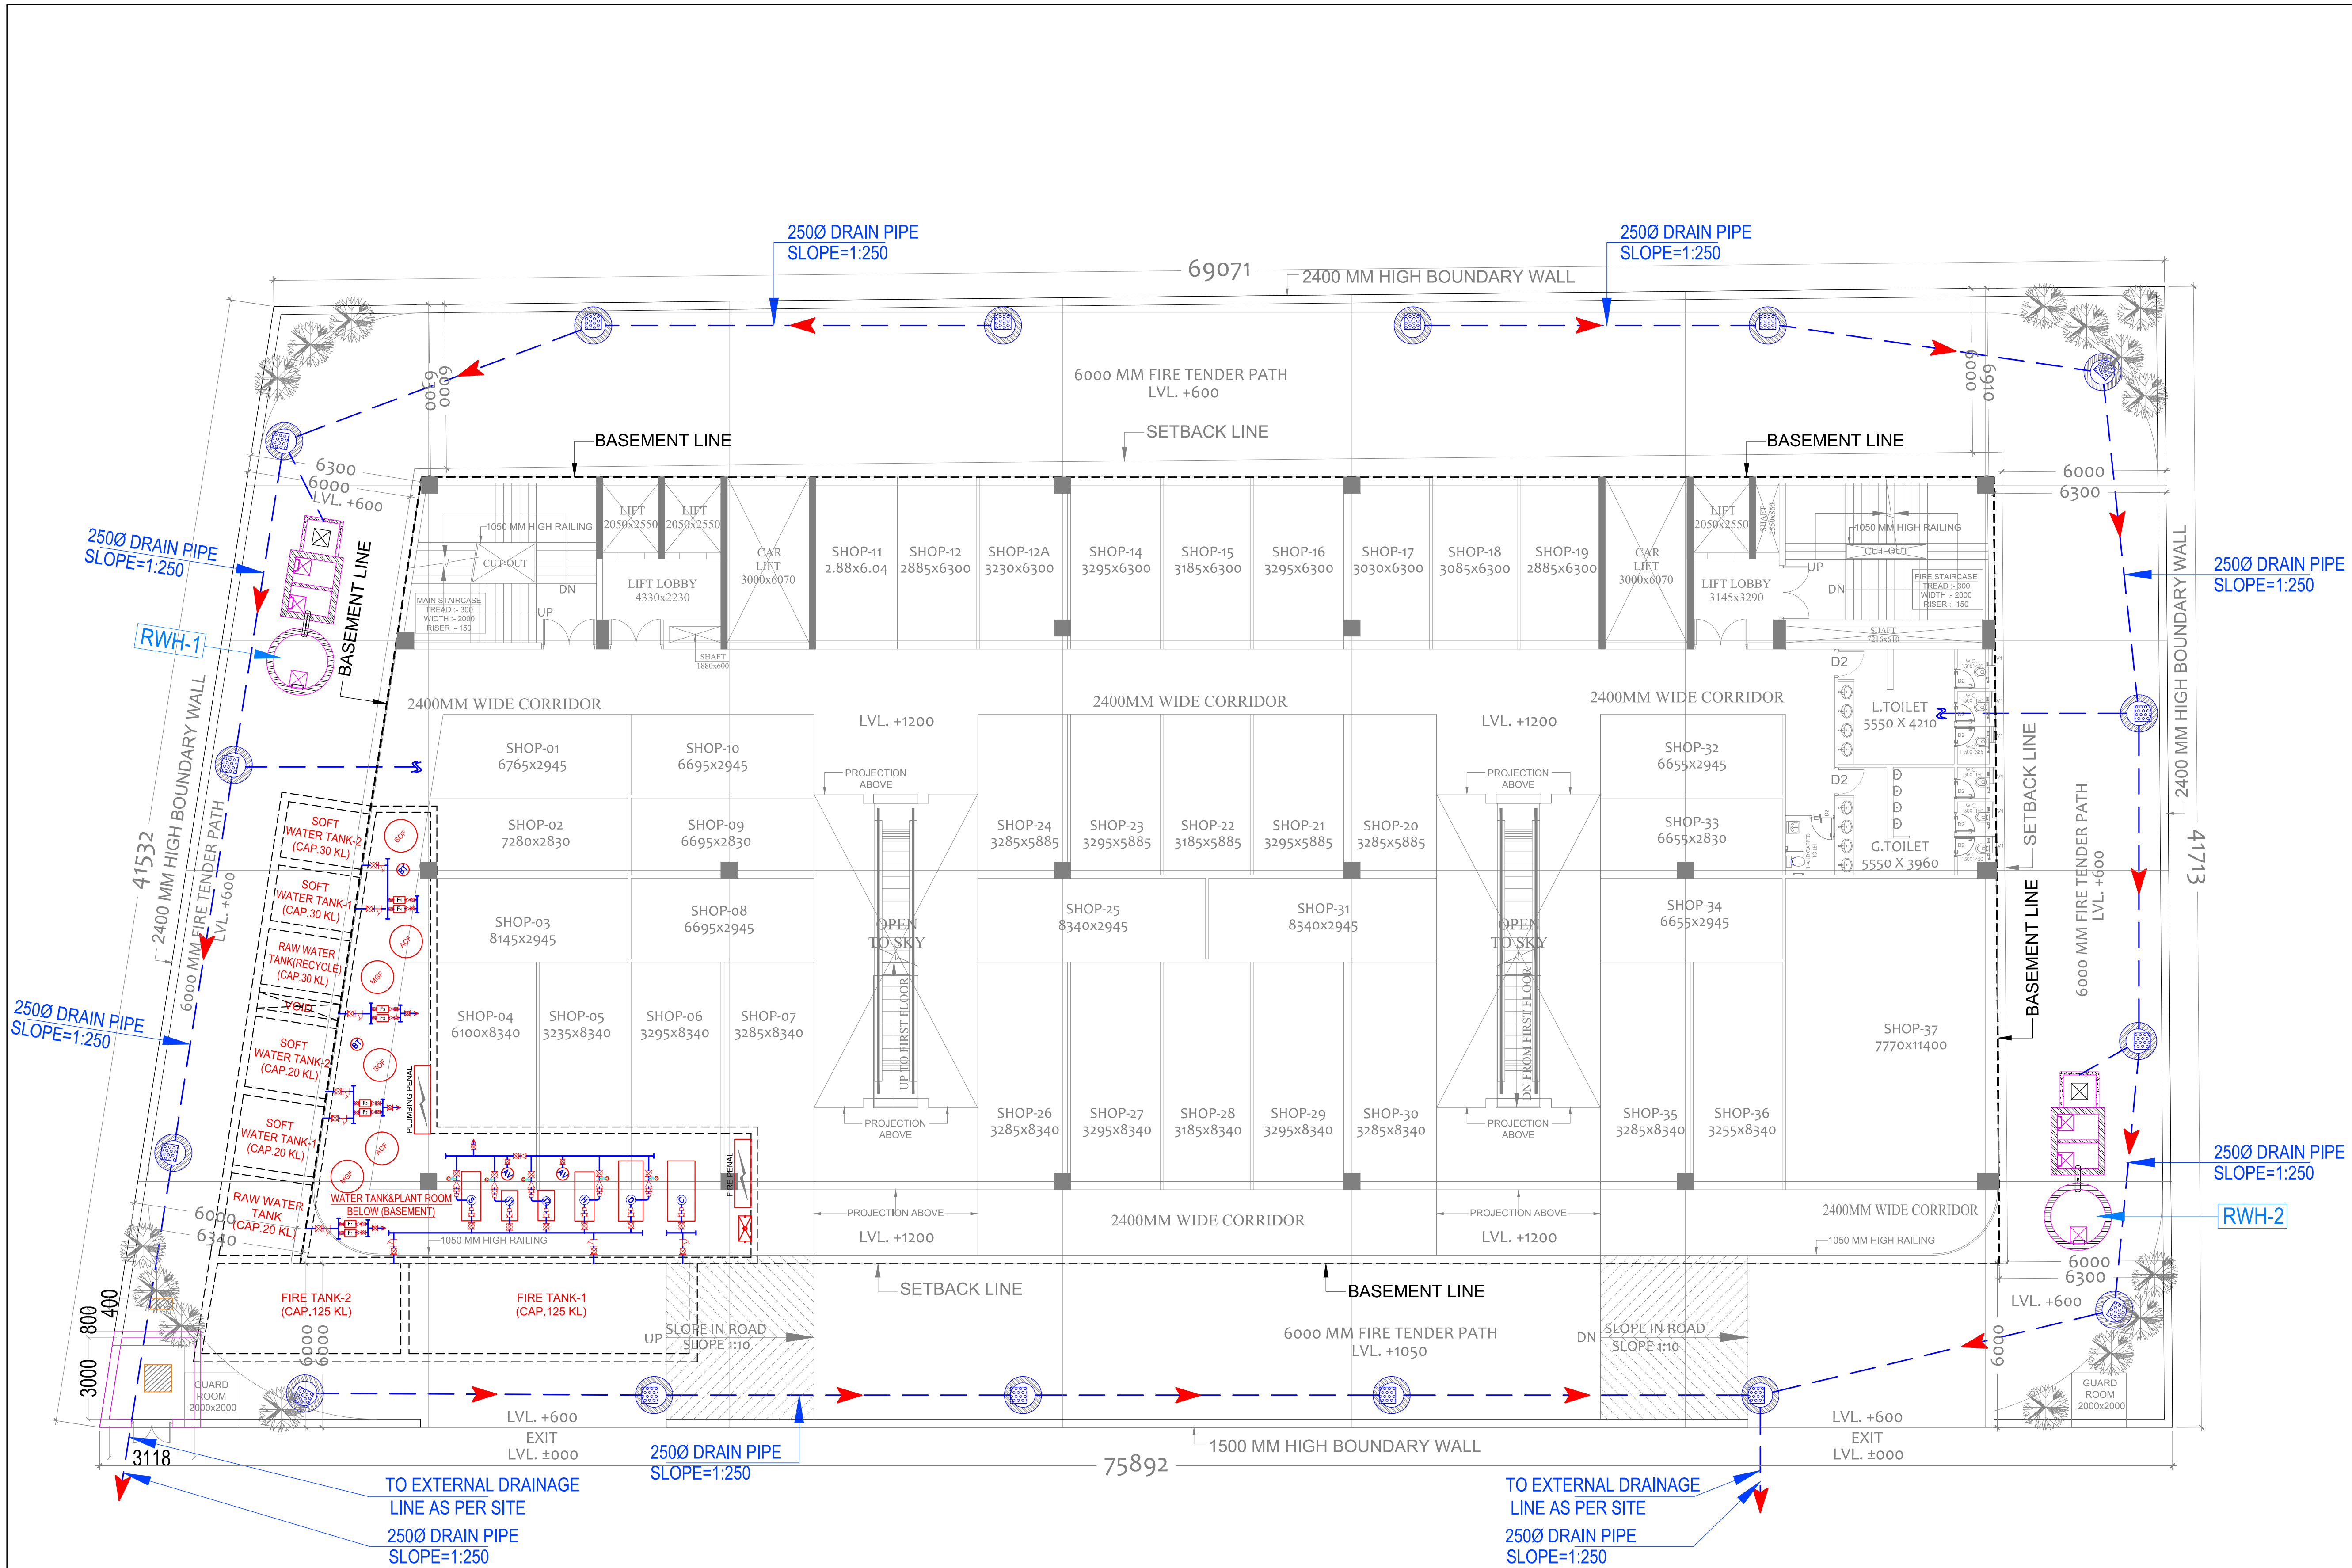

LEGEND : PLUMBING SYSTEM		
S. No.	SYMBOL	DESCRIPTION
1.	C.P.	CATCH PIT
2.	—	DRAINAGE LINE
3.	RWH	RAIN WATER HARVESTING
4.	---	BASEMENT RETAINING WALL

rev. no.	date	revision
..	..	..

project
PROPOSED SUBMISSION DRAWING FOR
COMMERCIAL CENTER-05, DUDA HERA, GHAZIABAD, UP.

Owner
GOLD COAST DEVELOPERS PVT. LTD.
A-106, POCKET-4, PANDAV NAGAR, MAYUR VIHAR, DELHI- 110091

title
SITE PLAN

subtitle
EXTERNAL DRAINAGE LAYOUT

drawing released for
☐ APPROVAL ☒ SUBMISSION
☐ ADVANCE COPY ☐ CONSTRUCTION

drg. no. CES / G.C / SP / P-02 drawn by Sandeep

scale 1:125 @ A1 designed by Shakir Shabbir

date 16.09.2021 checked by Anand Havelia

architects :
modarchindia
architects interior designers & planners
studio: 1st floor, B-99, sector-63, Noida -201301, U.P.
phone: 0120-4206253, email: amitganga@hotmail.com
website: www.modarch.in

services consultant
Consummate Engineering Services (P) Ltd.
Noida Office : B - 67, Sector - 67, Noida - 201 301
Tel : (0120) 2303300 (30 Lines)
Lko. Office : R 006, Rohas Plumeria, Gomti Nagar, Lucknow
e mail : mail@cespl.in, website : www.cespl.in