


GROUND [STILT] FLOOR PLAN
SCALE 1:200

ELECTRICAL SERVICES SHOWN THUS

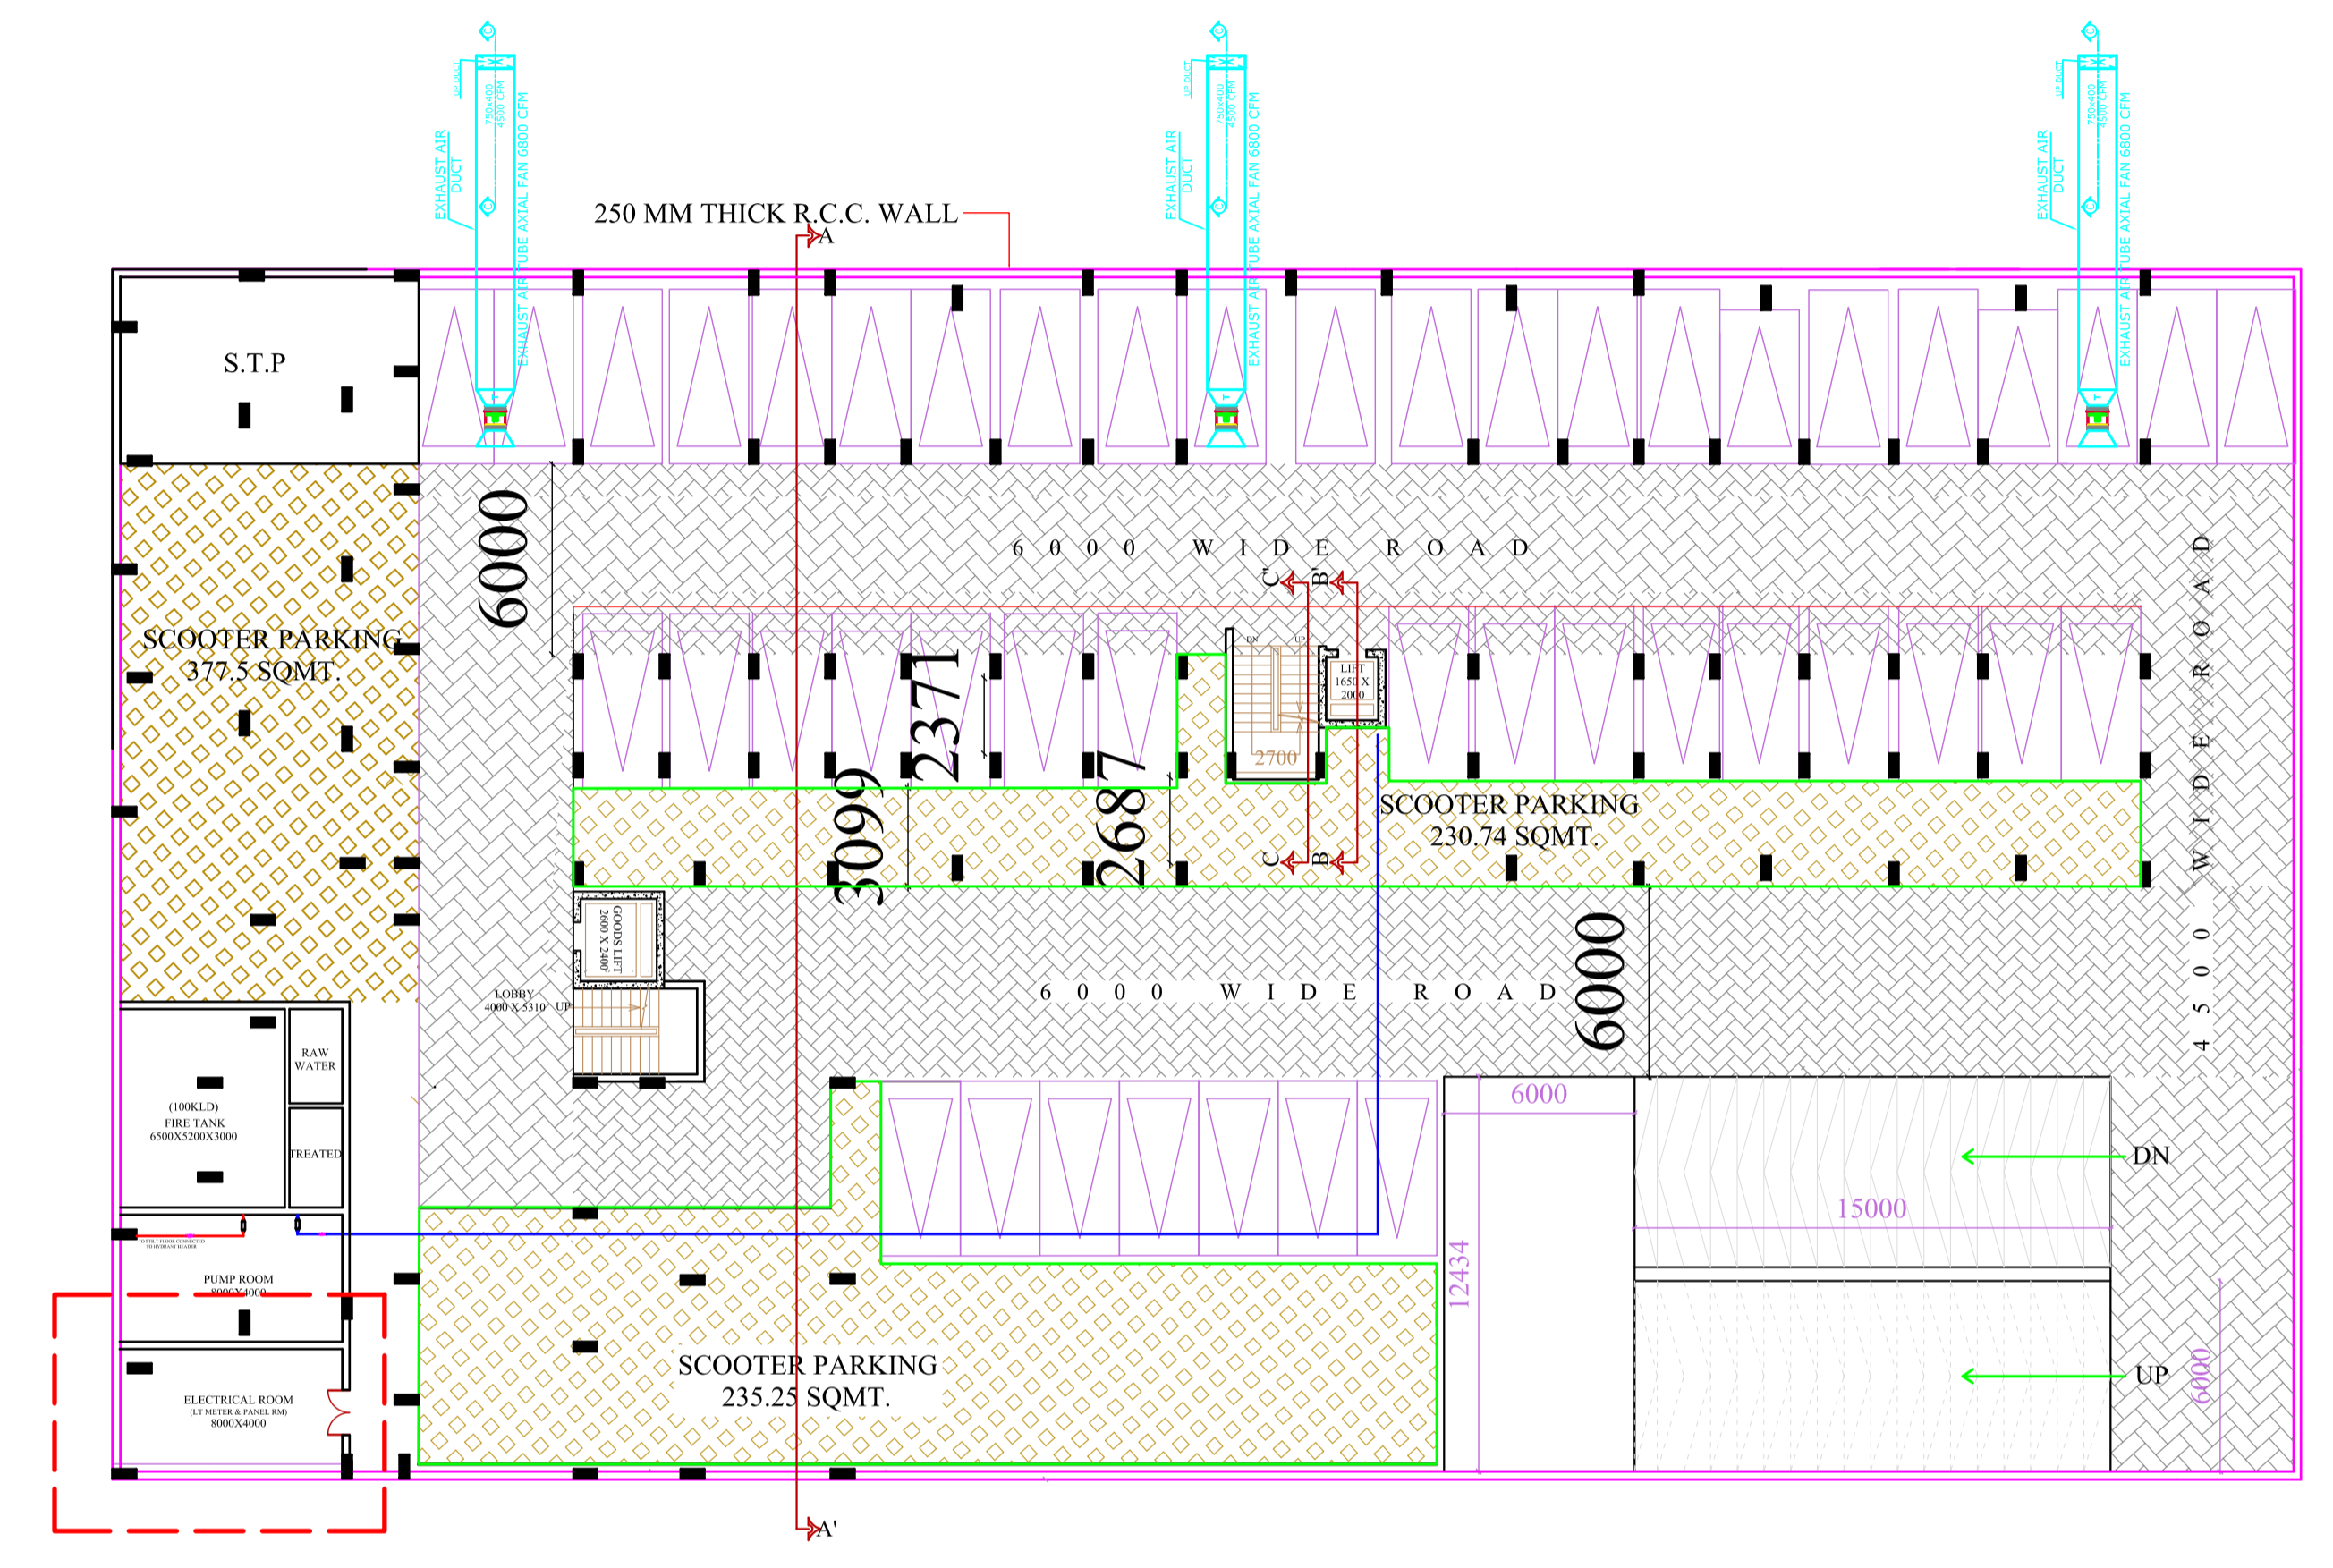

1st & 2nd BASEMENT FLOOR
PLAN SCALE 1:200

PROJECT :
PROPOSED GROUP HOUSING FOR G.S.R. BUILDERS & DEVELOPERS PVT. LIMITED ON PROJECT KALP CITY, AT VILLAGE - BIJNOUR, PARGANA - BIJNOUR, TEHSIL & DISTT. - LUCKNOW.

DRG. TITLE : **LAYOUT PLAN OF ELECTRICAL SERVICES**

SCALE : AS SHOWN SHEET NO. :

DATE. :

DRAWN BY.

NORTH :

OWNER'S SIGN.

ARCHITECT'S SIGN.

ARCHITECT :
AR. SUNIL SRIVASTAVA

CONSULTANTS :
DESIGNER'S WING

414-A & 426-B 4TH FLOOR SAHARA SHOPPING CENTRE FAIZABAD ROAD,LUCKNOW-226016
CELL- 9415150500 ,
TEL & FAX :- 0522-2311748,4009712
EMail : designers_wing@yahoo.com
Website : www.designerswing.org