
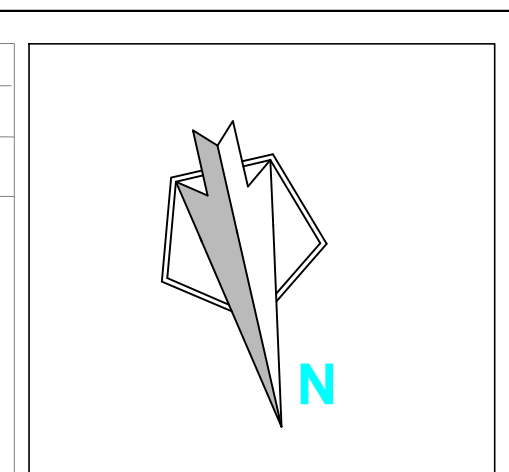


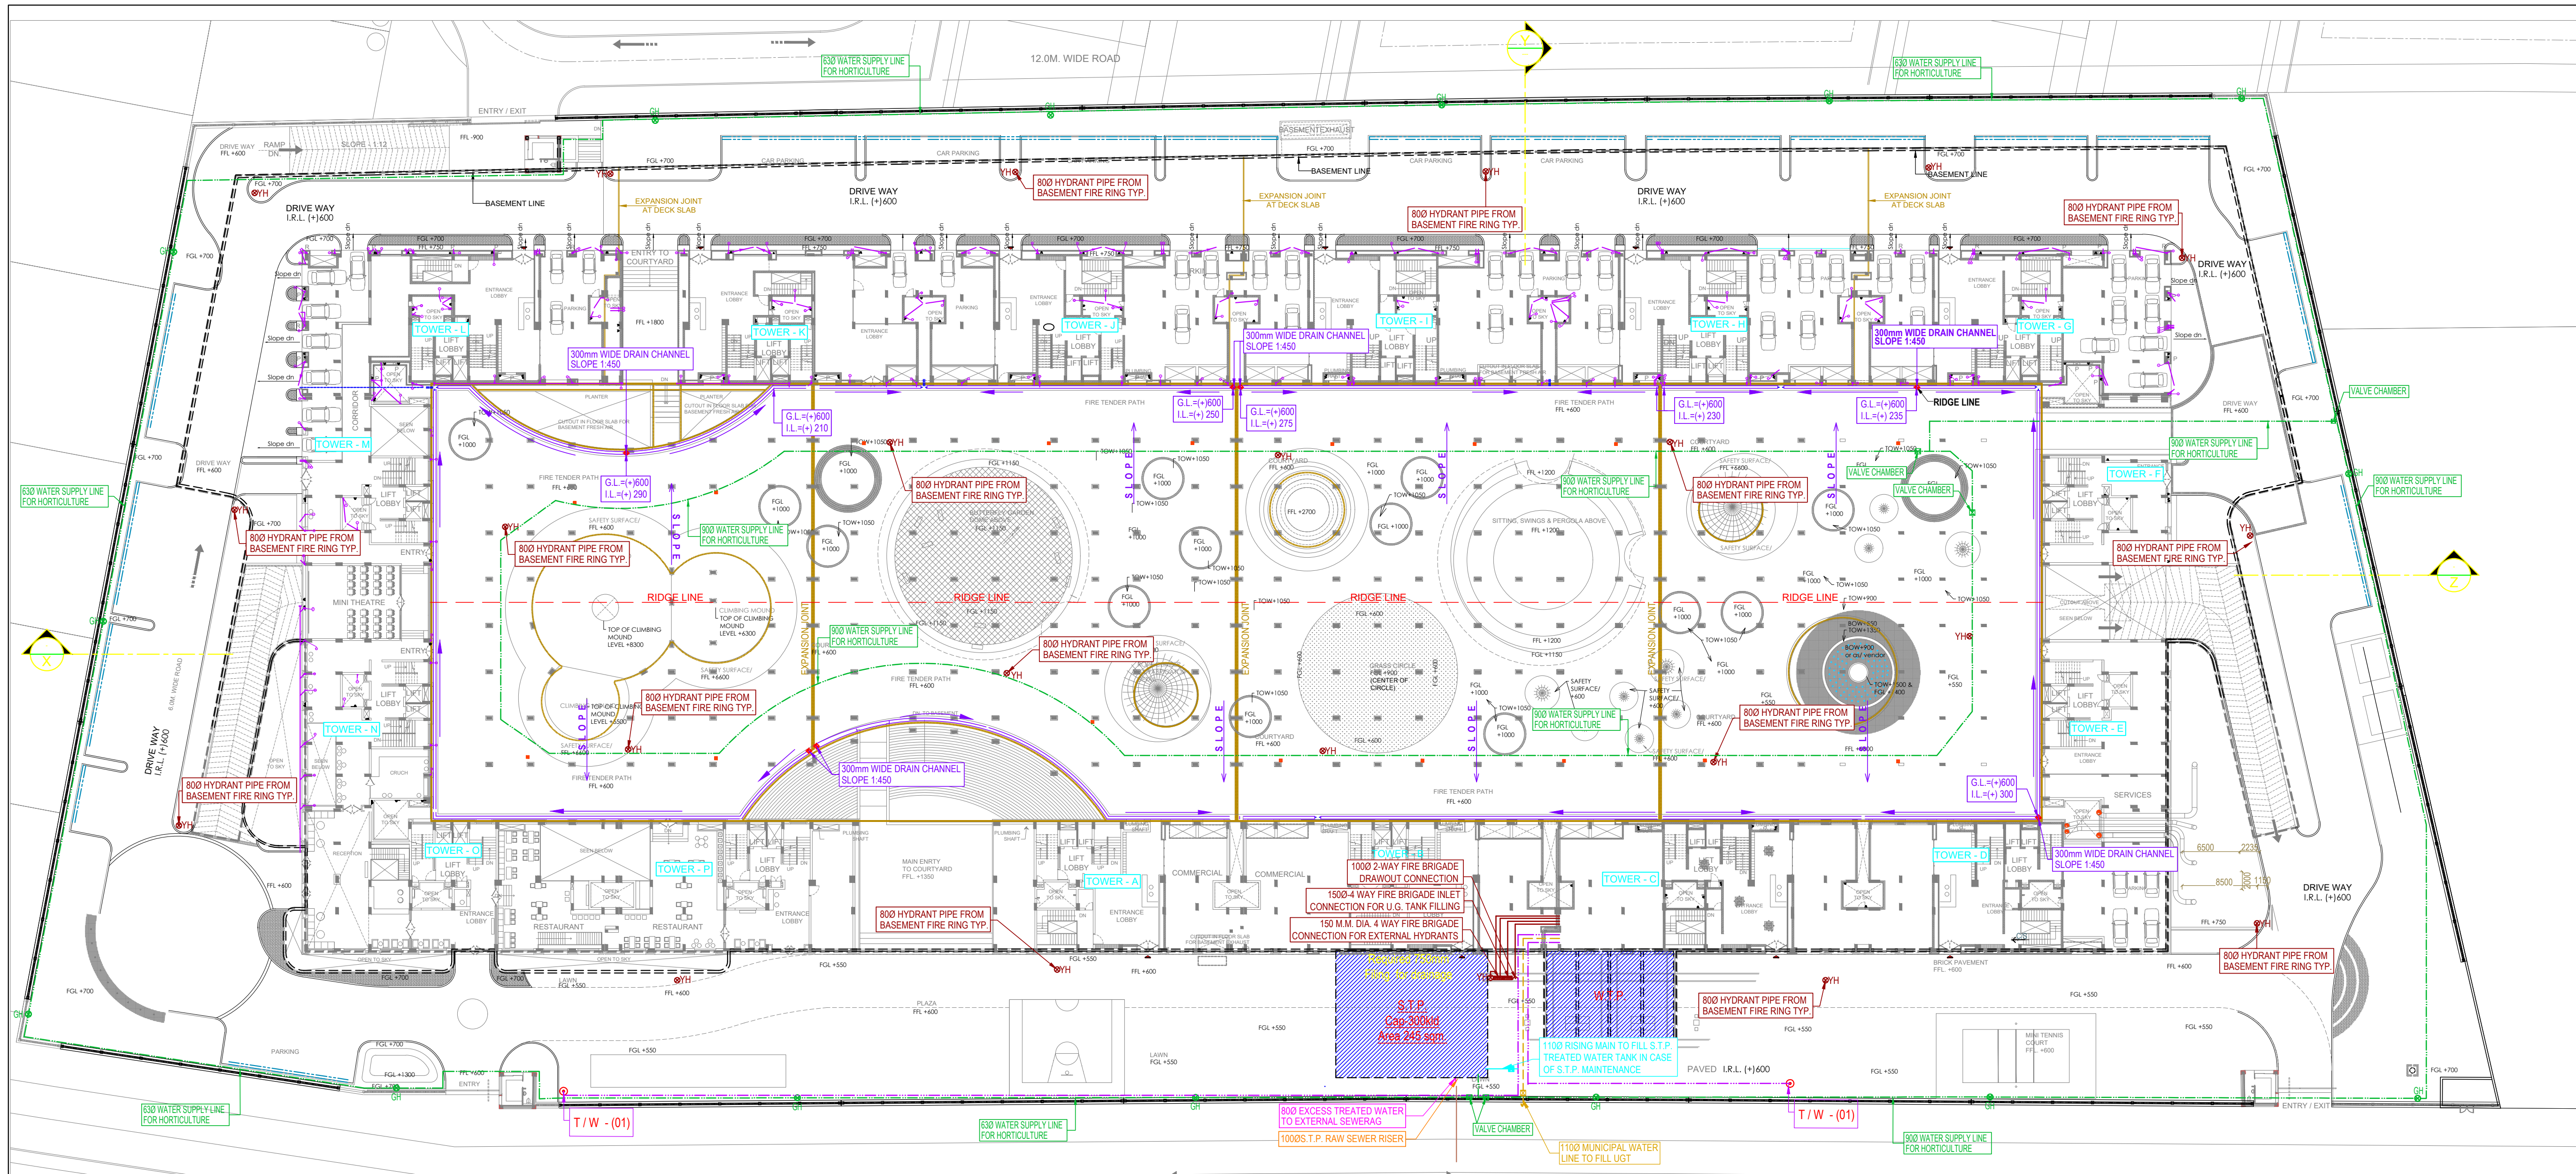

LEGEND :		
S. No.	SYMBOL	DESCRIPTION
1.		FIRE LINE
2.		YARD HYDRANT 63 M.M. DIA. SINGLE HEADED HYDRANT VALVE WITH 2 NOS. 15 M. LONG, 63 M.M. DIA. FIRE HOSE PIPE & 1 NO. BRANCH PIPE WITH NOZZLE
3.		FIRE BRIGADE CONNECTION
4.		BUTTERFLY VALVE
5.		NONRETURN VALVE (CHECK VALVE)
6.		ISOLATING VALVE WITH MASONARY CHAMBER

ALL YARD HYDRANT SHALL BE CONNECTED FROM
BASEMENT HYDRANT PIPE

LEGEND :		
S. No.	SYMBOL	DESCRIPTION
1.	M.H.	MANHOLE
2.		SEWER LINE
3.	C.P.	CATCH PIT
4.		UNDER GROUND PIPE DRAIN
5.		CATCH PIT (500x450mm)
6.		RIISING MAIN LINE (FROM TW TO U.G.T.)
7.		MUNICIPAL WATER SUPPLY PIPE LINE.
8.		RECYCLED WATER SUPPLY LINE FOR HORTICULTURE
9.		PROPOSED TUBE WELL
10.	GH	GARDEN HYDRANT
11.		BASEMENT RETAINING WALL
12.		RAIN WATER HARVESTING
13.		MASONRY CHAMBER FOR ISOLATING VALVE
14.		SAUCER DRAIN
15.		
16.		
17.		
18.		
19.		
20.		
F.L.		FORMATION LEVEL
I.L.		INVERT LEVEL
C.L.		CONNECTION LEVEL
I.R.L.		INTERNAL ROAD LEVEL

rev. no.	date	revision
project ORANGE CASTLE AT LUCKNOW		
title Water Supply plan		
subtitle SITE PLAN		
drawing released for ☒ APPROVAL ☐ SUBMISSION ☐ ADVANCE COPY ☐ CONSTRUCTION		
drg. no. CES / OC / SP - 01	drawn by S.Bhandari	
scale 1 : 400	designed by Shakir Shabbir	
date 07.02.2020	checked by Anand Havella	
architects ARCHHOM c-28c, sector-8, noida - 201301 (up), tel : 91 120 46 40 300, fax : 91 120 42 46 788 mail@archhom.com www.archhom.com		
services consultant Consummate Engineering Services (P) Ltd. Noida Office : B - 67, Sector - 67, Noida - 201 301 Tel : (0120) 2303500 (30 Lines) Lko. Office : R 006, Rohtas Plumeria, Gomti Nagar, Lucknow e mail : mail@cespl.in, website : www.cespl.in		