
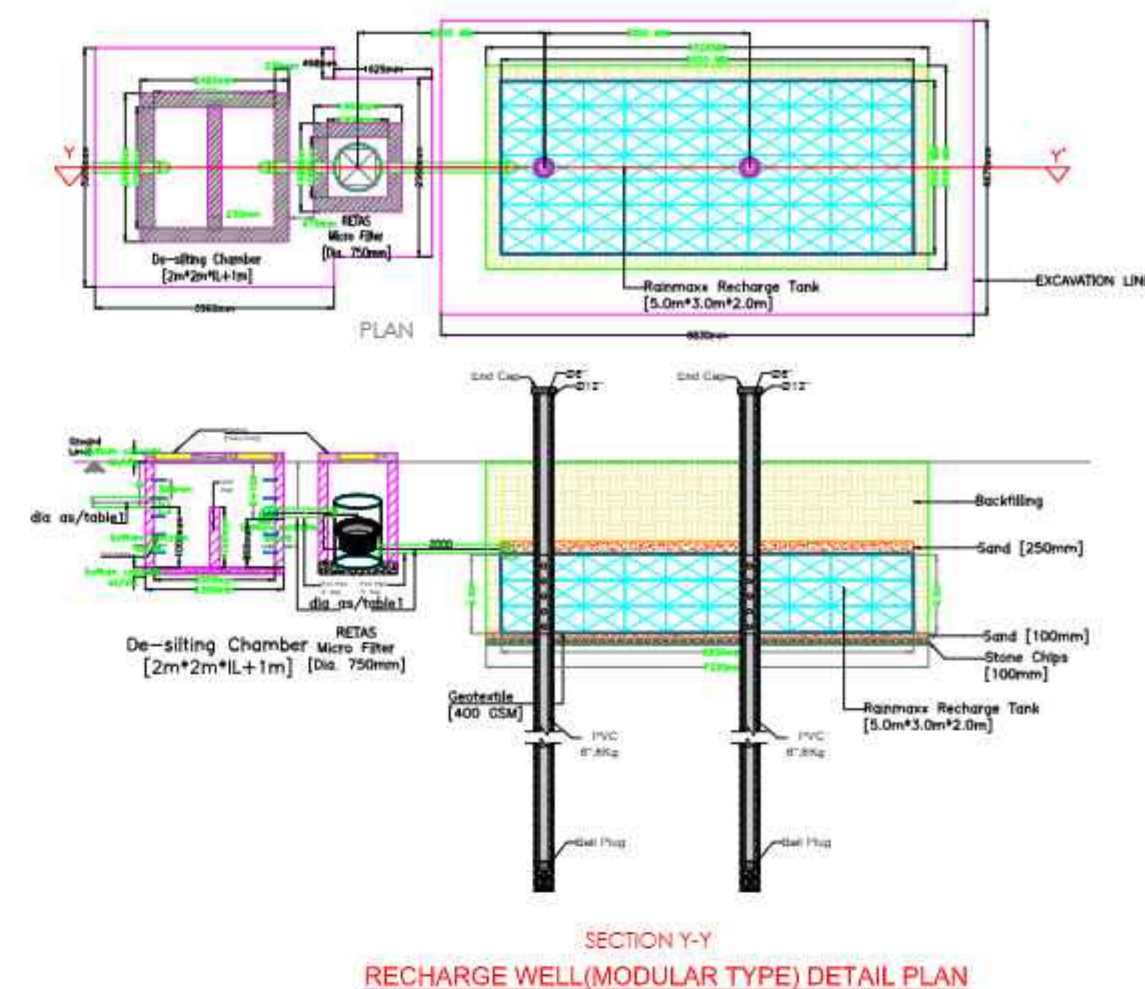
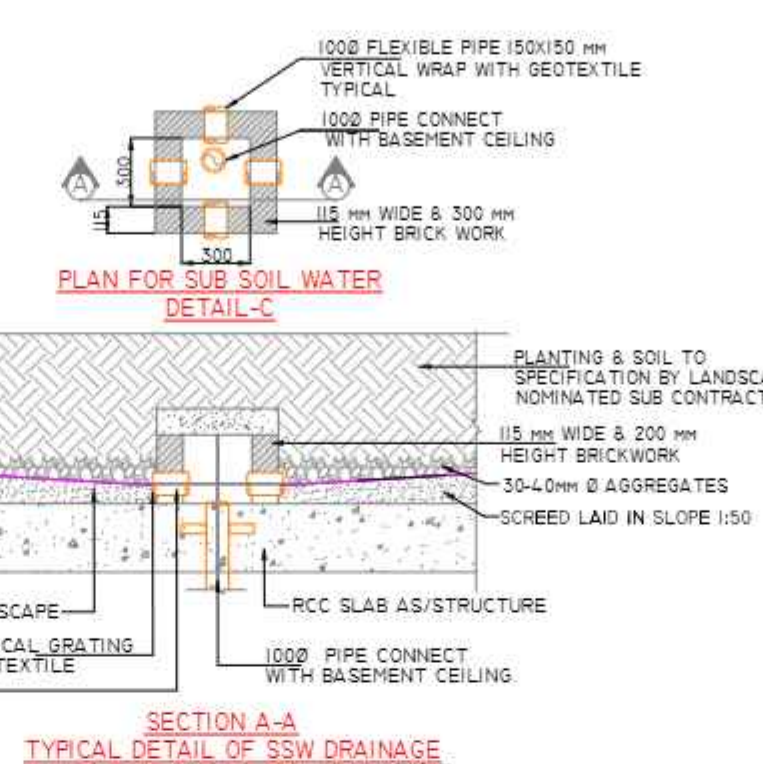
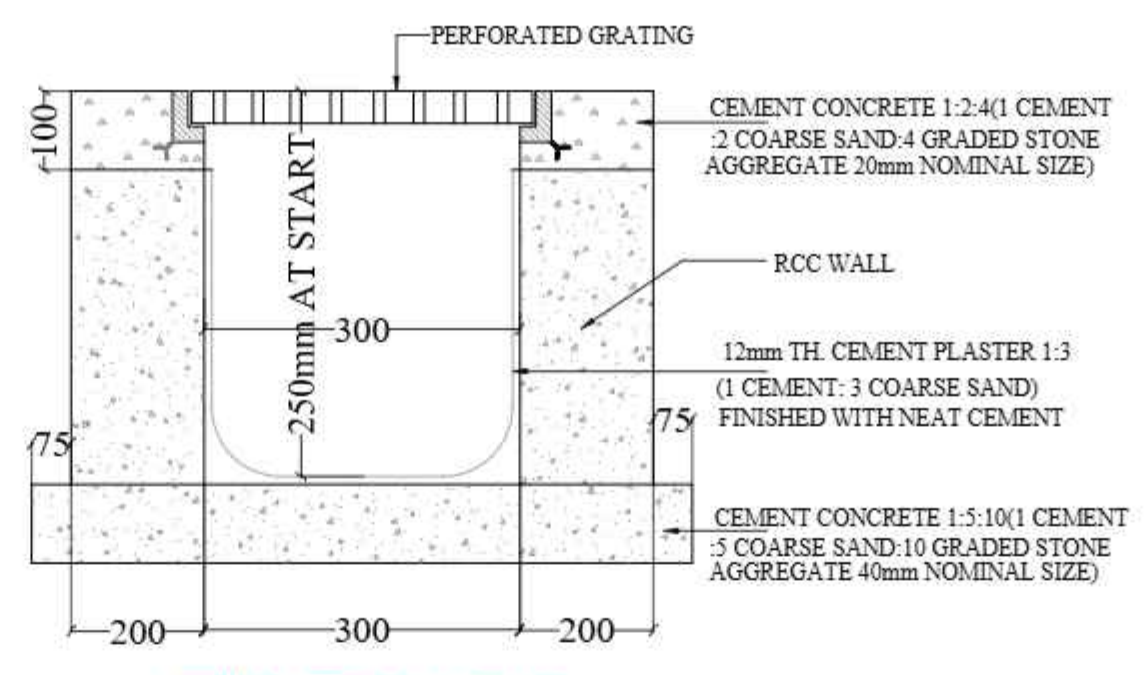


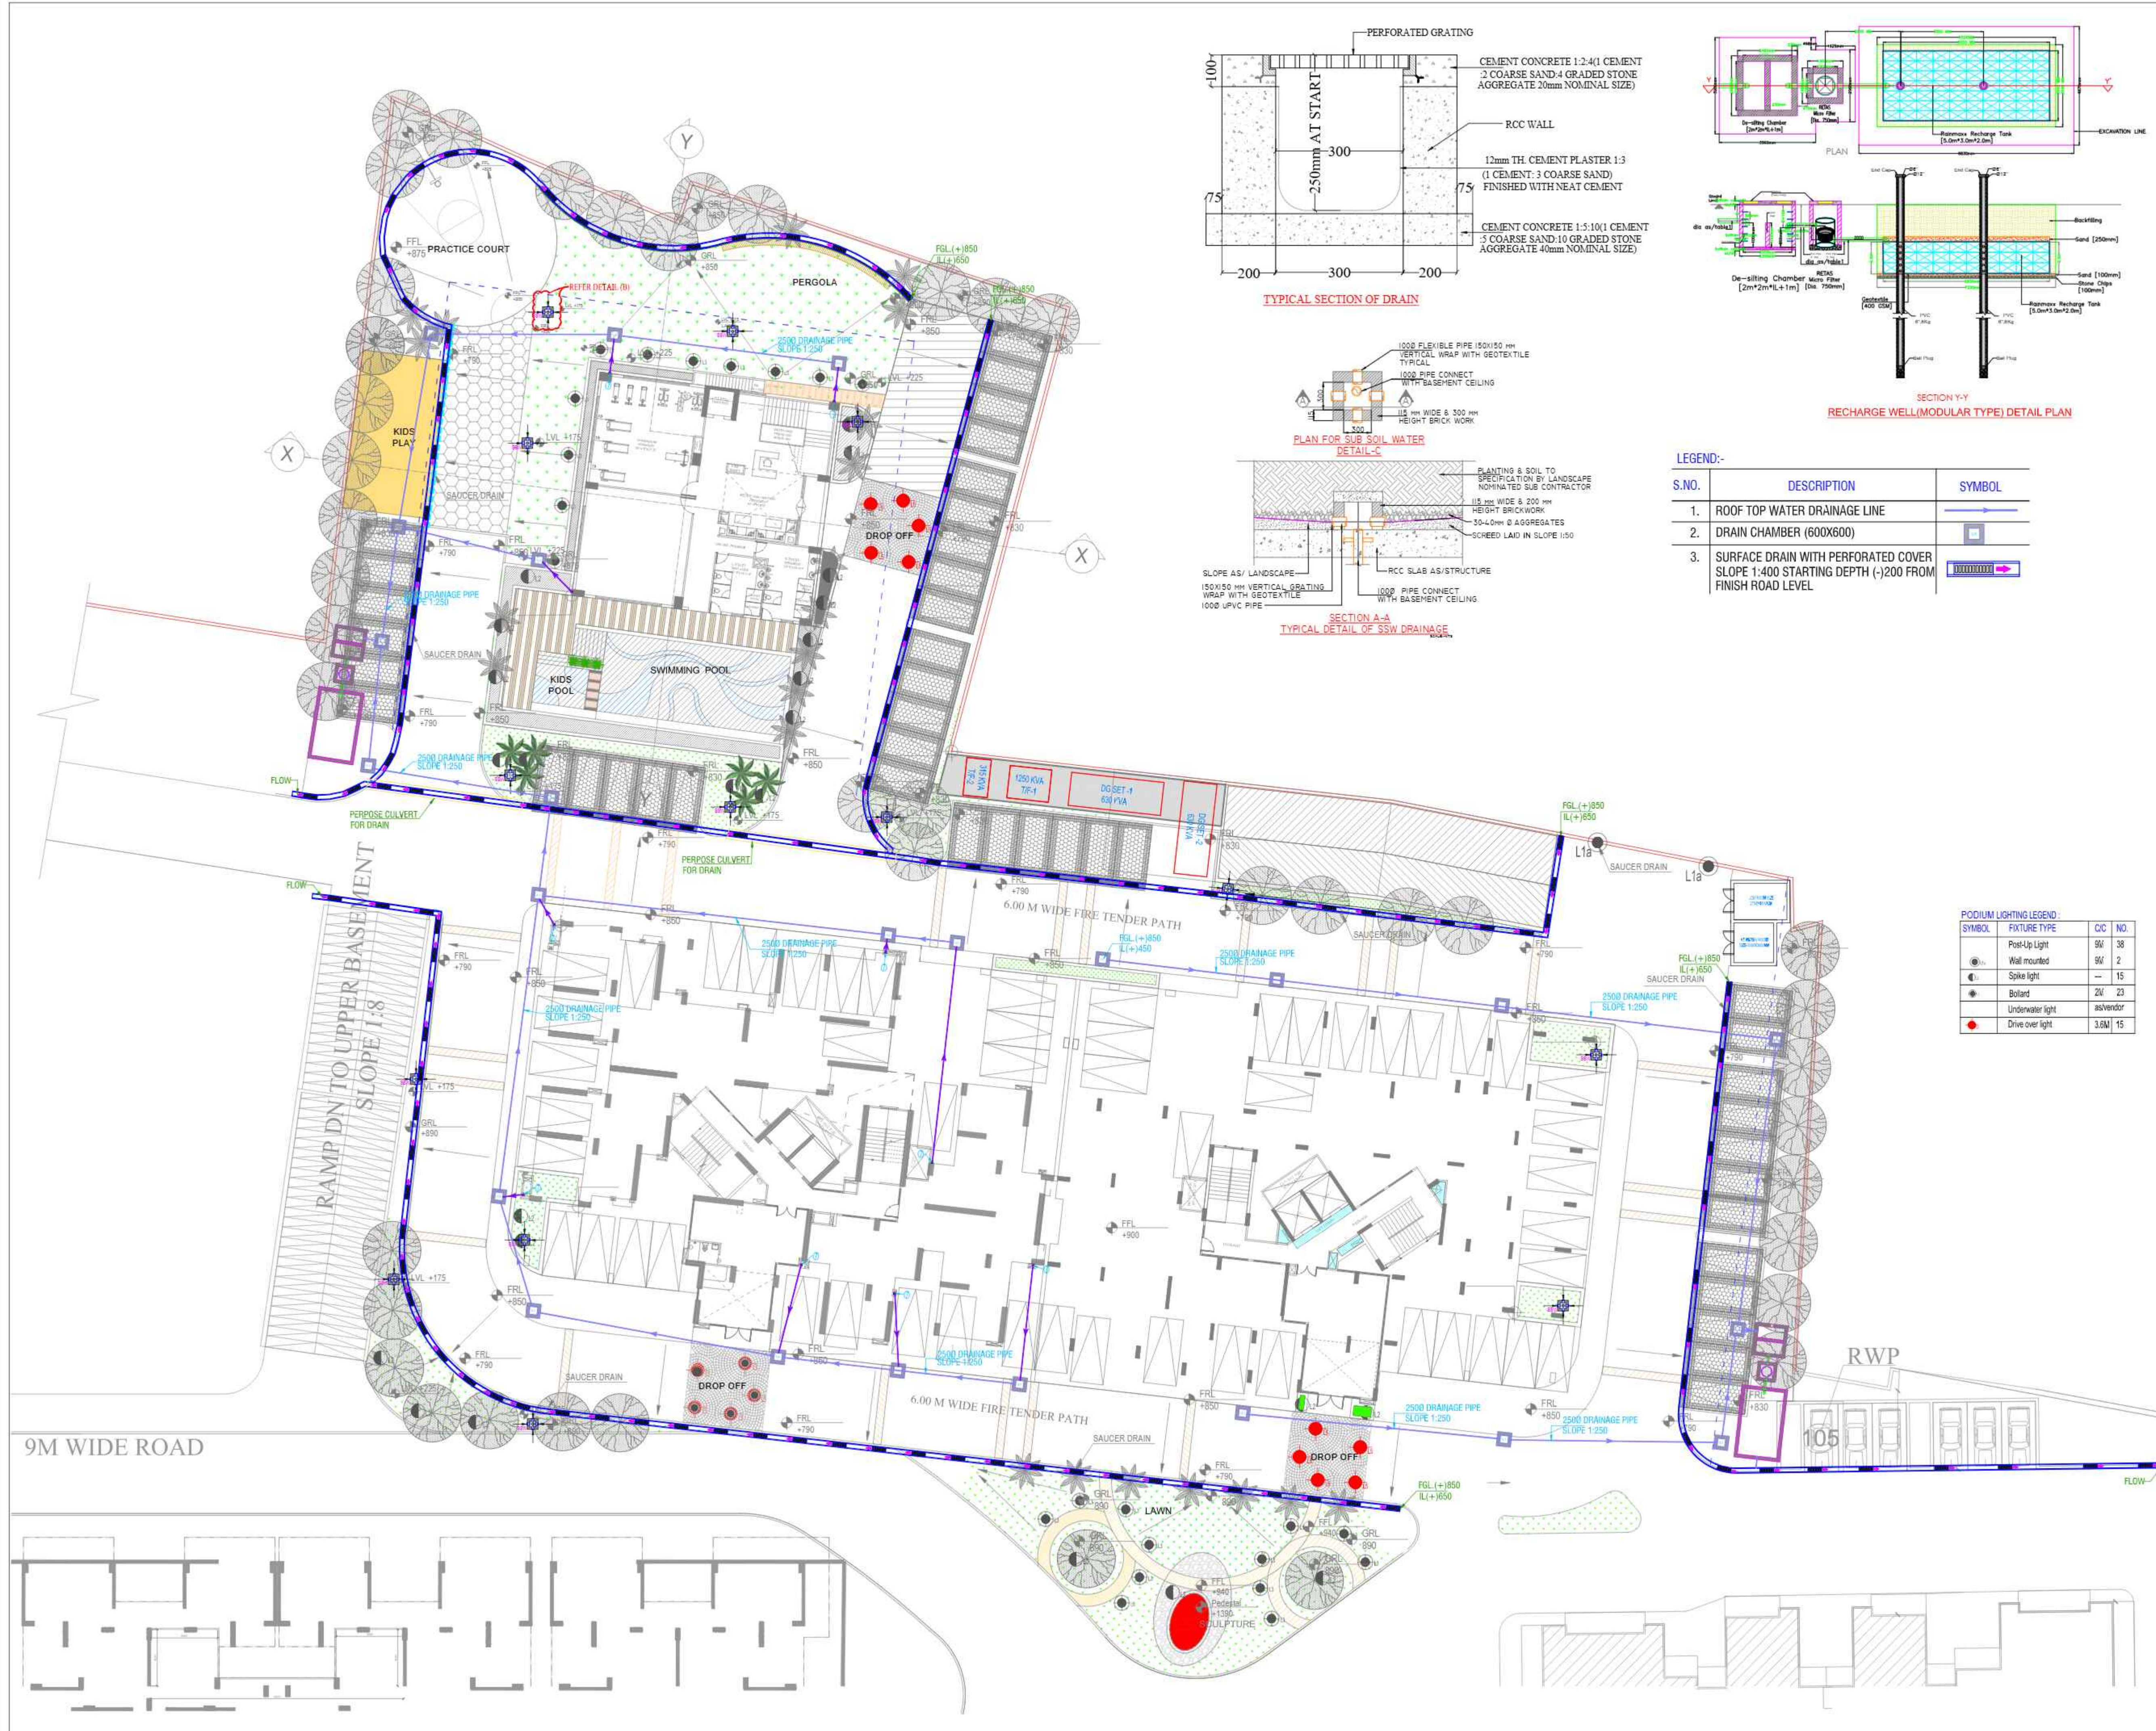

LEGEND:-

S.NO.	DESCRIPTION	SYMBOL
1.	ROOF TOP WATER DRAINAGE LINE	
2.	DRAIN CHAMBER (600X600)	
3.	SURFACE DRAIN WITH PERFORATED COVER SLOPE 1:400 STARTING DEPTH (-)200 FROM FINISH ROAD LEVEL	

PODIUM LIGHTING LEGEND:

SYMBOL	FIXTURE TYPE	CC	NO.
	Post-Up Light	9W	38
	Wall mounted	9W	2
	Spike light	—	15
	Bollard	2W	23
	Underwater light	as/vendor	
	Drive over light	3.6W	15



For AKJ Real Tech Private Limited
Shaif
Director

☐ ADVANCE COPY
☒ GOOD FOR CONSTRUCTION
☐ FOR TENDER
☐ FOR APPROVAL
Auth. Sign. *Pramod kumar*
For PKV Consulting Engineers (P) LTD.
GOOD FOR CONSTRUCTION

COPY	REV.	DATE	DESCRIPTION
PROJECT			
PROPOSED GROUP HOUSING (AKJ REAL TECH PVT.LTD.) "FLORA HOMEZ" AT PLOT NO-GH02, NH-24, VILLAGE - SHAHPUR BAMETA DISTT - GHAZIABAD (UP)			
BUILDER & PROMOTER			
M/s AKJ REAL TECH PVT.LTD			
LANDSCAPE ARCHITECT :			
AJ ARKIDESIGNS PRIVATE LIMITED			
 B - 33, KAILASH COLONY, NEW DELHI - 110045 TELEPHONE: 971144024 E-MAIL: info@ajarkidesigns.com			
ARCHITECTS			
 ARCHITECTS : Space Designers International B-34, Sector-67, Noida-201301 (U.P.) Ph : 0120-3100450, 451, 452, 453 91-9711633717, 18 e-mail : info@spacedi.com, www.spacedi.com			
DRAWING TITLE			
DRAINAGE PLAN			
SCALE		DATE	
N.T.S.		01.05.2025	
		SUNIL	
DRG.NO.		PL-01	
MEP CONSULTANT:			
PKV Consulting Engineers (P) Ltd.			
 C-815, DDA Flats,Loni Road, Delhi -110093 TELEFAX - 011-22816297 E-mail - pramod@pkv.co.in info@pkv.co.in			