



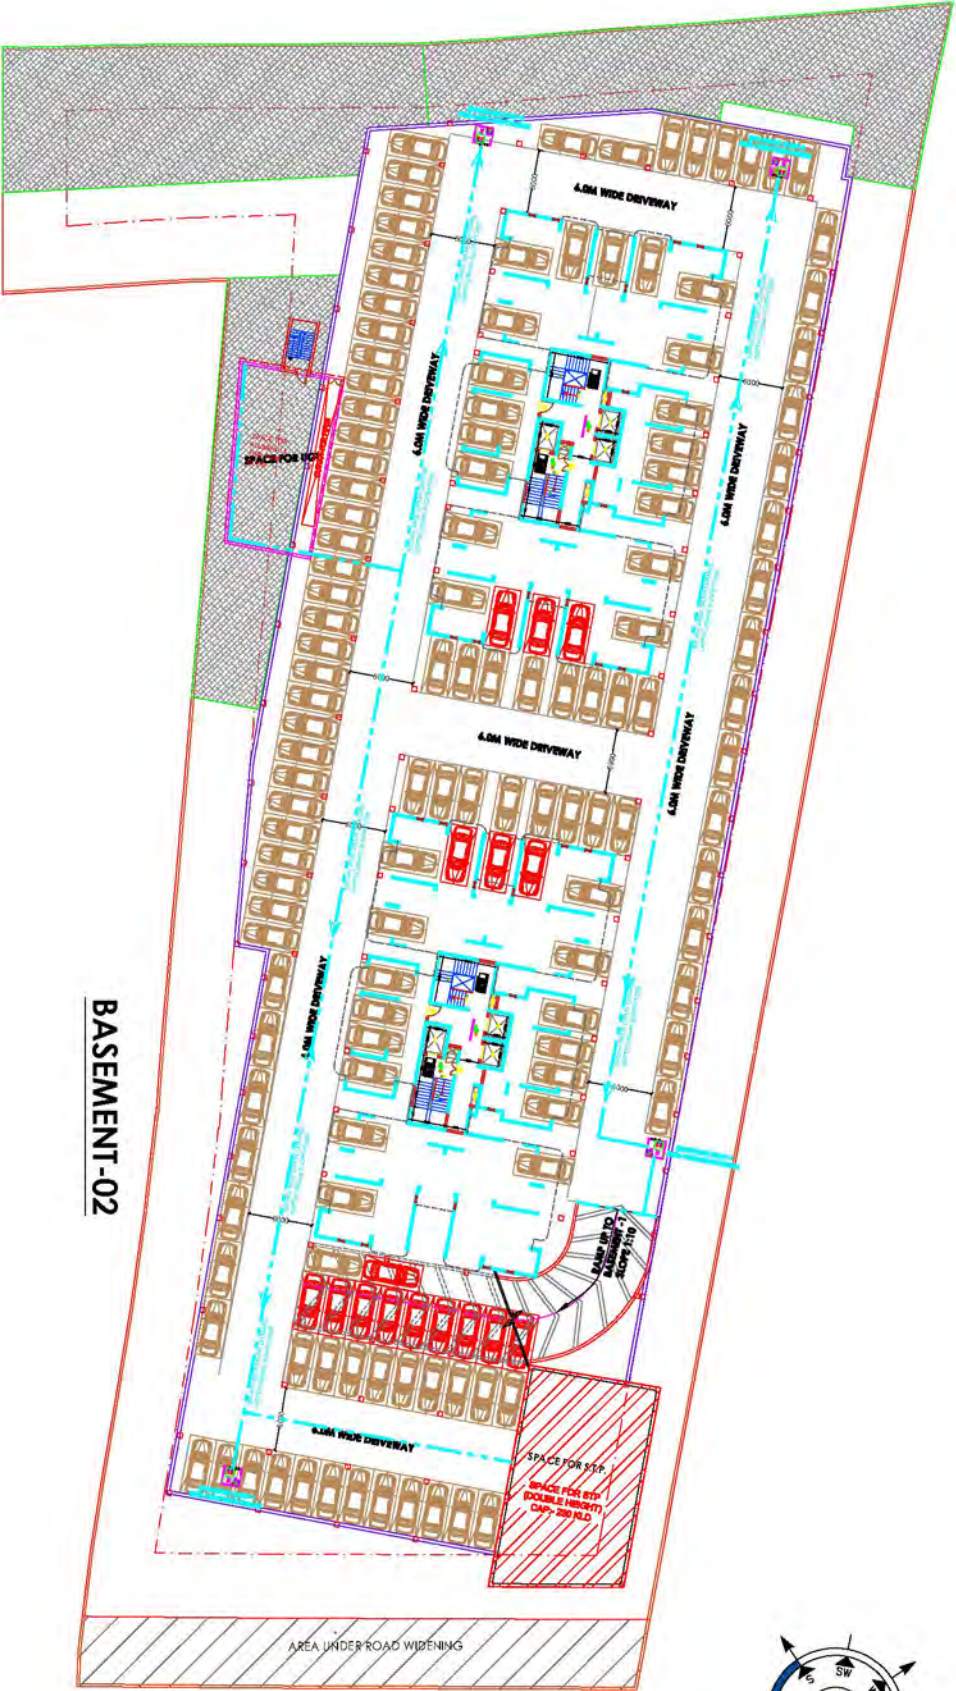

BASEMENT-02

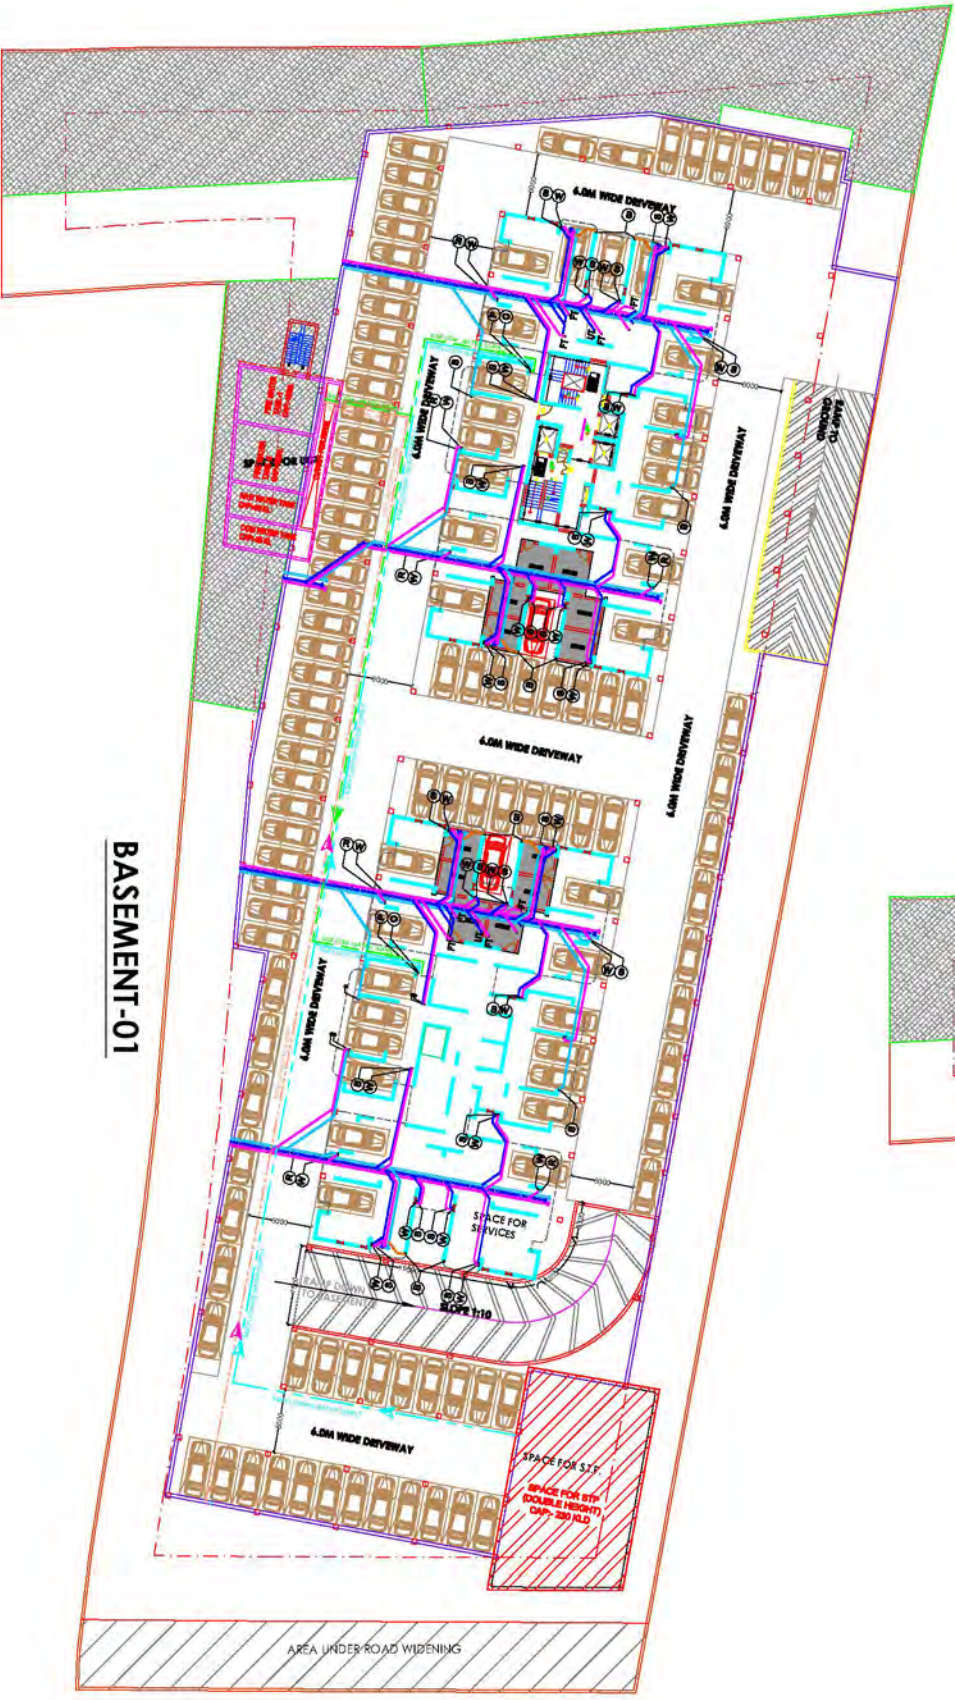

BASEMENT-01

S. No.	SYMBOL	DESCRIPTION
1	①	110mm OD UPVC SOIL AND VENT PIPE
2	②	110mm OD UPVC WASTE AND VENT PIPE
3	③	110mm OD UPVC KITCHEN WASTE AND VENT PIPE
4	④	DOMESTIC WATER SUPPLY PIPE (UPPER 3 FLOORS)
5	⑤	DOMESTIC WATER SUPPLY PIPE
6	⑥	FLUSHING WATER SUPPLY PIPE
7	⑦	800 DOMESTIC WATER RISER SUPPLY
8	⑧	500 FLUSHING WATER RISER SUPPLY
9	⑨	60mm OD UPVC VENT PIPE
10	⑩	110mm OD UPVC RAIN WATER PIPE
11	⑪	110mm OD UPVC BALCONY DRAIN PIPE
12	⑫	FLOOR DRAIN WITH GRATING
13	⑬	FLOOR TRAP / URINAL TRAP WITH GRATING
14	⑭	DWS - DOMESTIC WATER SUPPLY PIPE
15	⑮	FLUSHING WATER SUPPLY PIPE
16	⑯	HWS - HOT WATER SUPPLY PIPE
17	⑰	FLOOR CLEANOUT
18	⑱	CLEANOUT PLUG

PLUMBING SUBMISSION

PROJECT:

PROPOSED GROUP HOUSING
CHANDIGARH, INDIA
VILLAGE: CHANDIGARH, PHASE: CHANDIGARH, LOCATION: CHANDIGARH

CLIENT:

STRUCTURAL CONSULTANT:

M/E P CONSULTANT:

ARCHITECT:

K DESIGN
402, BALAJI APARTMENT
NEW BALAJI APARTMENT, NEW DELHI - 11000
Email: kdesignarchitect@gmail.com, kdesignarchitect.com

SCALE: 1/8" = 1'-0"


SITE PLAN

SHEET TITLE:


BASEMENT LAYOUT

SHEET NO.


SUB_S02

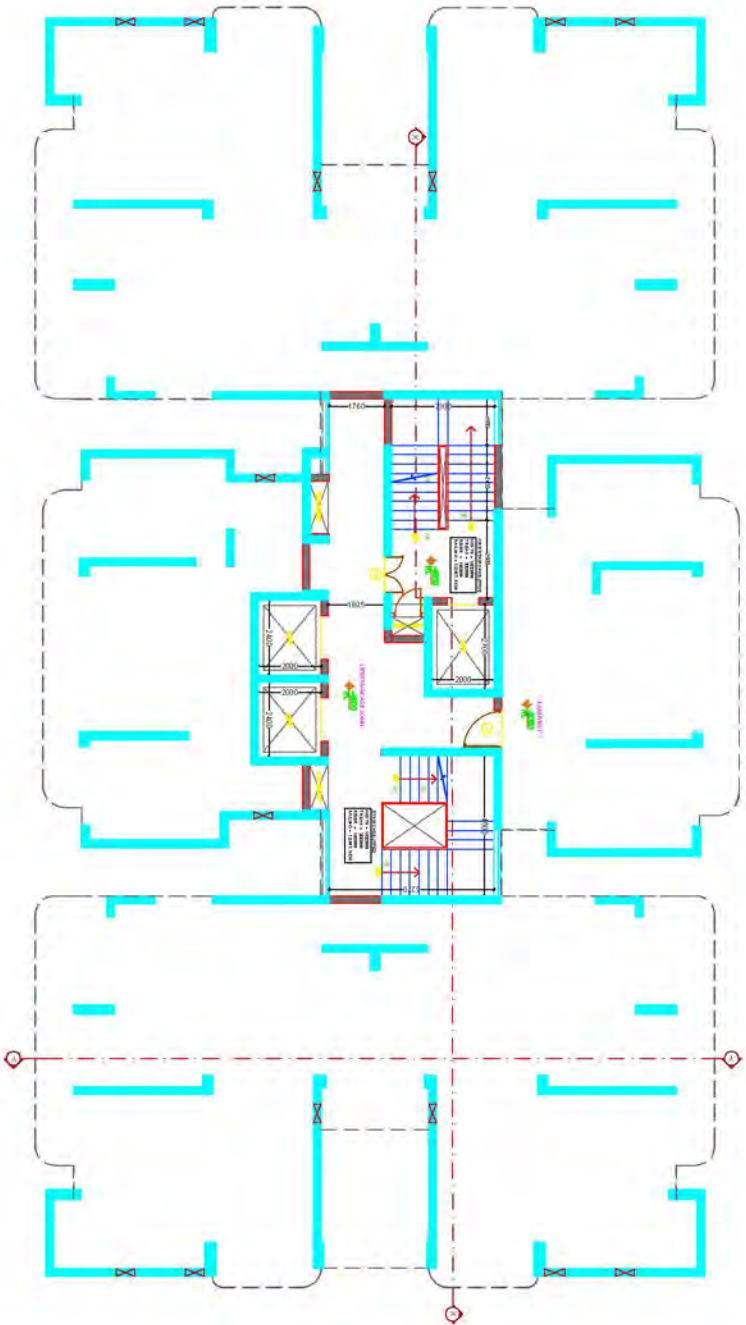


BASEMENT LEVEL -1 FLOOR PLAN
TOWER-A

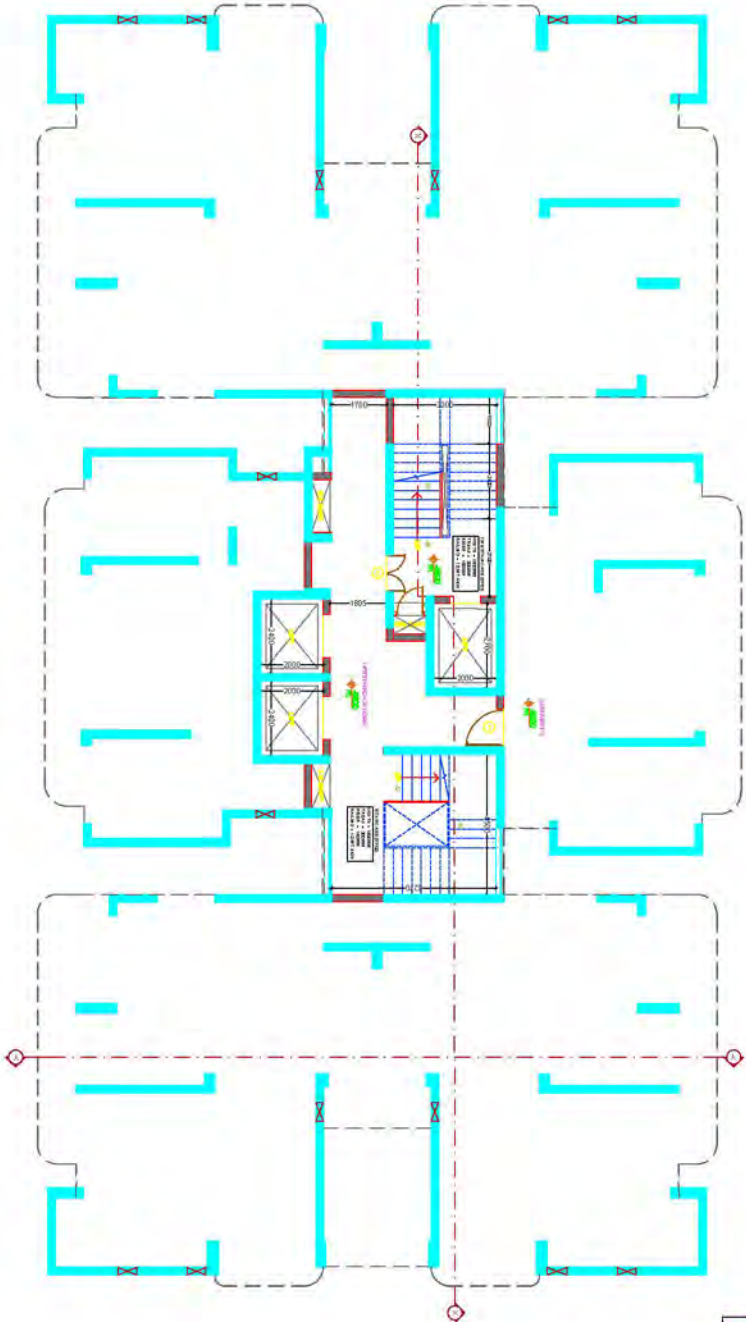

BASEMENT LEVEL -2 FLOOR PLAN
TOWER-A

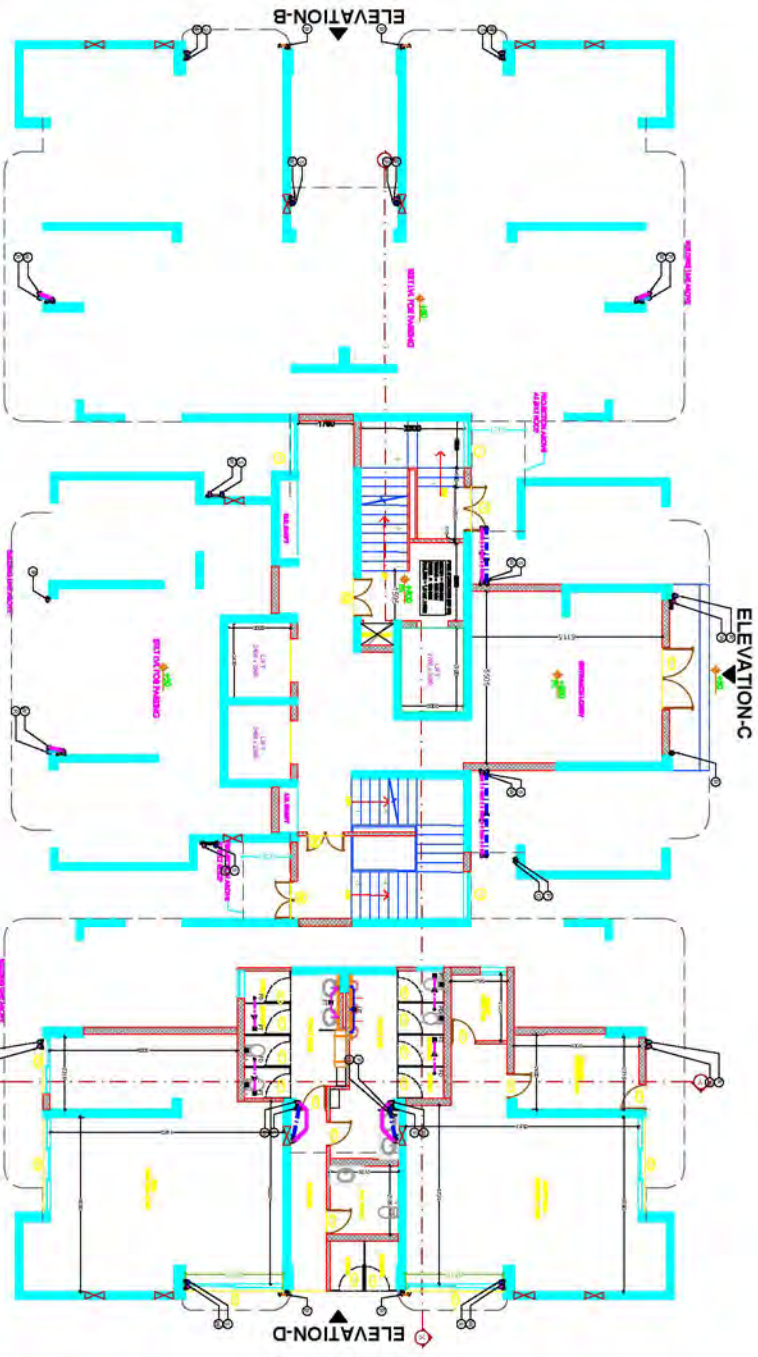

STILT LEVEL FLOOR PLAN
TOWER-A

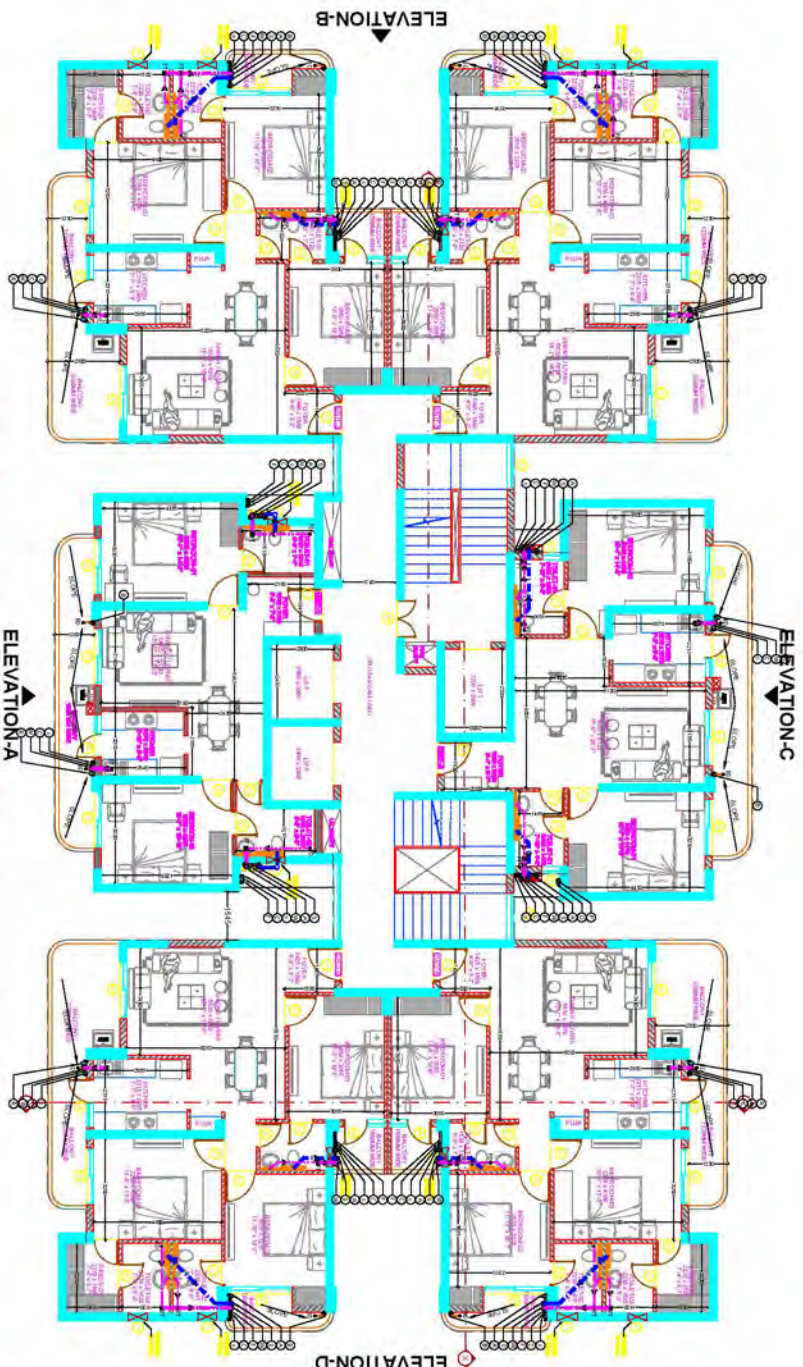

TYPICAL FLOOR PLAN (1ST TO 17TH, 19TH TO 26TH)
TOWER-A

PLUMBING LEGEND:-	
S.NO.	SYMBOL
1	110mm OD UPVC SOIL AND VENT PIPE
2	110mm OD UPVC WASTE AND VENT PIPE
3	110mm OD UPVC KITCHEN WASTE AND VENT PIPE
4	DOMESTIC WATER SUPPLY PIPE (UPPER 3 FLOOR)
5	DOMESTIC WATER SUPPLY PIPE
6	FLUSHING WATER SUPPLY PIPE
7	650 DOMESTIC WATER RISER SUPPLY
8	500 FLUSHING WATER RISER SUPPLY
9	80mm OD UPVC VENT PIPE
10	110mm OD UPVC RAIN WATER PIPE
11	80mm OD UPVC BALCONY DRAIN PIPE
12	FLOOR DRAIN WITH GRATING
13	FLOOR TRAP / URINAL TRAP WITH GRATING
14	DWS DOMESTIC WATER SUPPLY PIPE
15	FWS FLUSHING WATER SUPPLY PIPE
16	HWS HOT WATER SUPPLY PIPE
17	FLOOR CLEANOUT
18	CCP CLEANOUT FLUS

DRAINAGE PIPE CONNECTION DETAIL:-	
FROM WC TO STACK (M)	1000 PIPE
FROM SINK TO STACK (M)	1000 PIPE
FROM SINK TO SINK (M)	200 PIPE
FROM SINK TO FT	320 PIPE
FLOOR TRAP 1000 X 1000	FT
FLOOR DRAIN 100 X 60 / 100 X 50	FD
FLOOR CLEAN OUT 100 X 100	CCP

PLUMBING SUBMISSION

PROJECT:
PROPOSED GROUP HOUSING

CLIENT:
GOLDEN HILLS ESTATE DEVELOPMENT

STRUCTURAL CONSULTANT:
M. P. CONSULTANT

M. P. CONSULTANT:
M. P. CONSULTANT


ARCHITECT:
K DESIGN

SCALE: 1/8" = 1'-0"


DRAWING BLOCK:
TOWER -A

SHEET TITLE:
FLOOR PLANS


SHEET NO.
SUB_A01

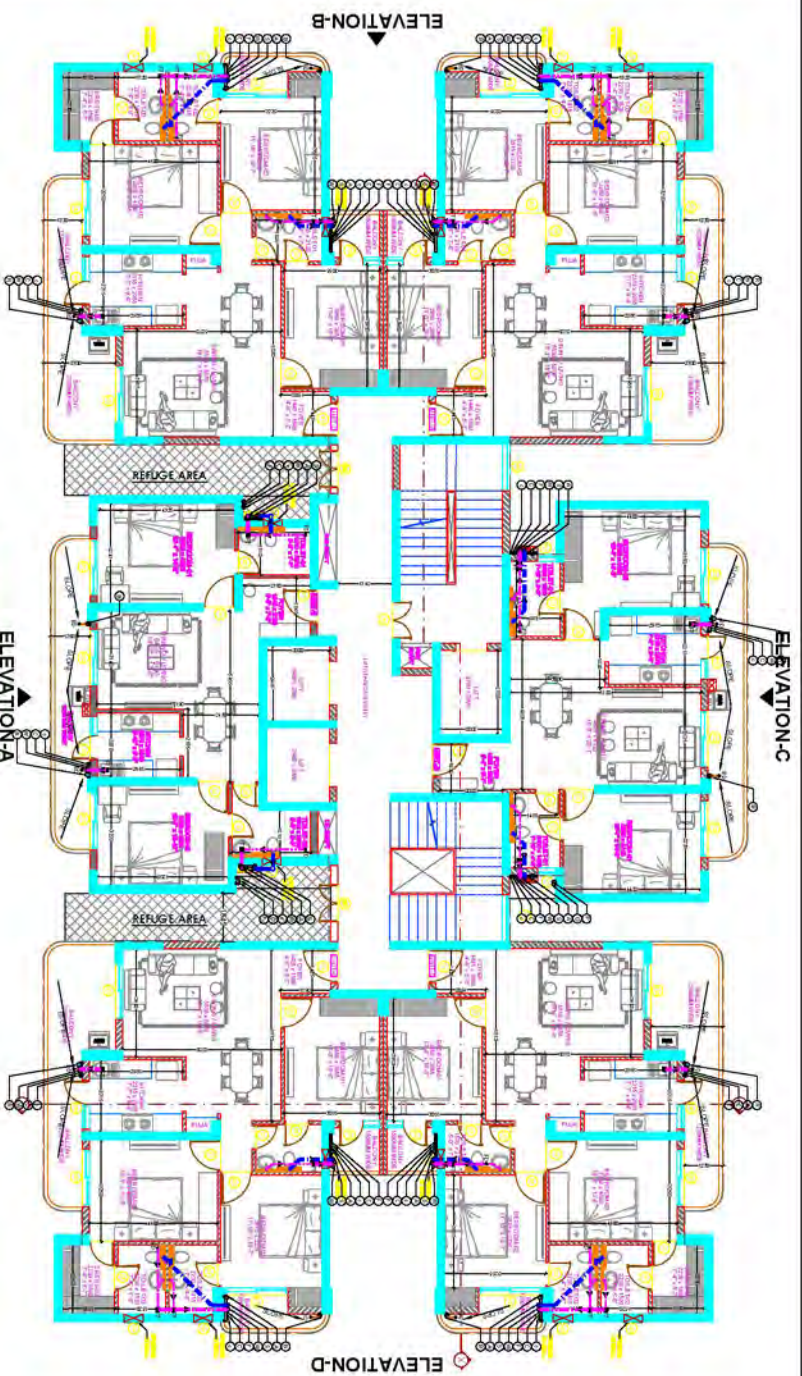

18TH FLOOR PLAN
TOWER-A

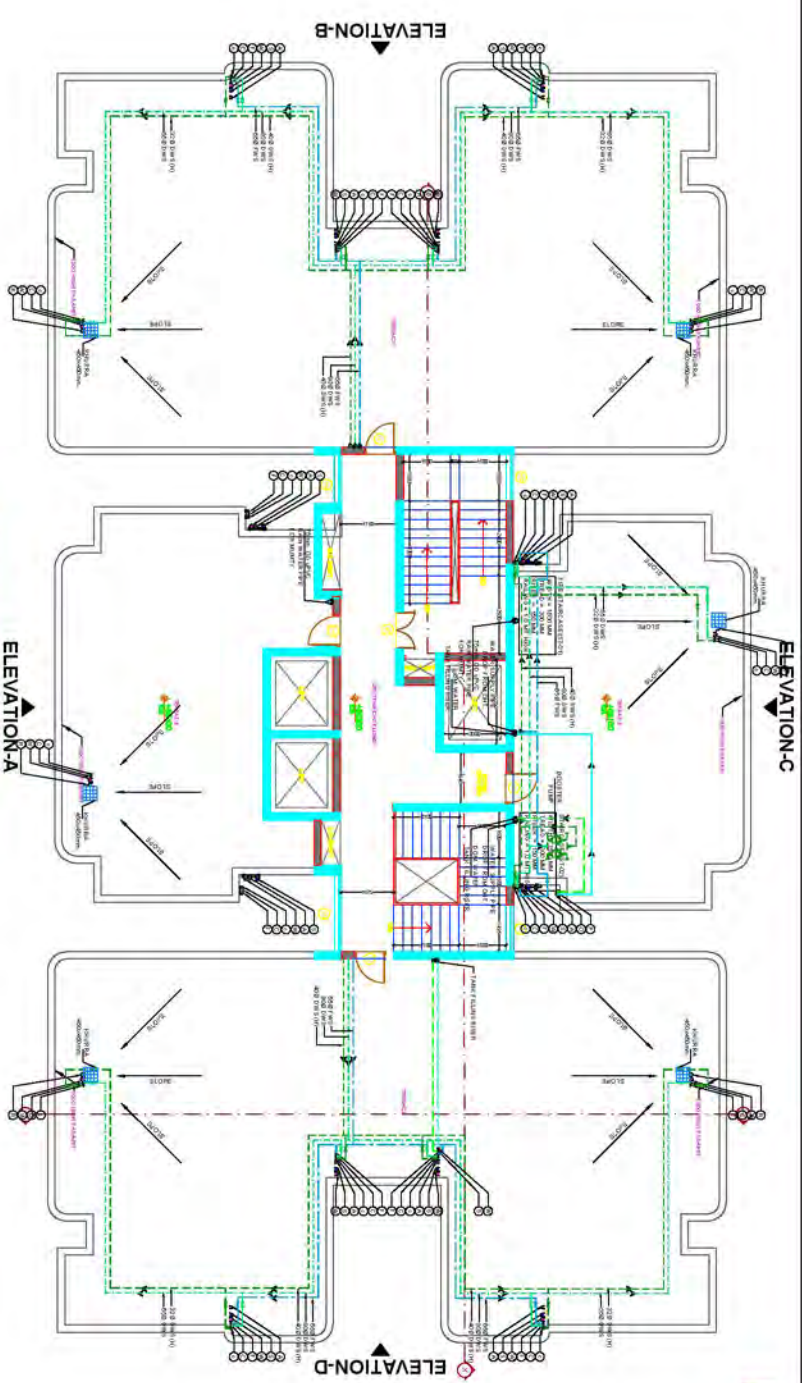TERRACE FLOOR PLAN
TOWER-A

FLUSHING LEGEND--		
S No	SYMBOL	DESCRIPTION
1		10 mm OD JPMC SOLID VENT PIPE
2		10mm OD JPMC WASTE AND VENT PIPE
3		10mm OD JPMC KITCHEN WASTE AND VENT PIPE
4		DOMESTIC WATER SUPPLY PIPE (UPPER FLOOR)
5		DOMESTIC WATER SUPPLY PIPE
6		FLUSHING WATER SUPPLY PIPE
7		FOR DOMESTIC WATER RISER SUPPLY
8		500 FLUSHING WATER RISER SUPPLY
9		RISER OD JPMC VENT PIPE
10		10mm OD JPMC KITCHEN WASTE PIPE
11		RISER OD JPMC BATHROOM DRAIN PIPE
12		FLOOR DRAIN WITH GRATING
13		FLOOR TRAP / U-BEND TRAP WITH GRATING
14		DOMESTIC WATER SUPPLY PIPE
15		FLUSHING WATER SUPPLY PIPE
16		HOT WATER SUPPLY PIPE
17		FLOOR CLEANOUT
18		CLEANOUT / JUS

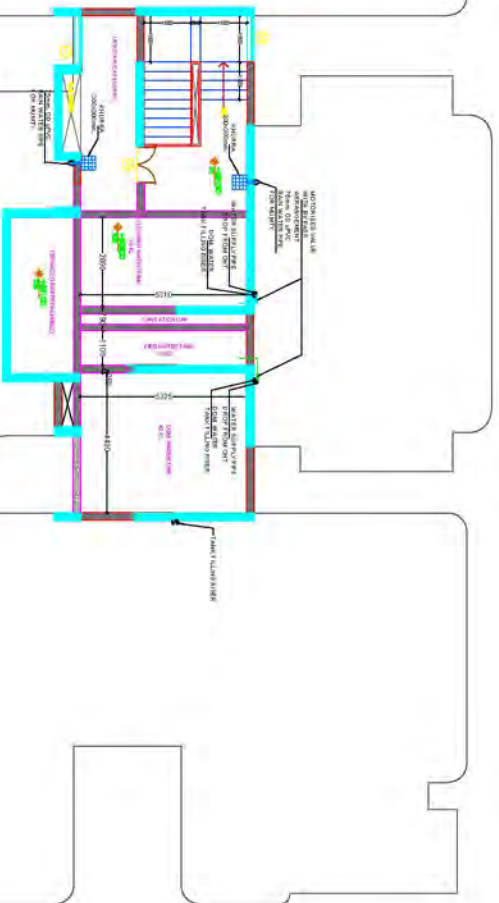OHT LEVEL FLOOR PLAN
TOWER-A

DRAINAGE PIPE CONNECTION DETAIL:-

PLUMBING SUBMISSION

PROJECT:

PROPOSED GROUP HOUSING

LEI HONGCHEN M.S. 64021, ZHANG JIUTING 6746, KONG JIN
VILLAGE ZHANGJIAN TOWNSHIP, SAO JIAHUAQI, GUICHOW

CLIENT:

STRUCTURAL CONSULTANT:

M.E.P CONSULTANT:

ARCHITECT:

K DESIGN

NEW MATHSALAPUR, NEW DELHI (INDIA)

© 2001 Blackwell Science Ltd *Journal of Internal Medicine* 250: 103–110

SCALE: NT54

TOWER -A

SHEET TITLE:

FLOOR PLANS

SHEET NO.

SUB_A02

This architectural floor plan depicts a symmetrical building layout with a central corridor and multiple rooms. The plan includes the following details:

- Central Corridor:** A central corridor runs horizontally, featuring a staircase and a set of double doors labeled "1000".
- Rooms:** The plan shows several rooms, including a large room on the left labeled "1000" and a room on the right labeled "1000". Other rooms are labeled with numbers like "1000", "1000", and "1000".
- Structural Elements:** The plan includes walls, doors, and windows. Doors are marked with "X" symbols, and windows are marked with "Y" symbols.
- Stairs:** A staircase is located in the central corridor, with a label "1000" and a note "1000".
- Dimensions:** Various dimensions are indicated, such as "1000", "1000", and "1000".
- Orientation:** The plan is oriented with a north arrow pointing towards the top right.

The diagram is a complex architectural floor plan of a building, oriented horizontally. It features a central corridor system with multiple stairwells and elevators. The building is divided into several rooms, some of which are labeled with text such as "ELEVATION-D" and "ELEVATION-C". The plan includes various symbols for doors, windows, and furniture, and is color-coded with red, blue, and green lines and text.

The architectural floor plan shows a building layout with four elevations labeled A, B, C, and D. The plan includes various rooms, corridors, and furniture. Key features include:

- Elevation A (Left):** Shows a large room with a desk and chair, a sofa, and a door labeled "DOOR WITH GLASS".
- Elevation B (Right):** Shows a room with a desk and chair, a sofa, and a door labeled "DOOR WITH GLASS".
- Elevation C (Top):** Shows a room with a desk and chair, a sofa, and a door labeled "DOOR WITH GLASS".
- Elevation D (Bottom):** Shows a room with a desk and chair, a sofa, and a door labeled "DOOR WITH GLASS".

The plan also includes dimensions, door types, and furniture placement. The overall layout is symmetrical, with a central corridor and rooms on either side.

DRAINAGE PIPE CONNECTION DETAIL:-

1 FROM WC TO STACK 1M1 1100 PIPE
2 FROM FT TO STACK 1G1 1100 PIPE
3 FROM WB TO HD 1 320 PIPE
4 FROM SINK TO FT 320 PIPE
5 FLOOR DRAIN 1100 X 1100 FT
6 FLOOR DRAIN 110 X 63 / 110 X 50 FD
7 FLOOR CLEAN OUT 110 X 110 C.O.P

Signature / Authorized signatory