

**BANDA DEVELOPMENT AUTHORITY**  
**GOVERNMENT OF U.P.**

**PROJECT**

**MUKHYA MANTRI SHAHARI VISTARIKARAN YOJNA (GRAM-MAHOKHAR),BANDA,U.P.**


**LEGEND:**

●	XMER-320KVA
●	XMER-160KVA
●	XMER-1600KVA
—	LIGHTING F.P
—	65-75W STREET LIGHT
—	H.T UNDER GROUND CABLE ROUTING
—	L.T UNDER GROUND CABLE ROUTING

**SHEET TITLE :**

**ELECTRICAL LAYOUT PHASE-1**

**NORTH** DRAWN BY SUDHANSHU  
DATE 23-12-2025  
SCALE 1:100  
CHECKED BY AR.YATI  
DRG.NO.

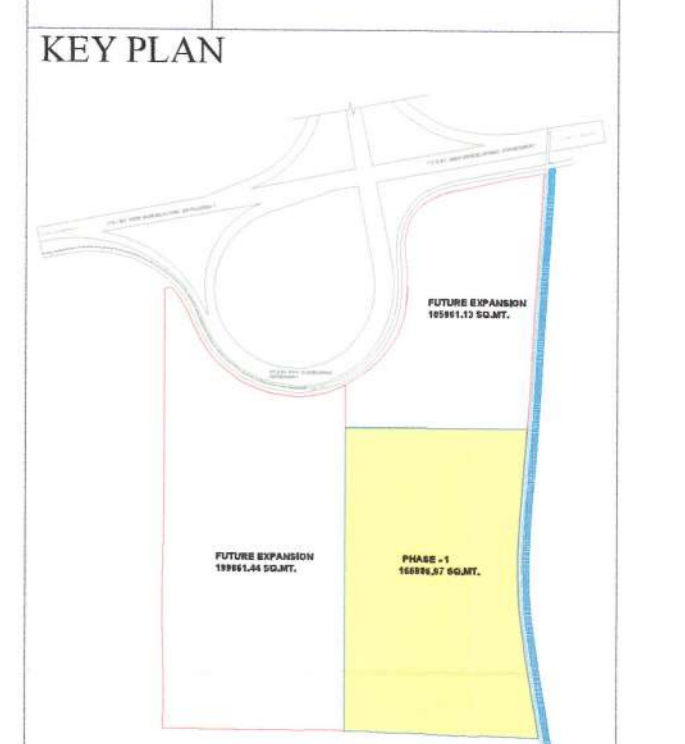

**NOTES :**

- ALL DIMENSIONS SHALL BE CHECKED AND CORRELATED WITH THE ARCHITECTURAL DRAWING AND ANY AMBIGUITY SHALL BE IMMEDIATELY BOUGHT TO THE NOTICE OF THE ARCHITECT/CONSULTANT BEFORE COMMENCEMENT OF THE WORK.
- ALL DIMENSIONS ARE IN M. UNLESS OTHERWISE SPECIFIED

THIS DRAWING IS THE PROPERTY OF SHALEEN CONSULTANTS AND IS NOT TO BE COPIED OR USED WITHOUT THEIR PRIOR PERMISSION.

**SHALEEN CONSULTANTS**  
AR. PAWAN MISHRA  
AR. YATI KUMAR MISHRA

2nd floor, Aishwarya Plaza-1, Sector-14, Aliganj, Lucknow  
312, Skyline Plaza -1, Shushant Golf City, Lucknow  
E-Mail : info.shaleenconsultants@gmail.com  
Contact No. : +91 9335920481 | +91 8966832308