


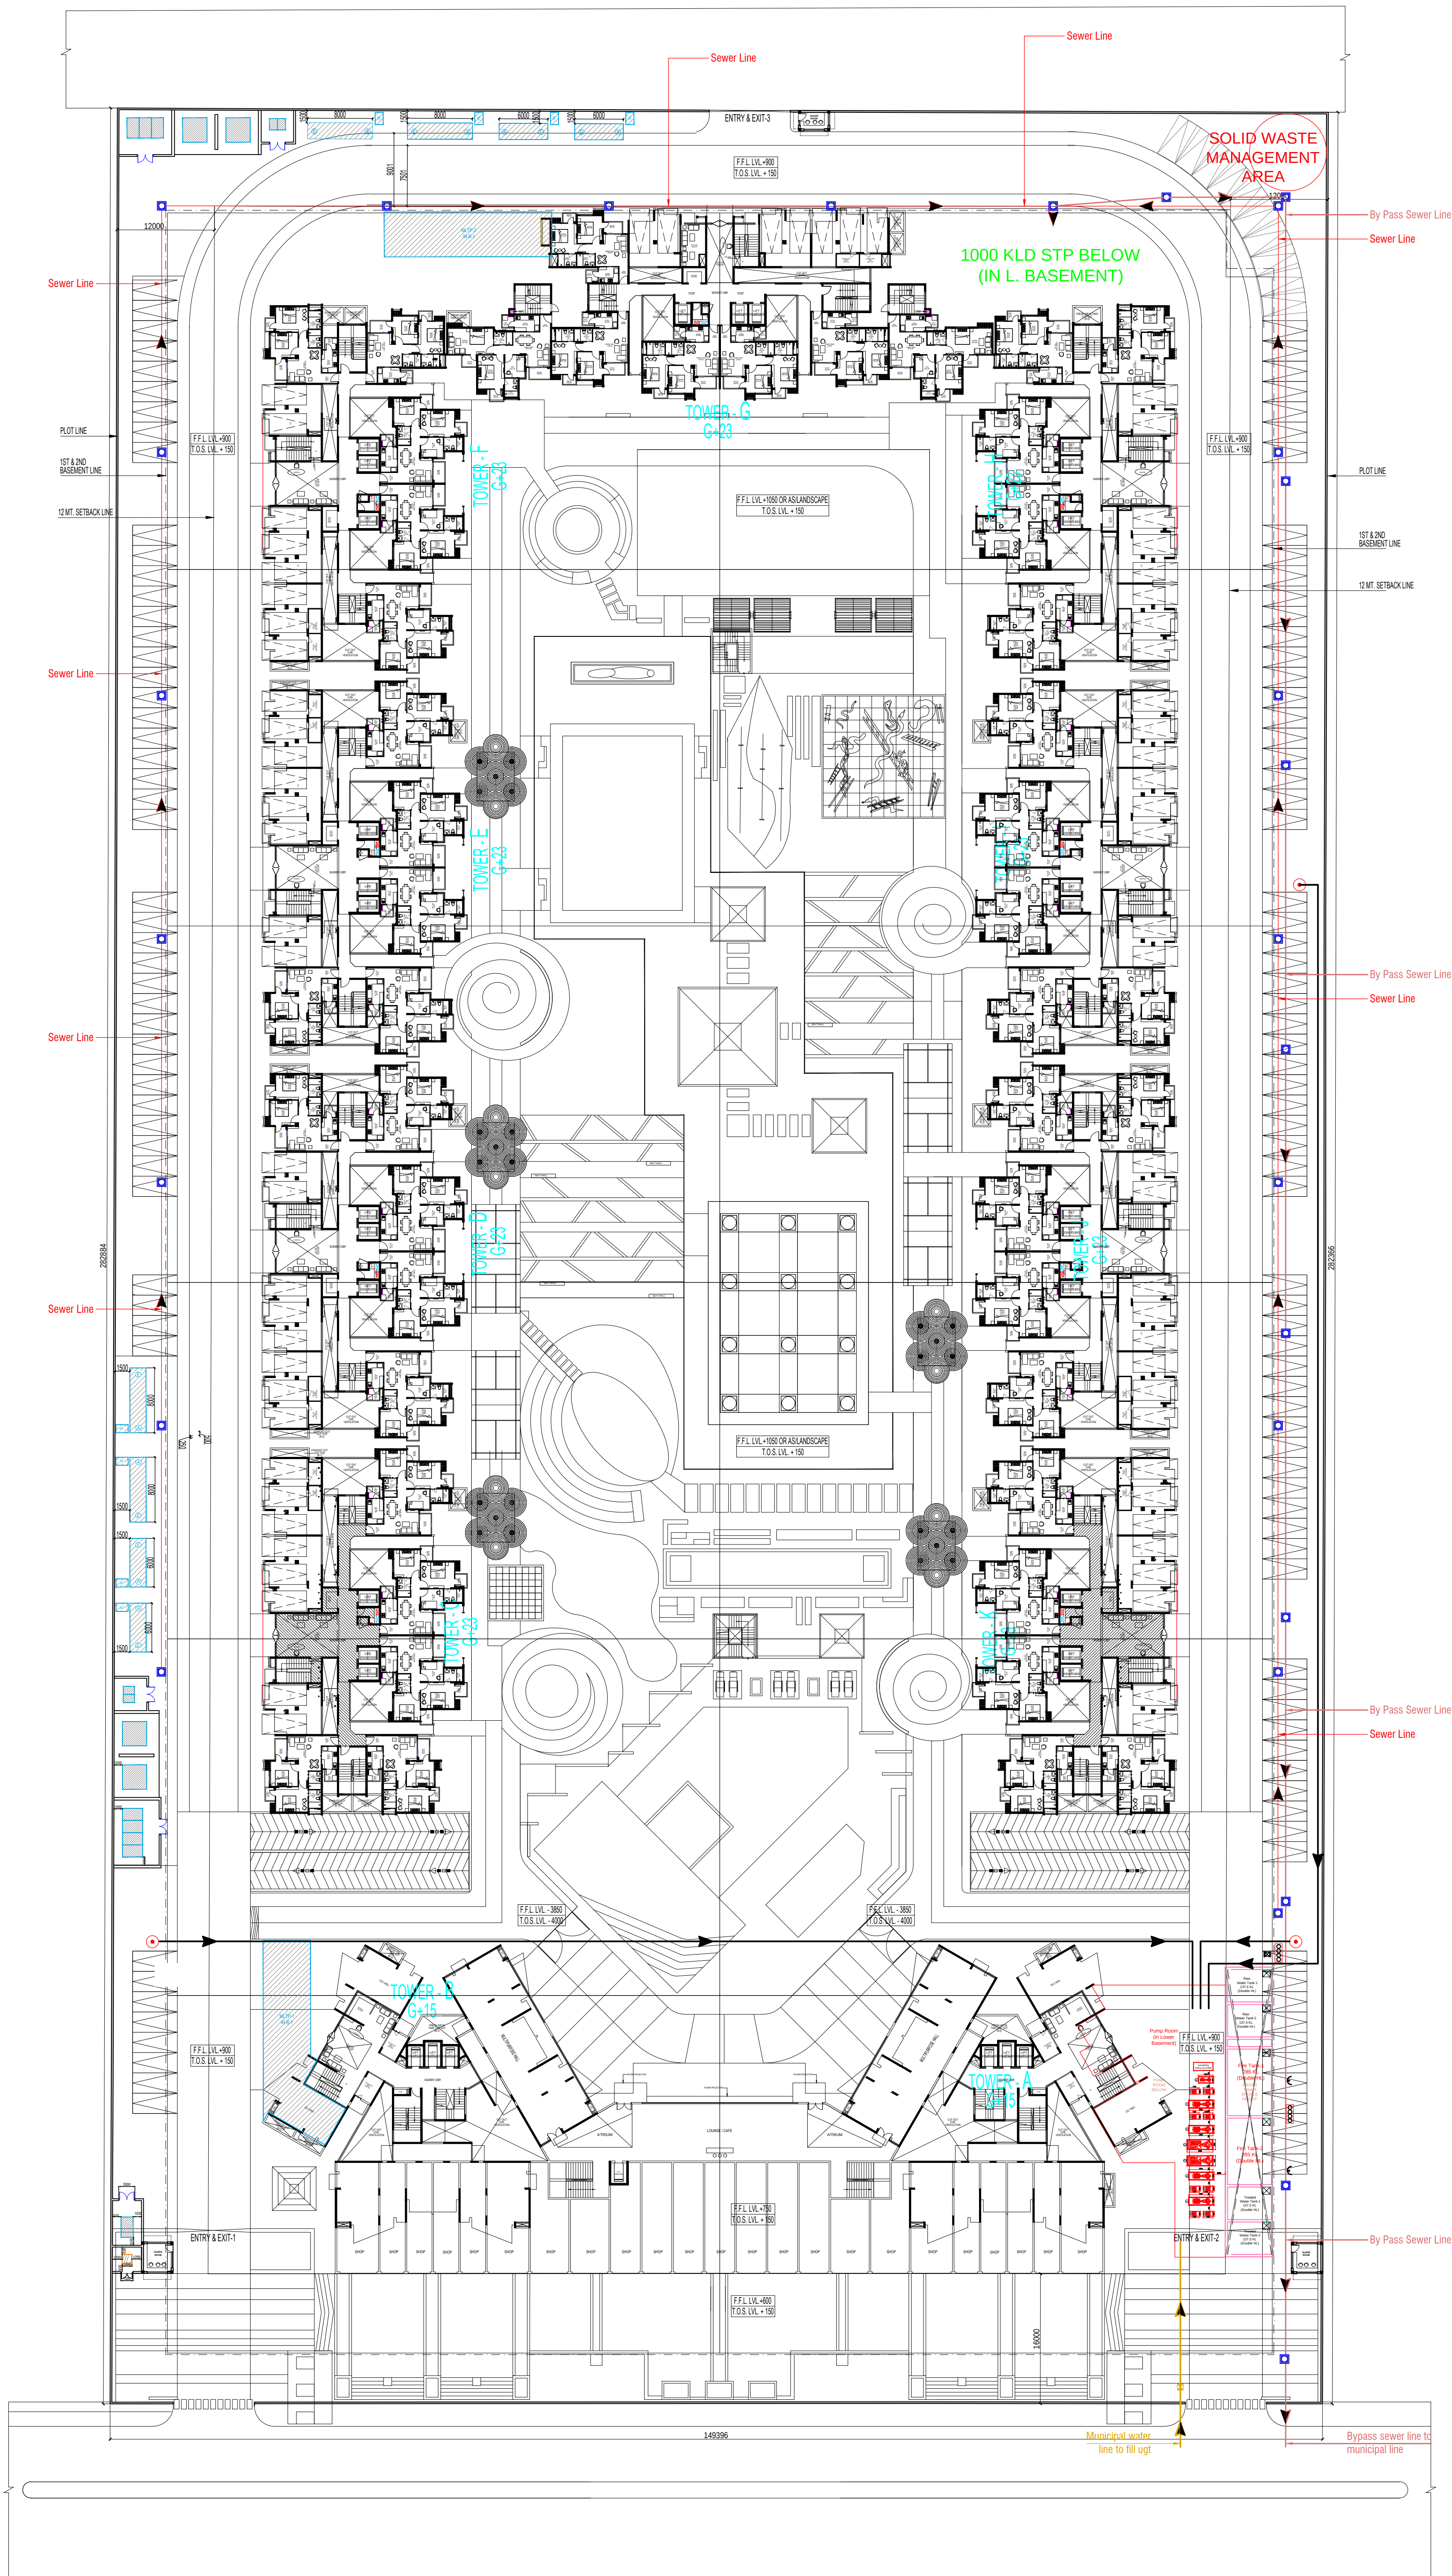

project
Ace Divino
Plot No. GH 14-A, Sector-1
Greater Noida

title
SITE PLAN
subtitle
WASTE DISPOSAL PLAN

drawing released for
☐ APPROVAL
☐ ADVANCE COPY
☒ SUBMISSION
☐ CONSTRUCTION

drg. no.
ACE/DIVINO/EXT/001
scale
1/425 @ A1
date
13-07-2017

drawn by
Anand Pandey
designed by
M Mansoor
checked by
Anand Havella

architects

Confluence
S-29 GK-2
N.D-48, INDIA
Ph: +91-11-29216006
Ph: +91-11-40564768

services consultant
Consummate Engineering Services (P) Ltd.
Noida Office: B-67, Sector-67, Noida - 201 301
Tel: (0120) 6943500 (24 Lines)
Lko. Office: R 006, Rohitas Plumeria, Gomti Nagar, Lucknow
e mail : mail@cespl.in, website : www.cespl.in