



समस्त अधिकार सुरक्षित हैं।
 यह दस्तावेज़ केवल निर्माण के लिए है।
 इस दस्तावेज़ को किसी भी प्रकार से प्रतिलिखित नहीं किया जा सकता।
 इस दस्तावेज़ में कोई भी त्रुटि हो सकती है।
 24/6
 Mr.

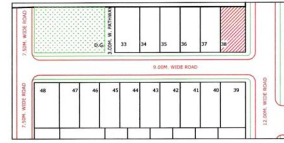


KEY PLAN

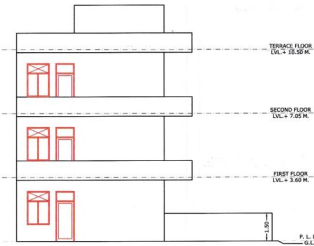


FRONT ELEVATION




SIDE ELEVATION

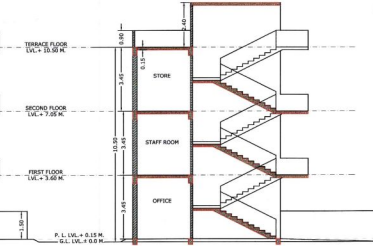


SECTION - AA

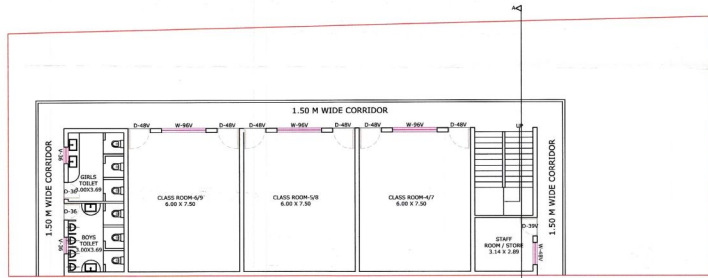


FIRST & SECOND FLOOR PLAN

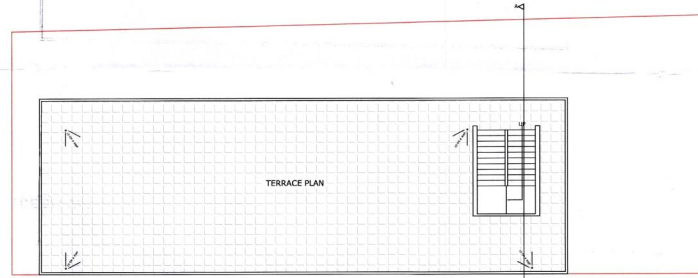

TERRACE PLAN

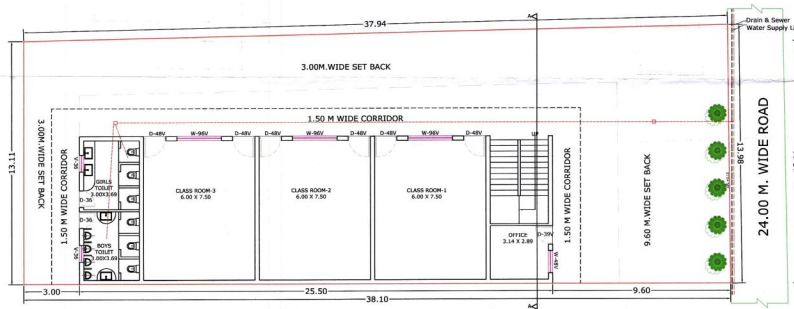

GROUND FLOOR PLAN

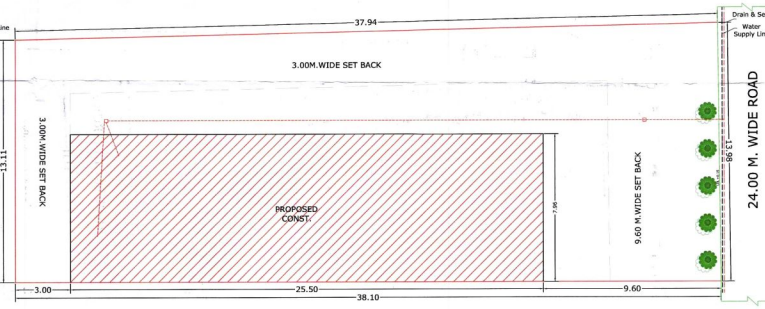

SITE PLAN

S. No.	DESCRIPTION	AREA	UNIT
1	TOTAL LAND AREA	100.00	SQM
2	GROUND FLOOR AREA	202.00	SQM
3	FIRST FLOOR AREA	202.00	SQM
4	SECOND FLOOR AREA	202.00	SQM
5	THIRD FLOOR AREA	17.00	SQM
6	TOTAL COVERED AREA	605.00	SQM
7	PERMISSIBLE GROUND COVERAGE	50.00	%
8	PLANTATION	1.00	SQM
9	TOTAL FURNISHABLE	2.00	SQM

TYPE	DESCRIPTION	SIZE
D-400	DOOR/VENTILATOR	1.00 x 2.00
D-300	DOOR	1.00 x 2.00
D-200	DOOR	0.80 x 2.00
D-100	DOOR	0.75 x 2.00
W-400	WINDOW/VENTILATOR	1.00 x 1.50
W-300	WINDOW/VENTILATOR	0.75 x 1.50
W-200	WINDOW/VENTILATOR	0.50 x 1.50
W-100	WINDOW/VENTILATOR	0.25 x 1.50

MH	MAN HOLE
ELECTRICAL TRANSFORMER	
SEWER LINES	

PLUMBING LINES	
PROPOSED NURSERY SCHOOL BUILDING PLAN	
AT PLOT NO. 38 OF SINGHIA DREAM CITY AT	
KHASRA NO. 187(P), 200(P), 201 & 202(P) MAUIZA	
LADAMADA, JAIPUR ROAD AGRA	

OWNER: M. R. INFRASTATE PVT. LTD.

North	SCALE 1:175	SHEET NO 1/1
-------	-------------	--------------

Owner's Signature:	Engineer's Sign
M. R. InfraState Pvt.Ltd.	Dr. Daya Shankar Sharma
	Chartered Engineer, Chartered Accountant
	FTV, MIEDM, ICAEW, ICA, ICA, ICA

Modcon A GROUP OF ARCHITECTS
 (INDIAN) & VALENTA
 Group Office: 10, Sector 10, Gurgaon, Haryana, India. Phone: +91-122-4000000
 Regd. Office: 10, Sector 10, Gurgaon, Haryana, India. Phone: +91-122-4000000