




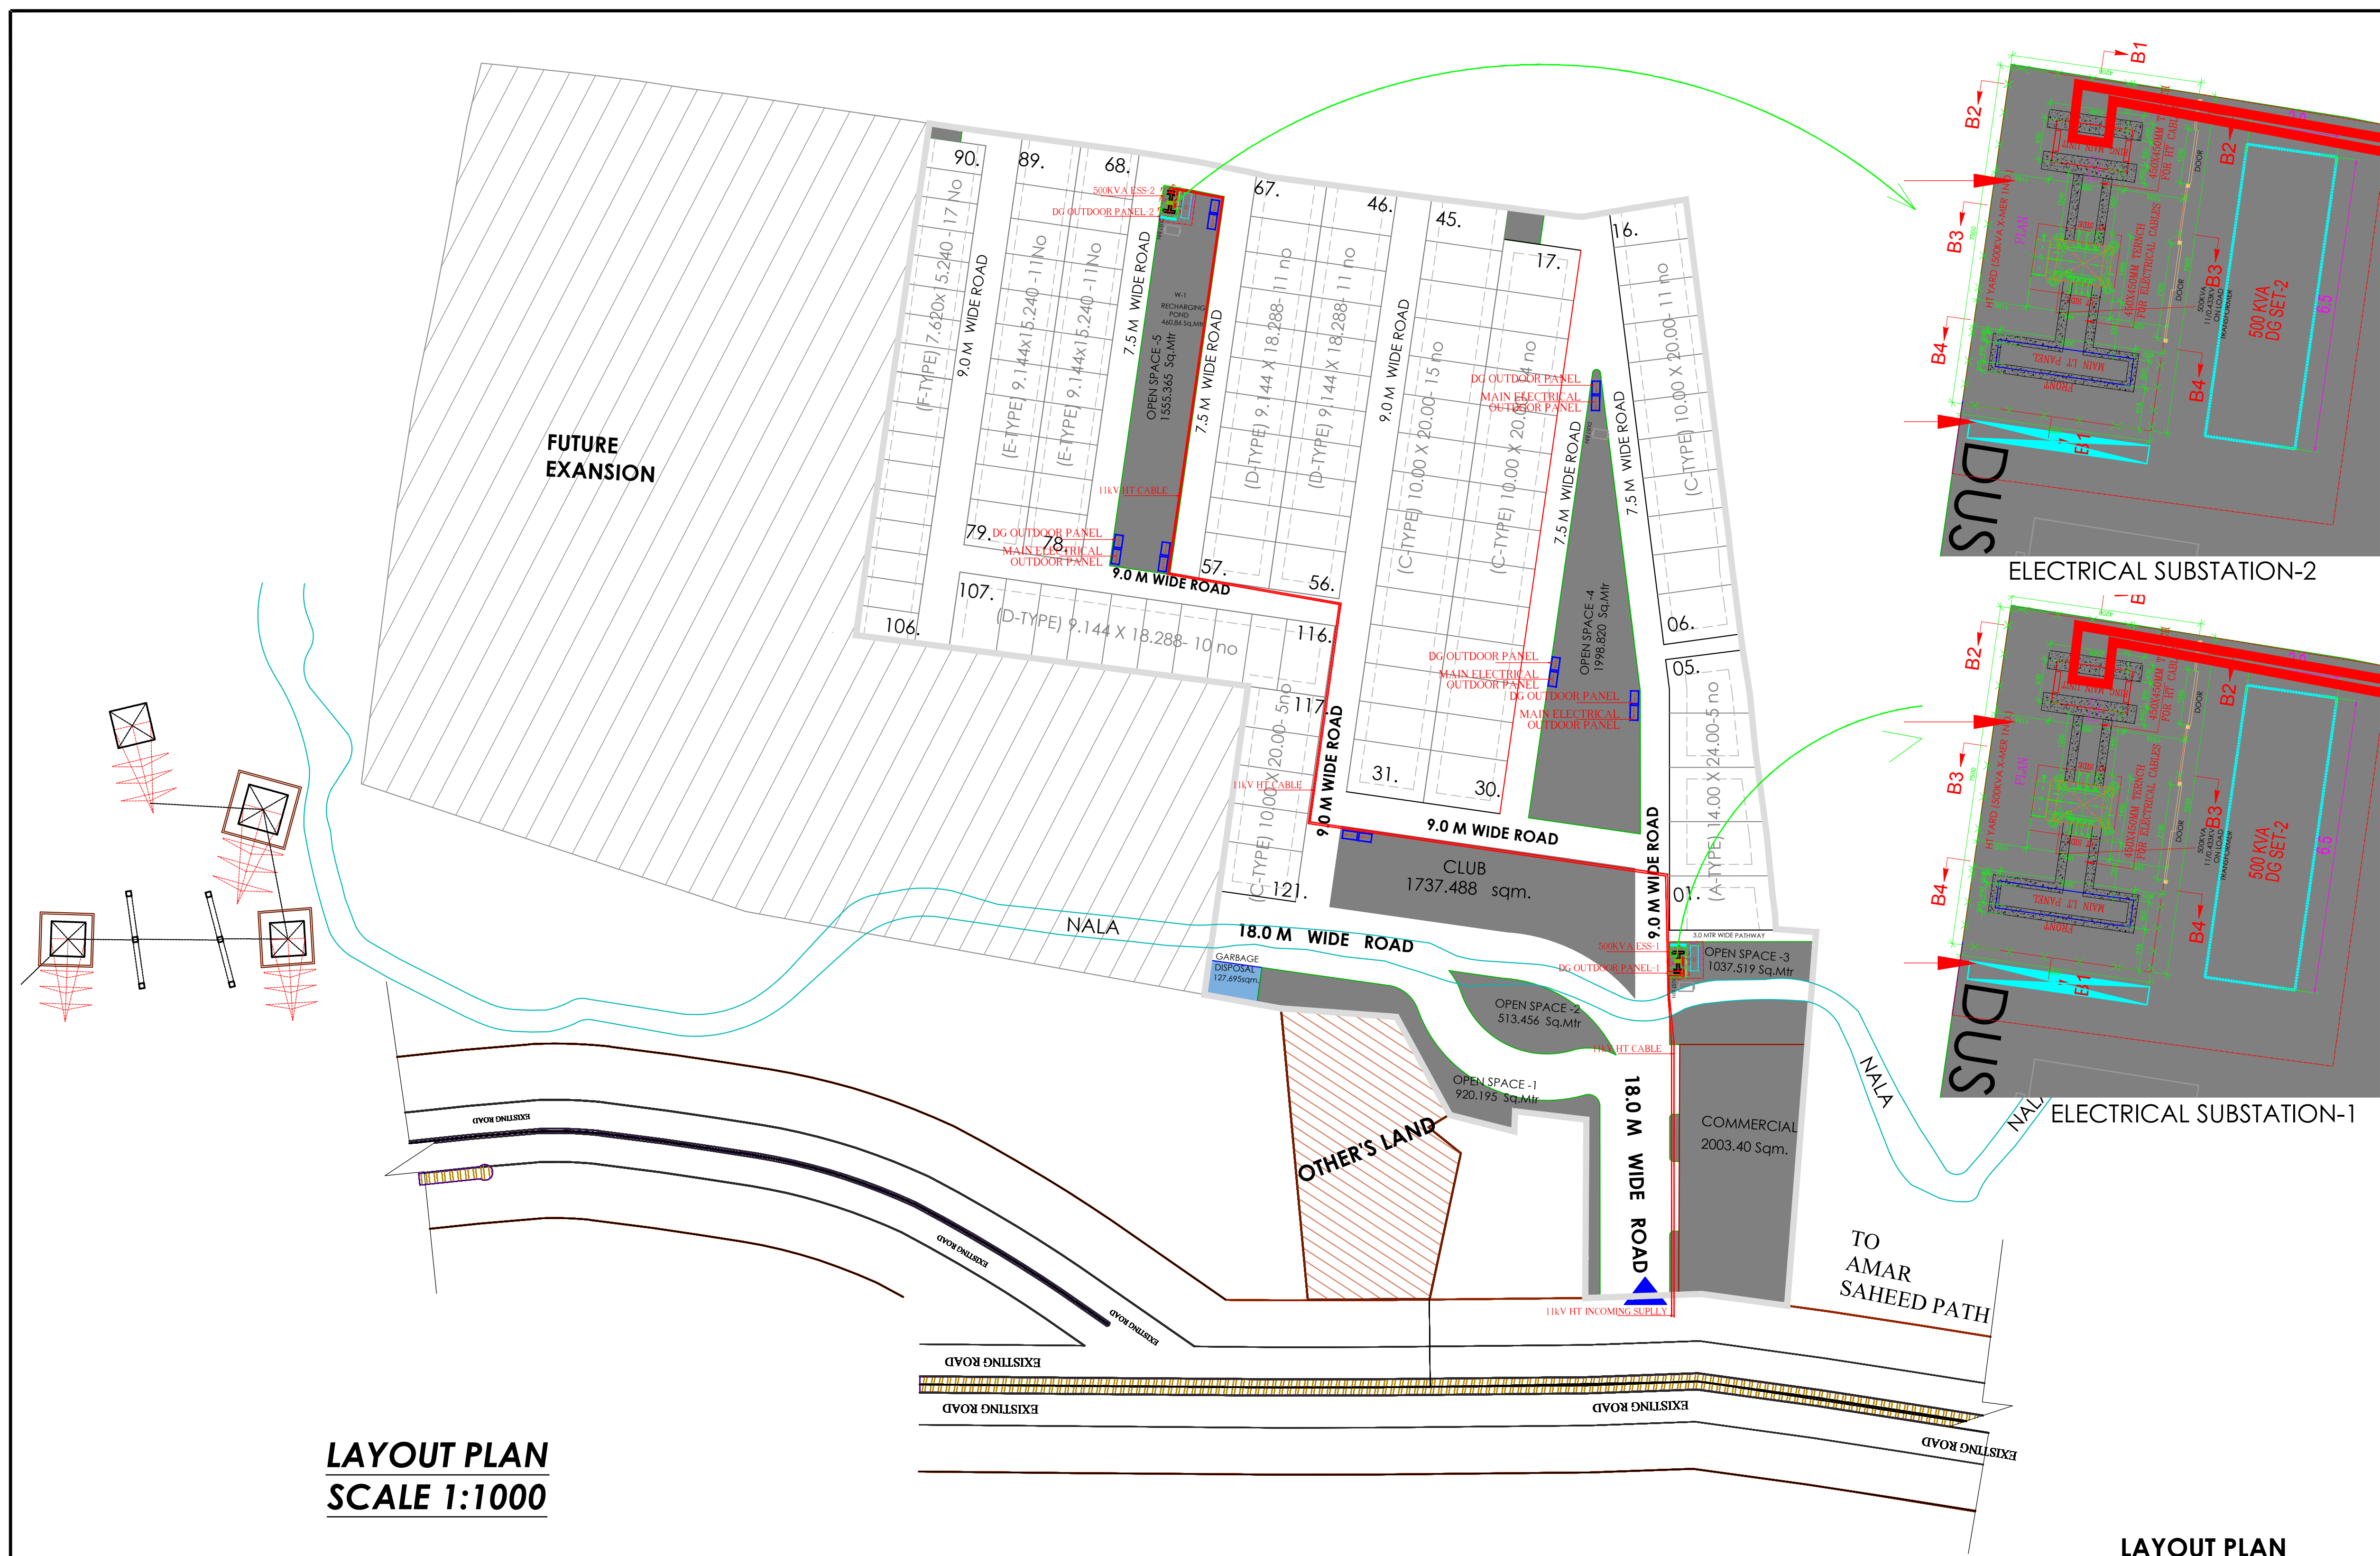

LAYOUT PLAN
SCALE 1:1000

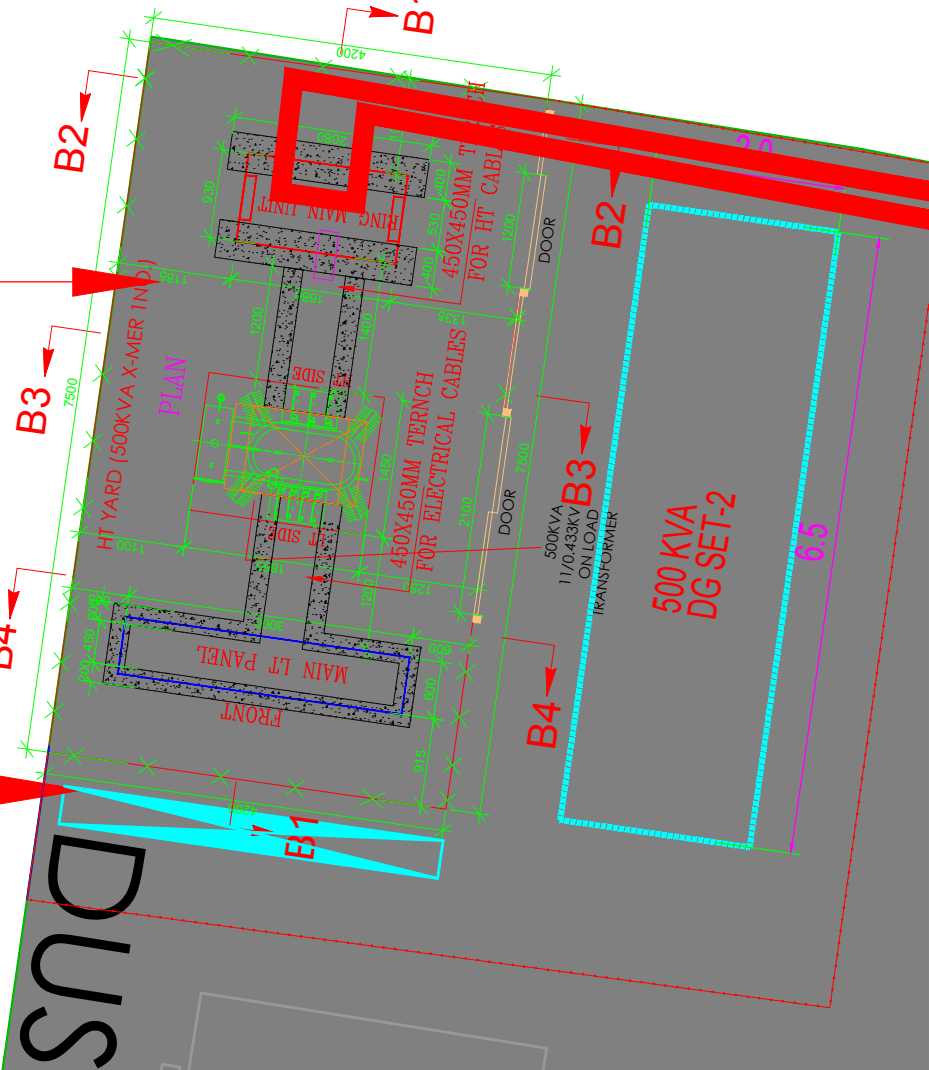

ELECTRICAL SUBSTATION-2

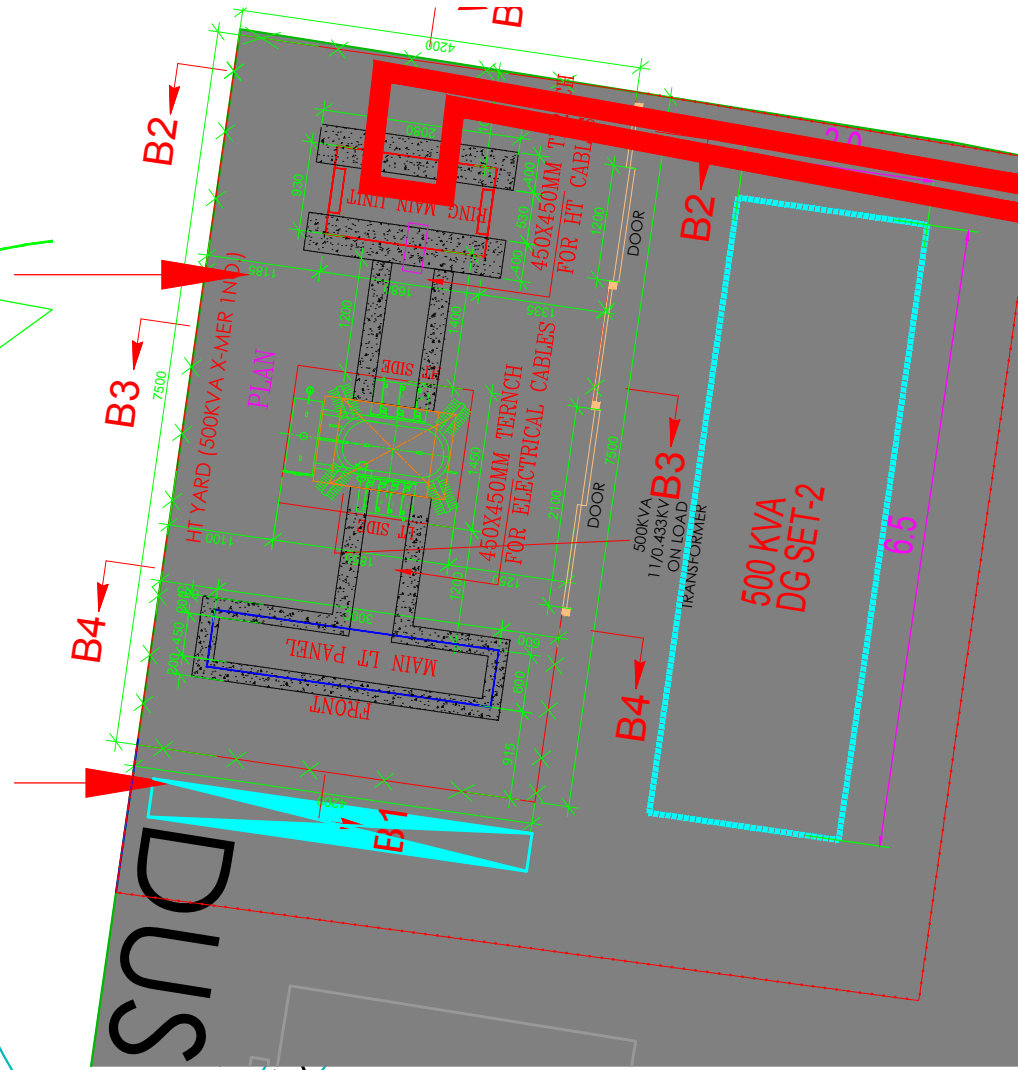

ELECTRICAL SUBSTATION-1

LAYOUT PLAN

- NOTES
1. DRAWING AND DIMENSIONS ARE ONLY TO BE READ AND NOT SCALED.
 2. ALL DIMENSIONS ARE GIVEN IN MM UNLESS OTHERWISE MENTIONED.
 3. ALL LEVELS GIVEN IN THIS DRAWING ARE WITH REFERENCE TO THE DATUM AS SPECIFIED ON SITE PLAN BY ARCHITECTS.
 4. ANY DISCREPANCY BETWEEN THE ARCHITECTURAL/STRUCTURAL OR SERVICES DRAWINGS MUST BE BROUGHT TO THE ATTENTION OF THE ARCHITECT BY THE CONTRACTOR OR DEVELOPMENT MANAGER.
 5. THIS DRAWING SHALL BE READ IN CONJUNCTION WITH RELEVANT ARCHITECTURAL, STRUCTURAL, AND SERVICES DRAWINGS.
 6. THE SIZE/THICKNESS OF ALL THE R.C.C. STRUCTURES/COLUMN, RETAINING WALL, SLAB/BELM, ETC.) SHALL BE AS PER RELEVANT STRUCTURAL DRAWING.

Rev. No.	Date	Description
R0	29.05.2020	

REVISIONS

PROJECT:
PROPOSED LAYOUT PLAN OF TOWNSHIP 'EXCELLA RESORTICO' OF 9.87 ACRES ON KHASRA NO 2, 212, 213, 214, 215, 216, 217, 218, 251 AT VILLAGE SARSAWAN, LUCKNOW

CLIENT:
M/S SUN COMPOSITE LLP
M/S ESS AAR PROPERTIES
M/S BEYOND HEIGHTS INFRA CITY Pvt Ltd
B-21345, Vihar Khand, Gomti Nagar
Lucknow - 226010

STRUCTURAL CONSULTANT:

MEP CONSULTANT:
Acrobat Engineers Pvt.Ltd.
H.No. A 1750, BASEMENT LEVEL
GATE NO.3 GREEN FIELD COLONY
NEAR NTPC CHOKHI
PH : 0120-2511312/13/20/21
customerservice@acrobatingineers.com

ARCHITECT:
K DESIGN
405, AVALON APPT,
NEW MANGALPURI, NEW DELHI-110030
E mail : architectkrateshaharma@gmail.com, royak07@gmail.com

Scale : 1:1000

Drawing Block :

SHEET NO SHEET 1

Sheet Title:
**MASTER SITE PLAN
ELECTRICAL LAYOUT**

DRAWING NO:-
AEPL/SITE/EL-01

Status:
FOR TENDER ☐ ADVANCE COPY ☐ GOOD FOR CONSTRUCTION ☒

Signature (Authorised signatory)