


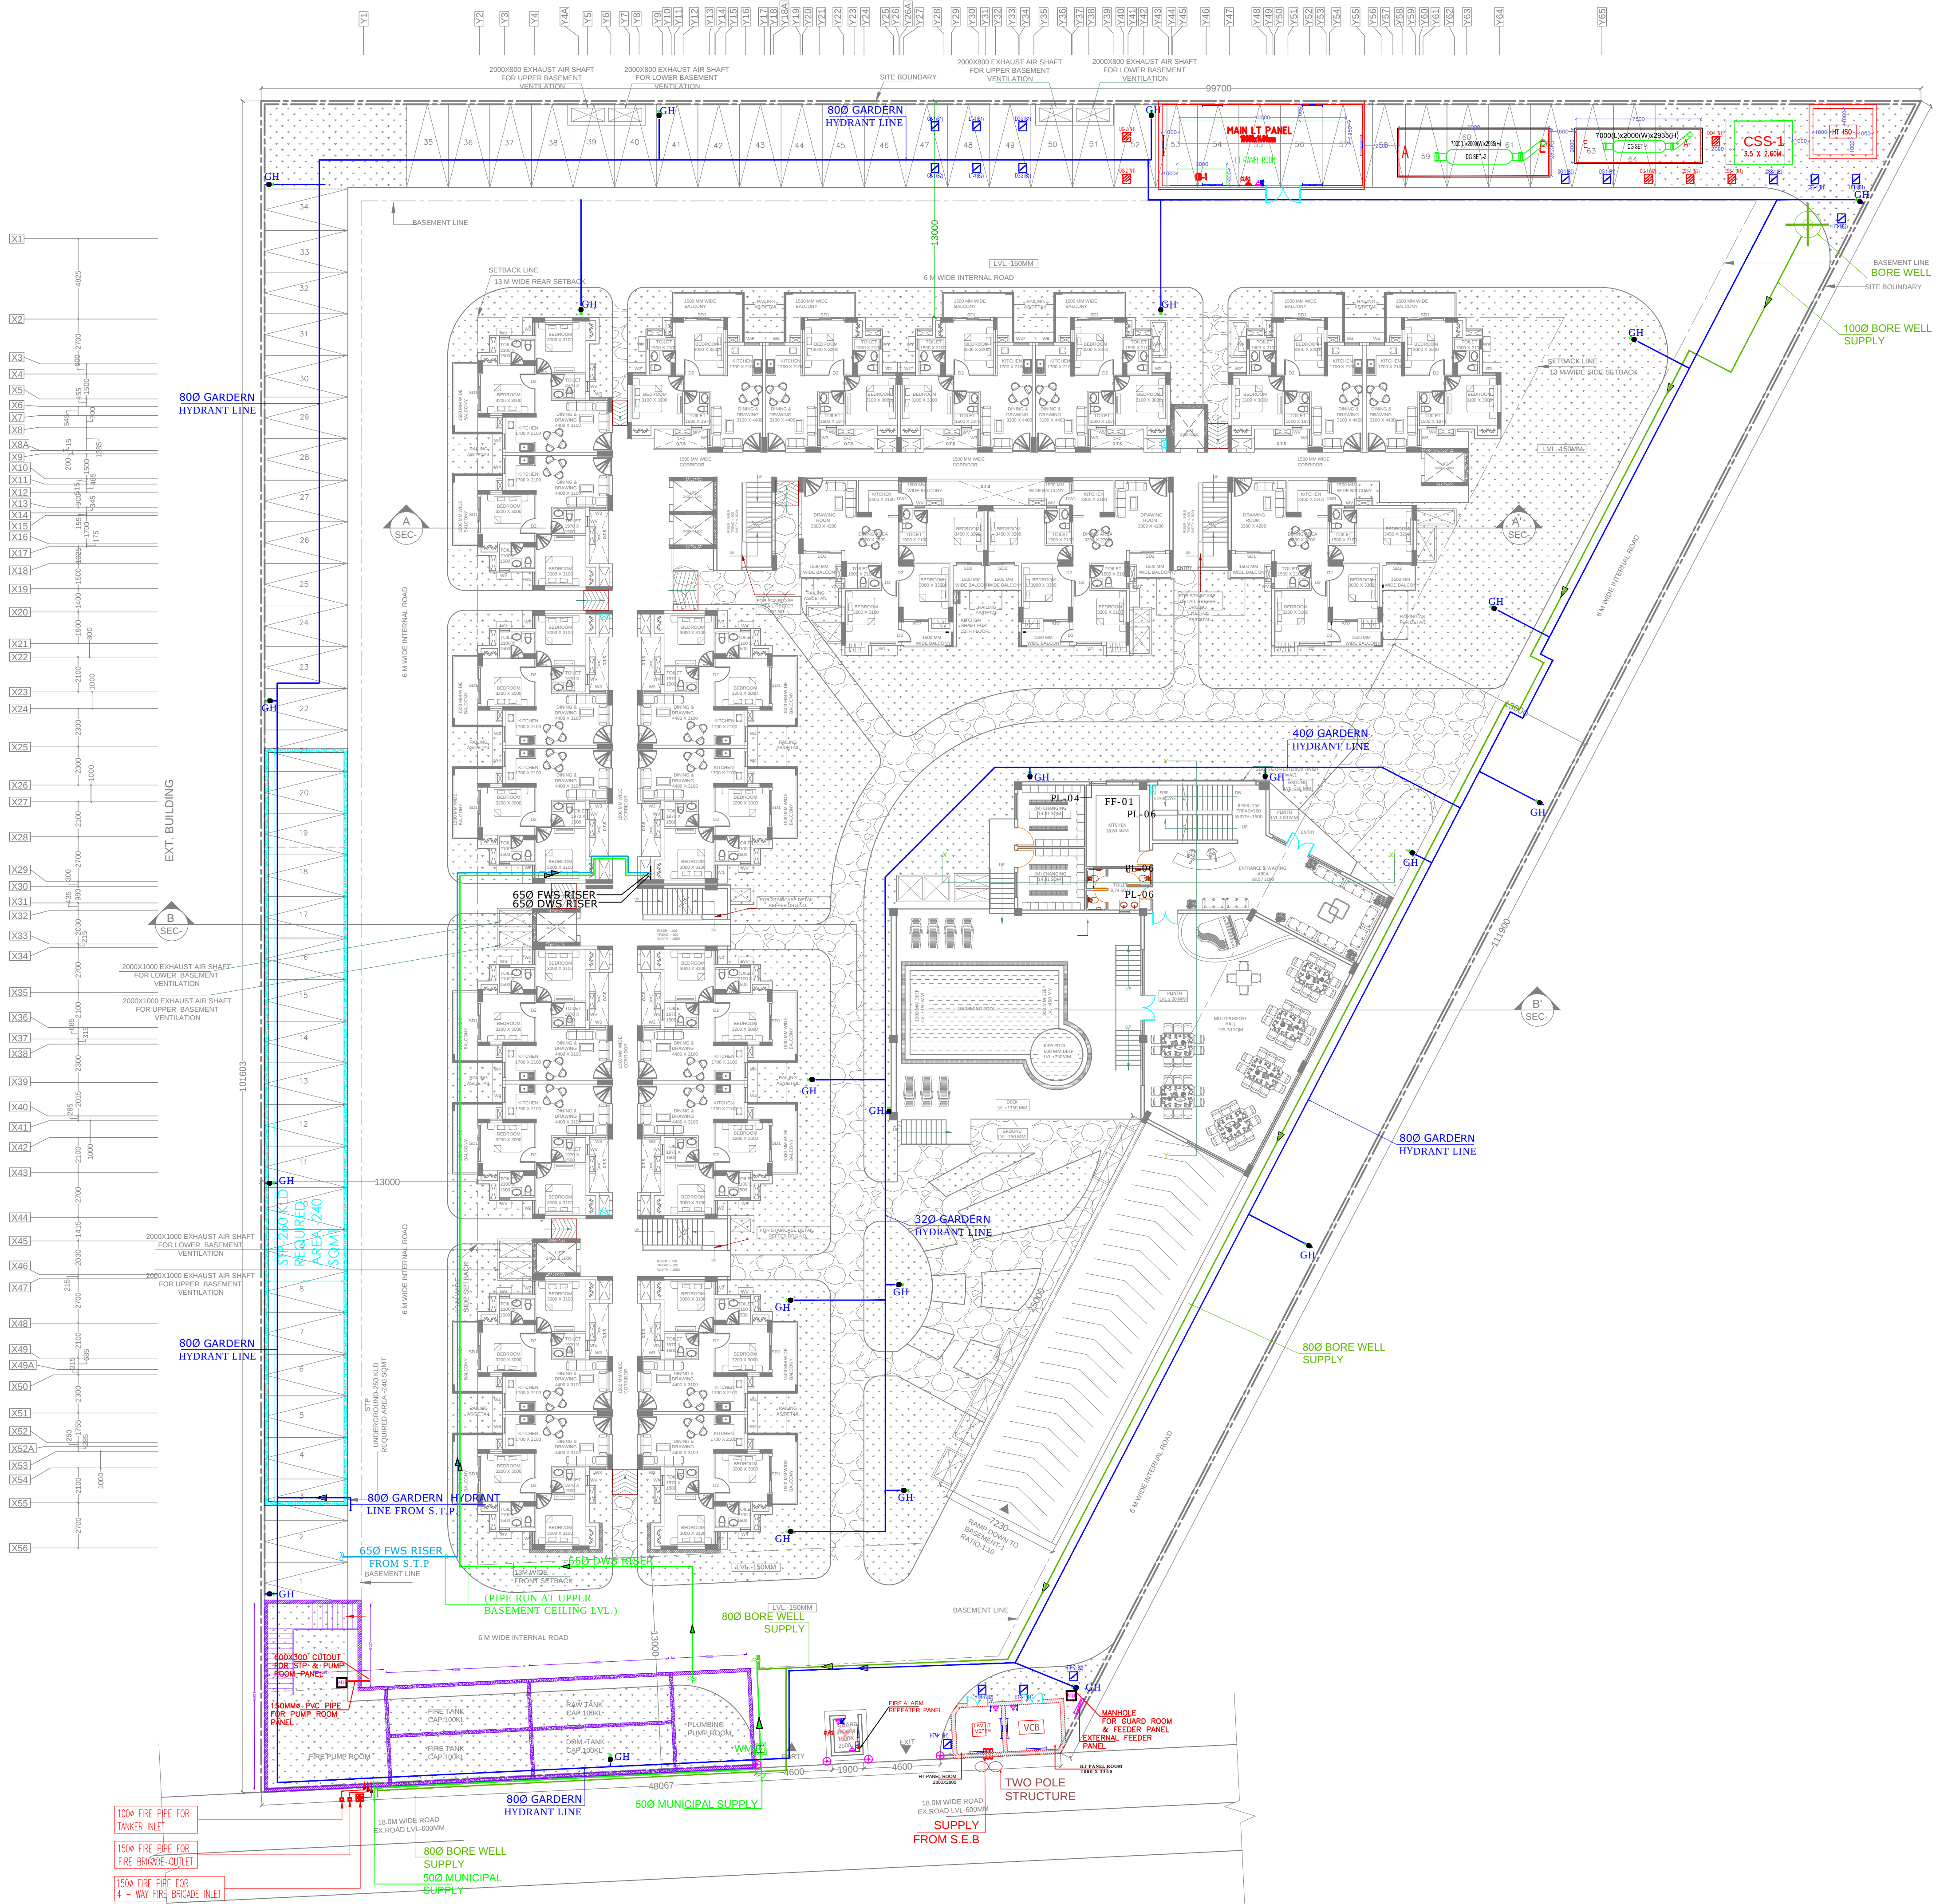

LEGEND-	
SYMBOL-	(DESCRIPTION)
	GARDNER HYDRANT PIPE
	MUNICIPAL INLET PIPE
	DOMESTIC WATER SUPPLY
	GARDNER HYDRANT

SHAFT & CUTOUT SCHEDULE

S.NO	SIZE
PL-01	900x300
PL-02	600x300
PL-03	150x150
PL-04	DELETE
PL-05	1170x600
PL-06	150x150
FF-01	600x300

R-05	05-04-17	REVISED AS PER LATEST ARCH. DWG.	D.S.	S.K.
R-04	27-03-17	REVISED AS PER LATEST ARCH. DWG.	D.S.	S.K.
R-03	18-03-17	REVISED AS PER LATEST ARCH. DWG.	D.S.	S.K.
R-02	23-02-17	REVISED AS PER LATEST ARCH. DWG.	D.S.	S.K.
R-01	20-01-17	REVISED AS PER LATEST ARCH. DWG.	D.S.	S.K.
R-00	15-12-16	REVISED AS PER LATEST ARCH. DWG.	D.S.	S.K.

Rev. No.	Date	Description	Drawn	Checked
----------	------	-------------	-------	---------

MEP CONSULTANT :-



Address:-C-15 Ground Floor, Jaipuria Apartment, Seemant Vihar, Kaushambi(Ghaziabad)
MOB.NO.-9650901083,8468001800,9718536912. email- info@skepi.com
web- www.skepi.com

ARCHITECTS :-

NEXUSPLUS CONSULTANTS PVT.LTD
B-116 2ND FLOOR,SECTOR 50,NOIDA

OWNER:-

SHOBHIK GOYYAL

PROJECT:-

LUXE PARADISE AT TAJNAGRI, AGRA

DRAWING TITLE:-

PLUMBING LAYOUT
SITE PLAN
WATER SUPPLY LAYOUT

STATUS:-

TENDER DRAWING		
DRAWN BY	ENGINEER	CHECKED BY
D.S.	S.Kumar	K.S.
PROJECT CODE	SHEET SIZE & SCALE	
	A0 1/200	
DRAWING NO.	DATE	REVISION NO
SK/SG/HG/PL/03	30/05/2017	R-05