
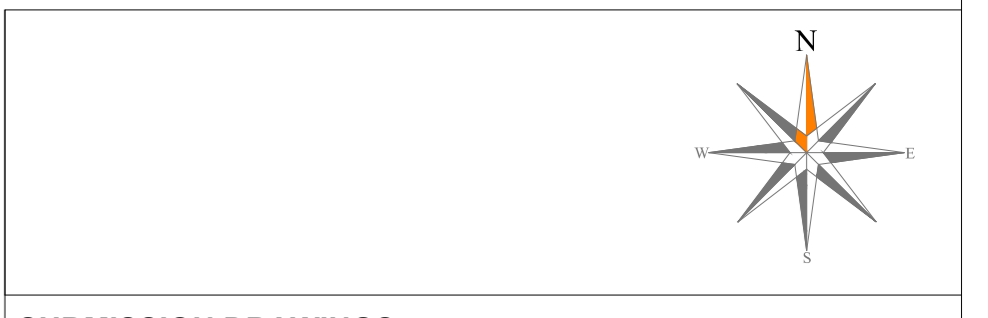


LEGEND	
	EXTERNAL FIRE HYDRANT LINE
	EPH EXTERNAL FIRE HYDRANT
	FBC FIRE BRIGADE CONNECTION
	4 WAY FIRE BRIGADE INLET FOR TANK FILLING
	ICV (INSTALLATION CONTROL VALVE)

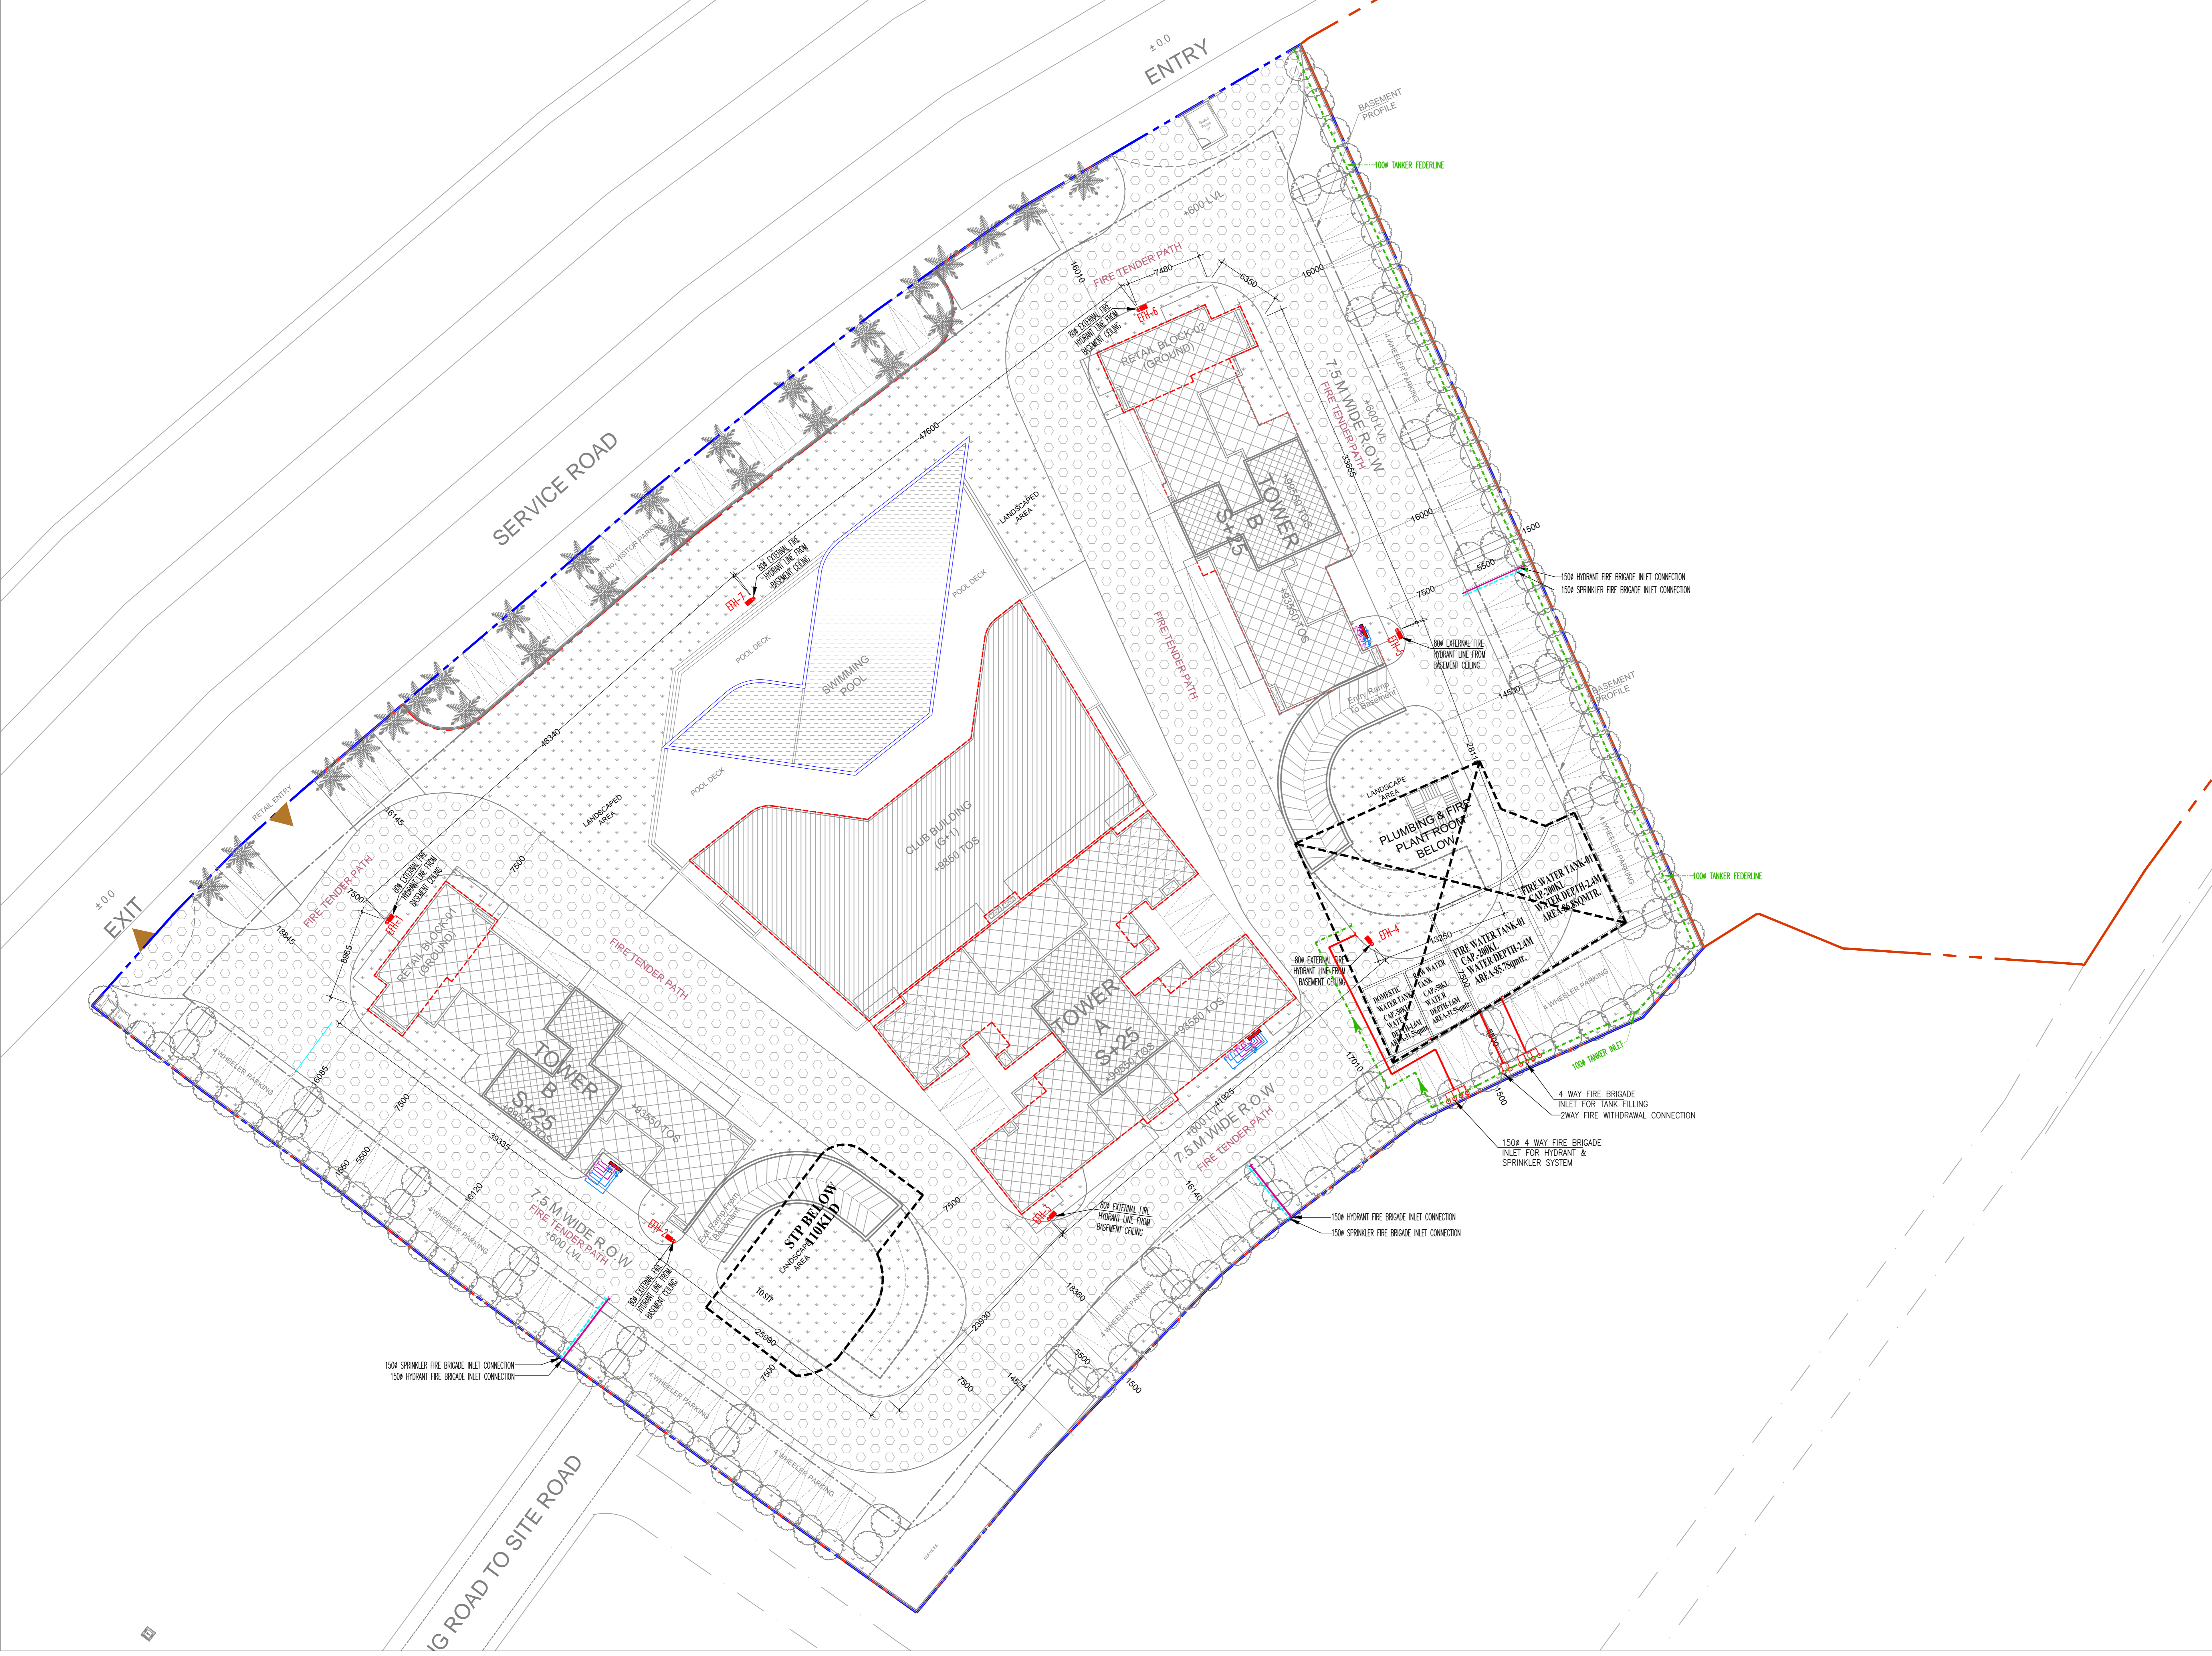

**SUBMISSION DRAWINGS**

PROJECT:  
Proposed Group housing colony scheme over an area measuring 3.09 acres at Gomati Nagar Lucknow U.P. by Inception Buildtech Private Limited.

DRAWING TITLE:  
**FIRE FIGHTING LAYOUT**

SITE PLAN

OWNER'S SIGN      ARCHITECT'S SIGN

PLUMBING & FIRE CONSULTANT:-

**CPA** C P Vidya and Associates  
 312A, UNIT-10, Sector-10, Gurgaon  
 Sector-49, NEAR PARK HOSPITAL, GURGAON  
 Haryana-122018 (INDIA)  
 Email :- cpvidyassociates@gmail.com

**ACPL** ISO 9001:2015  
 Architectural Management Planning

ACPL Design Ltd  
 E-24, South Extension - II, New Delhi-110048, India  
 Tel: +91 11 26422795  
 Fax: +91 11 26422795  
 Email: acpl@acpl.com

SCALE 1:275	DEALT BY	DATE AUG. 2023
DESIGN BY	CHECKED BY	DRG. No. PL/ST/FF-05