


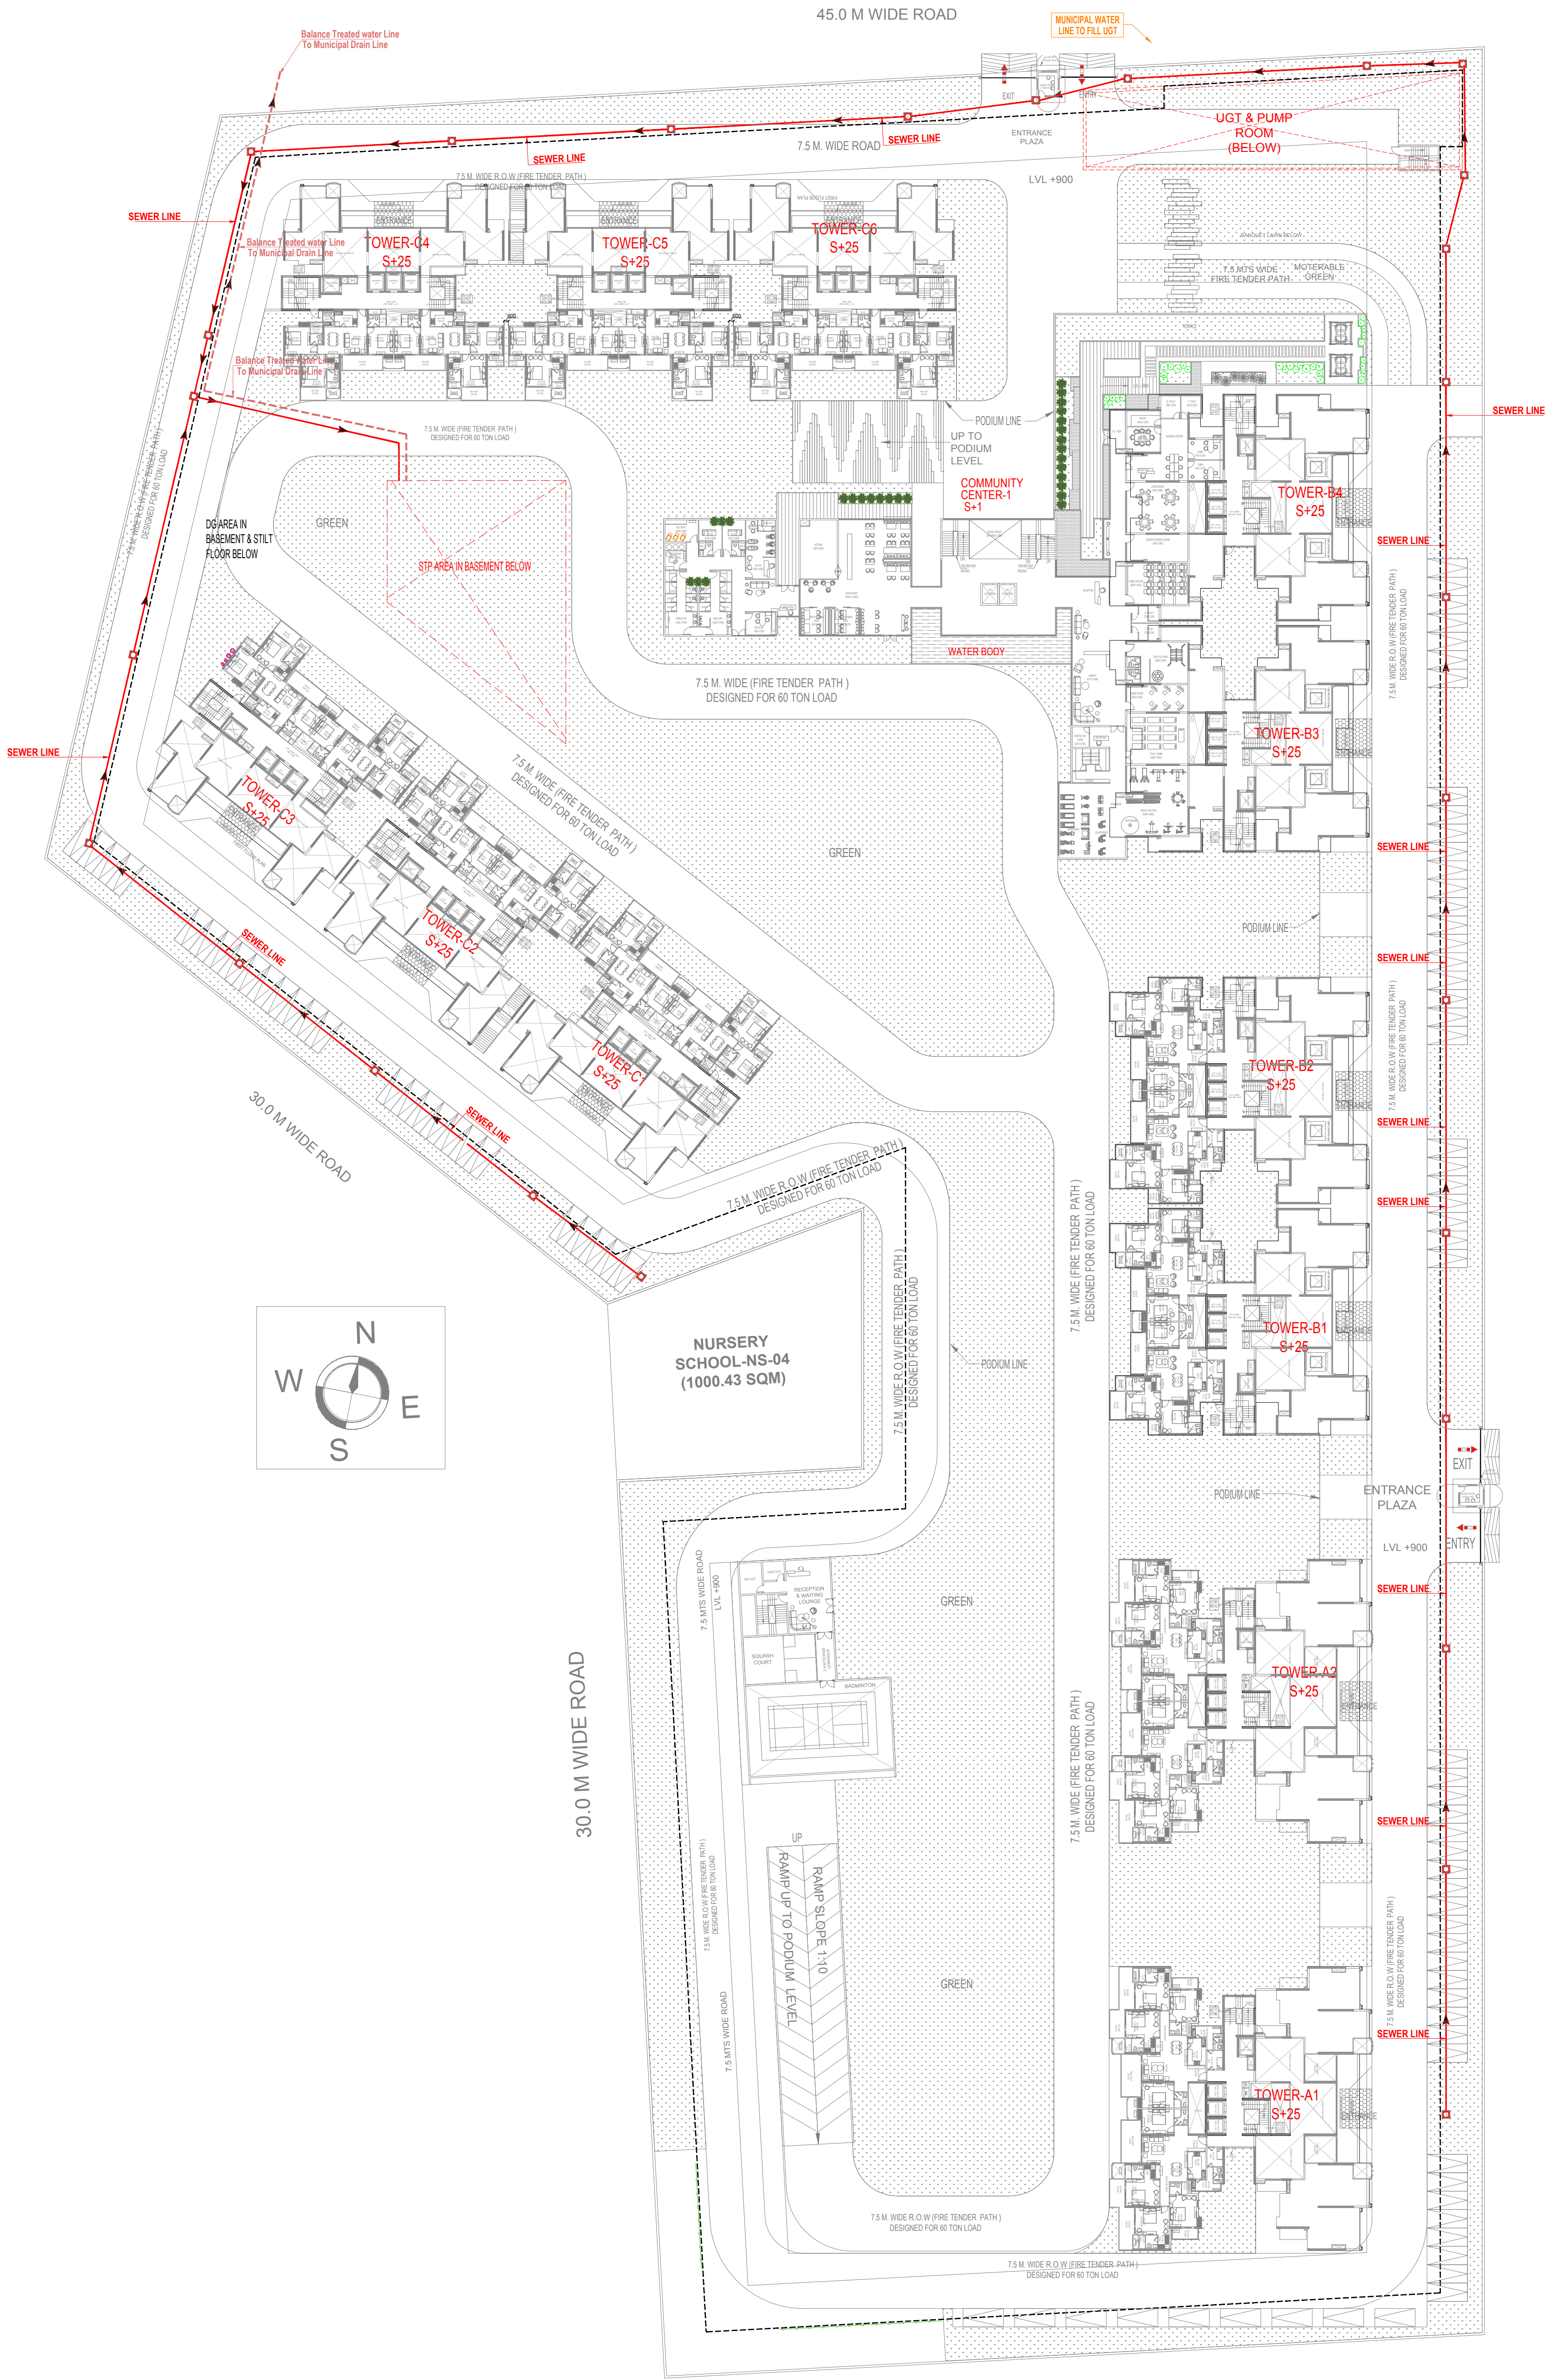

LEGEND :		
S. No.	SYMBOL	DESCRIPTION
1.	M.H.	MANHOLE
2.		SEWER LINE
3.		BYPASS SEWER LINE
4.		BASEMENT LINE

Project
PROPOSED GROUP HOUSING FOR
M/S AJAY REALCON INDIA LLP
AT PLOT NO:- P5 & P6, SECTOR - 22D
YAMUNA EXPRESS WAY, DISTRICT GAUTAM BUDDHA NAGAR (U.P.)

Title
WASTE DISPOSAL SITE PLAN
Subtitle
EXTERNAL SEWERAGE SERVICES

Drawing released for
☐ APPROVAL
☐ ADVANCE COPY
☒ SUBMISSION
☐ CONSTRUCTION

Drg. no.
ACE 11 / EX / S-01
Scale
1:500
Date
Sep. 2023

Drawn by
Kulwant
Designed by
R.K.
Checked by
Anand Havelia

Architects

Confluence
B-421, NFC, Ph: +91-11-292716008, ccs@inconfuence.com, Member of ISBC
N.D-65, INDIA Ph: +91-11-45564768, www.inconfuence.com, ISO - 9001 : 2000
architecture urban design hospitality interiors

Services Consultant
Consummate Engineering Services (P) Ltd.
Noida Office : B - 67, Sector - 67, Noida - 201 301
Tel : (0120) 6943500 (23 Lines)
Lko. Office : R 006, Rohtas Plumeria, Gomti Nagar, Lucknow
Tel : (0522) 4025902
e mail : mail@cespl.in, website : www.cespl.in