



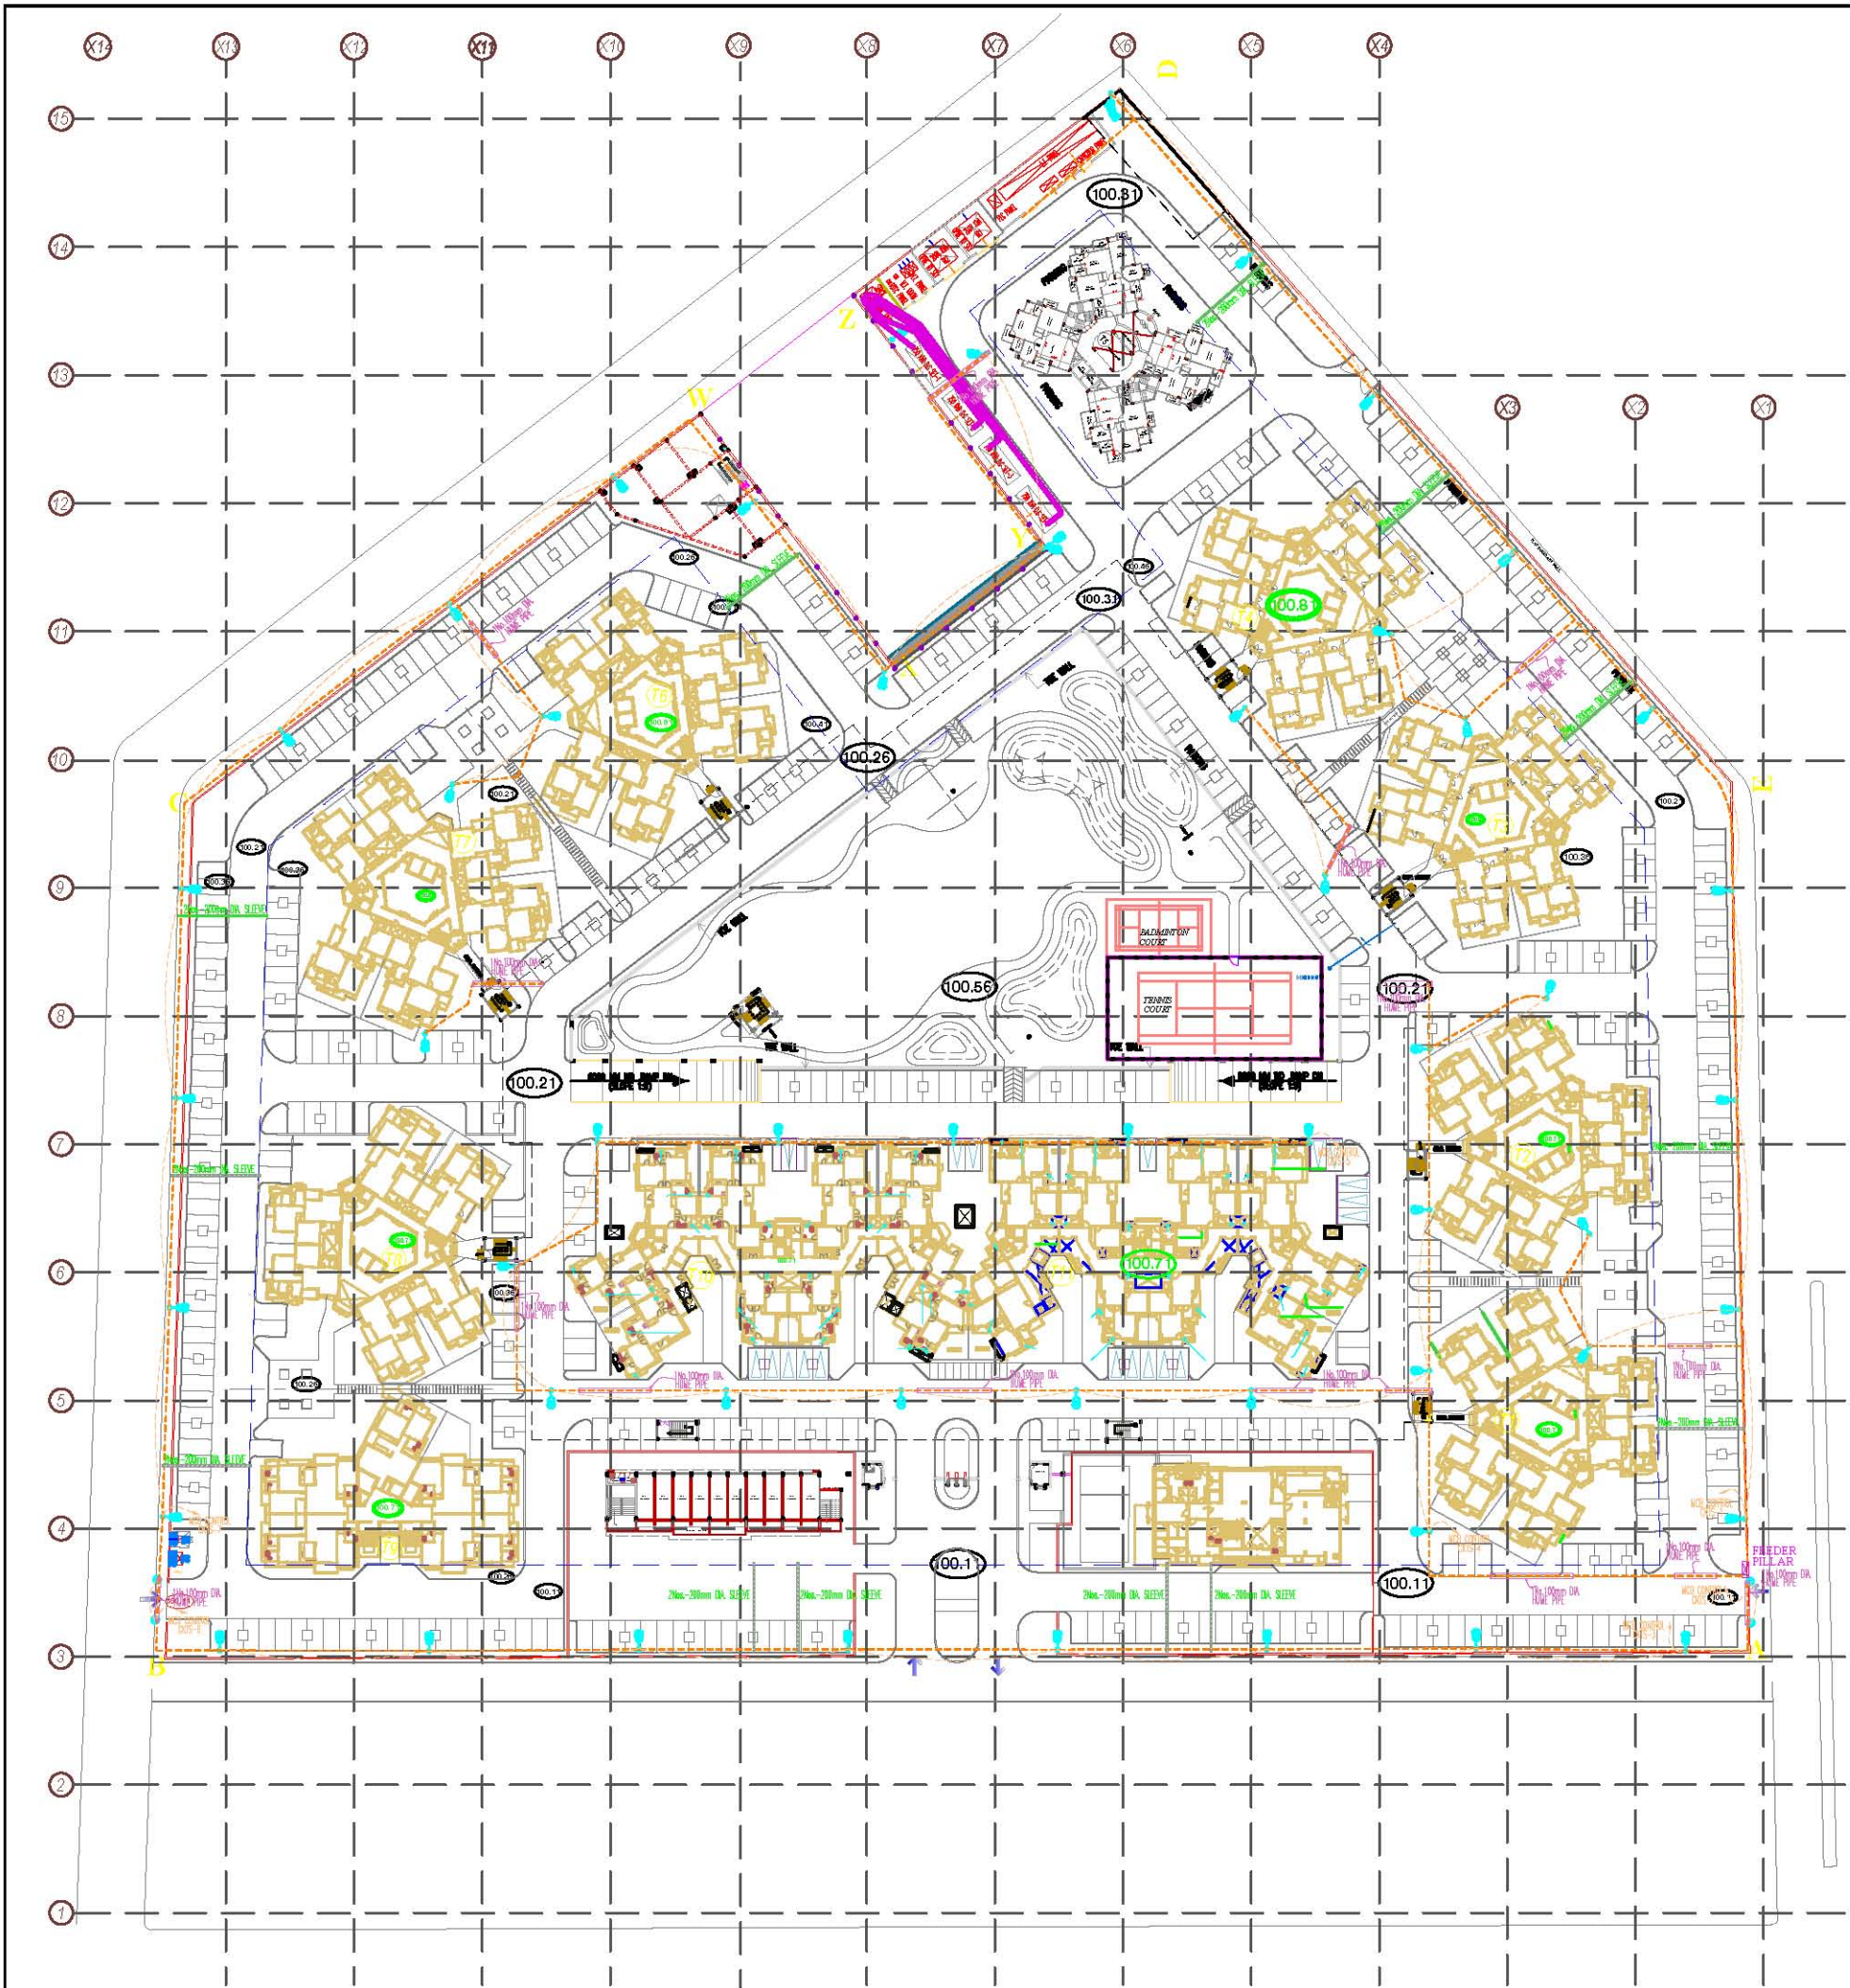

EXTERNAL LIGHTING LAYOUT

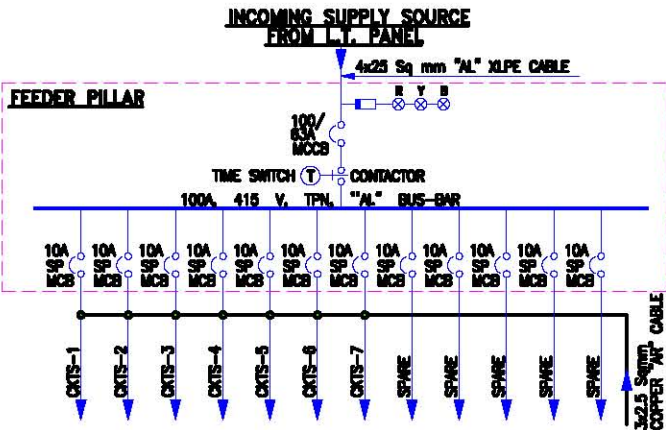

DESCRIPTION	SYM.	QTY.
7 Mtrs Street Light Pole-1x70Watt. Son-T Lamp Phillips Cat. ref. CRP 320		35 Nos.
11 Mtrs Street Light Pole-1x250Watt. Son-T Lamp. Phillips Cat. ref. SGP 401		28 Nos.
Gate Lighting 1x70Watt. Son-T Lamp Phillips Cat. ref. HPS 1121xSON 70W WIC		4 Nos.
L.T. CABLE ROUTE		
EMER./STREET LTG. FEEDER PILLAR		

PROPOSED GROUP HOUSING ON PLOT NO. 9-D/G.H.-1, SECTOR-9-D AT VRINDAVAN YOJANA NO.-2, LUCKNOW PROMOTER: ELDECO HOUSING & INDUSTRIES LTD.	DESIGNER: A/Sanjay Kumar Gupta 10/F, Pooja Corporate Chamber-1, Mahatma Road, Civil Lines, Lucknow-226010 Ph: 9080808, 9081808 www.sanjaygupta.com	DRAWING TITLE: SAUBHGYAM EXTERNAL LIGHTING LAYOUT PROJECT: ELDECO SAUBHAGYAM VRINDAVAN COLONY, SHAHEED PATH, RAIBERILY ROAD, LUCKNOW	CLIENT: ELDECO HOUSING & INDUSTRIES LTD. ARCHITECTS :- SPACE COMBINE Architects, Engineers, Planners project management consult. A1/112 SHYAMAL ENCLAVE, NEW DELHI -110029 Ph: 4610000	ENGINEER CONSULTANT :- D.P. ARORA & ASSOCIATES G-2/40, ANAND APARTMENT PACHA WADI, NEW DELHI-11 MOB: 92221400 E-mail: dp_arora@yahoo.com <table><tr><td>DESIGN BY:-</td><td>DPA</td><td>DESIGNED BY:-</td></tr><tr><td>CHECKED BY:-</td><td>SUNNY</td><td>SCALE/DATE:-</td></tr><tr><td>DATE:-</td><td>2009</td><td>JOB NO.:-</td></tr><tr><td>REV:-</td><td>01-09-09</td><td></td></tr></table>	DESIGN BY:-	DPA	DESIGNED BY:-	CHECKED BY:-	SUNNY	SCALE/DATE:-	DATE:-	2009	JOB NO.:-	REV:-	01-09-09	
DESIGN BY:-	DPA	DESIGNED BY:-														
CHECKED BY:-	SUNNY	SCALE/DATE:-														
DATE:-	2009	JOB NO.:-														
REV:-	01-09-09															