


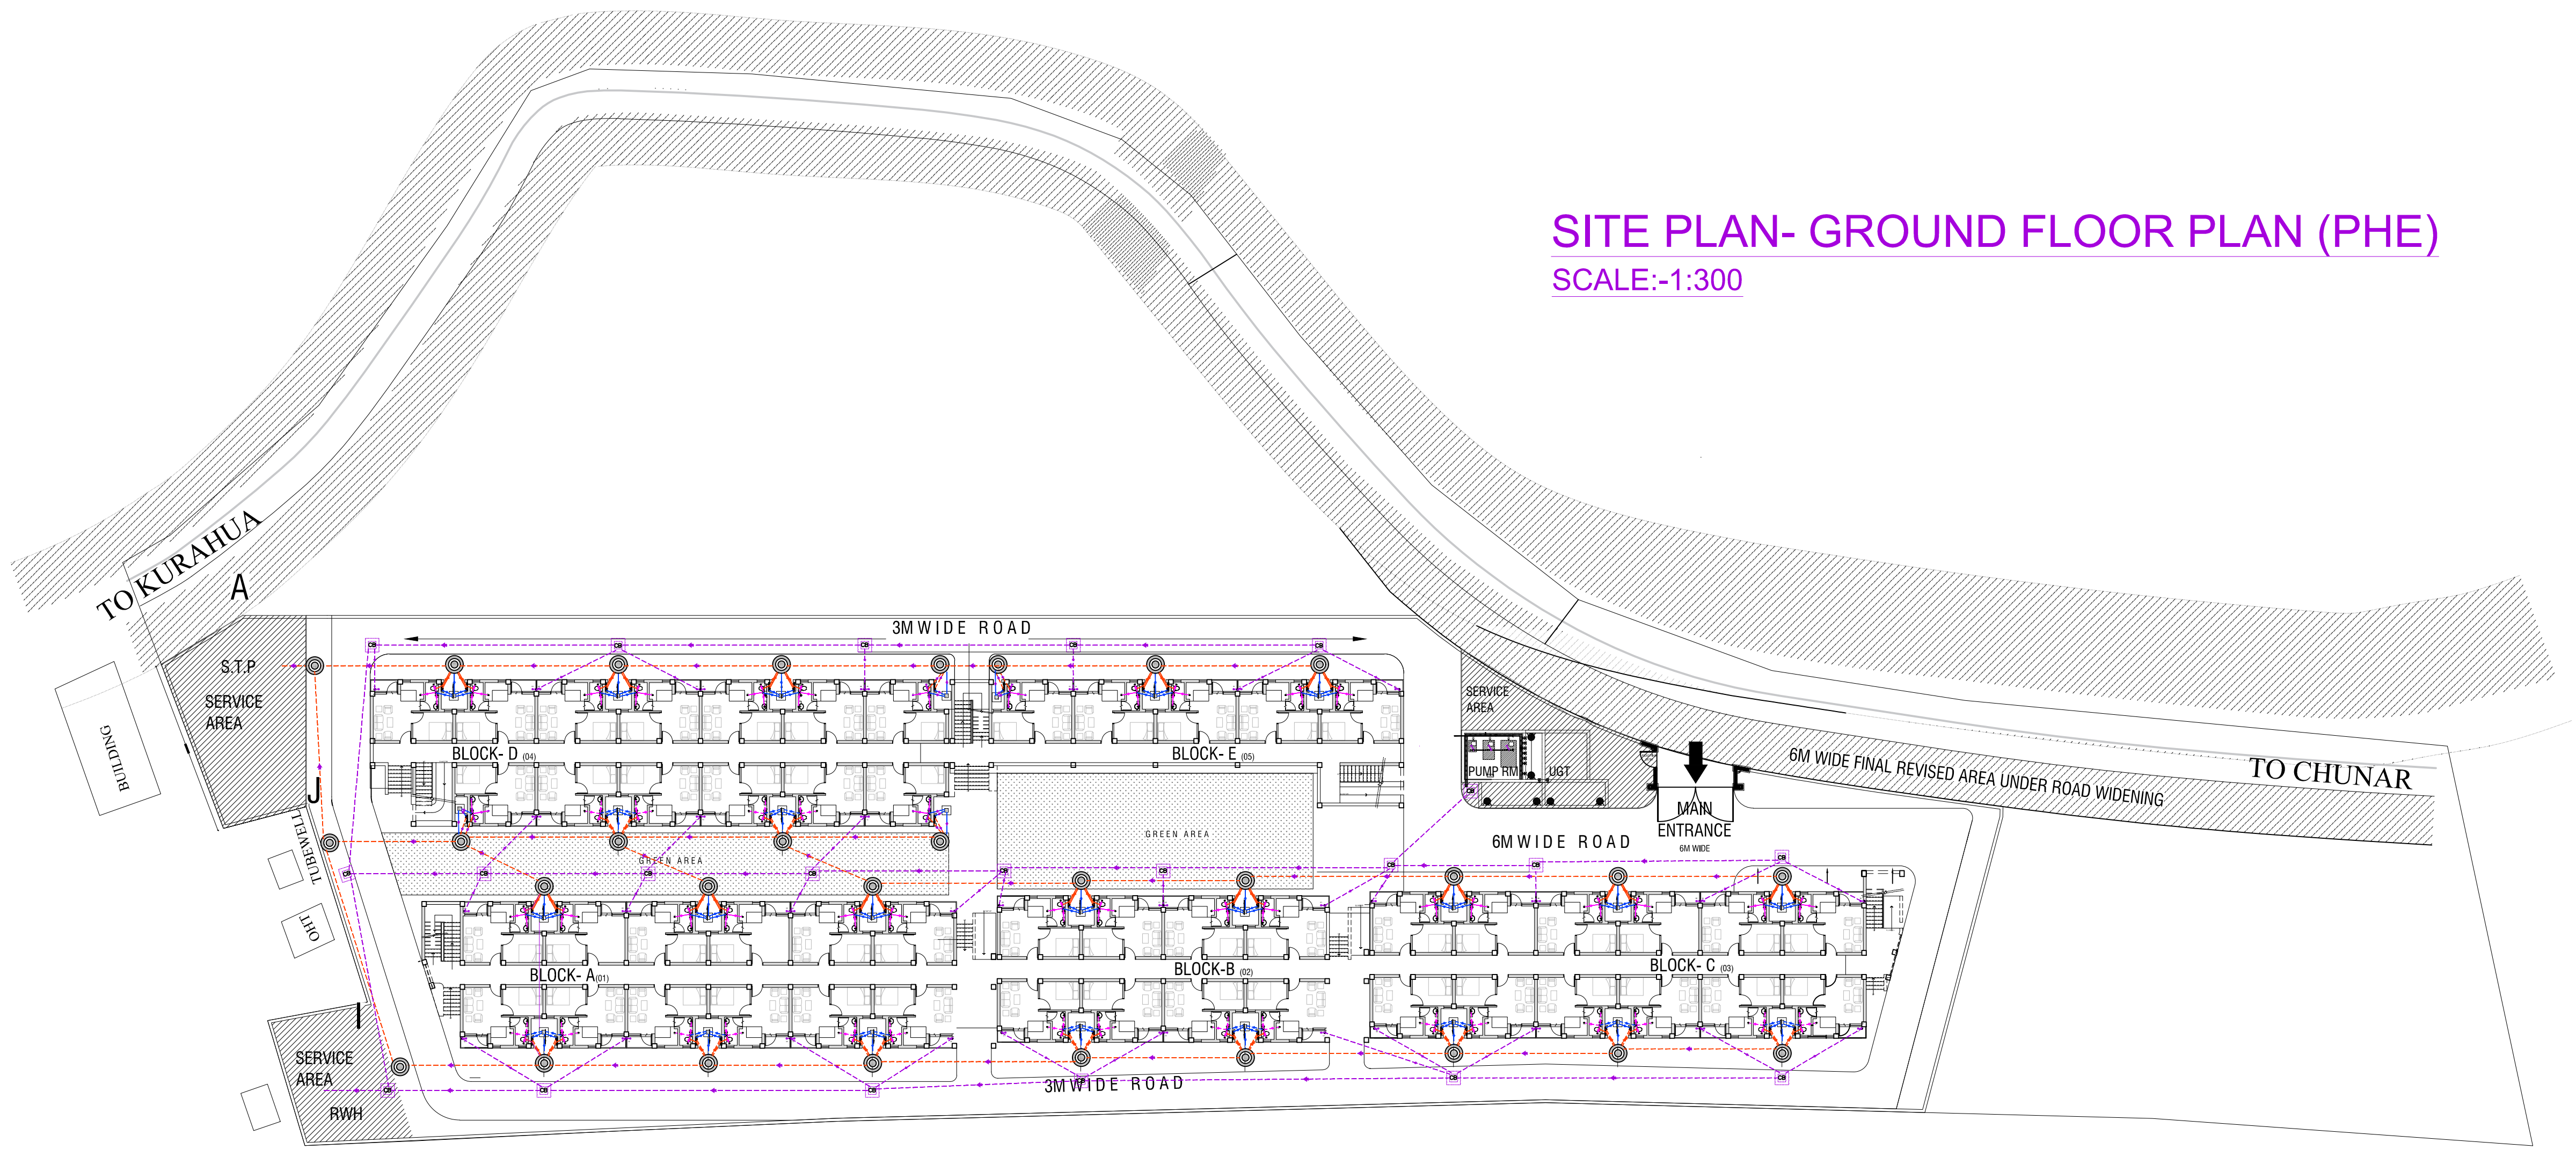

SITE PLAN- GROUND FLOOR PLAN (PHE)
SCALE:-1:300

NOTE:-

- # APPROVAL / NOC SHOULD BE OBTAINED FROM THE CONCERNED LOCAL AUTHORITIES / DEPTTS . AS PER RULES BEFORE EXECUTION OF THE WORK.
- # NO CHANGES ARE TO BE INCORPORATED IN THE DESIGN/ CONST- RUCTION WITHOUT CONCERN OF THE CHIEF ARCHITECT.
- # PHOTO COPYING OR TRACING OF THIS DRAWING IS NOT PERMITTED.
- # ANY CONFUSION OR ERROR REGARDING THIS DRAWINGS SHALL BE BROUGHT IN TO THE KNOWLEDGE OF THE CHIEF ARCHITECT BEFORE EXECUTION.
- # EXISTING STRUCTURE THOSE WHICH ARE NOT USE SHOULD WE DISMENTALED AS PER REQUIREMENT OF PERMISSABLE GROUND COVERAGE.
- # DRAWING IS NOT TO BE MEASURED
- # ALL STRUCTURE DETAILS TO BE REFERRED WITH STRUCTURE DRAWINGS

CHAMBER DESCRIPTIONS	
STORM & SEWER MANHOLE (PERFORATED GRATING)	DEPTH RANGE
450x450 (CB)	(450mm-600mm)
600x600 (CB)	(600mm-750mm)
750x750 (CB)	(750mm-900mm)
800x900 (CB)	(900mm-1200mm)

PLUMBING LEGEND:-

	INTERNAL WASTE WATER PIPE
	EXTERNAL WASTE WATER PIPE
	EXTERNAL SEWERAGE PIPE
	EXTERNAL DRAINAGE PIPE

	SEWERAGE MANHOLE
	GULLY TRAP
	CATCH BASIN
	SEWER CIRCULAR MH 910 DIA
	DRAIN CIRCULAR MH 910 DIA

CONSTRUCTION DRAWING

REVISION			

S.N.	DATE	DESCRIPTIONS	INITIAL

ARCHITECTURE

INTEGRATED STUDIO FOR ENVIRONMENTAL EFFORTS & DEVELOPMENT PVT. LTD. (InSEED PVT LTD)

PROJECT TITLE:

PMAY_HFA2022_250DHU_KURUHUA_VARANASI

KHASRA NUMBER:

खसरा संख्या 75, कुरुहुआ, जनपद वाराणसी

CLIENT :-

VARANASI DEVELOPMENT AUTHORITY, VARANASI

DRAWING TITLE:

SITE PLAN PHE-GROUND FLOOR (SEWERAGE & STORM WATER DRAINAGE)

DRAWING NUMBER:

InSEED-PMAY/KURAHUA/VDA/2020/ PHE / SITE LAYOUT GROUND FLOOR PLAN/001

DEALT BY :	DATE:	REV.NO
SMITA	18-09-2020	R0
CHECKED BY:	SCALE:	
ANKUR	1:300	