


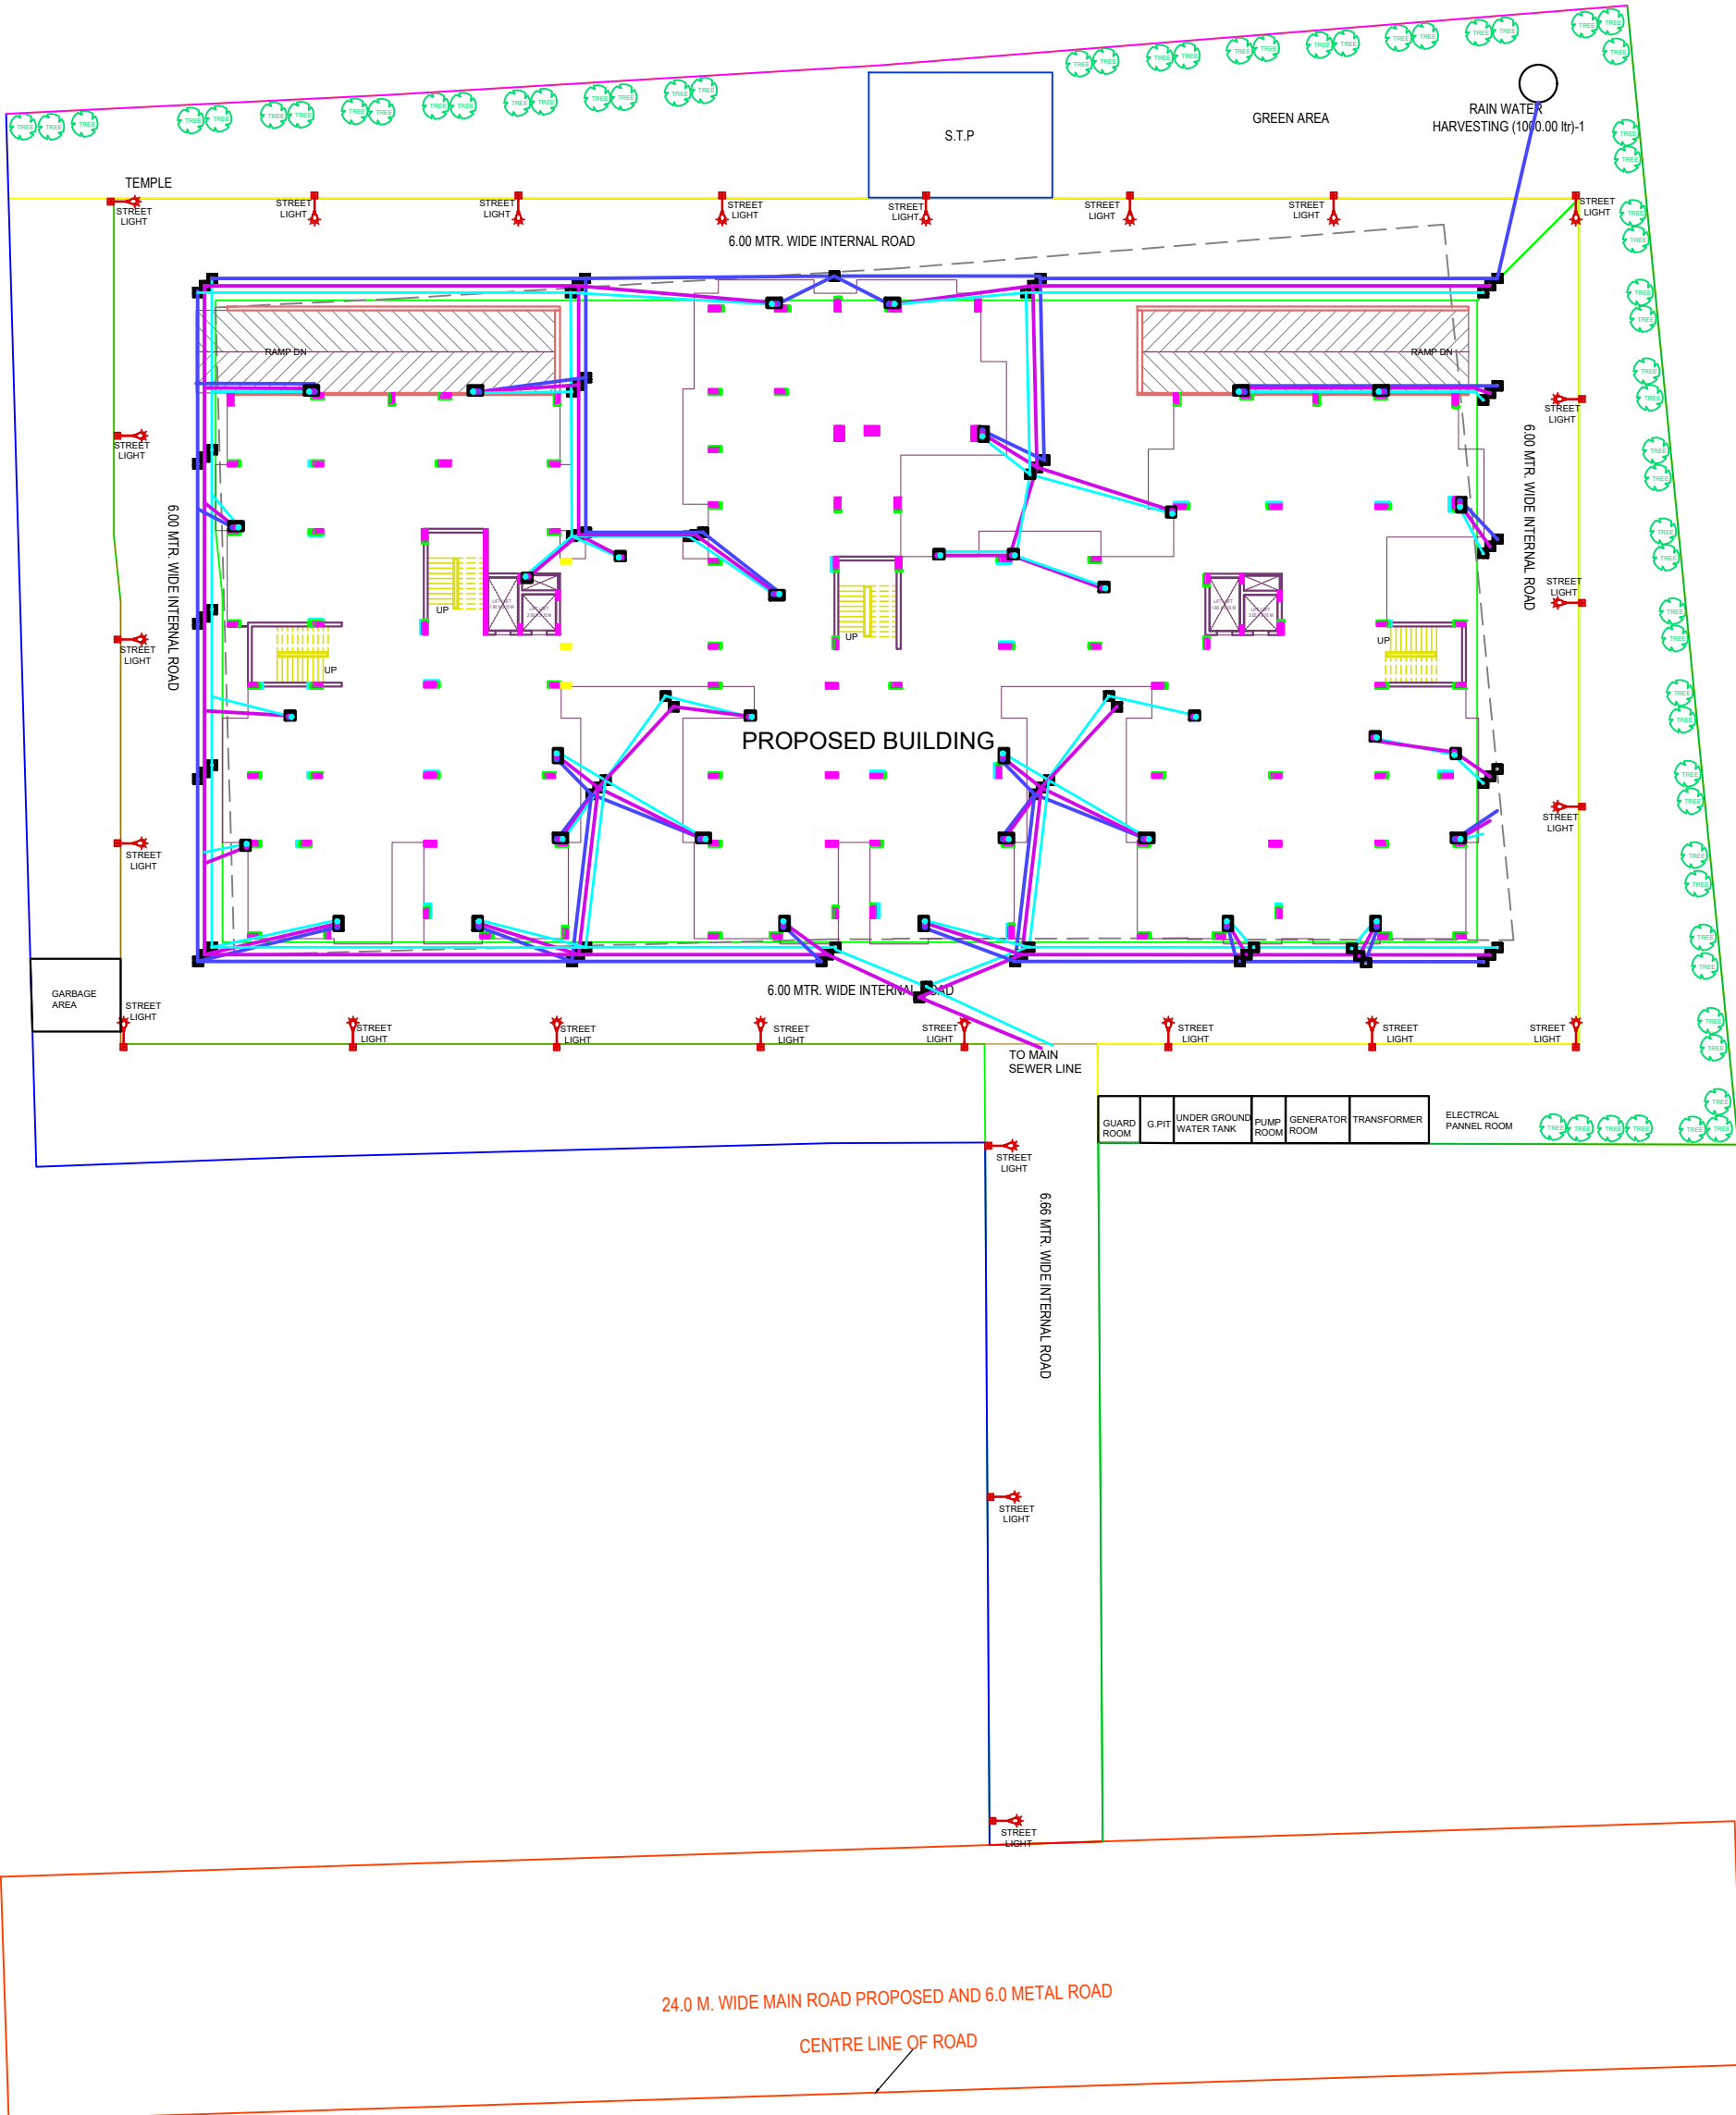

PROJECT

RAJENDRA PRASAD SINGH, SURENDRA NARAYAN SINGH, SHIV KUMAR SINGH, NISHA DEVI, DEEPAK SINGH, GIRISH KUMARI, PRAMOD KUMAR RAI, LOVKUSH SINGH, AWADH BUILDCON THROUGH DIRECTOR SUSHIL KUMAR RAI



DRAWING TITLE
SITE PLAN
PLUMBING LAYOUT
DRAWING STATUS


DATE RIV 20-05-2025
SHEET NO. 01
DRAWN BY RAHUL
CHECKED BY

ARCHITECT
AR. AJAY SINGH



DESIGN CENTRE
ESTABLISHED - 1995
MAKE IDEAS HAPPEN
ARCHITECTURE | PROJECT MANAGEMENT | INTERIORS | ENGINEER

WEB :- www.designcentreindia.in
E-MAIL :- ajaysingh@designcentreindia.in
S, 10/8-3K, P, Maqbool Alam Rd, Khajuri Colony, Varanasi - 221002
PHONE - 9628932134

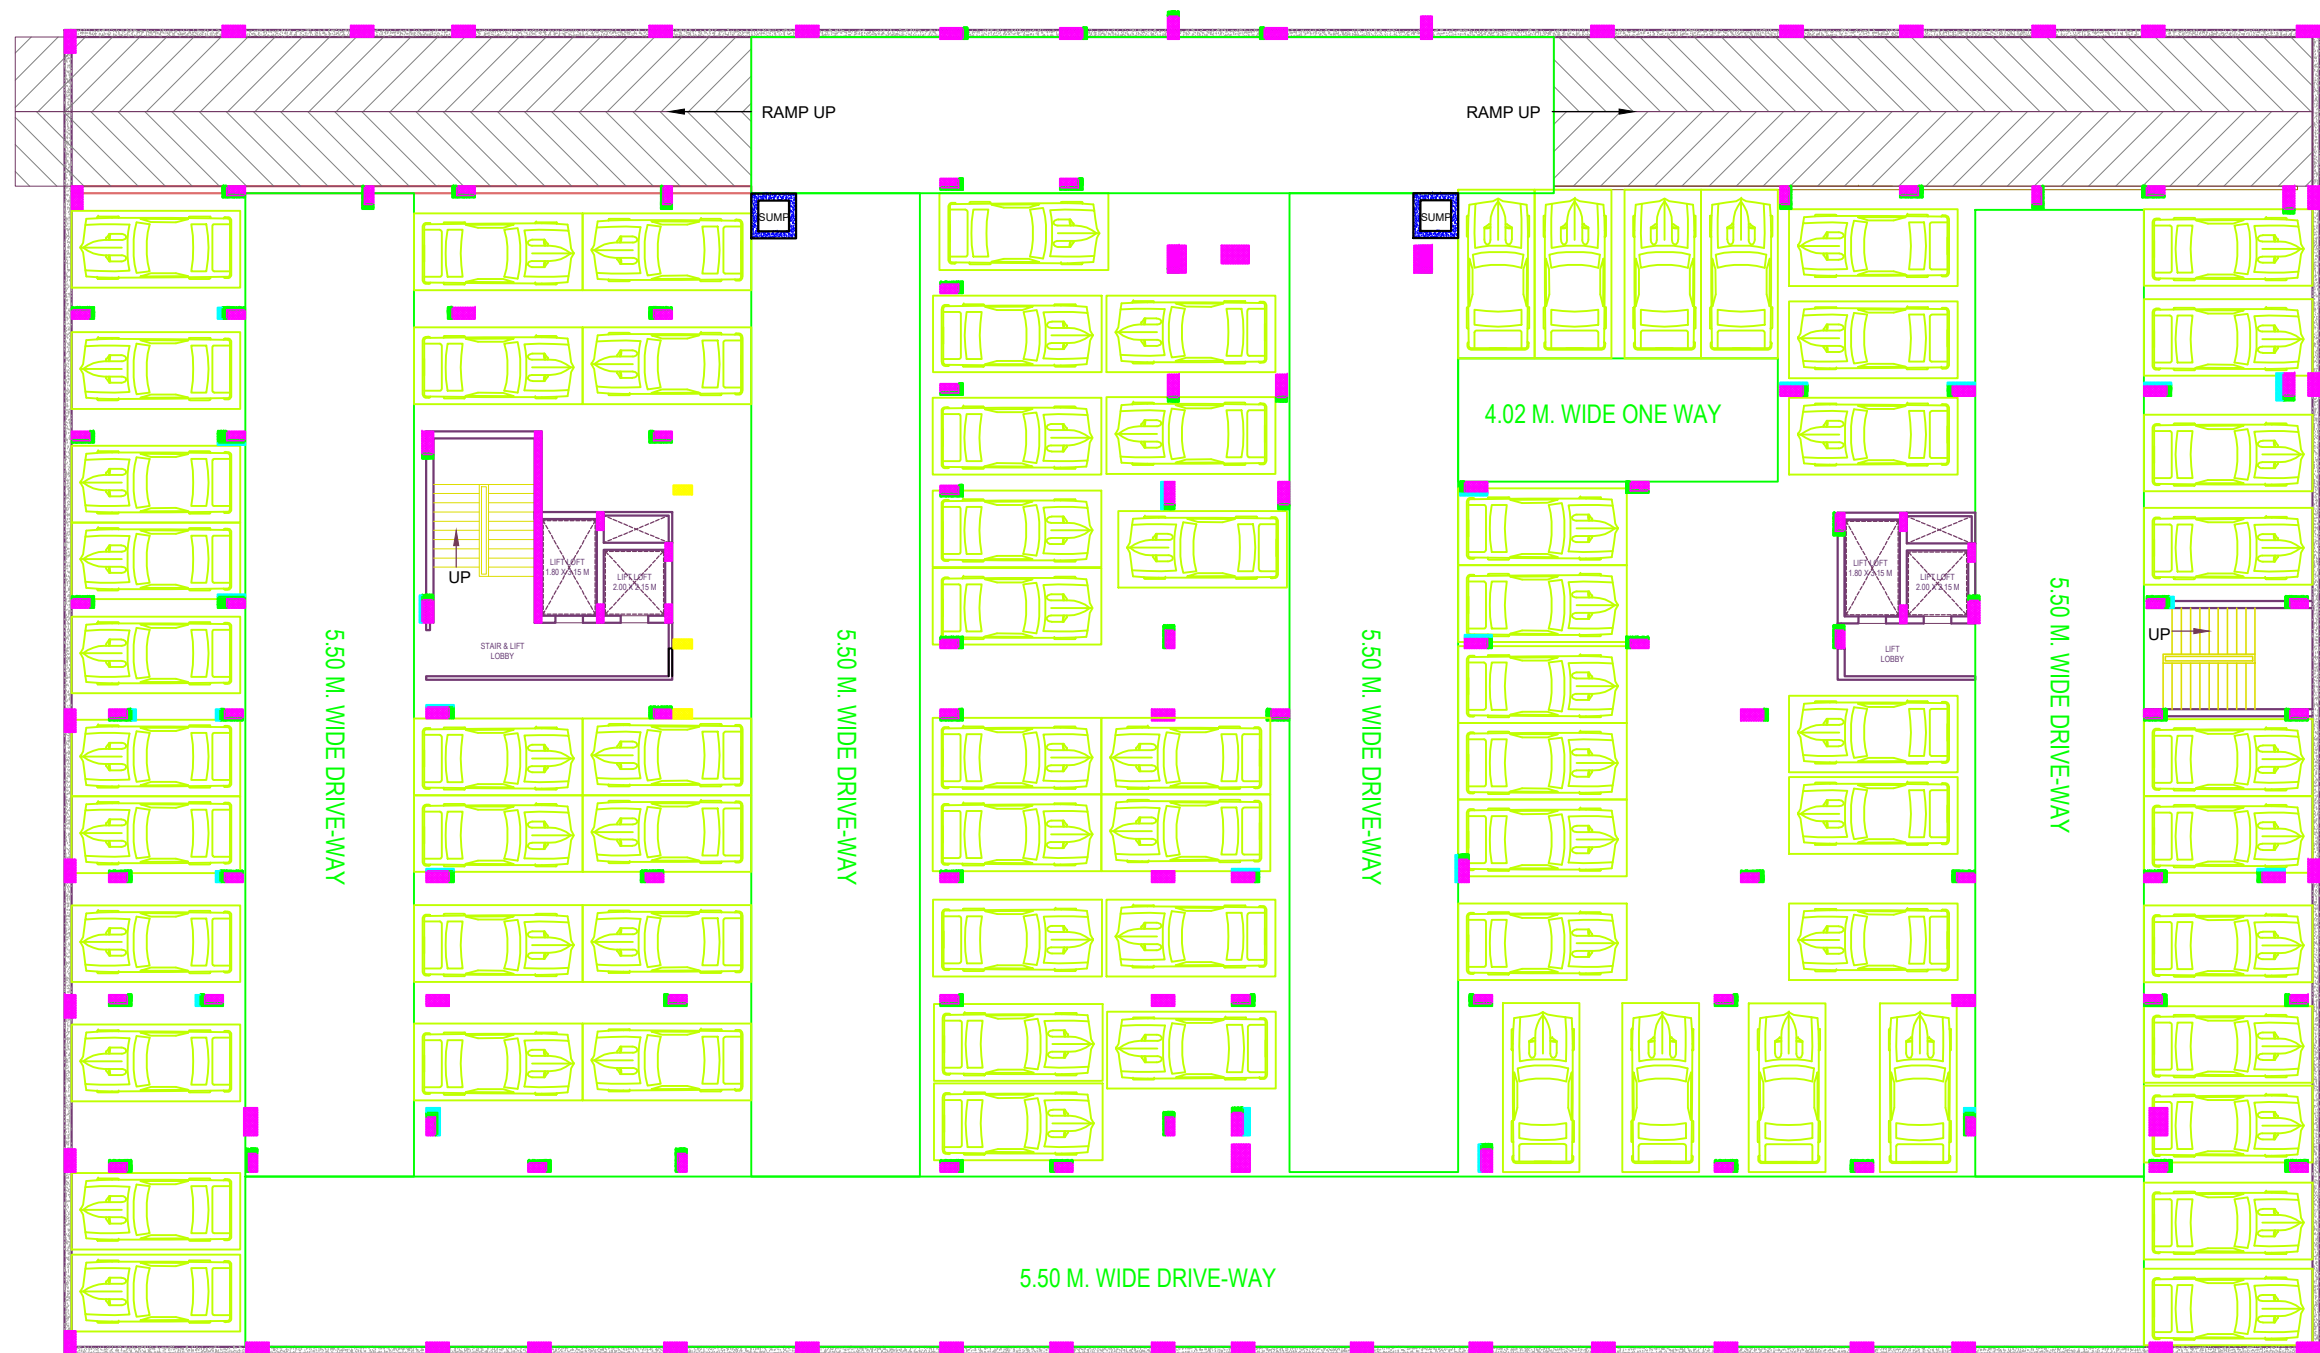

PROJECT

RAJENDRA PRASAD SINGH, SURENDRA NARAYAN SINGH,
SHIV KUMAR SINGH, NISHA DEVI, DEEPAK SINGH,
GIRISH KUMARI, PRAMOD KUMAR RAI,
LOVKUSH SINGH, AWADH BUILDCON THROUGH
DIRECTOR SUSHIL KUMAR RAI



DRAWING TITLE
BASEMENT FLOOR
(PLUMBING LAYOUT)

DRAWING STATUS

DATE RIV 20-05-2025

SHEET NO. 01

DRAWN BY
RAHUL


CHECKED BY

ARCHITECT
AR. AJAY SINGH



DESIGN CENTRE
ESTABLISHED - 1996
MAKE IDEAS HAPPEN
ARCHITECTURE | PROJECT MANAGEMENT | INTERIORS | ENGINEER

WEB :- www.designcentreind.in
E-MAIL :- ajaysingh@designcentreind.in
S, 10/8-3K, P, Maqbool Alam Rd, Khajuri Colony,
Varanasi - 221002
PHONE - 9628932134

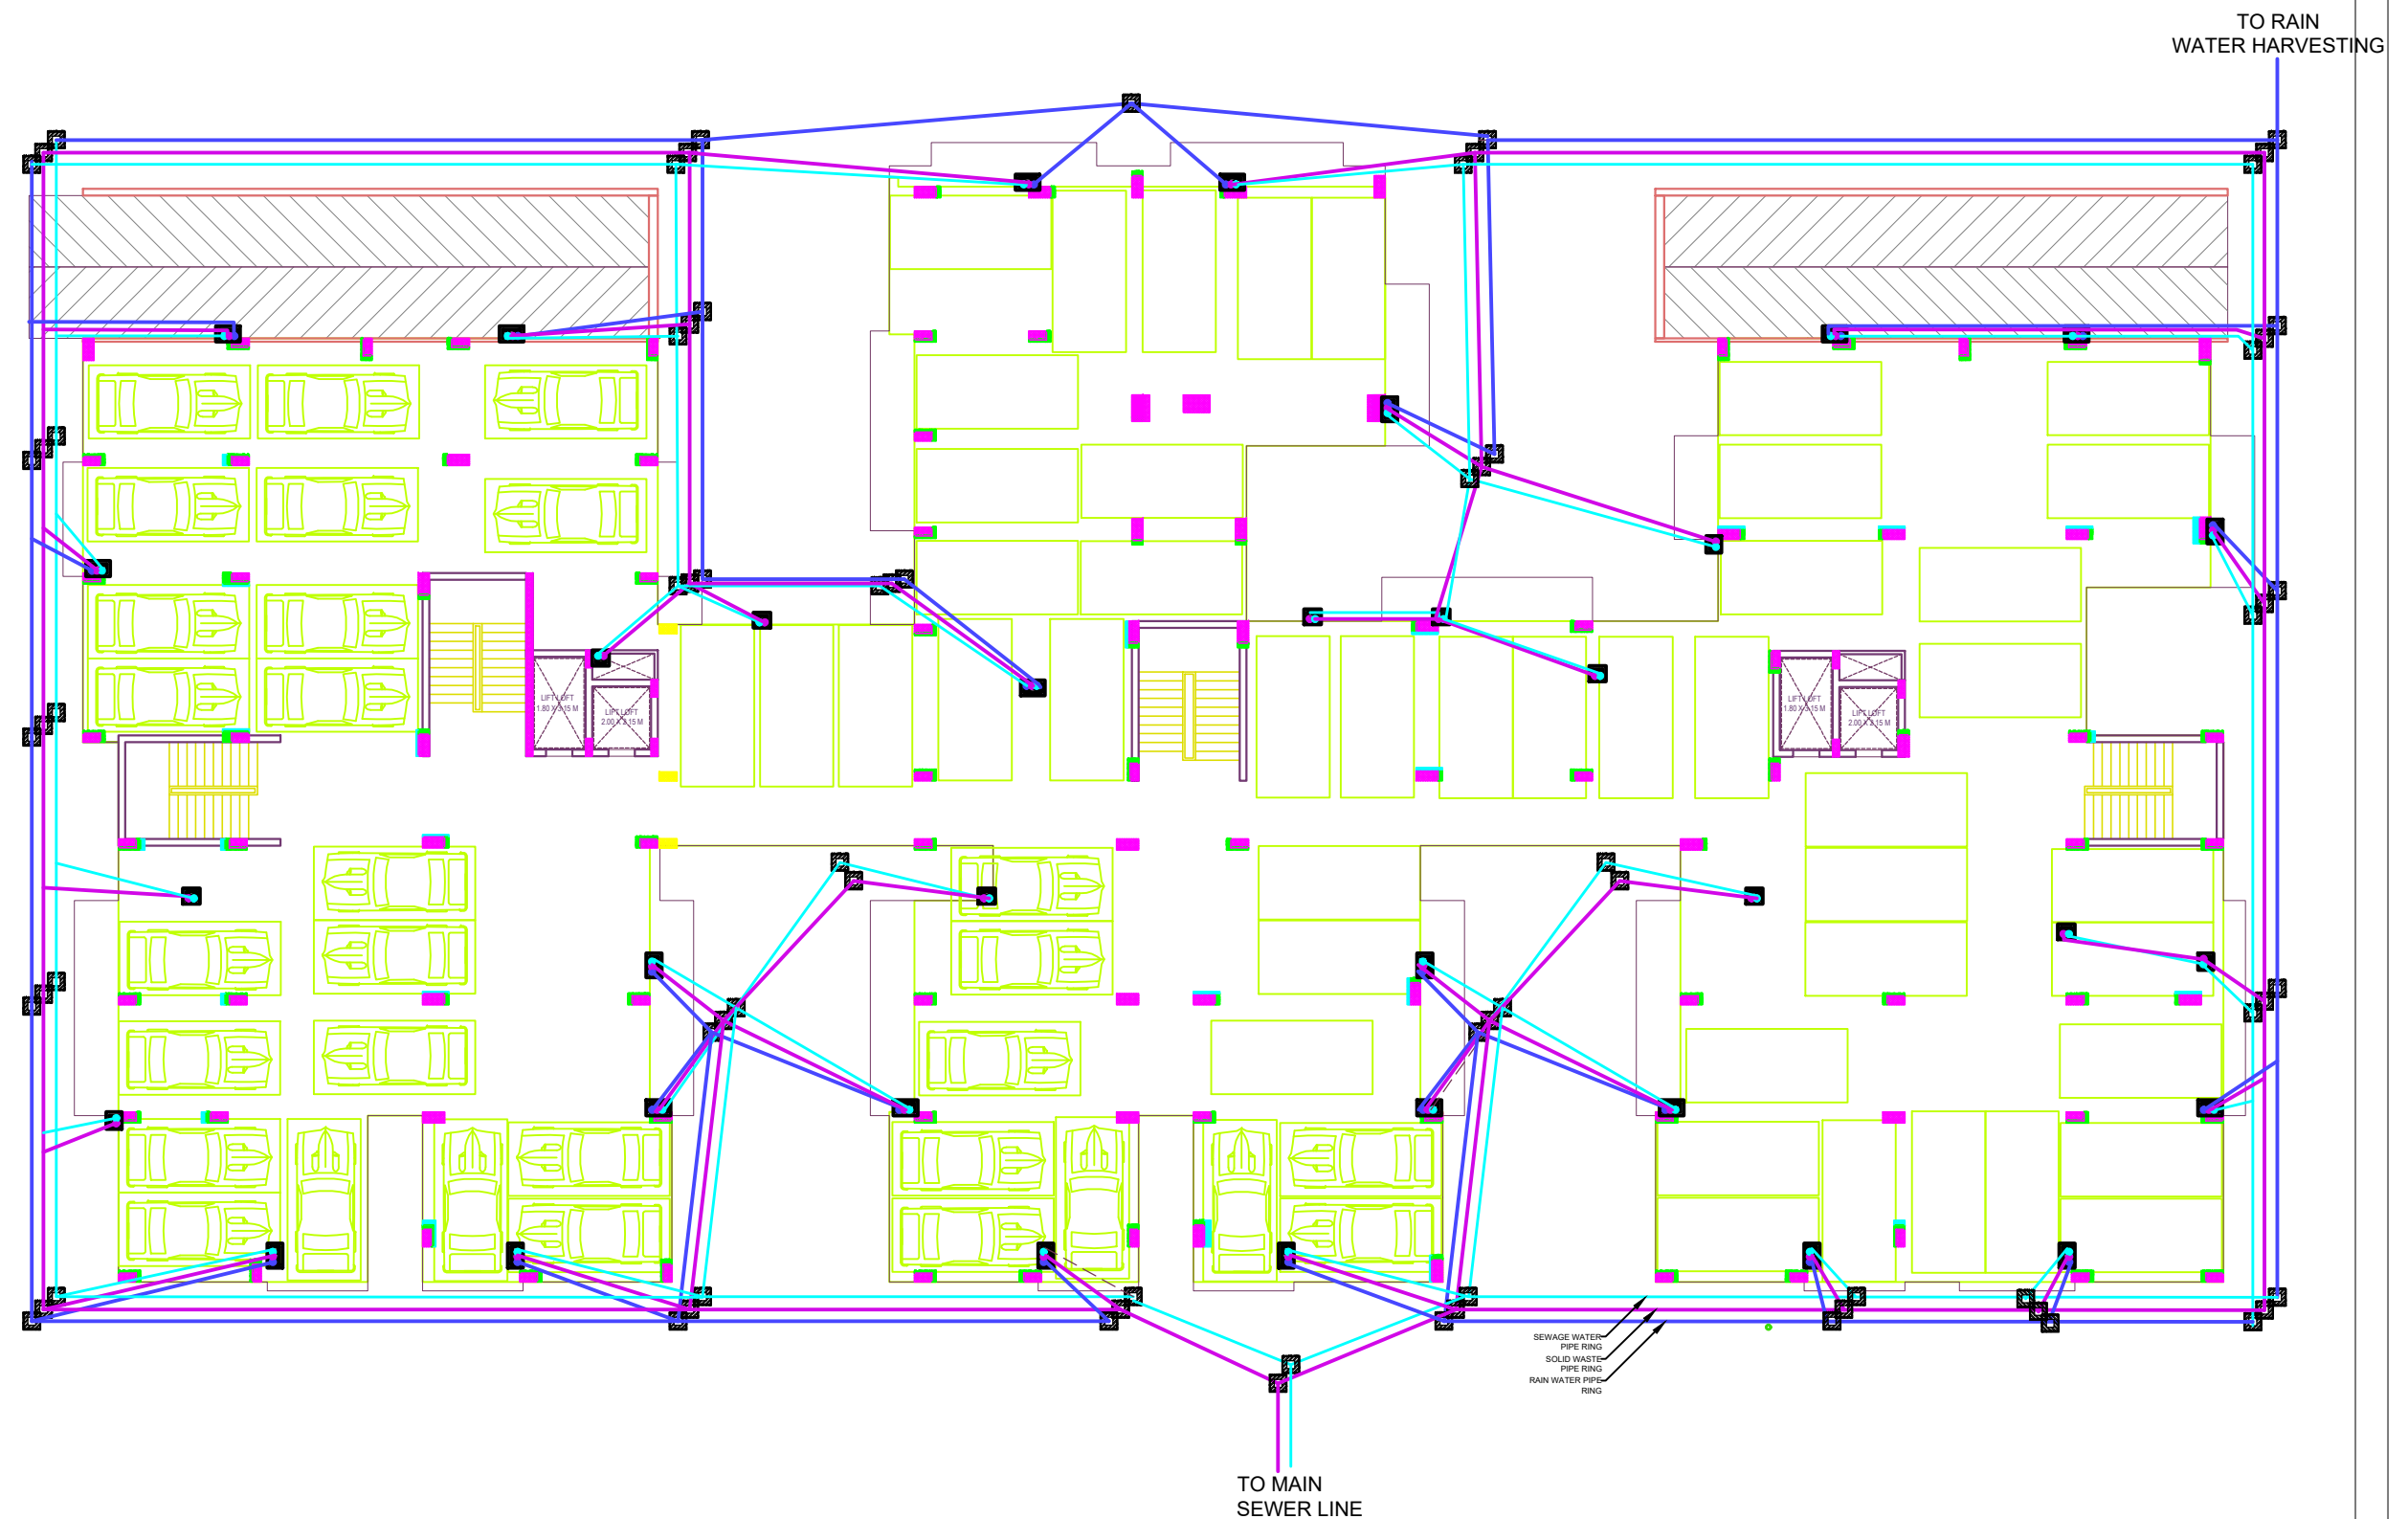

PROJECT

RAJENDRA PRASAD SINGH, SURENDRA NARAYAN SINGH,
SHIV KUMAR SINGH, NISHA DEVI, DEEPAK SINGH,
GIRISH KUMARI, PRAMOD KUMAR RAI,
LOVKUSH SINGH, AWADH BUILDCON THROUGH
DIRECTOR SUSHIL KUMAR RAI



DRAWING TITLE

STILT FLOOR
(PLUMBING LAYOUT)

DRAWING STATUS

DATE RIV 20-05-2025

SHEET NO. 01

DRAWN BY
RAHUL

CHECKED BY

ARCHITECT
AR. AJAY SINGH



DESIGN CENTRE
ESTABLISHED - 1996
MAKE IDEAS HAPPEN

ARCHITECTURE | PROJECT MANAGEMENT | INTERIORS | ENGINEER

WEB :- www.designcentreindia.in

E-MAIL :- ajaysingh@designcentreindia.in
S, 10/8-3K, P, Maqbool Alam Rd, Khajuri Colony,
Varanasi - 221002

PHONE - 9628932134



PROJECT

RAJENDRA PRASAD SINGH, SURENDRA NARAYAN SINGH, SHIV KUMAR SINGH, NISHA DEVI, DEEPAK SINGH, GIRISH KUMARI, PRAMOD KUMAR RAI, LOVKUSH SINGH, AWADH BUILDCON THROUGH DIRECTOR SUSHIL KUMAR RAI



DRAWING TITLE
TYPICAL FLOOR
(PLUMBING LAYOUT)
DRAWING STATUS

DATE RIV 20-05-2025
SHEET NO. 01
DRAWN BY RAHUL
CHECKED BY

ARCHITECT
AR. AJAY SINGH



DESIGN CENTRE
ESTABLISHED - 1996
MAKE IDEAS HAPPEN
ARCHITECTURE | PROJECT MANAGEMENT | INTERIORS | ENGINEER

WEB :- www.designcentreind.in
E-MAIL :- ajaysingh@designcentreind.in
S, 10/8-3K, P, Maqbool Alam Rd, Khajuri Colony,
Varanasi - 221002
PHONE - 9628932134