


ROAD 30.00 MT WD. LVL ± 00




NEW SAMAJWADI PLOT
UNDER CONSTRUCTION

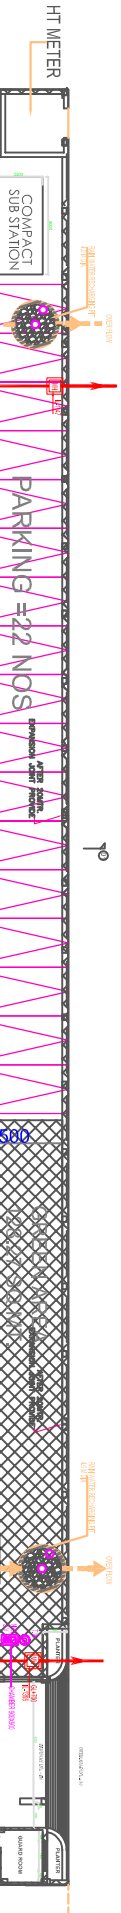

ROAD 24.00 Mts WD.

PLUMBING SITE PLAN

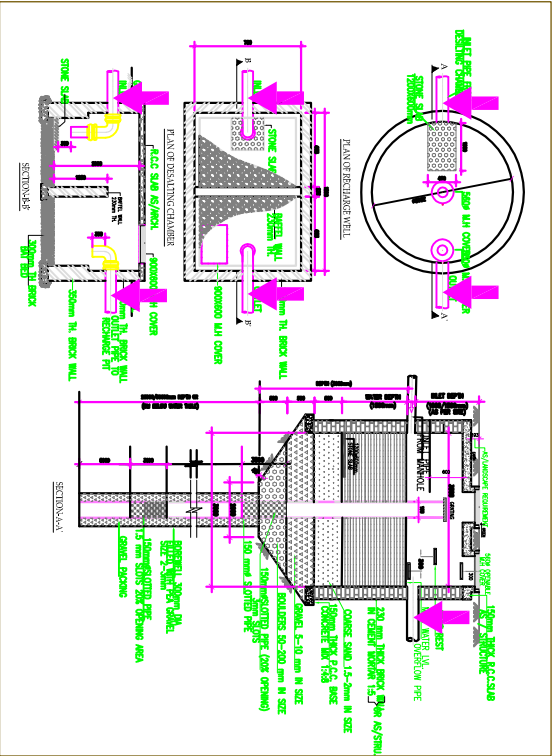

- LEGEND :- SEWER PIPE SLOPE
- 1.... 1500RCC S.W PIPE SLOPE =1:100
 - 2.... 200RCC SEWER PIPE SLOPE =1:150
 - 3.... 250RCC SEWER PIPE SLOPE =1:200
 - 4.... 300RCC SEWER PIPE SLOPE =1:250
- SEWER MANHOLE
- GULLY TRAP

			
ANAND VIHAR RESIDENTIAL SCHEME, HAPUR (BLOCK-H GROUP HOUSING-1)			
DRAWING TITLE			
SERVICE PLAN (L.I.G & E.W.S) WATER SUPPLY SYSTEM (RAIN WATER & WASTE WATER SYSTEM) (SEWORAGE SYSTEM) STROM WATER LINE			
ARCHITECT SIGN		OWNER SIGN	
 <i>Design Studio</i> ANUJ AGARWAL ARCHITECTS OFFICE:- A-244 KAUSHAMBI GHATBHAD (U.P.) Ph:-0720- 6645162 / 64, 4165716, TEL. FAX:- 2773582 E-mail: anujagrawal@gmail.com			
SCALE	DEALT BY	DATE	28.5.17
DESIGN BY	CHECKED BY	DWG. No.	
ARABISH	AR ABISH AGARWAL		