


LEGEND	
SYMBOL	DESCRIPTION
	SCHREDER MAKE Z-1 TYPE FIXTURE WITH 150W METAL HALIDE LAMP ON 7 METRE HIGH POLE.
	4M HIGH CONICAL(TUBULAR) POST TOP LANTERN WITH 39W LED LIGHT FICTURE.
	ELECTRICAL SUBSTATION
	FEEDER PILLAR
	ELECTRICAL CABLE

LEGENDS

LT LINE

HT LINE

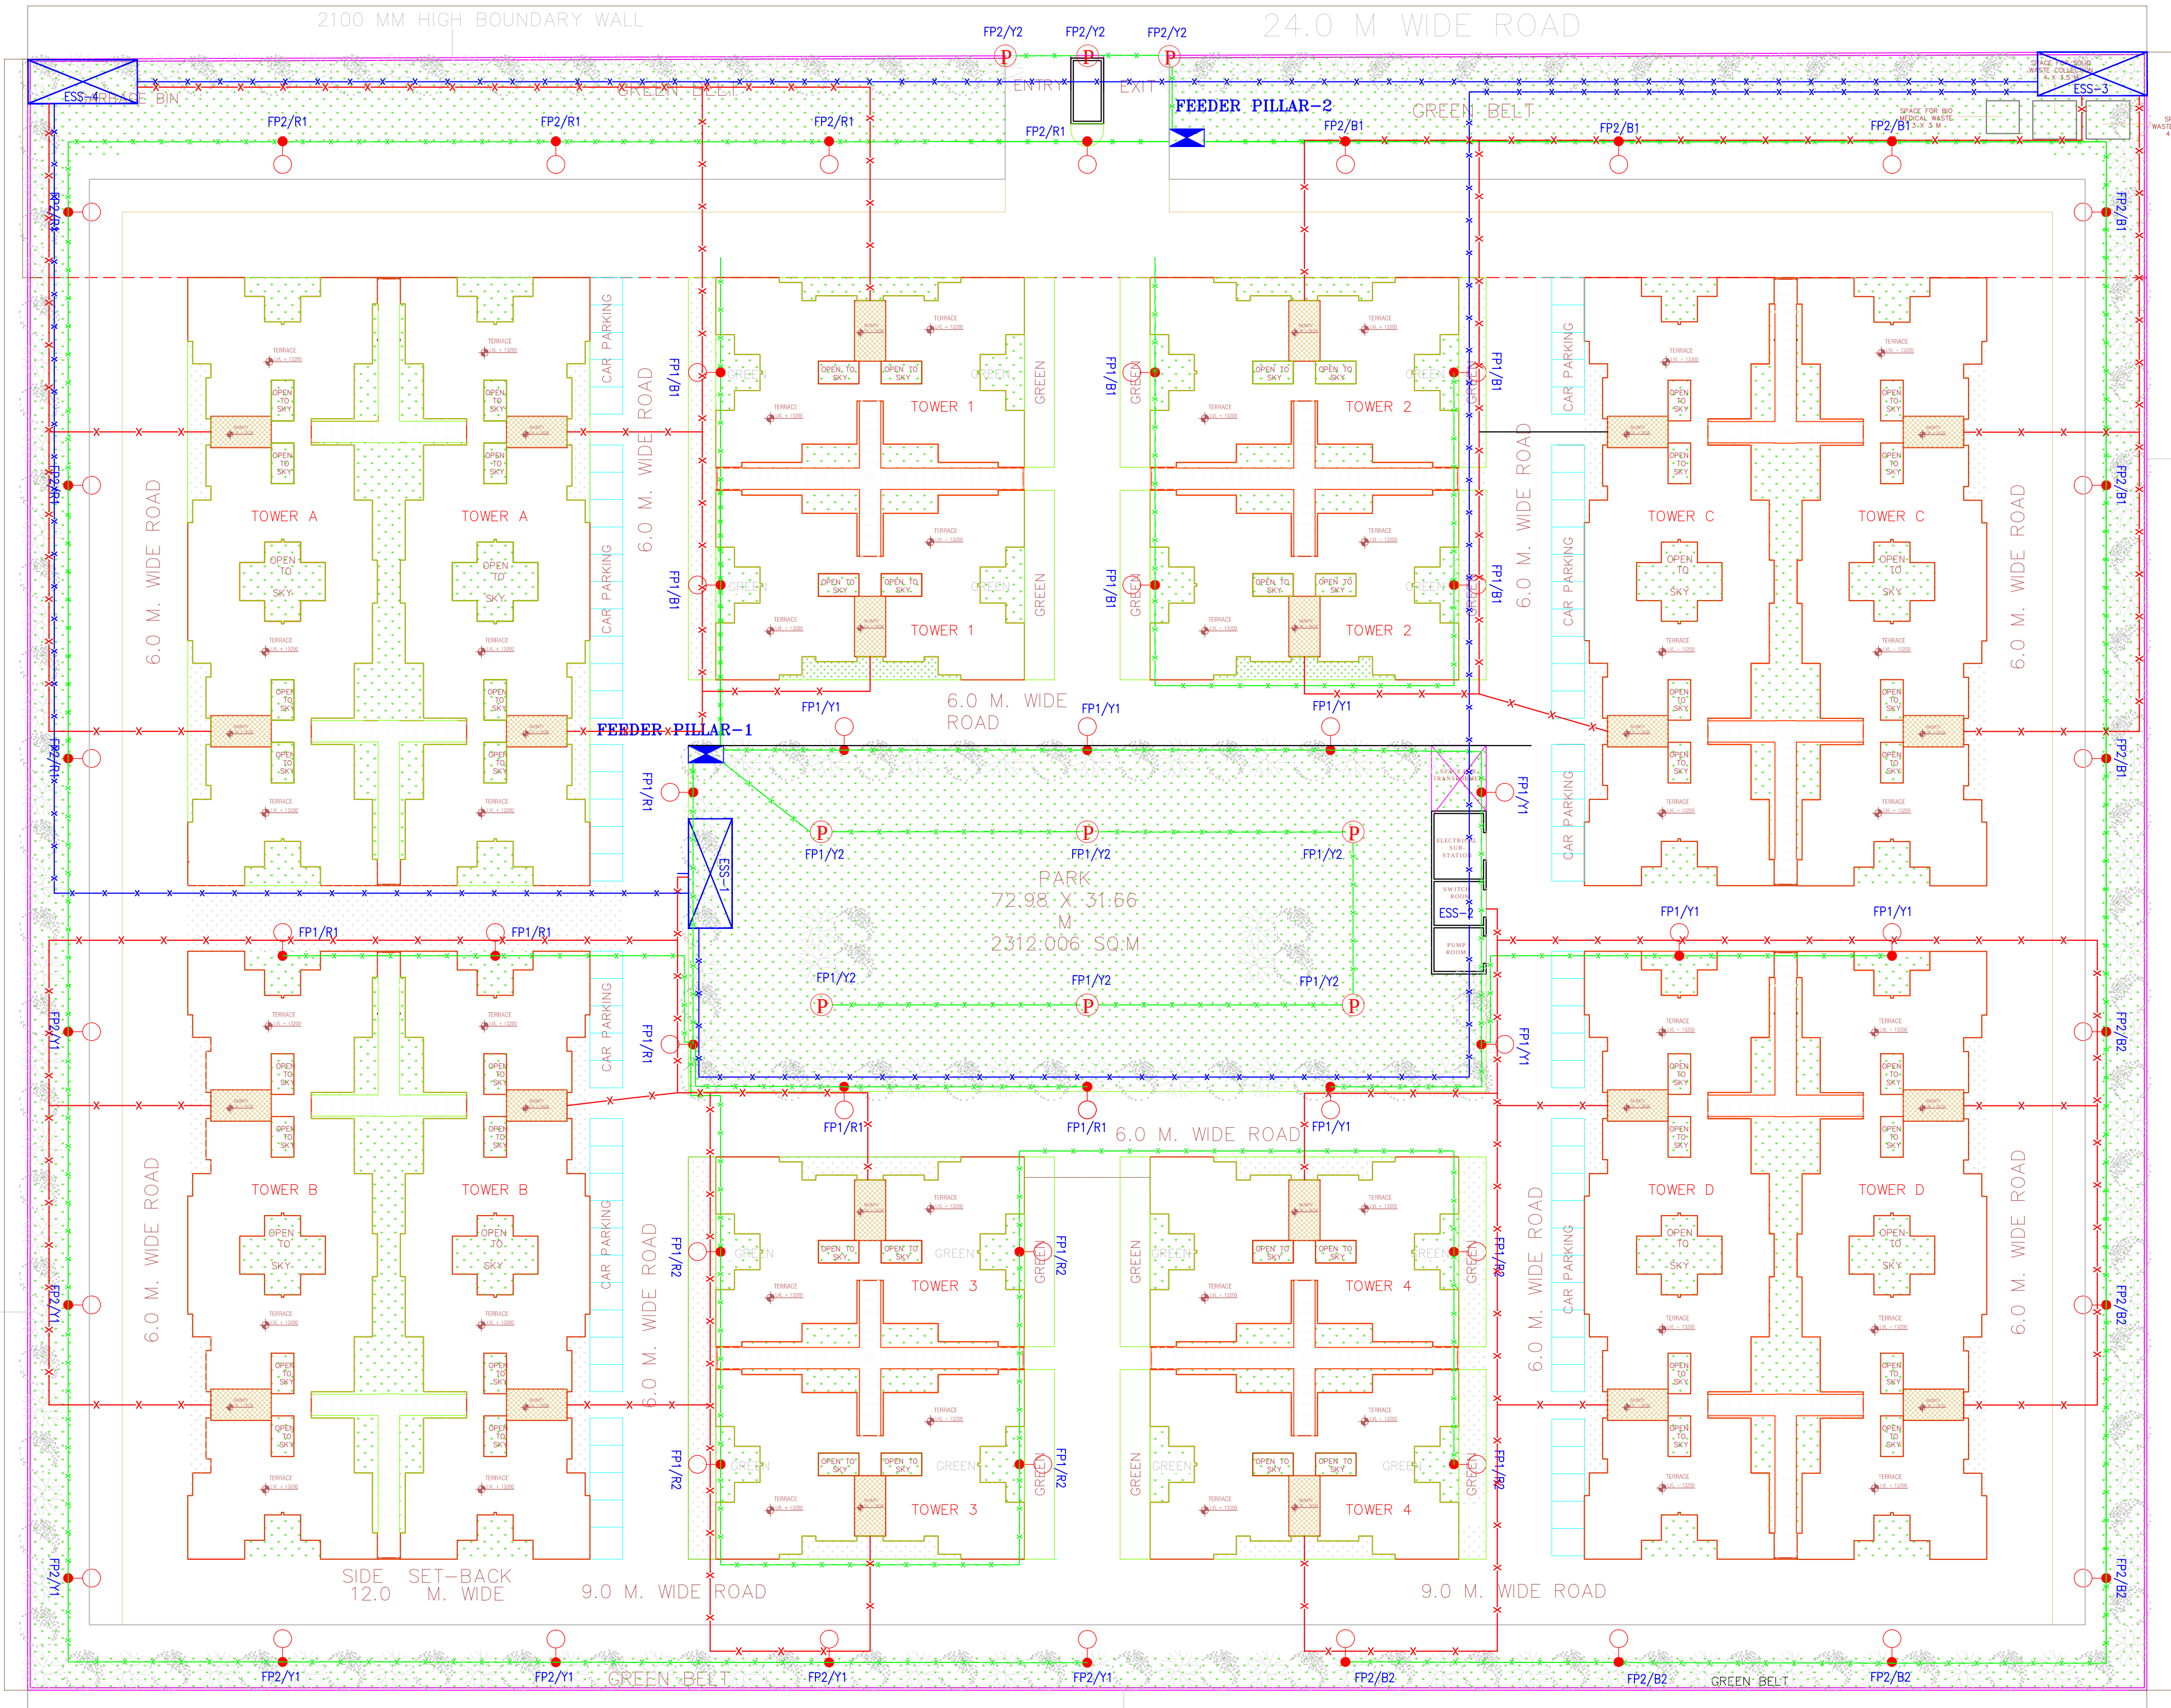

SITE PLAN

NO.	DESCRIPTION	DATE
NATURE OF DWG.		
SANCTION DWG.		
PROJECT :		
GROUP HOUSING GH-01A\1		
ETA-2		
GREATER NOIDA		
CLIENT :		
		
G.M. PLANNING AND ARCHITECTURE, GREATER NOIDA INDUSTRIAL DEVELOPMENT AUTHORITY		
H-169,CHITWAN ESTATE,SECTOR - GAMMA, GREATER NOIDA CITY - 201308		
DISTT. GAUTAM BUDH NAGAR (U.P.) INDIA		
ARCHITECT :		
DEXTEROUS DESIGNERS & ASSOCIATES		
		
architects, interior designers & urban planners		
f-10/d-2, krishna apra royal plaza alpha commercial belt, alpha-1, greater noida.		
DRG. NO		
ESC/GH-01A/1/ETA-II/E-01		
OWNER		ARCHITECT
TITLE :-		REV NO.
EXTERNAL LIGHTING & SUBSTATION LOCATION SITE PLAN (PLOT NO GH-02)		R-0.
DATE:	25.02.2016	NORTH :
SCALE:	1:500	
DEALT BY:	VIRENDER	
CHECKED BY:	DHINGRA	