



STRL CONSULTANTS:-

PROPOSED HOUSING OF
PARK SQUARE
AT LUCKNOW

DESCRIPTION

DRAWING TITLE

WATER SUPPLY

JOB TITLE

GROUND FLOOR PLAN

CLIENT NAME:
MR. JASWANI

SCALE: N.T.S. DATE:

DRAWN BY:- CKD BY:-

REVISION DATE:- NORTH

SHEET NO.-

W E S N

STRL CONSULTANTS:-

AE ANPEE-TECH ENGINEERS
CIVIL & STRUCTURAL CONSULTANTS
INDRAPRASTH APPT (G. FLOOR)
111/7 HARSH NAGAR KANPUR
MOB :- 9415039584, 9335036545

MEP CONSULTANTS:-


TRIVENI CONSULTING ENGINEERS
14/34 YAMAN SAHARA ESTATE,
JANKIPURAM, 226011,
(LUCKNOW)
PH :- 0522 - 4333761
mail us at:-triveniconsultants.lko@gmail.com

CTE


Firm Name

VASTU SRAJAN
OMAXE HEIGHTS, CARLTON T 2, GF 001,
VIBHUTI KHAND, GOMTI NAGAR,
LUCKNOW-226010.
ph- 8799419194 ,0522 4103370
e-mail- vastu.srajan@gmail.com
www.vastusrajan.com

W

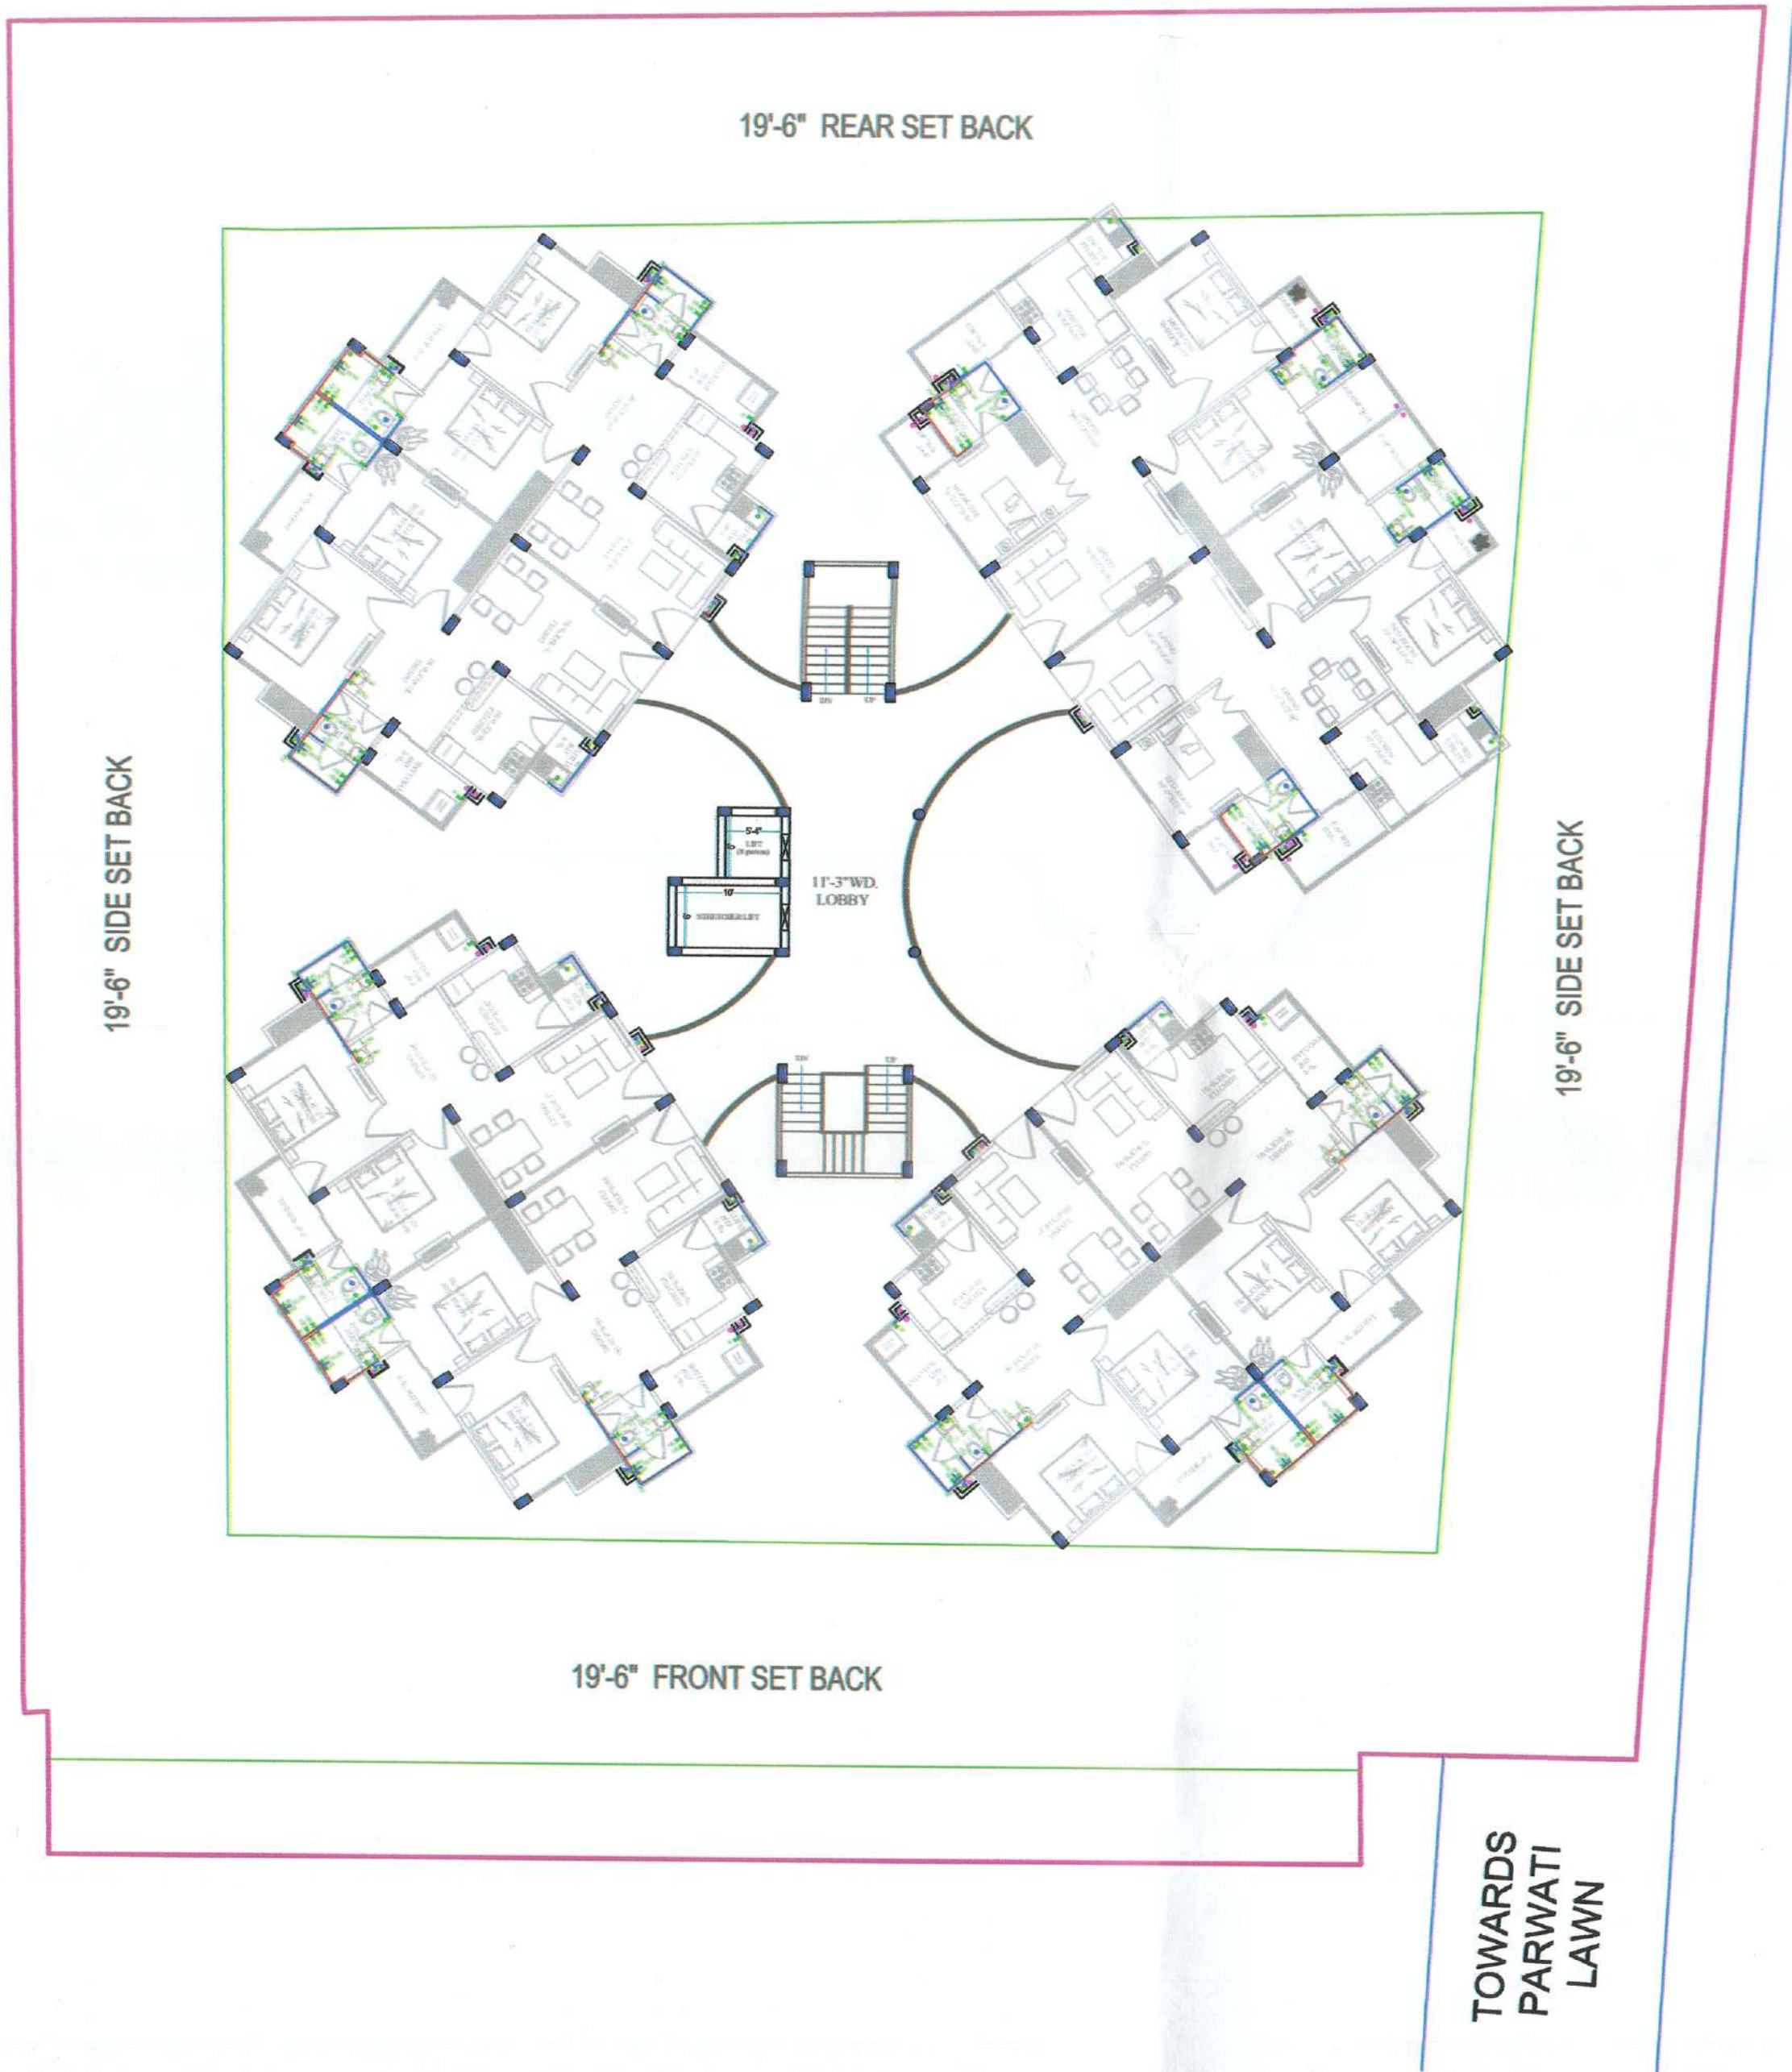

STRL CONSULTANTS:-	
PROPOSED HOUSING AT LUCKNOW	
DESCRIPTION	
DRAWING TITLE WATER SUPPLY	
JOB TITLE TYPICAL FLOOR PLAN	
CLIENT NAME: MR. JASWANI	
SCALE N.T.S.	DATE
DRAWN BY:-	CKD BY:-
REVISION DATE:-	NORTH
SHEET NO.-	
STRL CONSULTANTS:- AE ANPEE-TECH ENGINEERS CIVIL & STRUCTURAL CONSULTANTS INDRAPRASTH APPT (G. FLOOR) 111/7 HARSH NAGAR KANPUR MOB :- 9415039584, 9335036545	
MEP CONSULTANTS:- TRIVENI CONSULTING ENGINEERS 14/34 YAMAN SAHARA ESTATE, JANKIPURAM, 226021, (LUCKNOW) PH :- 0522 - 4333761 mail us at: triveniconsultants.fo@gmail.com	
Firm Name VASTU SRAJAN OMAKE HEIGHTS, CARLTON T 2, CF 001, VIBHUTI KHAND, GOMTI NAGAR, LUCKNOW-226010. ph- 8799419194 ,0522 4103370 e-mail- vastu.srajan@gmail.com www.vastusrajan.com	

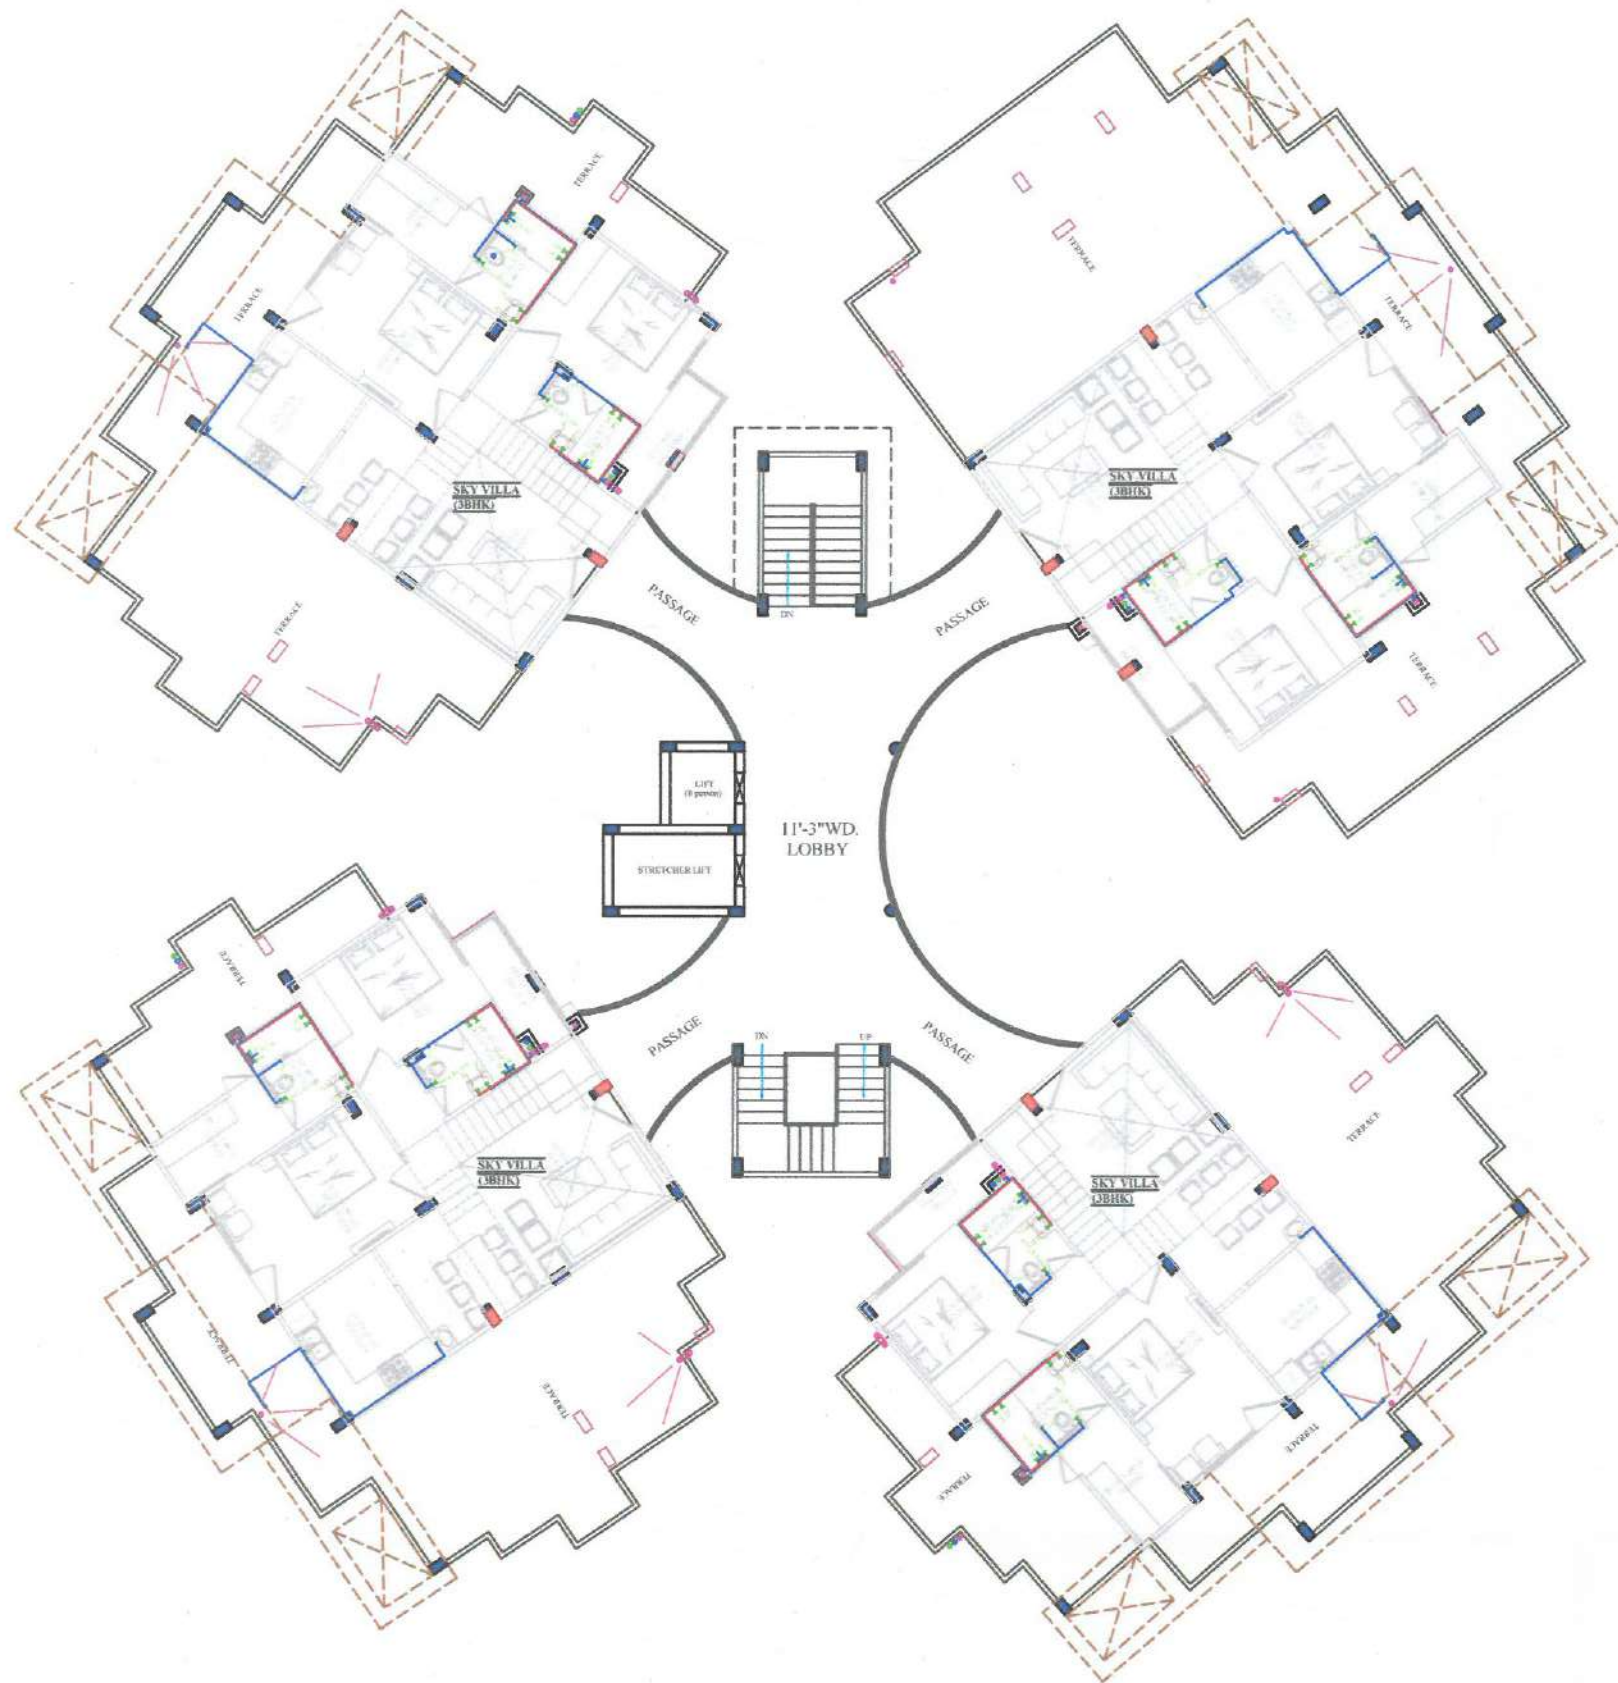

- EXISTING COLUMN
- CHANGED COLUMN SIZE FROM SIXTH FLOOR

STRL CONSULTANTS:-

PROPOSED HOUSING AT LUCKNOW

DESCRIPTION

DRAWING TITLE

WATER SUPPLY

JOB TITLE

SIXTH FLOOR PLAN

CLIENT NAME:	
MR. JASWANI	
SCALE	DATE
N.T.S.	
DRAWN BY:-	CKD BY:-
REVISION DATE:-	NORTH
SHEET NO:-	

STRL CONSULTANTS:-


ANPEE-TECH ENGINEERS
CIVIL & STRUCTURAL CONSULTANTS
INDRAPRASTH APPT (G. FLOOR)
111/7 HARSH NAGAR KANPUR
MOB :- 9415039584, 9335036545

MEP CONSULTANTS:-

TRIVENI CONSULTING ENGINEERS
14/34 YAMAN SAHARA ESTATE,
JANKIPURAM, 226021,
(LUCKNOW)
PH :- 8522 - 433761
mail us at:-triveniconsultants.iko@gmail.com

Firm Name

VASTU SRAJAN
OMAXE HEIGHTS, CARLTON T 2, GF 001,
VIBHUTI KHAND, GOMTI NAGAR,
LUCKNOW-226010.
ph- 8799419194 ,0522 4183370
e-mail- vastu.srajan@gmail.com
www.vastusrajan.com

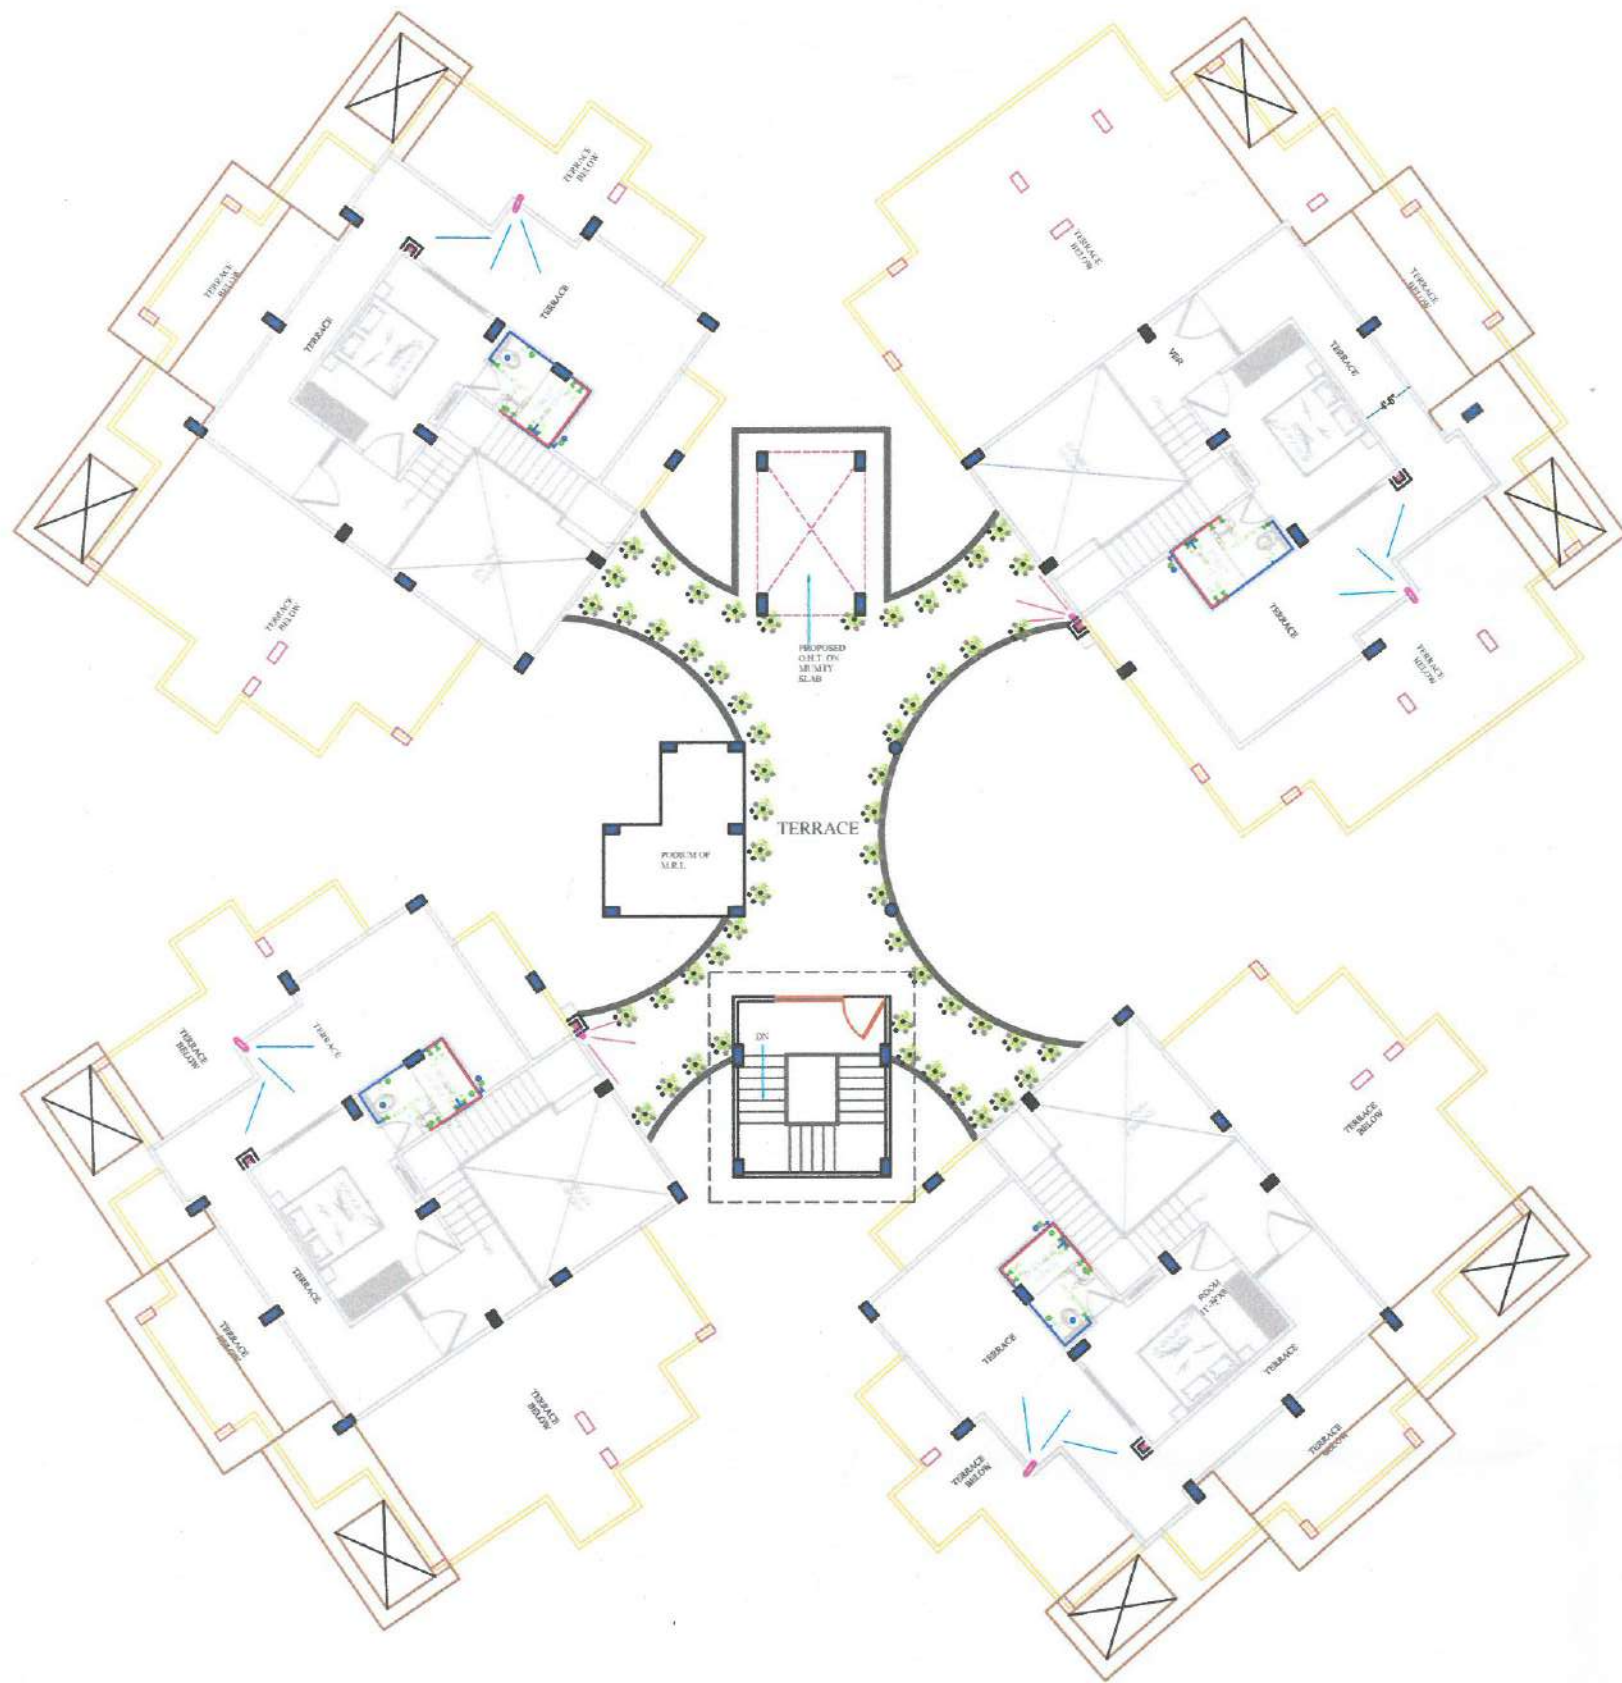

STR. CONSULTANTS:-

PROPOSED HOUSING AT LUCKNOW

DESCRIPTION

DRAWING TITLE

WATER SUPPLY

JOB TITLE

SEVENTH FLOOR PLAN

CLIENT NAME:

MR. JASWANT

SCALE

N.T.S.

DATE

DRAWN BY:-

CKD BY:-

REVISION DATE:-

NORTH

SHEET NO.:-



STR. CONSULTANTS:-



ANPEE-TECH ENGINEERS
CIVIL & STRUCTURAL CONSULTANTS
INDRAPRASTH APPT (G. FLOOR)
111/7 HARSH NAGAR KANPUR
MOB :- 9415039584, 935030545

MEP CONSULTANTS:-

TRIVENI CONSULTING ENGINEERS

14/34 YAMAN SAHARA ESTATE,
JANKIPURAM, 226021,
(LUCKNOW)
PH :- 0522 - 4333761

mail us at:- triveniconsultants.lko@gmail.com




Firm Name

VASTU SRAJAN

OMAXE HEIGHTS, CARLTON T 2, GF 001,
VIBHUTI KHAND, GOMTI NAGAR,
LUCKNOW-226010.

ph- 8799419194 ,0522 4103370
e-mail- vastu.srajan@gmail.com
www.vastusrajan.com



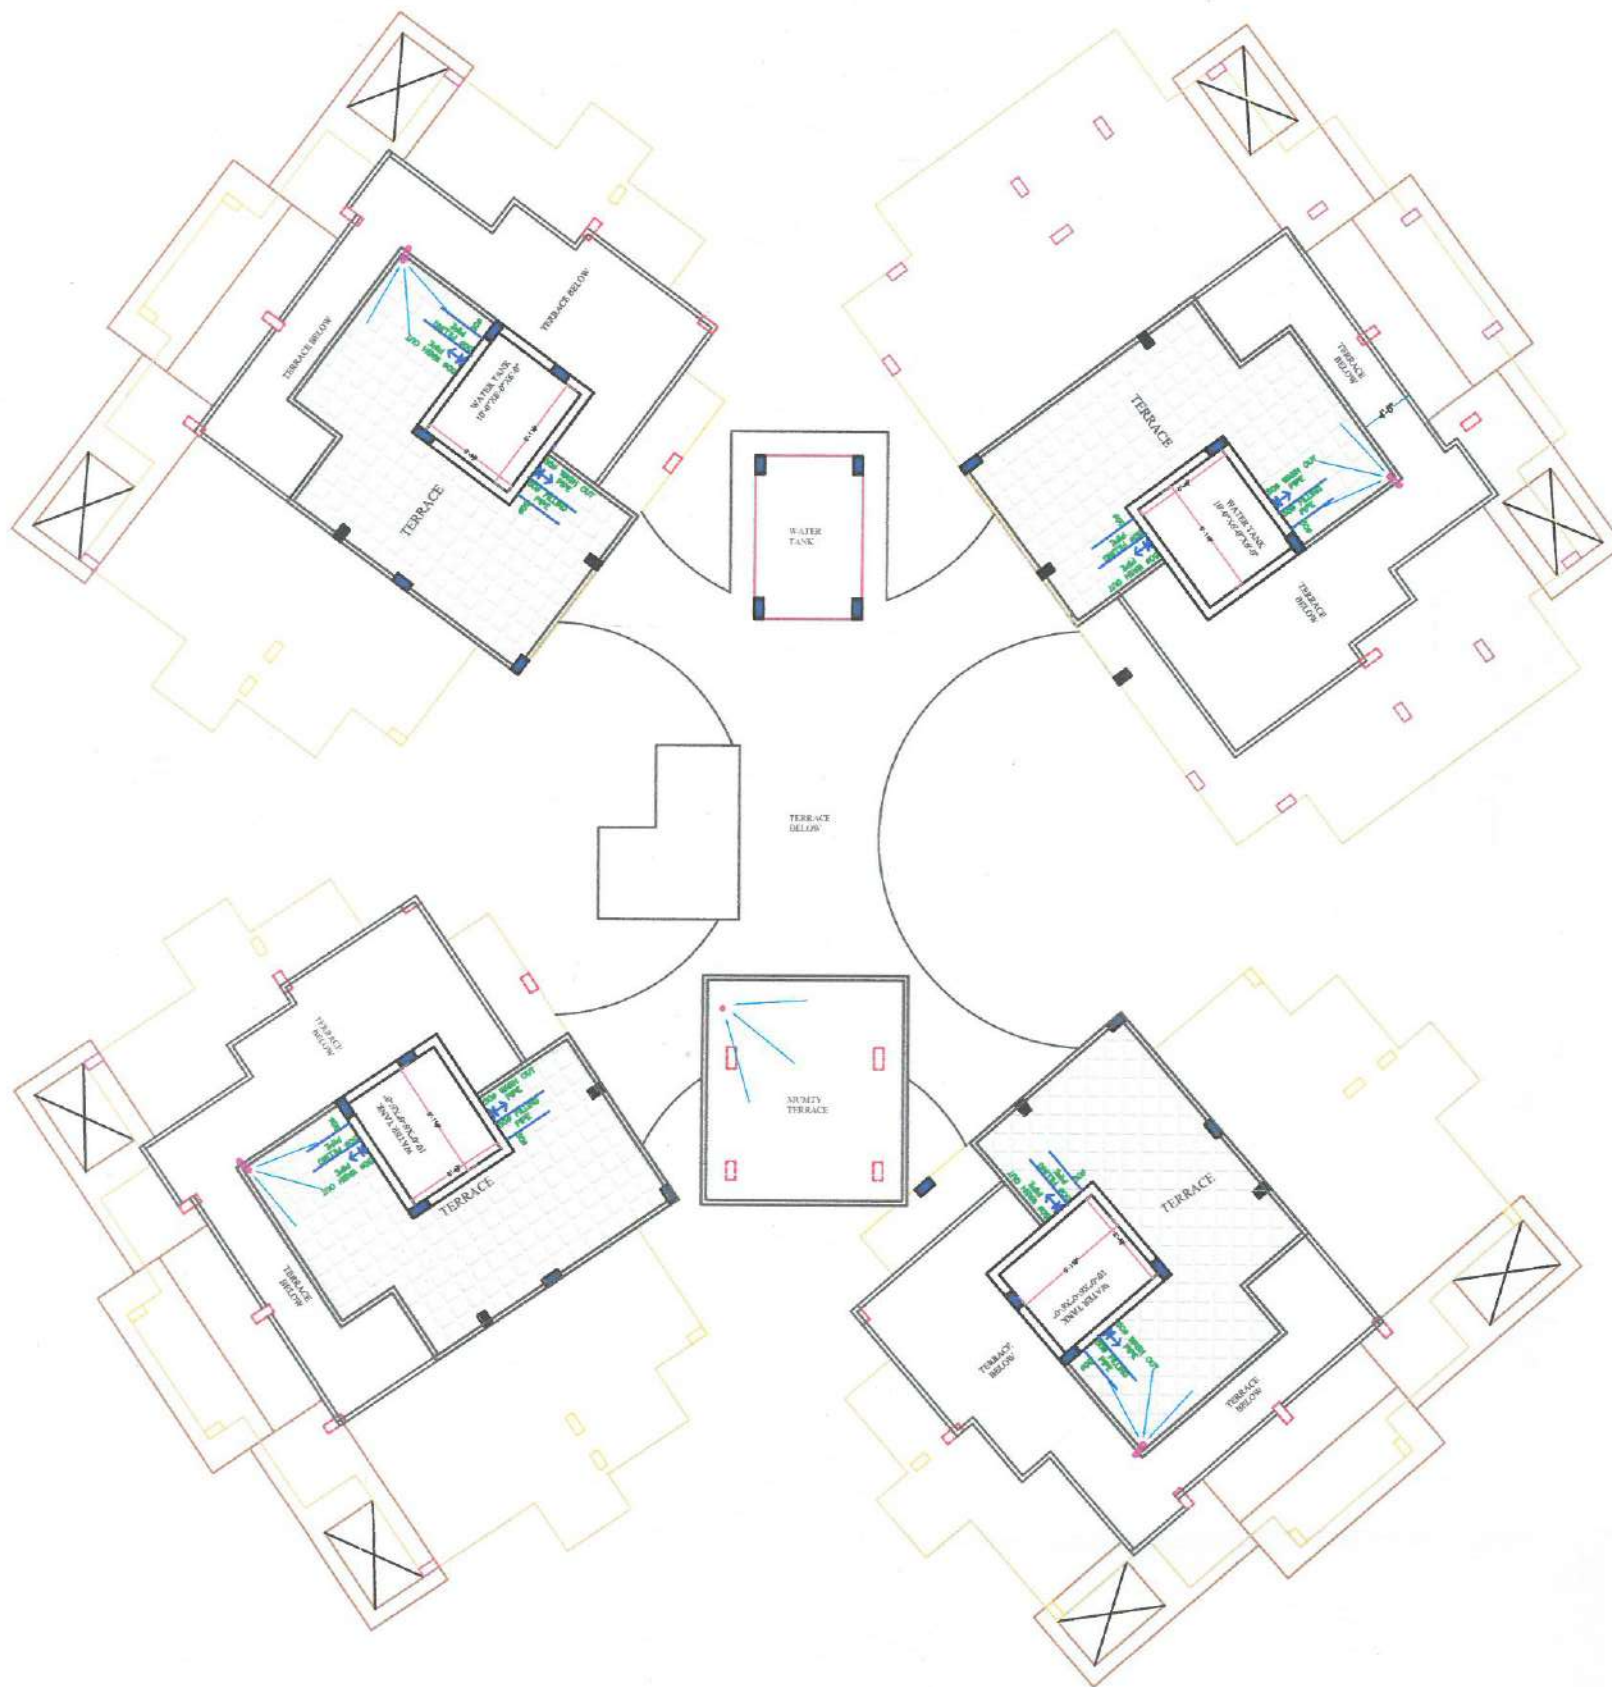

STR. CONSULTANTS:-

PROPOSED HOUSING AT LUCKNOW

DESCRIPTION

DRAWING TITLE

WATER SUPPLY

JOB TITLE

TERRACE PLAN

CLIENT NAME:

MR. JASWANI

SCALE

N.T.S.

DATE

DRAWN BY:-

CKD BY:-

REVISION DATE:-

NORTH

SHEET NO.:-



STR. CONSULTANTS:-



ANPEE-TECH ENGINEERS
CIVIL & STRUCTURAL CONSULTANTS
INDRAPRASTH APPT (G. FLOOR)
111/7 HARSH NAGAR KANPUR
MOB :- 9415039584, 9335036545

MEP CONSULTANTS:-

TRIVENI CONSULTING ENGINEERS

14/34 YAMAN SAHARA ESTATE,
JANKIPURAM, 226021,
(LUCKNOW)
PH :- 0522 - 4333761

mail us at: triveniconsultants.lko@gmail.com




Firm Name

VASTU SRAJAN


OMAXE HEIGHTS, CARLTON T 2, GF 001,
VIBHUTI KHAND, GOMTI NAGAR,
LUCKNOW-226010.

ph- 8799419194 ,0522 4103370
e-mail- vastu.srajan@gmail.com
www.vastusrajan.com



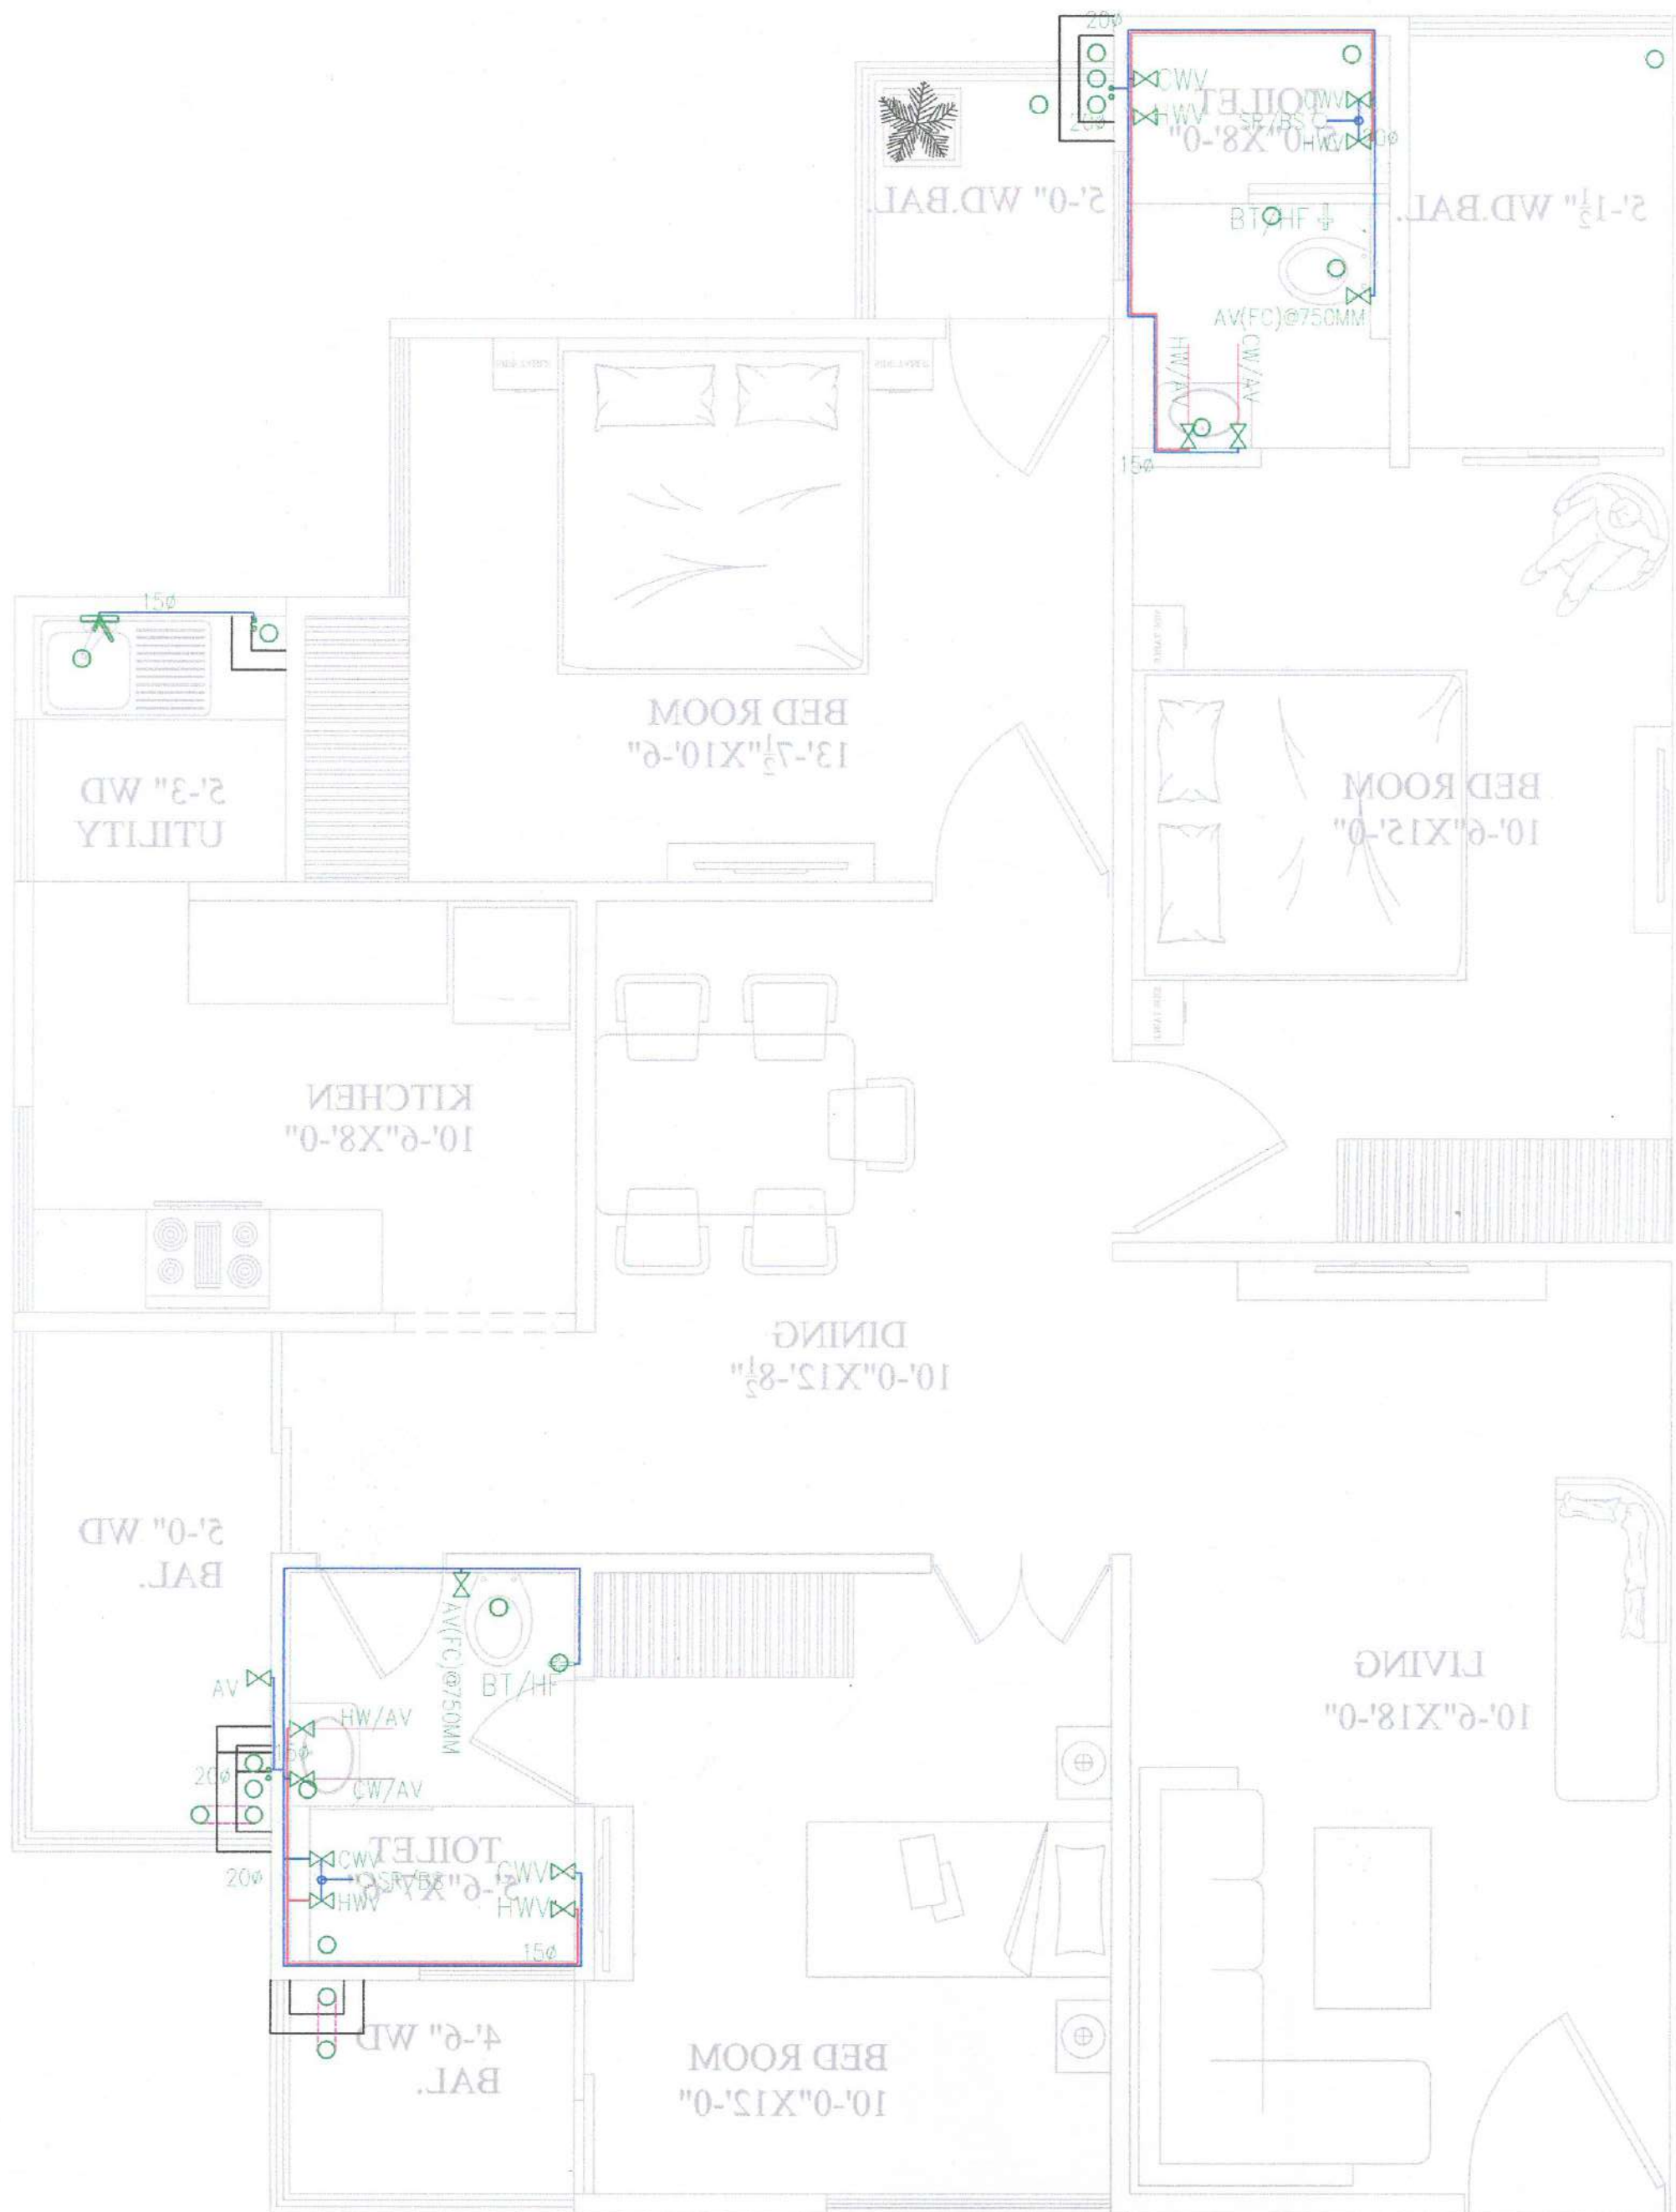

BLOW UP PLAN OF WATER SUPPLY(3BHK)

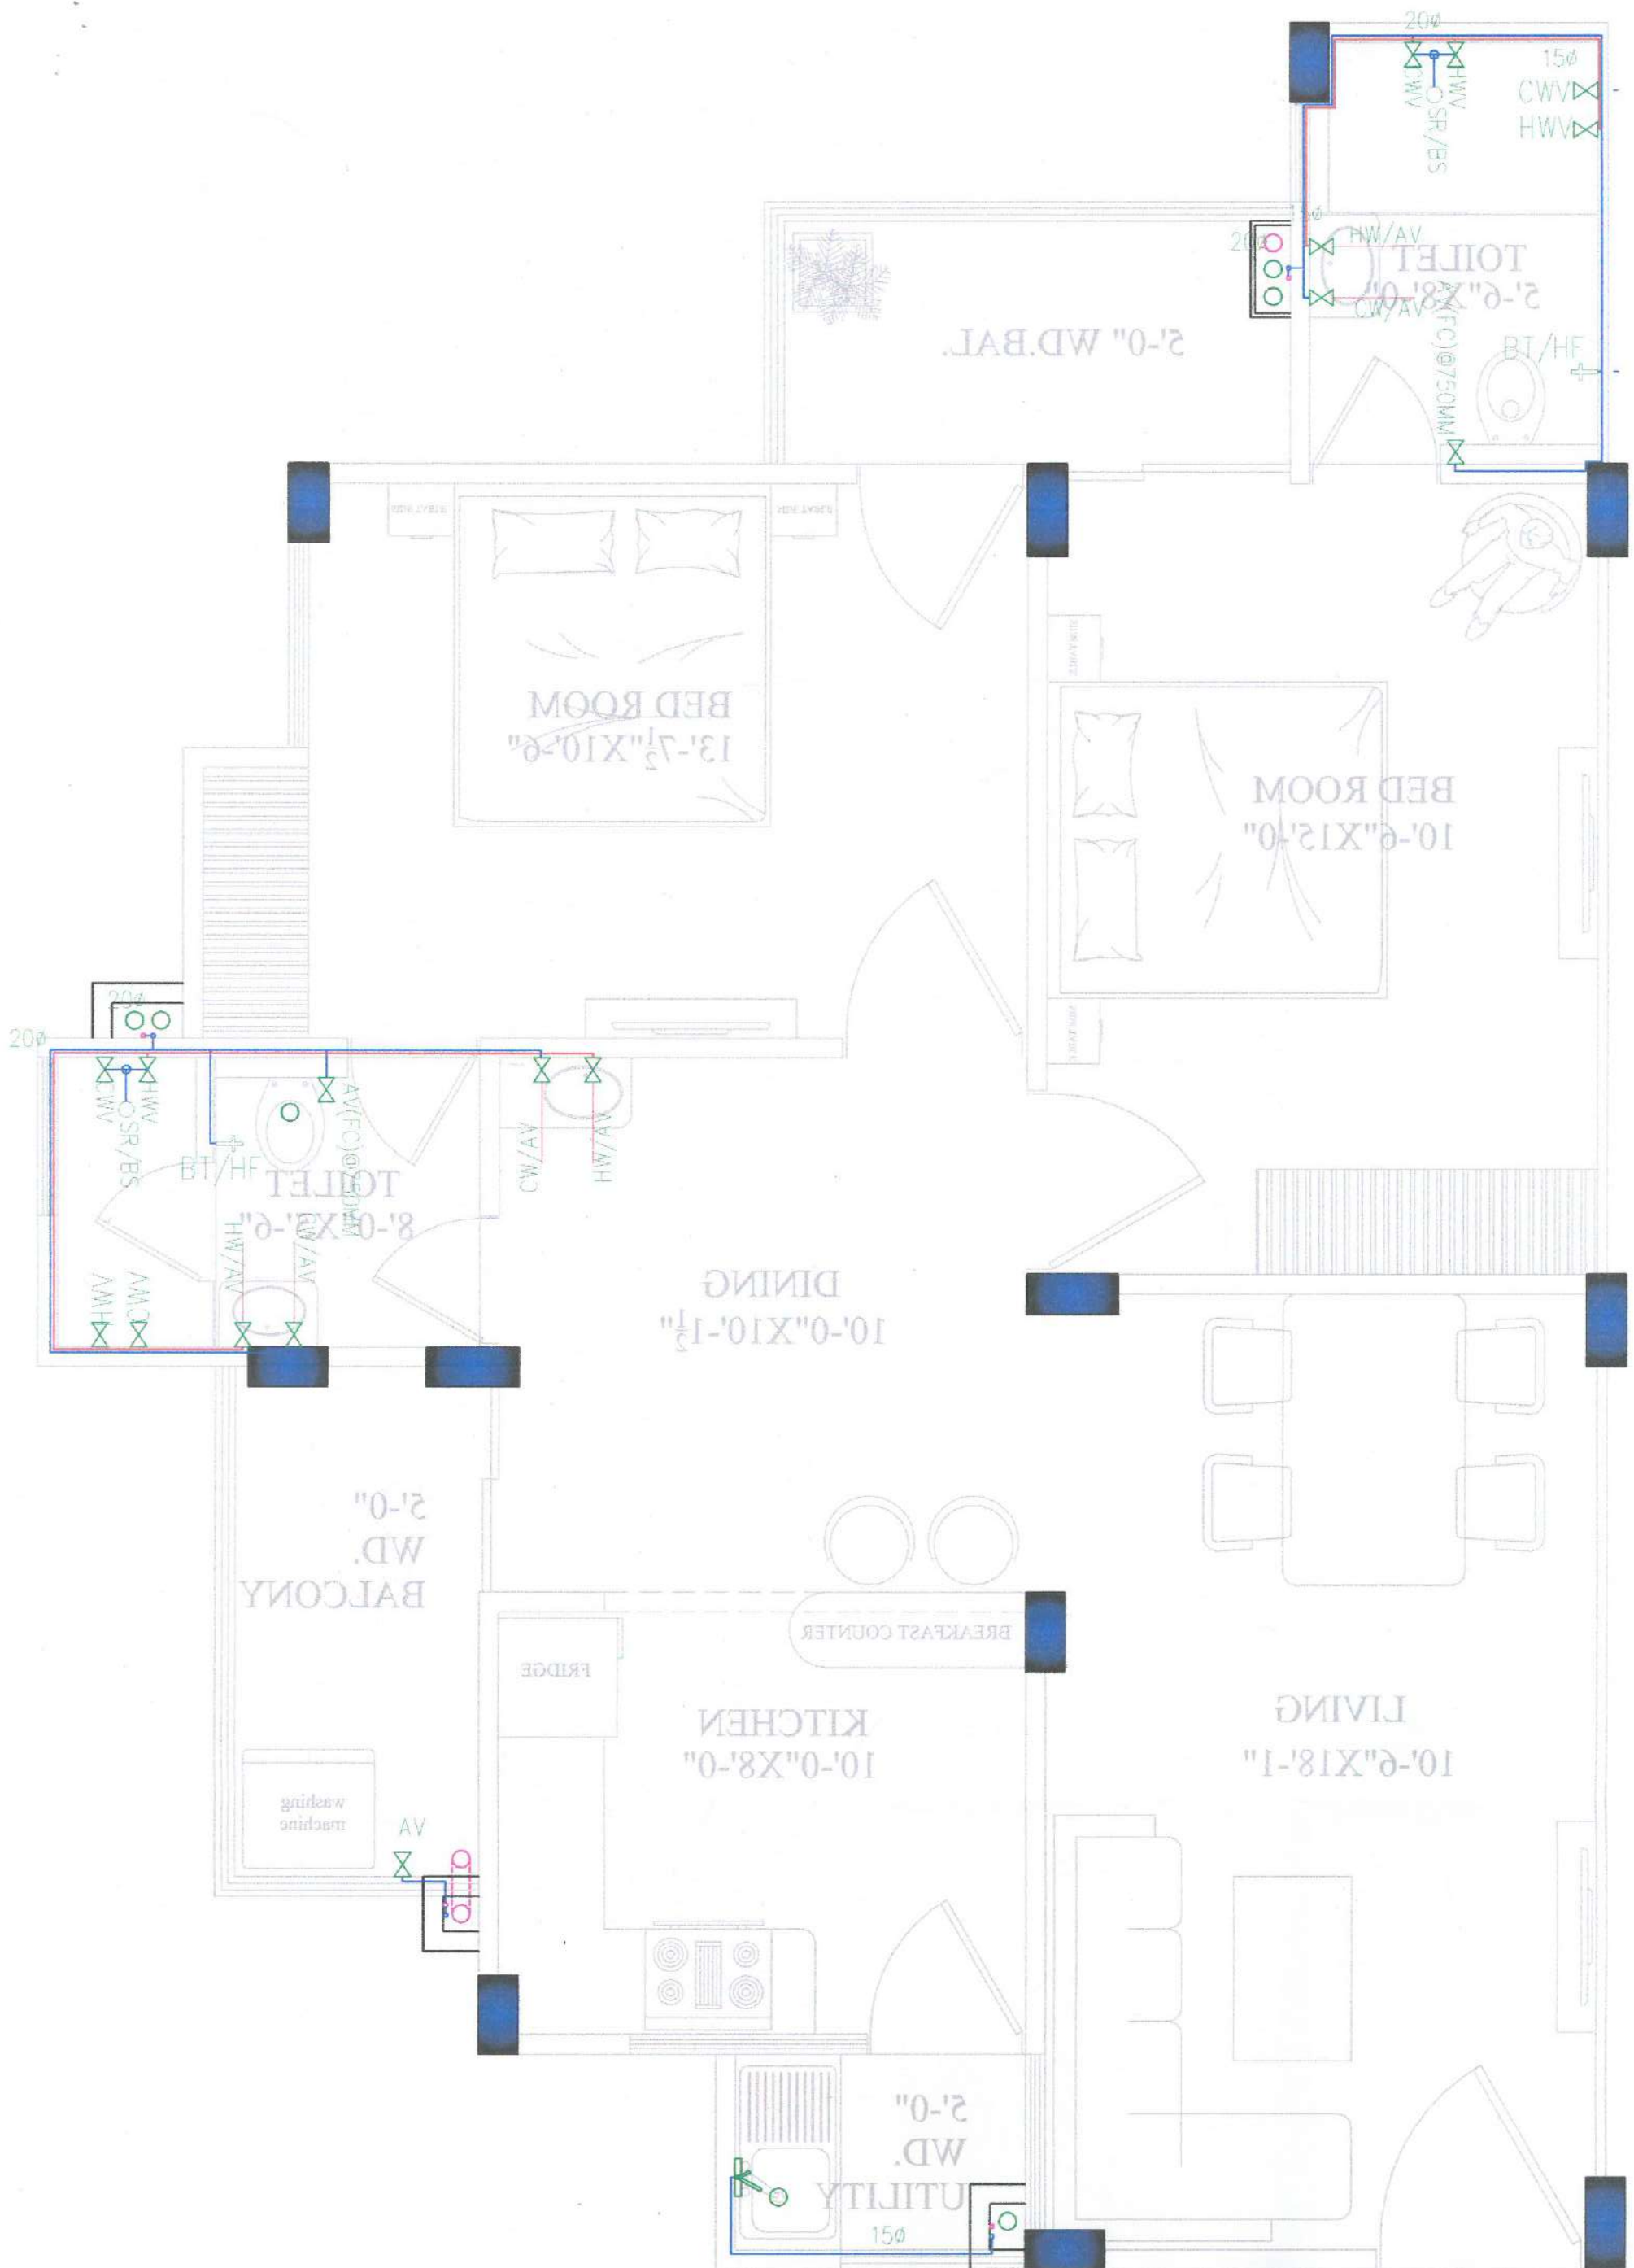

BLOW UP PLAN OF WATER SUPPLY(2BHK)