


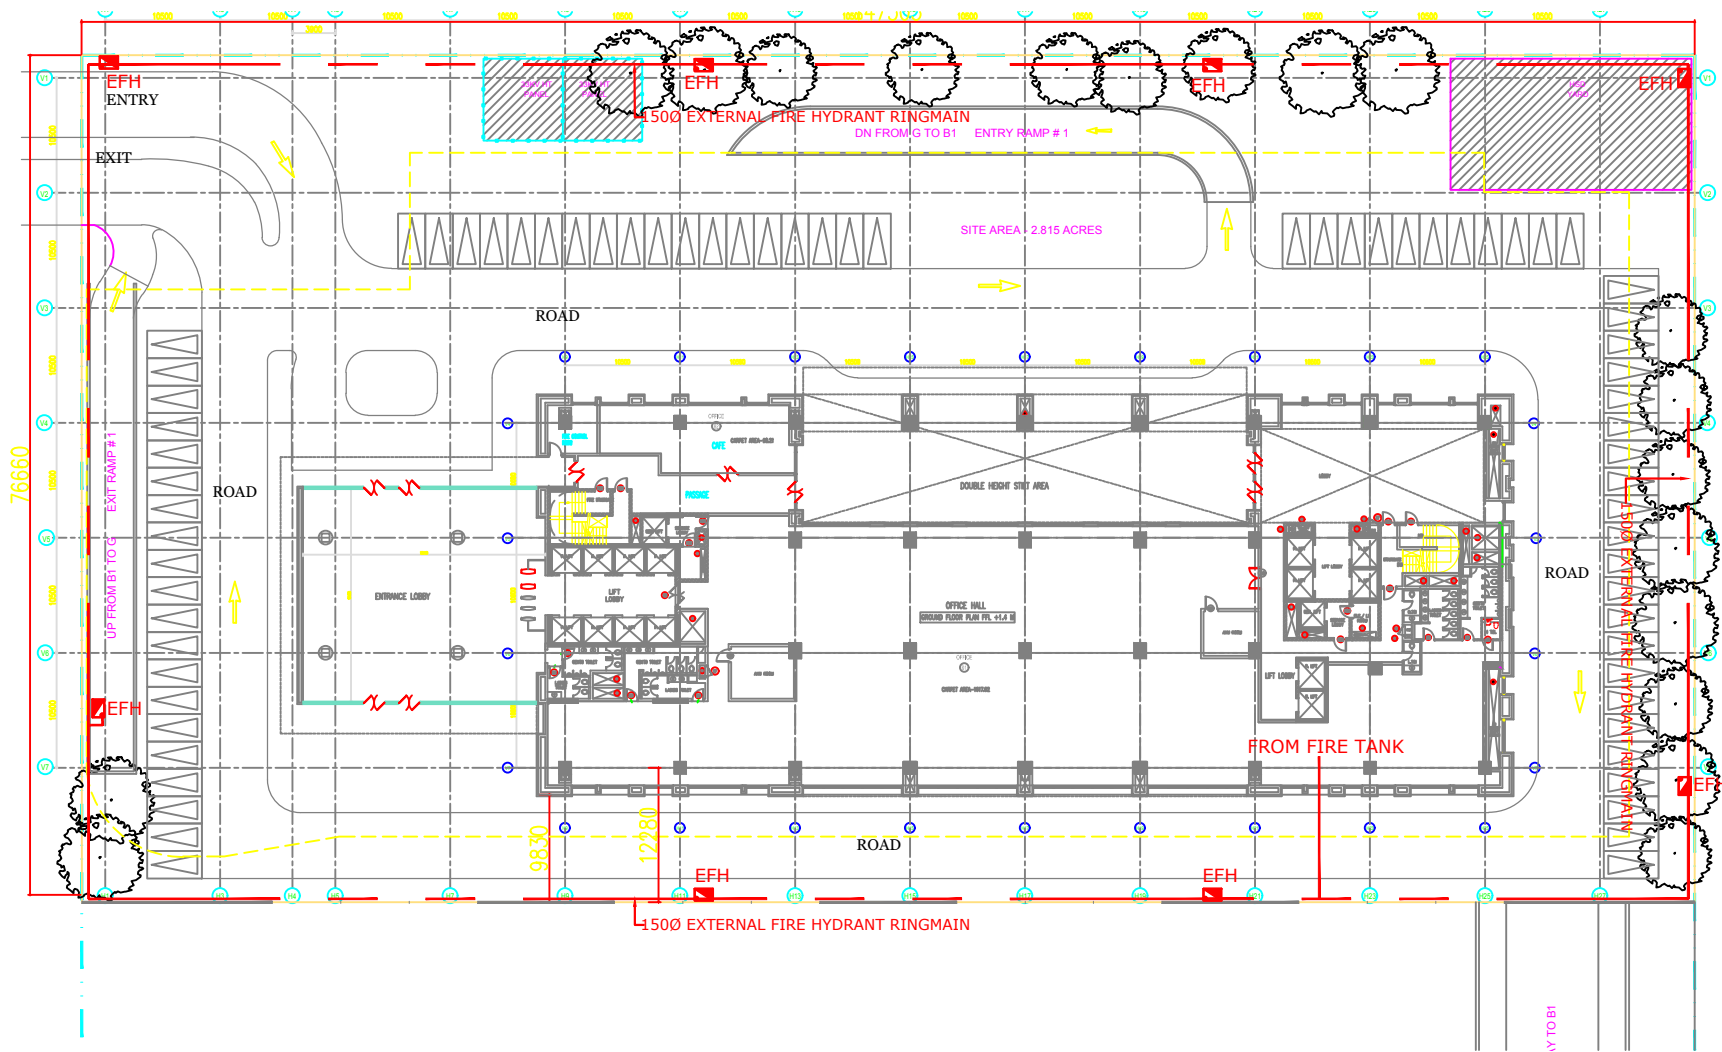

CLIENT
BPTP INTERNATIONAL
TRADE CENTRE LIMITED
M-11, Middle Circle, Connaught Circle,
New Delhi-110002
Tel: 011 43660888 Fax: 011 41515037-38

PROJECT
CAPITAL CITY
MANSION LANSIAH COMPLEX
PLOT NO. 2, SECTOR 34, NOIDA



NOTES

1. ALL DIMENSIONS ARE IN METERS.
2. ALL DIMENSIONS ARE TO FACE UNLESS OTHERWISE SPECIFIED.
3. ALL DIMENSIONS ARE TO BE VERIFIED ON SITE.
4. ALL DIMENSIONS ARE TO BE VERIFIED ON SITE.
5. ALL DIMENSIONS ARE TO BE VERIFIED ON SITE.
6. ALL DIMENSIONS ARE TO BE VERIFIED ON SITE.
7. ALL DIMENSIONS ARE TO BE VERIFIED ON SITE.
8. ALL DIMENSIONS ARE TO BE VERIFIED ON SITE.
9. ALL DIMENSIONS ARE TO BE VERIFIED ON SITE.
10. ALL DIMENSIONS ARE TO BE VERIFIED ON SITE.

DESIGN ARCHITECT
Robert A.M. Stern Architects, LLP
400 West 59th Street, New York, NY 10019
Tel: +1 212 676 1000 Fax: +1 212 676 1001

ARCHITECTURE TEAM

STRUCTURAL CONSULTANTS
MEHRD Consultants
A-10, Gurgaon, Haryana, India - 122001
Tel: +91 98960 10000 Fax: +91 98960 10001
Email: info@mehrd.com

ELECTRICAL CONSULTANTS
Electrical Consulting Engineers
P-10, Gurgaon, Haryana, India - 122001
Tel: +91 98960 10000 Fax: +91 98960 10001
Email: info@ecce.com

MECHANICAL CONSULTANTS
Dewi Puri Consultants Pvt. Ltd.
B-10, Gurgaon, Haryana, India - 122001
Tel: +91 98960 10000 Fax: +91 98960 10001
Email: info@dpcpl.com

PL & PP CONSULTANTS
Sangam Engineering Consultants Pvt. Ltd.
A-10, Gurgaon, Haryana, India - 122001
Tel: +91 98960 10000 Fax: +91 98960 10001
Email: info@sangam.com

LANDSCAPE CONSULTANTS

SHEET TITLE
SITE PLAN
FIRE FIGHTING LAYOUT

Scale: 1:500

DATE: 15/08/2018

BY: R.A.M. STERN

FOR: BPTP INTERNATIONAL

PROJECT: CAPITAL CITY

LOCATION: MANSION LANSIAH COMPLEX

PLOT NO. 2, SECTOR 34, NOIDA