

REVISION	SCALE	NORTH-
	<b>1:250</b>	


DRAWING NO.  
**2618/60/YES/SITE PLAN/01**

OWNER'S SIGNATURE


ARCHITECT'S SIGNATURE

DRAWING  
**MASTER PLAN SHOWING  
 ALL SERVICES**

DRAWN BY:

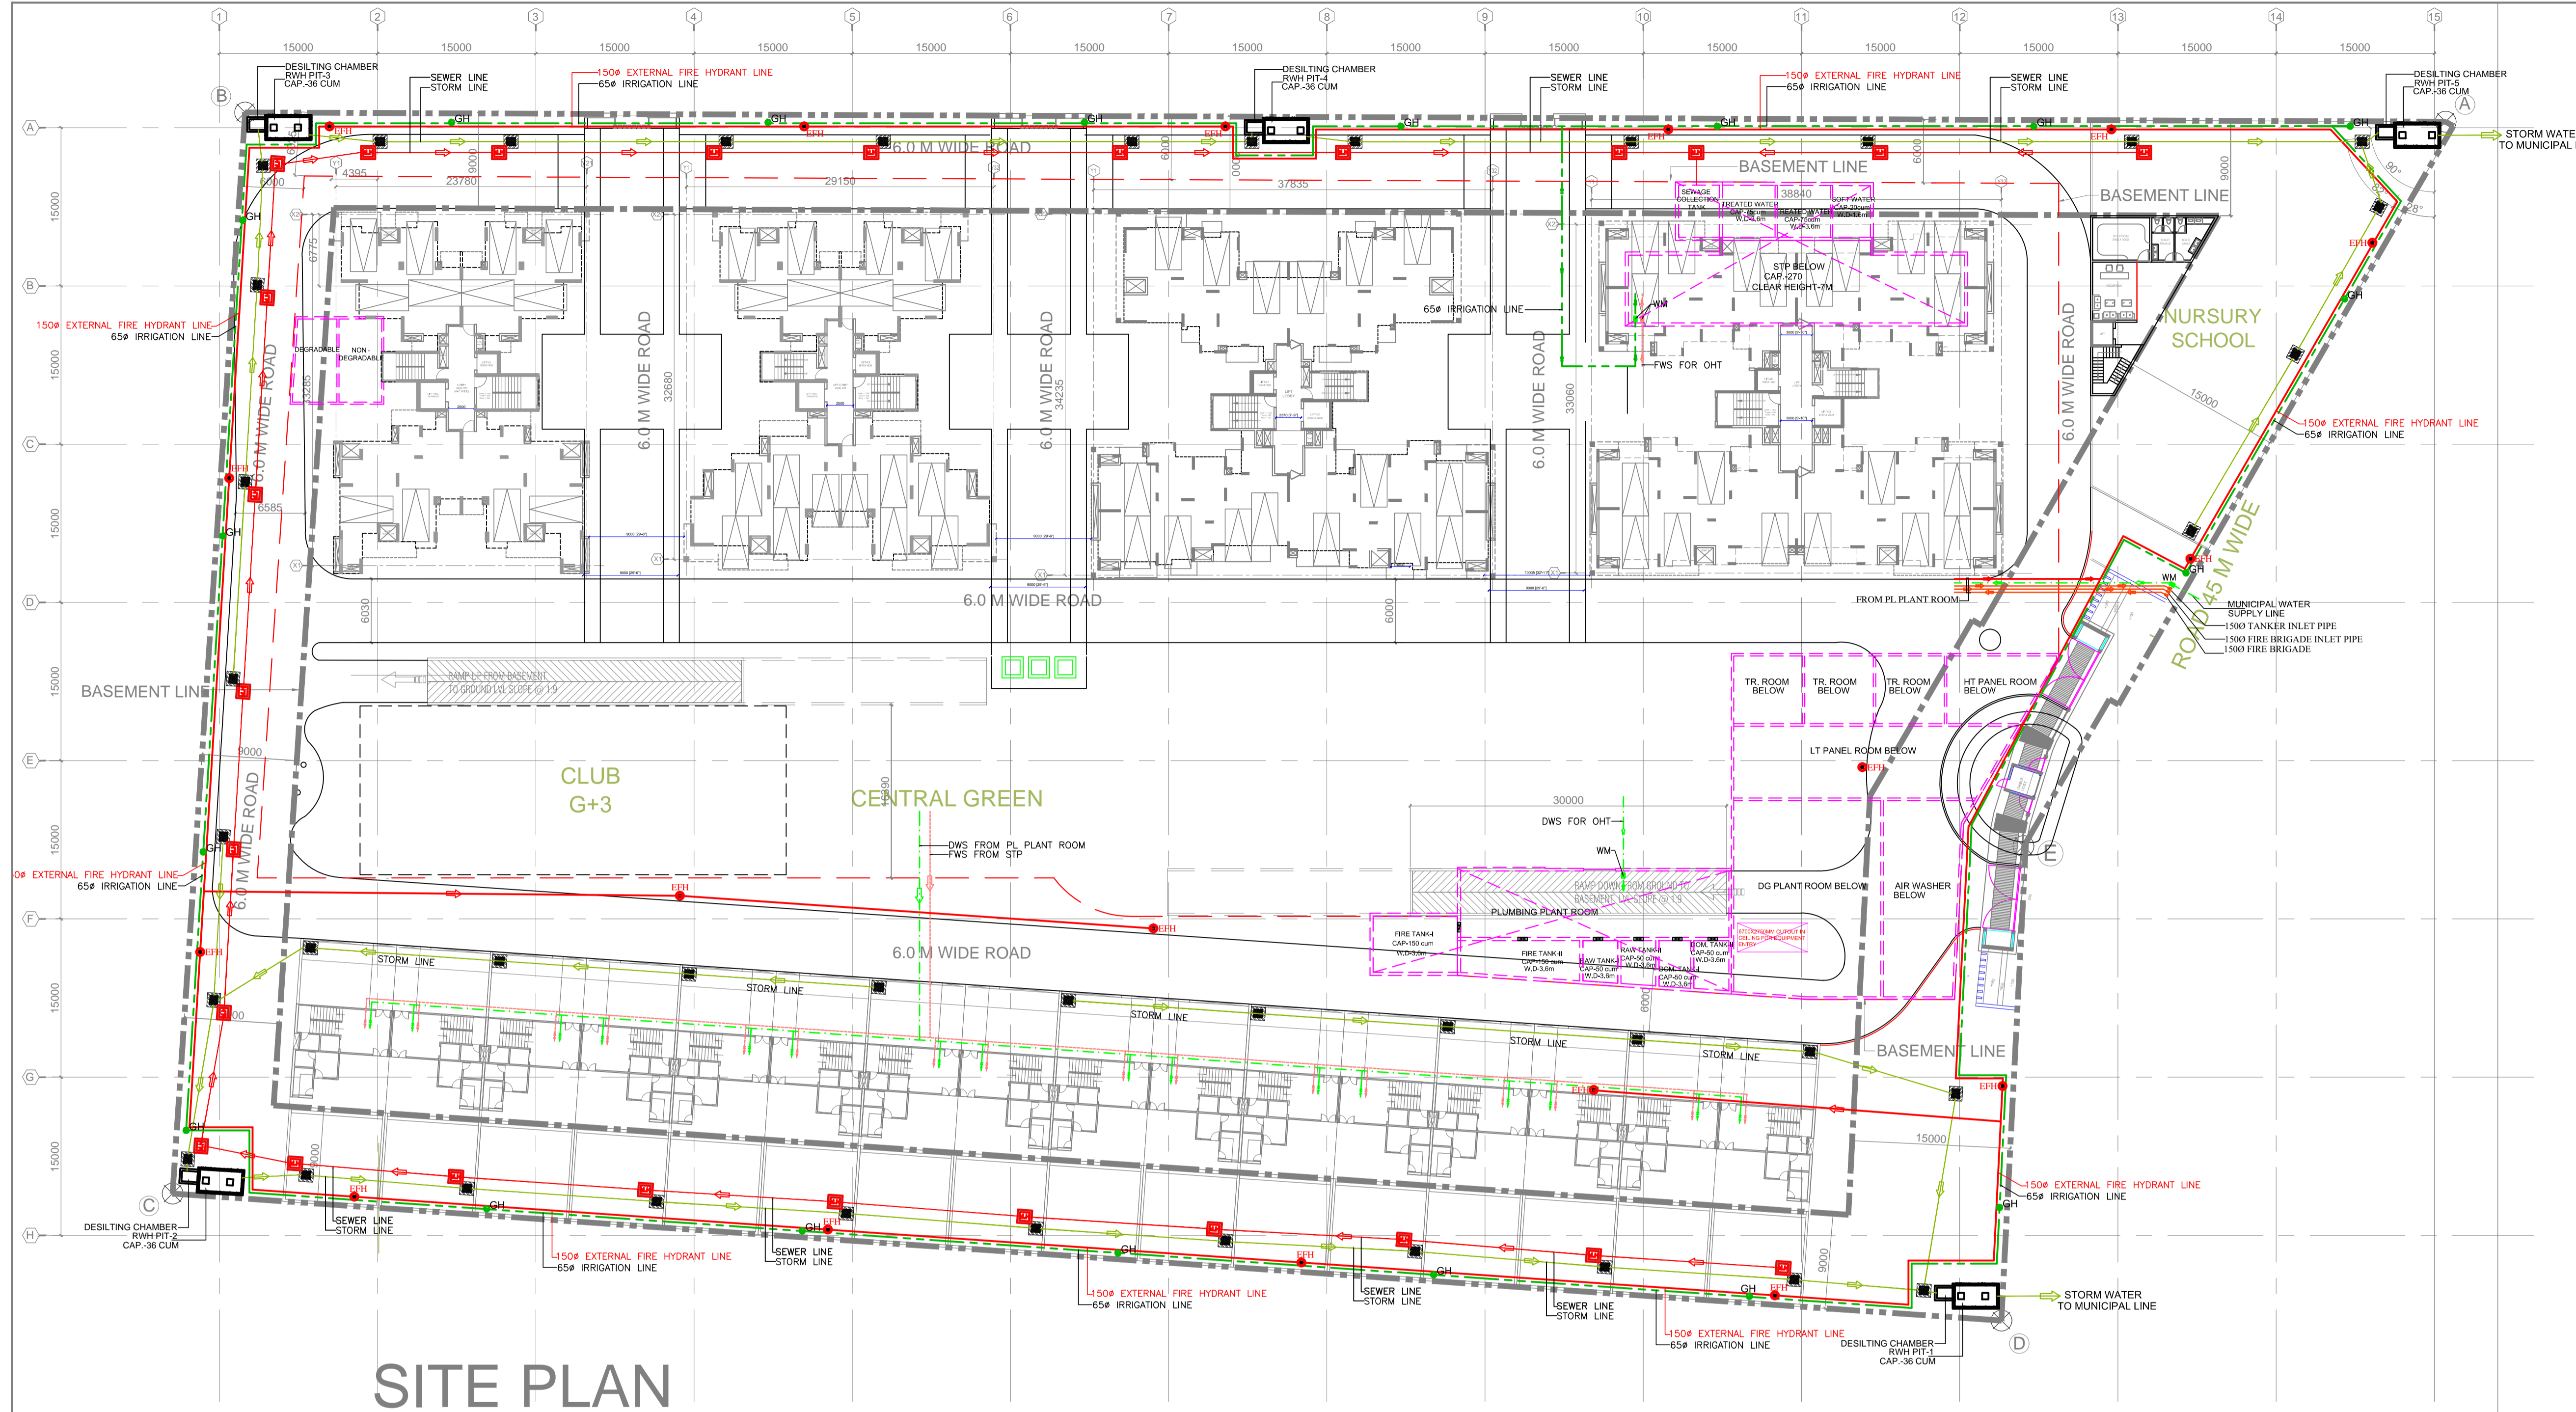

# SITE PLAN

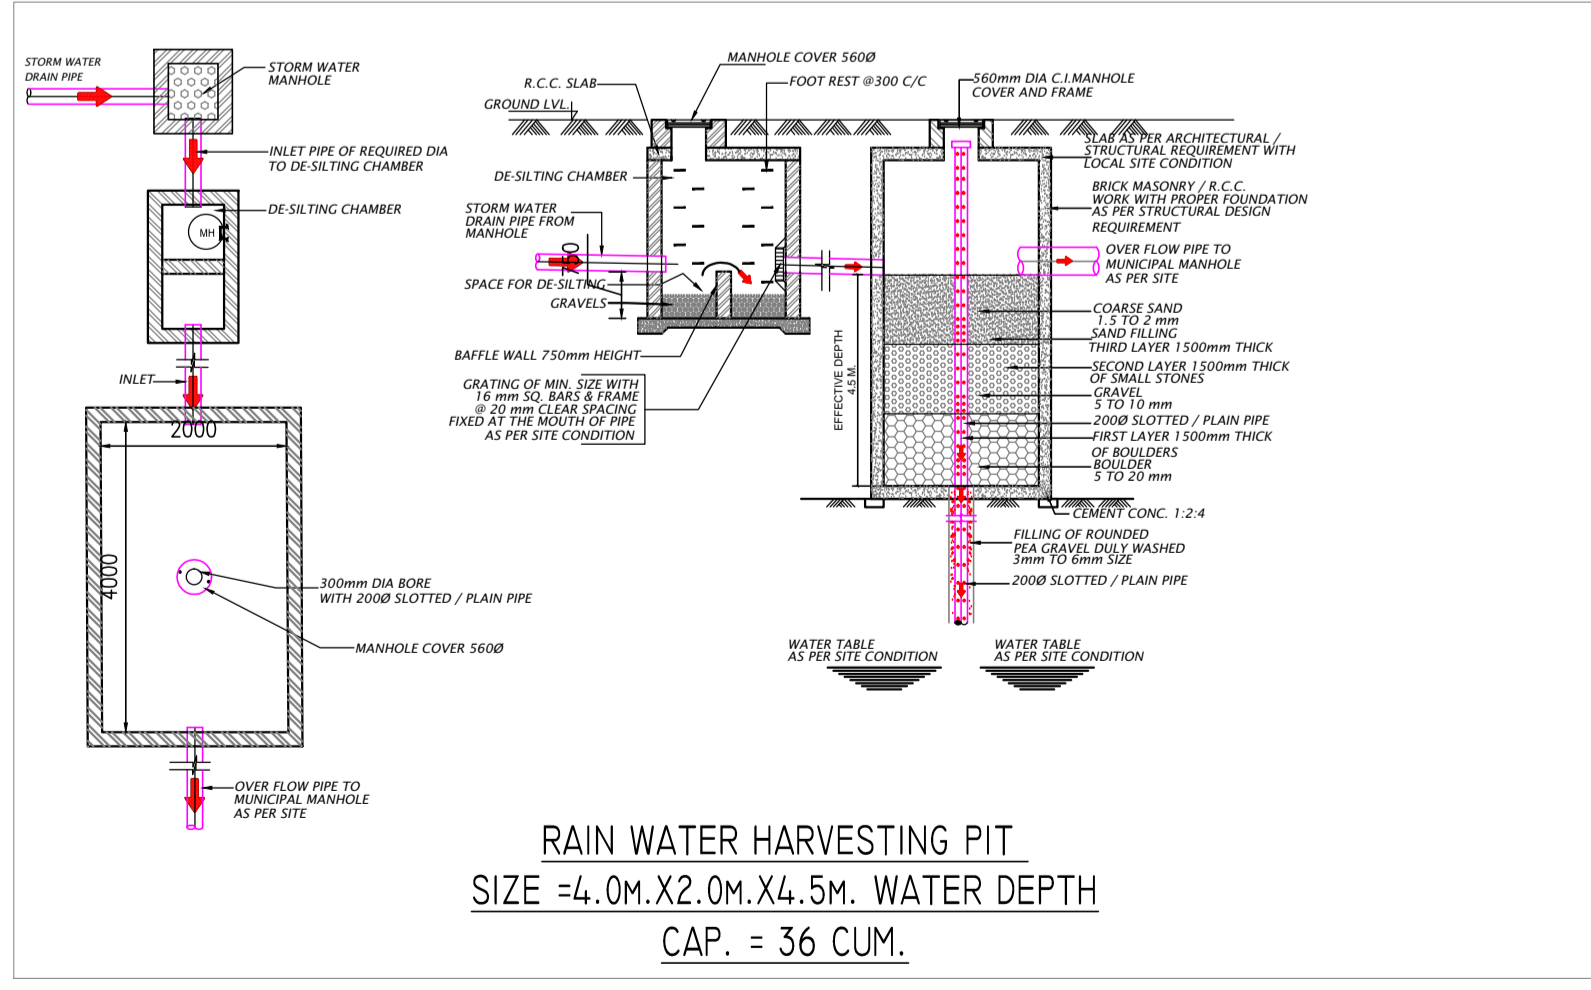

PLUMBING LEGENDS:	
	IRRIGATION WATER SUPPLY LINE
	FLUSH WATER SUPPLY LINE
	DOM. WATER SUPPLY LINE
	GARDEN HYDRANT
	SEWER LINE
	STORM WATER LINE
FIRE LEGENDS:	
	EXTERNAL FIRE HYDRANT LINE
	EXTERNAL FIRE HYDRANT