


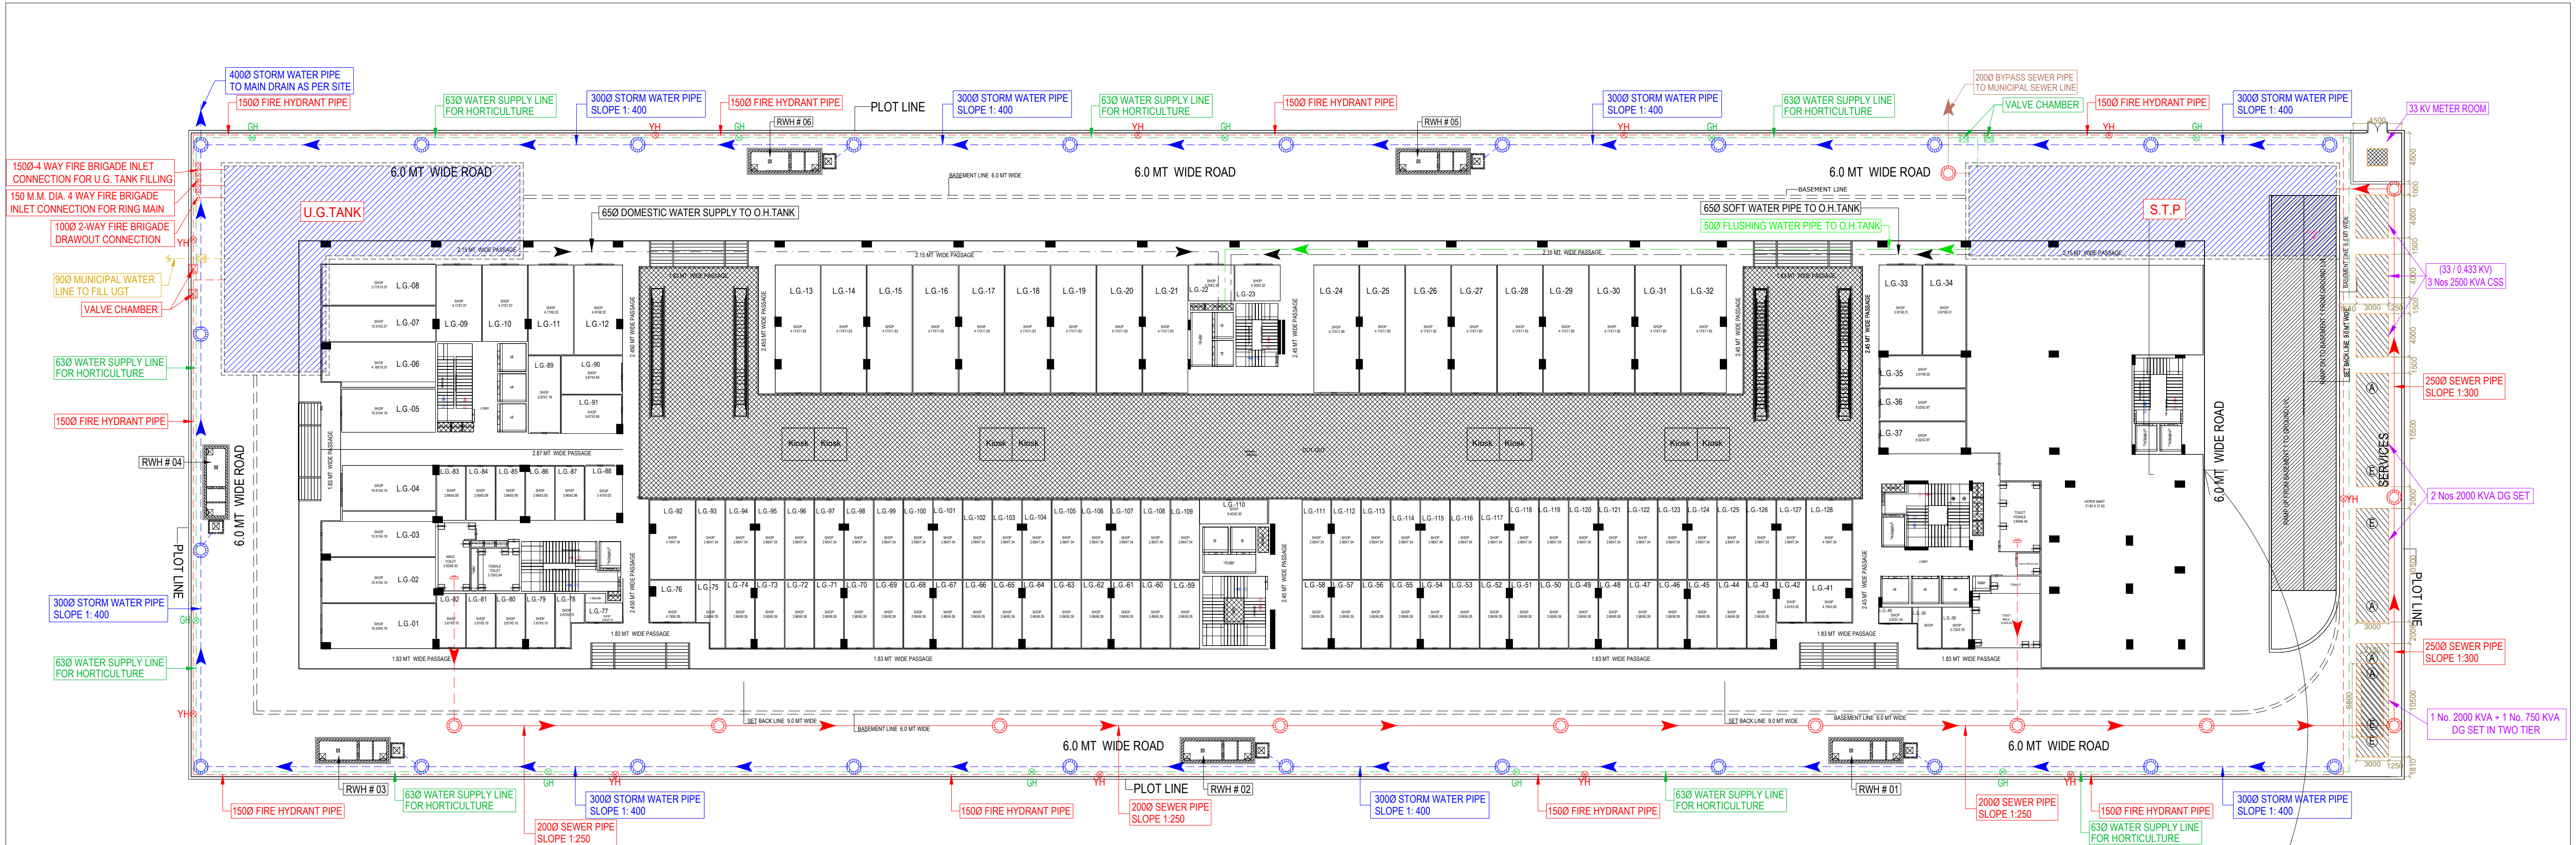

| LEGEND : |        |                                      |
|----------|--------|--------------------------------------|
| S. No.   | SYMBOL | DESCRIPTION                          |
| 1.       | C.P.   | CATCH PIT                            |
| 2.       |        | UNDER GROUND PIPE DRAIN              |
| 3.       |        | RAIN WATER HARVESTING                |
| 4.       | M.H.   | MANHOLE                              |
| 5.       |        | SEWER LINE                           |
| 6.       |        | MUNICIPAL WATER SUPPLY PIPE LINE.    |
| 7.       |        | MASONRY CHAMBER FOR ISOLATING VALVE  |
| 8.       |        | IRRIGATION WATER SUPPLY LINE ( IWS ) |
| 9.       | GH     | GARDEN HYDRANT                       |
| 10.      |        | DOMESTIC WATER SUPPLY PIPE ( DWS )   |
| 11.      |        | FLUSHING WATER SUPPLY PIPE ( FWS )   |

| LEGEND : FIRE SYSTEM |        |                                                                                                                                                   |
|----------------------|--------|---------------------------------------------------------------------------------------------------------------------------------------------------|
| S. No.               | SYMBOL | DESCRIPTION                                                                                                                                       |
| 1.                   |        | EXTERNAL FIRE LINE                                                                                                                                |
| 2.                   | YH     | YARD HYDRANT<br>63 M.M. DIA. SINGLE HEADED HYDRANT VALVE<br>WITH 2 NOS. 15 M LONG, 63 M.M. DIA. FIRE HOSE<br>PIPE & 1 NO. BRANCH PIPE WITH NOZZLE |
| 3.                   |        | FIRE BRIGADE CONNECTION                                                                                                                           |
| 4.                   |        | BUTTERFLY VALVE                                                                                                                                   |
| 5.                   |        | NONRETURN VALVE (CHECK VALVE)                                                                                                                     |
| 6.                   |        | ISOLATING VALVE WITH MASONRY CHAMBER                                                                                                              |

**Clients**

AURA BUILDCOM LLP,BLD.

**architects**

KATARIA AND ASSOCIATES

**Project :**

COMMERCIAL PLOT  
NO-5 SPRING WOOD  
ENCLAVE SECTOR-4 WAVE CITY

**title**

SITE PLAN

**subtitle**

EXTERNAL COORDINATED LAYOUT

**drawing released for**

☐ APPROVAL ☒ SUBMISSION

☐ ADVANCE COPY ☐ CONSTRUCTION

**drg. no.**

CES / AURA / SP / PL-04

**scale**

A1@1:300

**date**

25.07.2024

**drawn by**

S.Bhandari

**designed by**

Shakir Shabir

**checked by**

ANAND HAVELIA

**services consultant**

Consummate Engineering Services (P) Ltd.

Noida Office : B - 67, Sector - 67, Noida - 201 301  
Tel. : (0120) 2303500 / 24 Lines )  
Lko. Office : R 006, Rohitas Plumeria, Gomti Nagar, Lucknow  
e mail : mail@cespl.in, website : www.cespl.in