


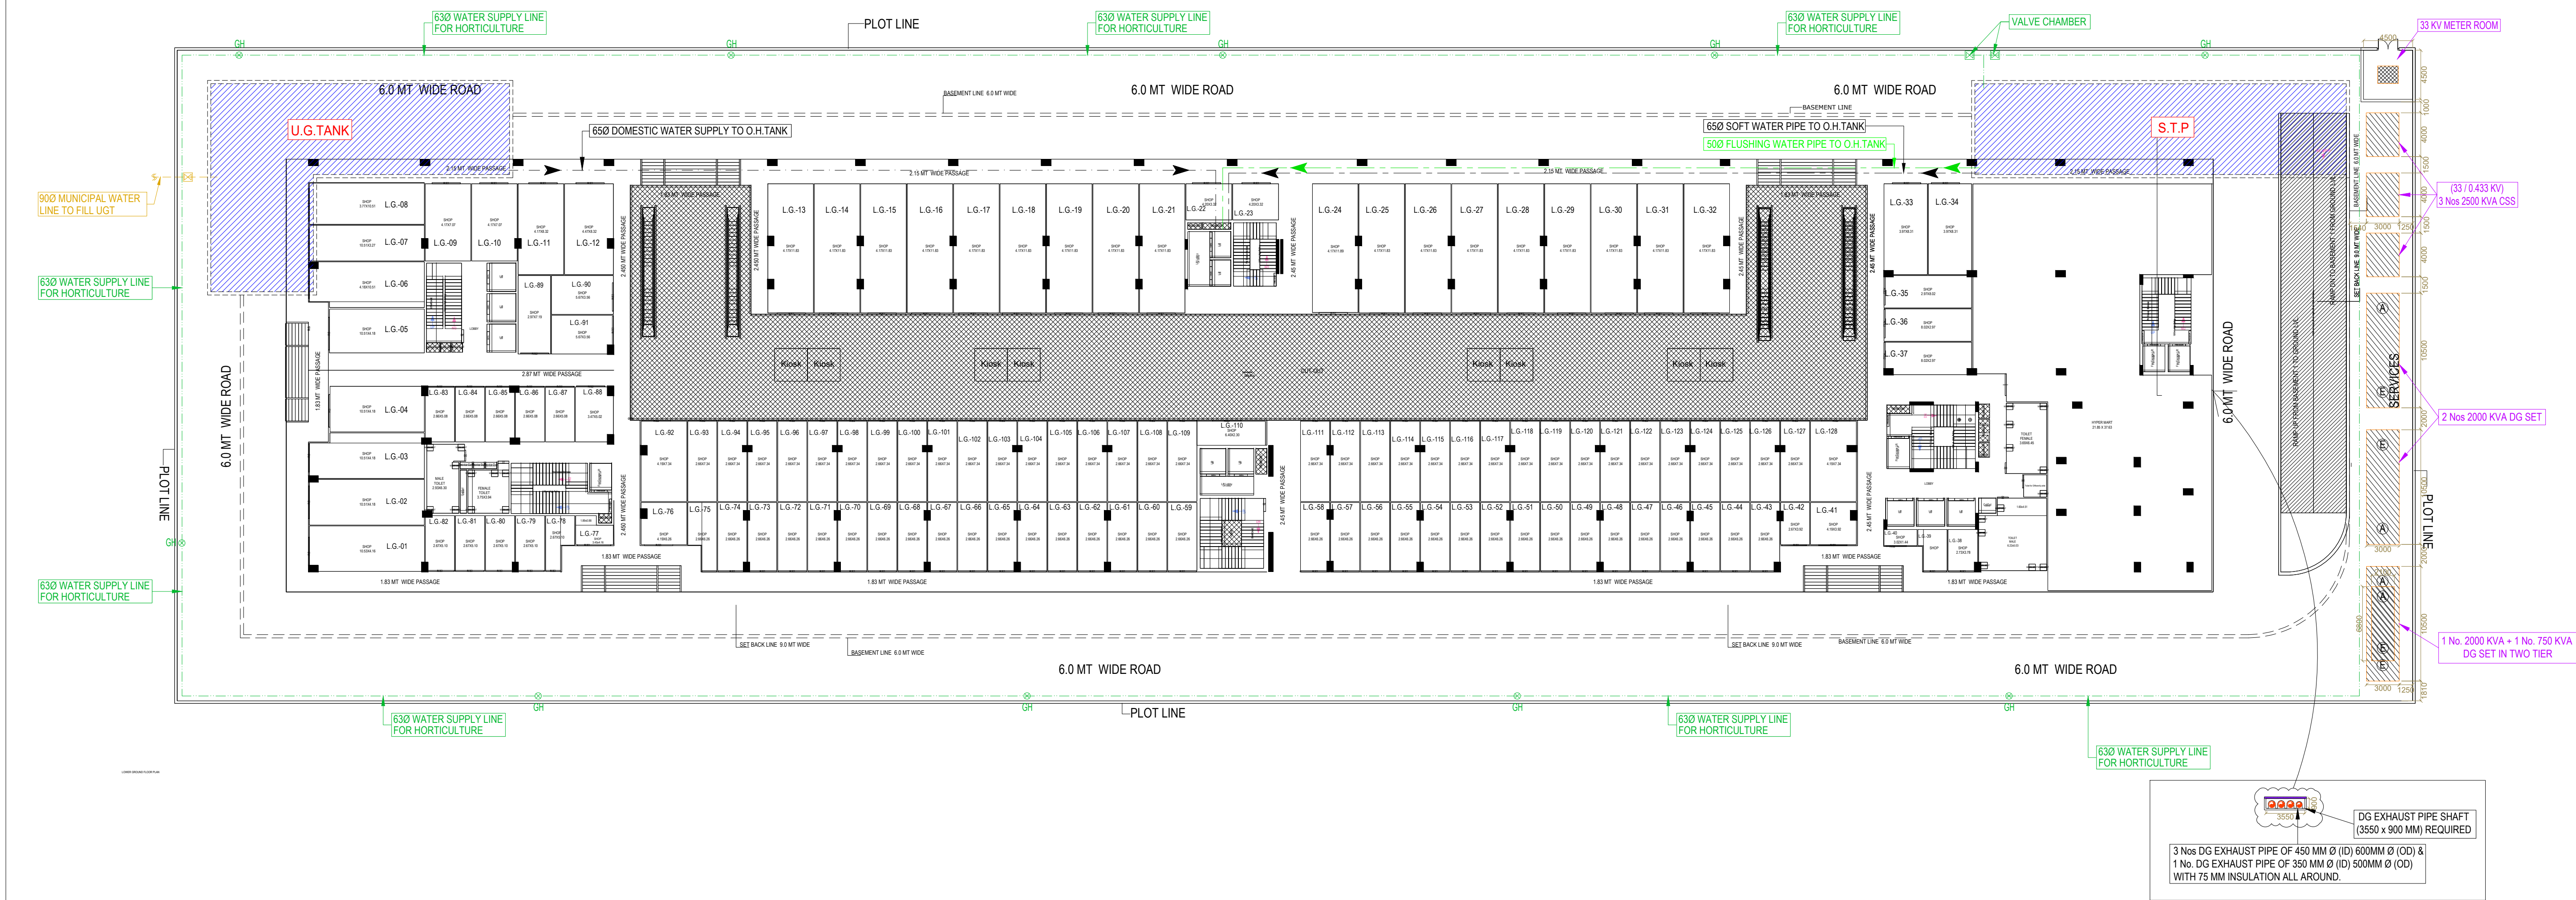

LEGEND :		
S. No.	SYMBOL	DESCRIPTION
1.		MUNICIPAL WATER SUPPLY PIPE LINE
2.		MASONRY CHAMBER FOR ISOLATING VALVE
3.		IRRIGATION WATER SUPPLY LINE (IWS)
4.		GARDEN HYDRANT
5.		DOMESTIC WATER SUPPLY PIPE (DWS)
6.		FLUSHING WATER SUPPLY PIPE (FWS)

Clients

AURA BUILDCOM LLP,BLD.

architects

KATARIA AND ASSOCIATES

Project :

COMMERCIAL PLOT
NO-5 SPRING WOOD
ENCLAVE SECTOR-4 WAVE CITY

title

SITE PLAN

subtile

EXTERNAL WATER SUPPLY LAYOUT

drawing released for

☐ APPROVAL ☒ SUBMISSION

☐ ADVANCE COPY ☐ CONSTRUCTION

drg. no.

CES / AURA / SP / PL-03

scale

A1@1:300

date

25.07.2024

drawn by

S.Bhandari

designed by

Shakir Shabir

checked by

ANAND HAVELIA

services consultant

Consummate Engineering Services (P) Ltd.

Noida Office : B - 67, Sector - 67, Noida - 201 301
Tel. : (0120) 2303500 / (24 Lines)
Lko. Office : R 006, Rohitas Plumeria, Gomti Nagar, Lucknow
e mail : mail@cespl.in, website : www.cespl.in