
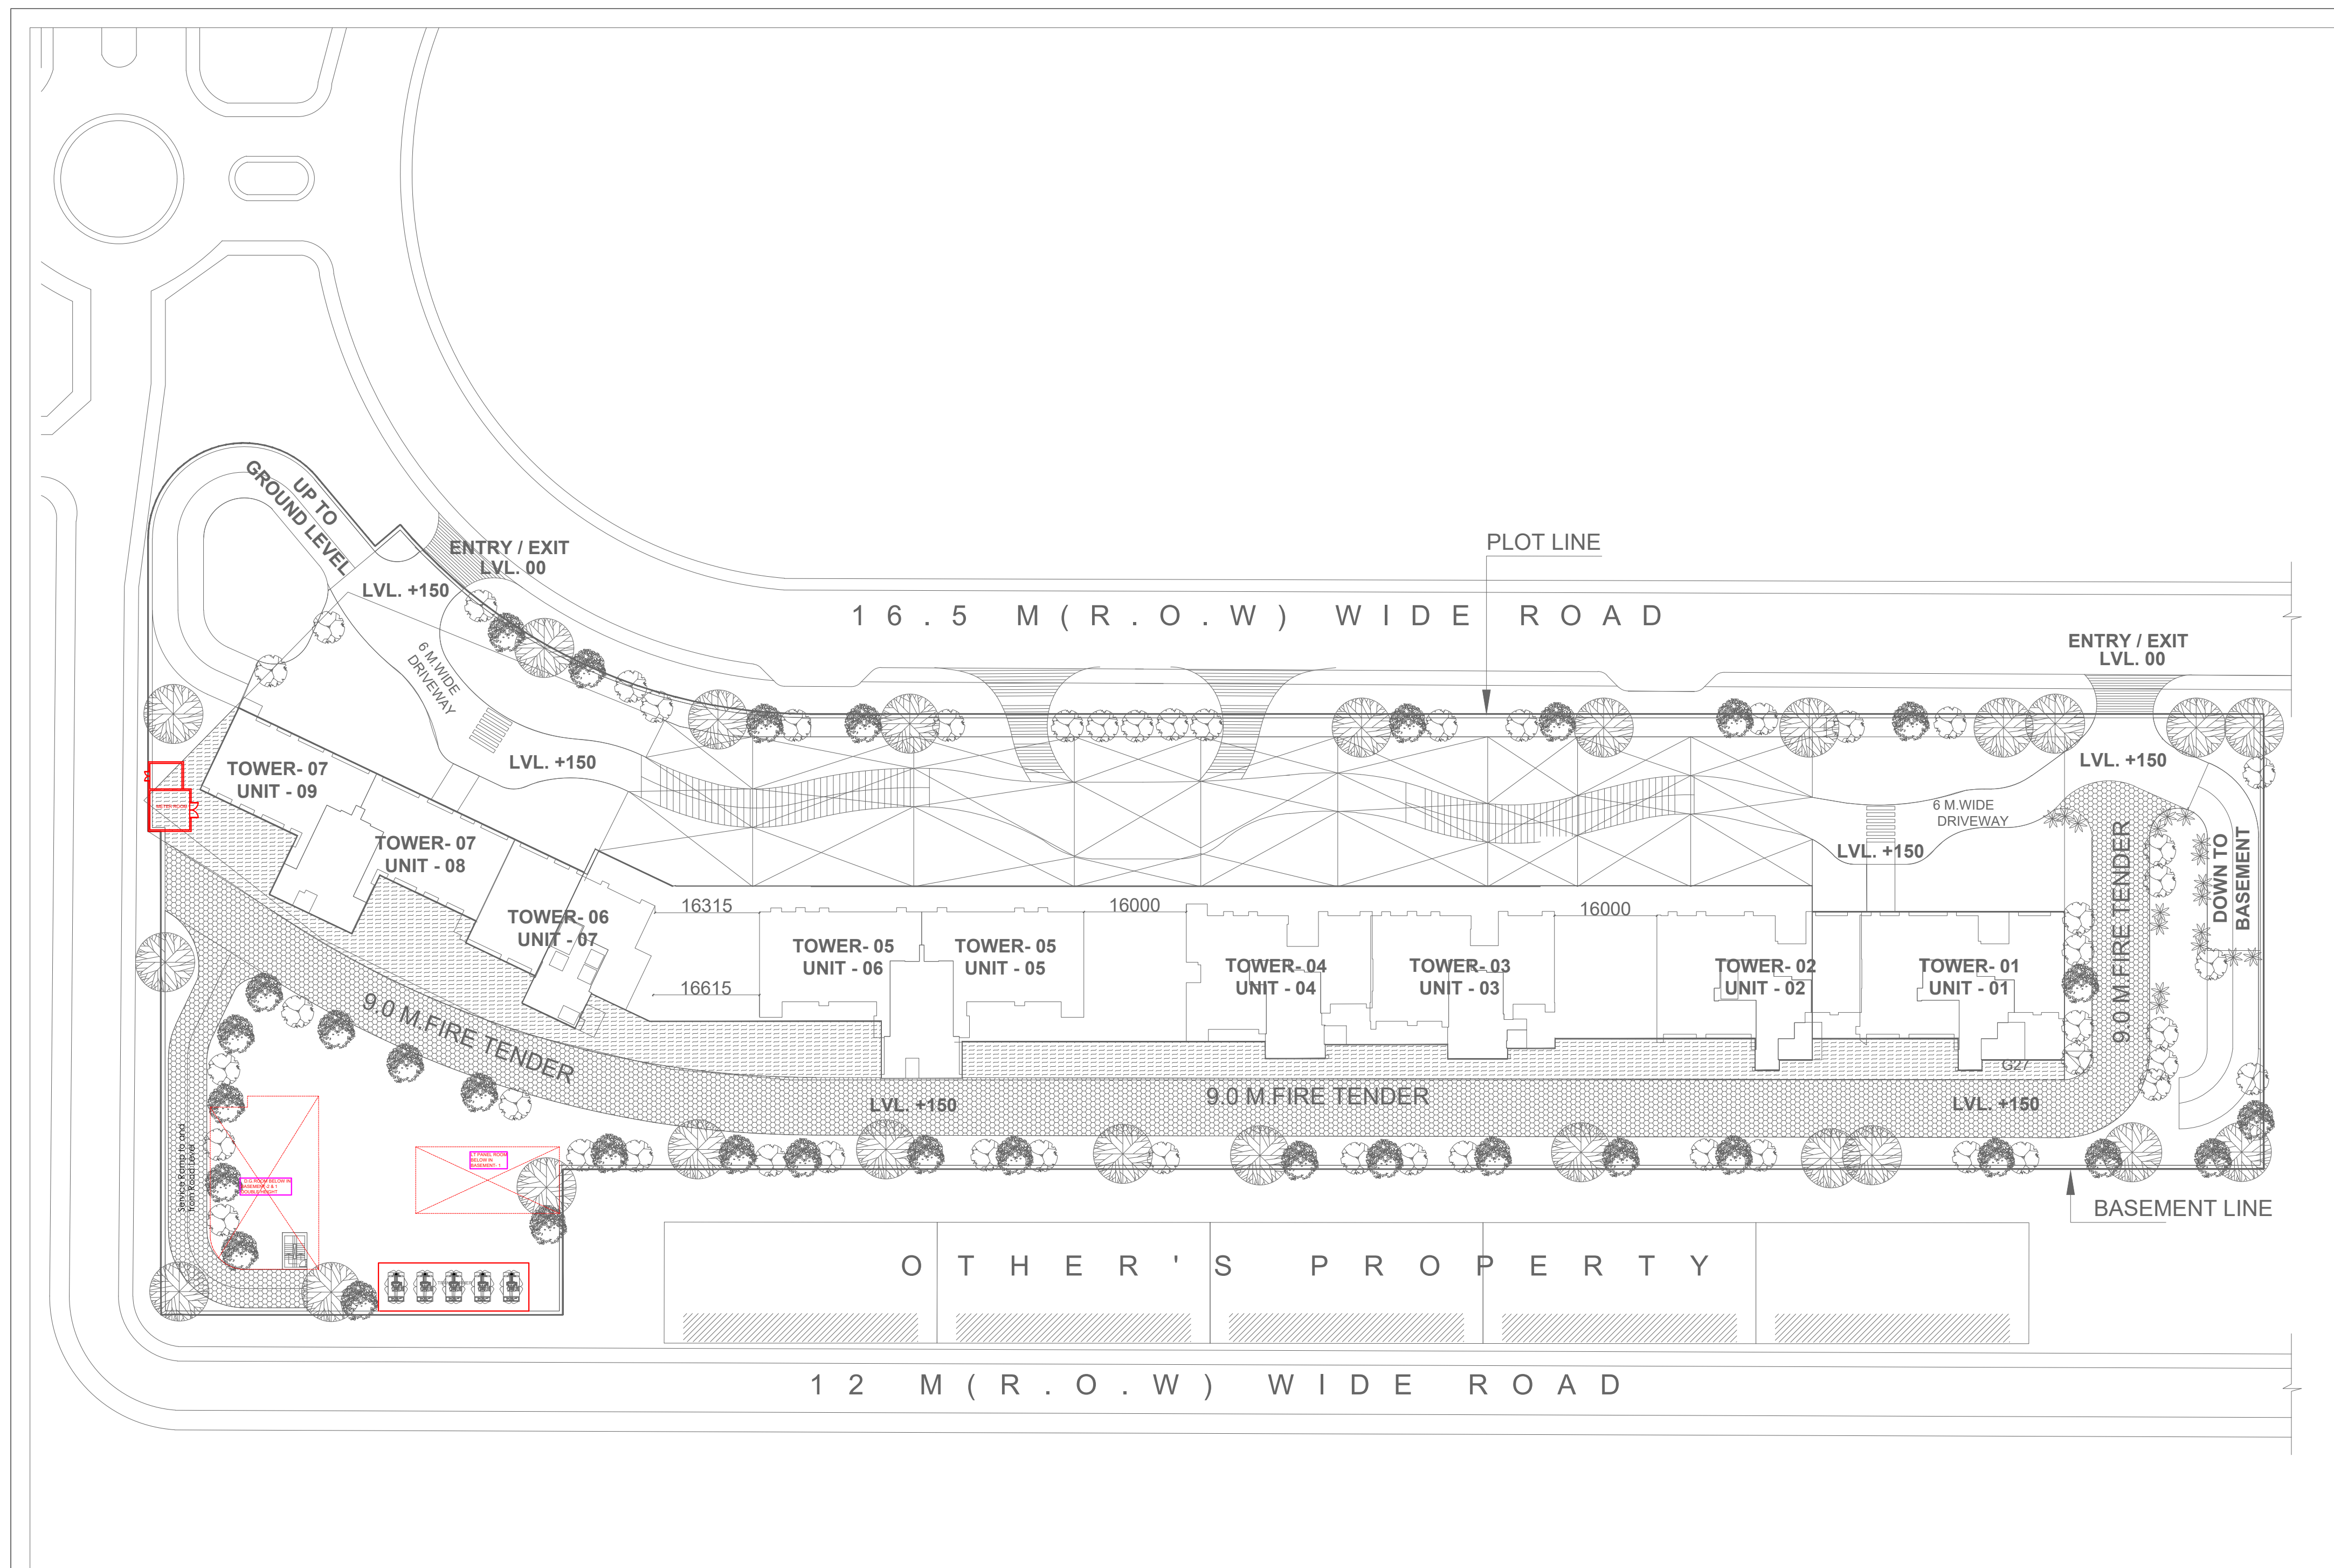


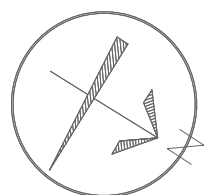

SCALE 1:250	DATE	
DRAWN BY	DRG. NO. 01	
PROJECT PROPOSED SUBMISSION OF GROUP HOUSING AT PLOT NO C1 IN LAND -2 , INTEGRATED SPORT COMPLEX AT JAYPEE GREENS SECT 26 AND 31 SURAJPUR KASANA ROAD , GREATER NOIDA , U.P.		
OWNER JAYPEE GREENS (A DIVISION OF JAI PRAKASH ASSOCIATE LTD.)		
DRAWING TITLE SITE PLAN FOR ELECTRICAL LAYOUT		
TOWN PLANNER		
OWNER SIGN.		ARCHITECTS SIGN.