




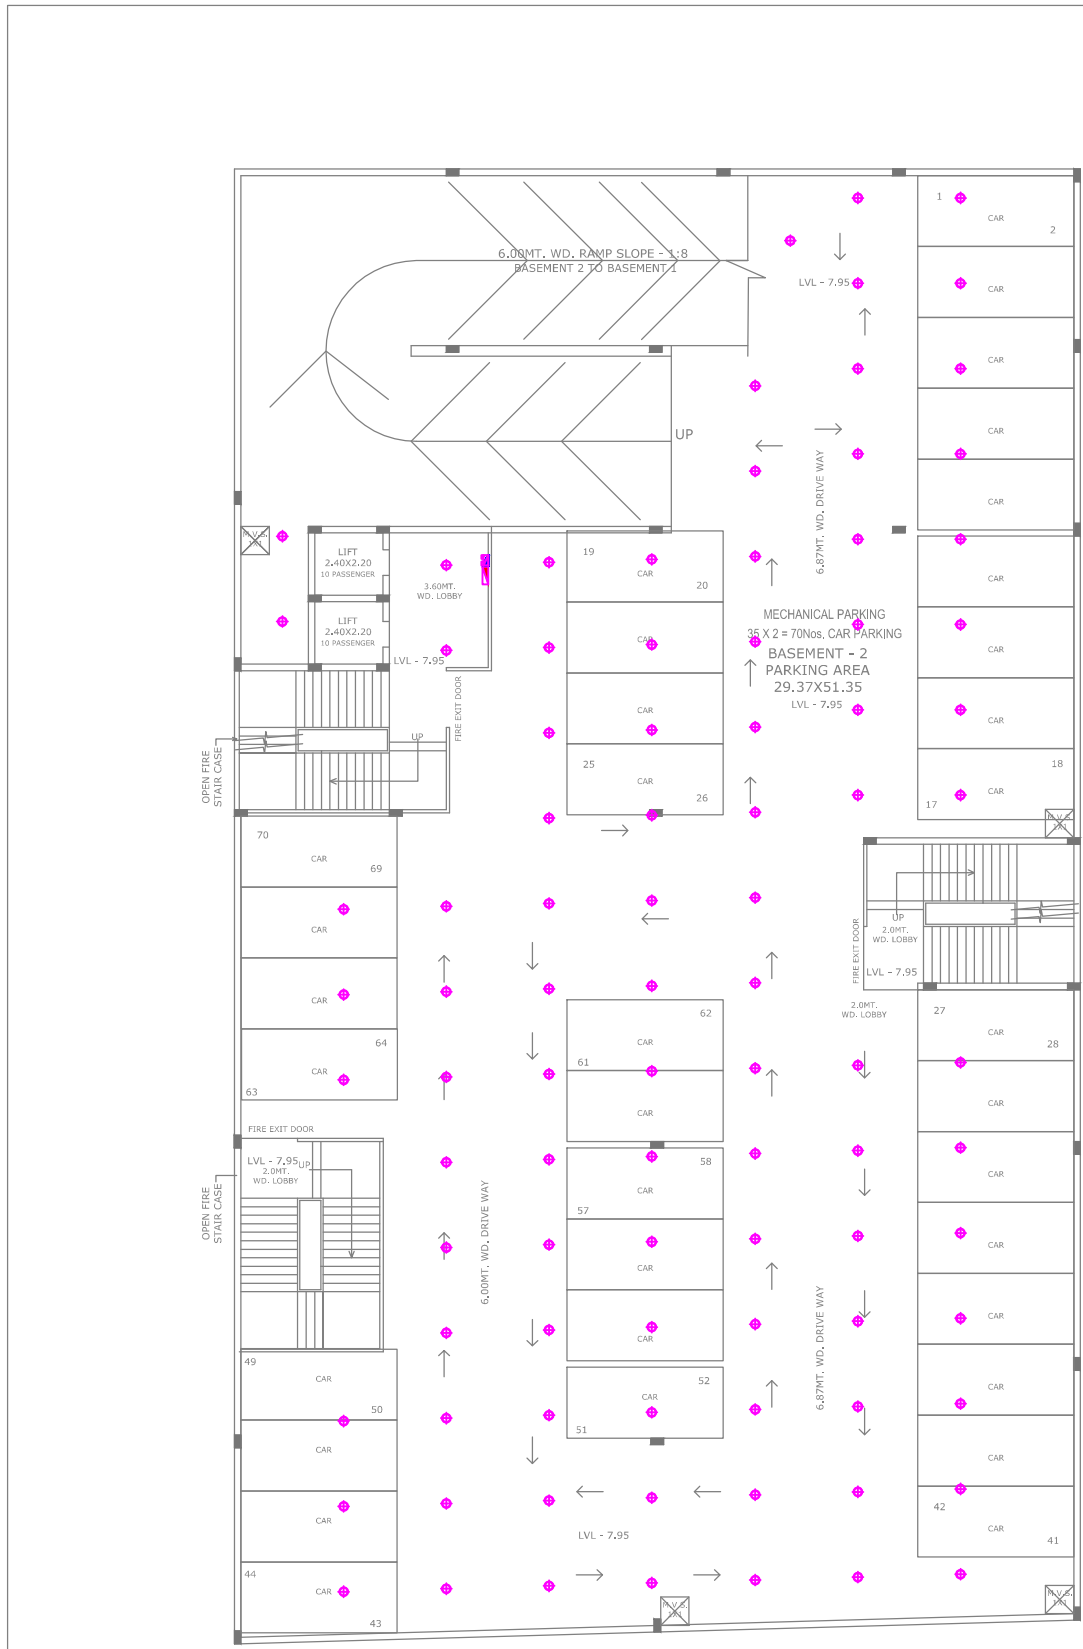

BASEMENT -2 PLAN

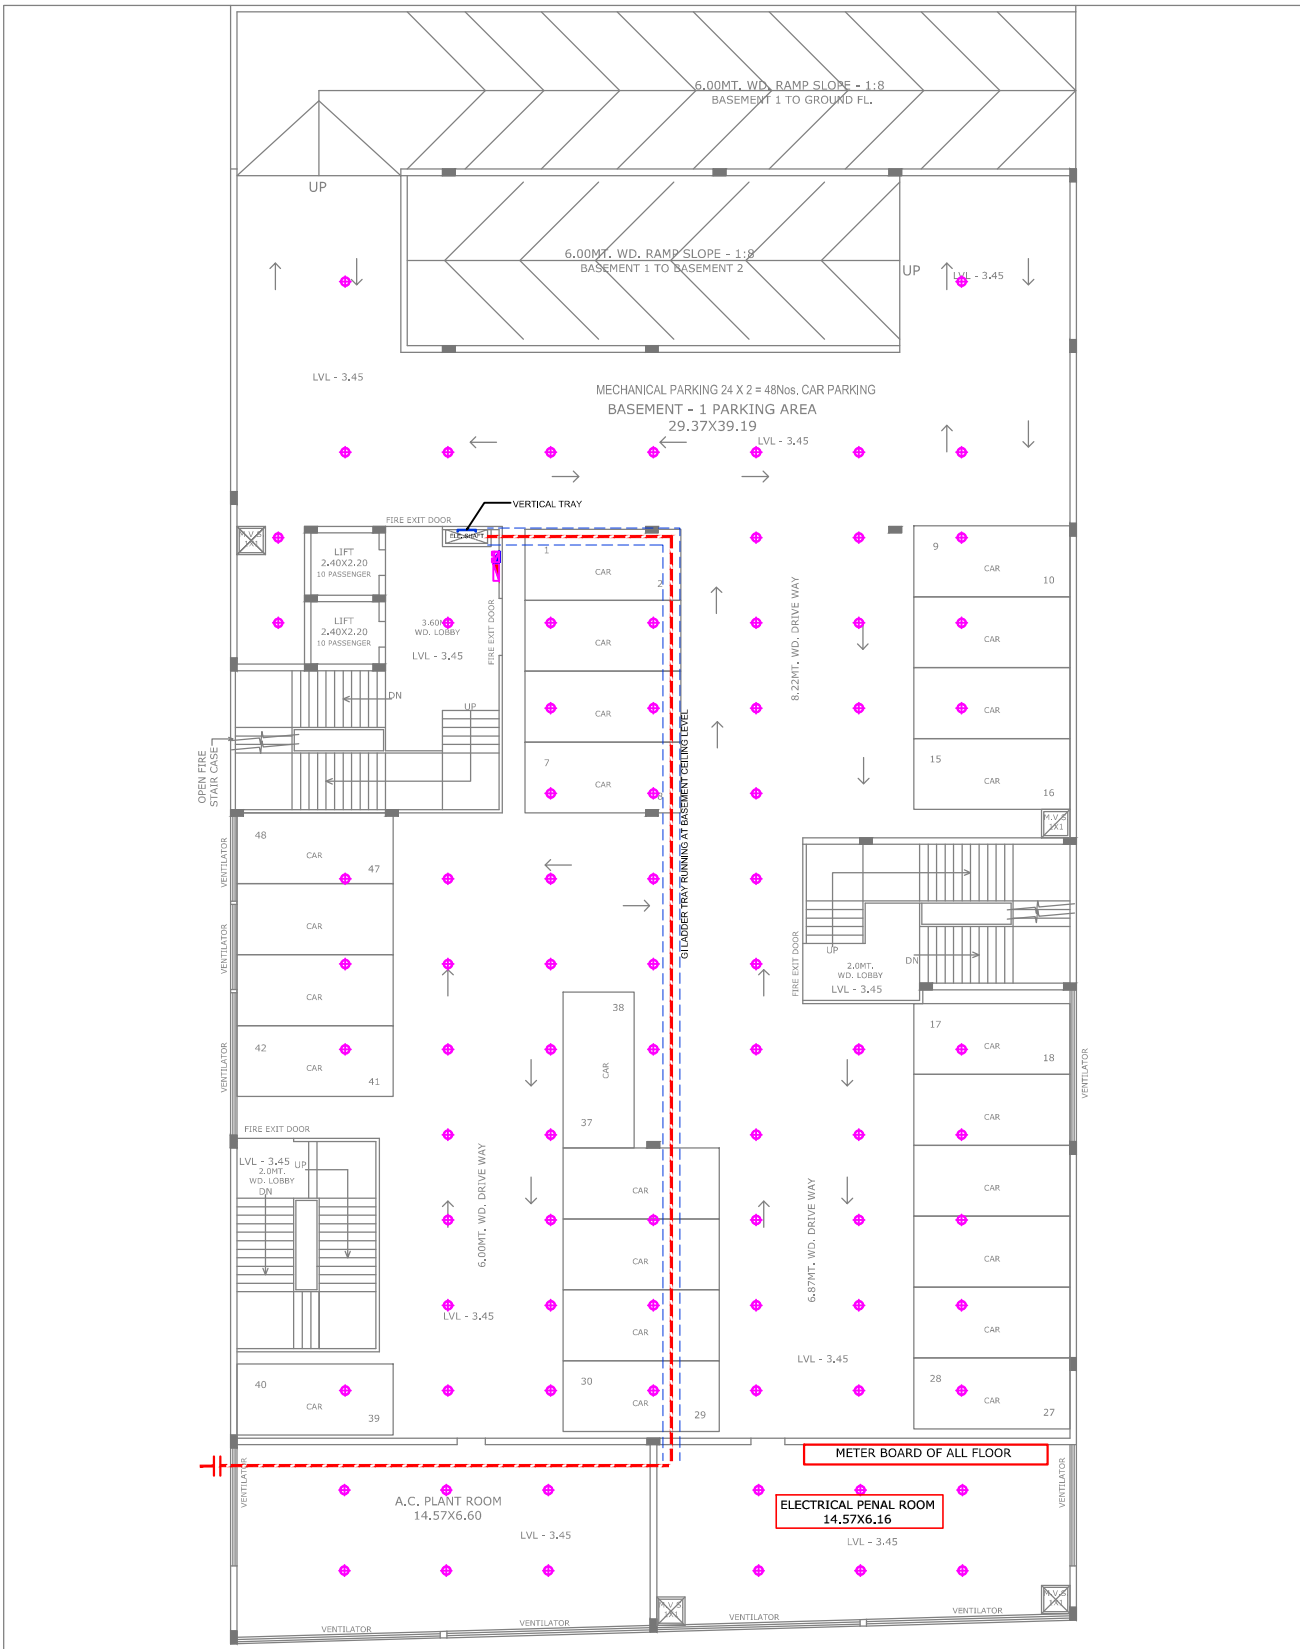


BASEMENT -1 PLAN

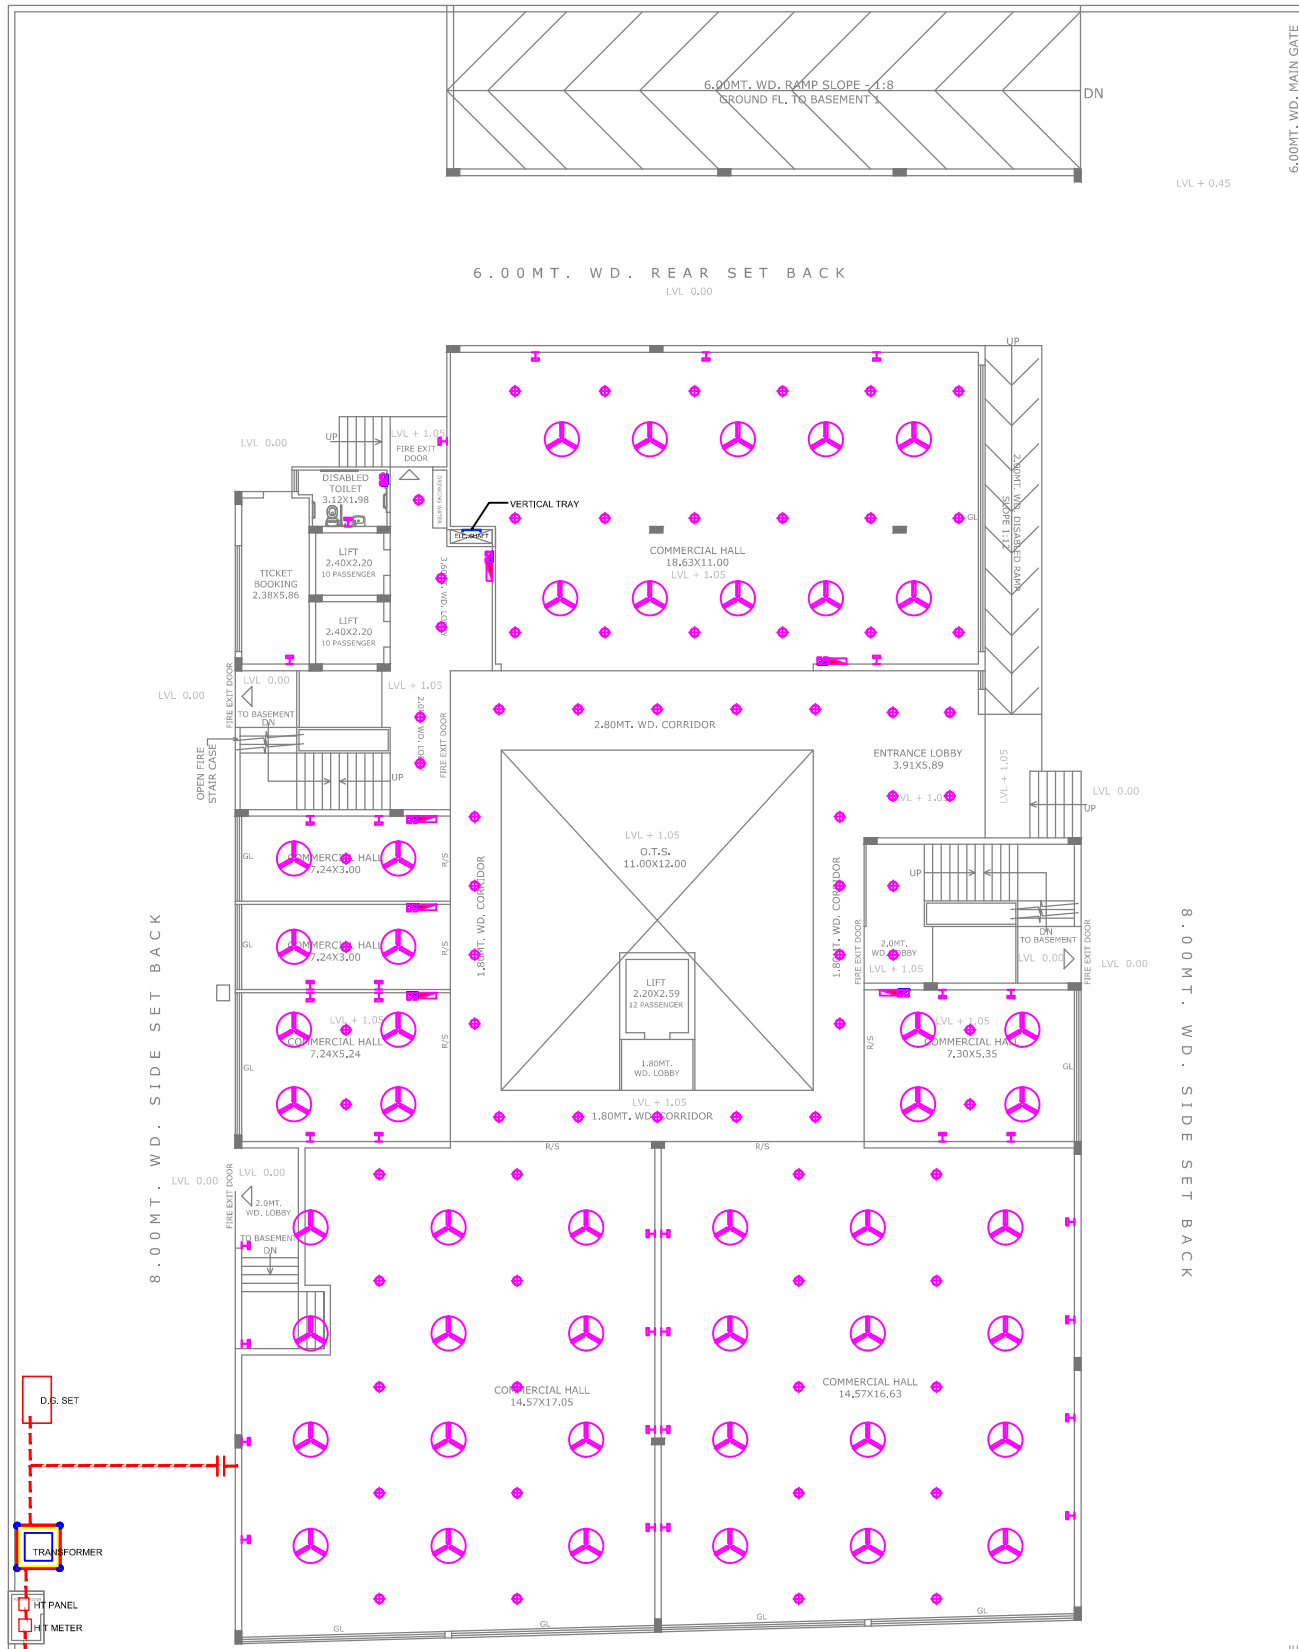


GROUND FLOOR PLAN


---9.00MT. WIDE SERVICE ROAD BAY PASS (N.H.-2)---

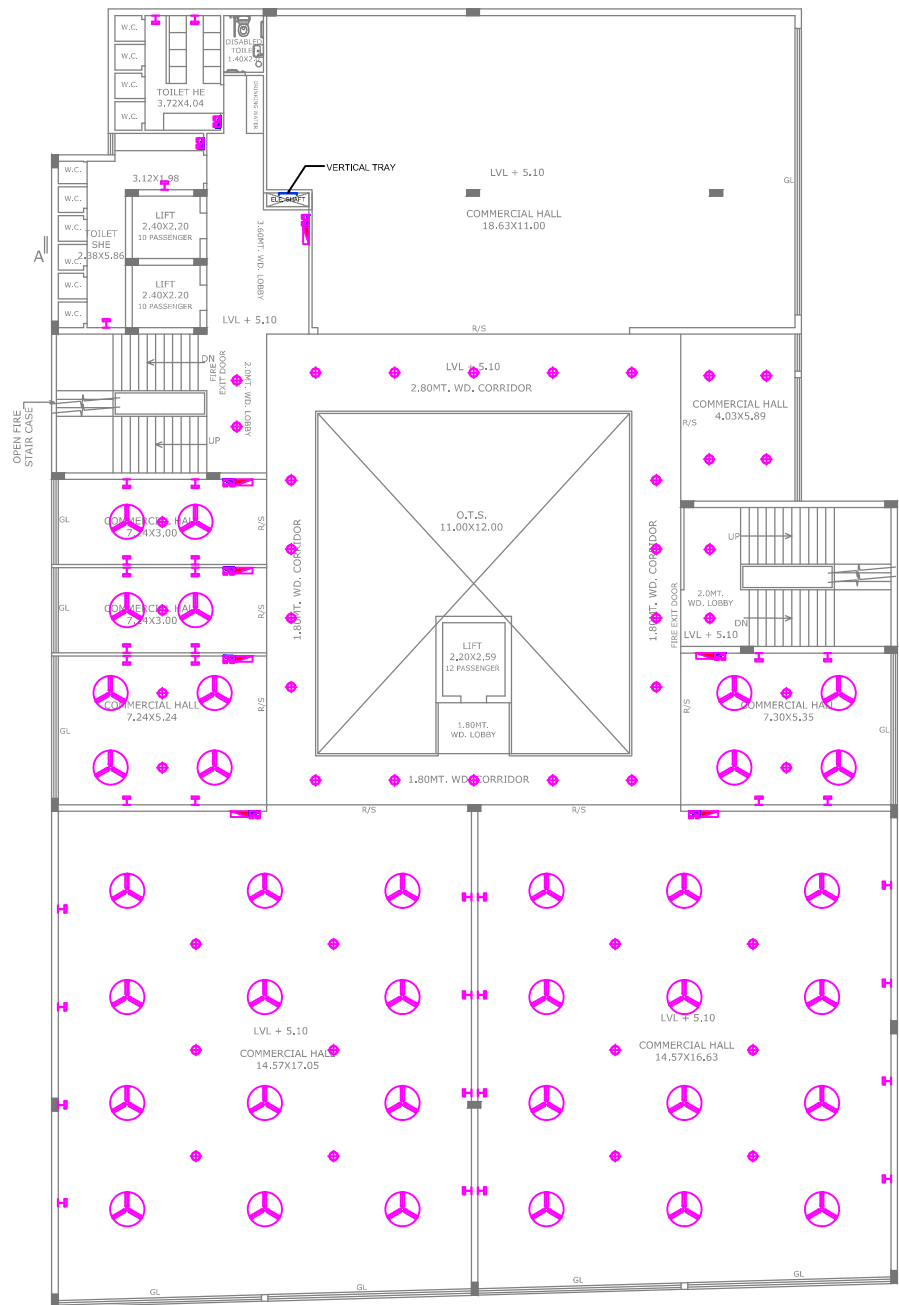


FIRST FLOOR PLAN

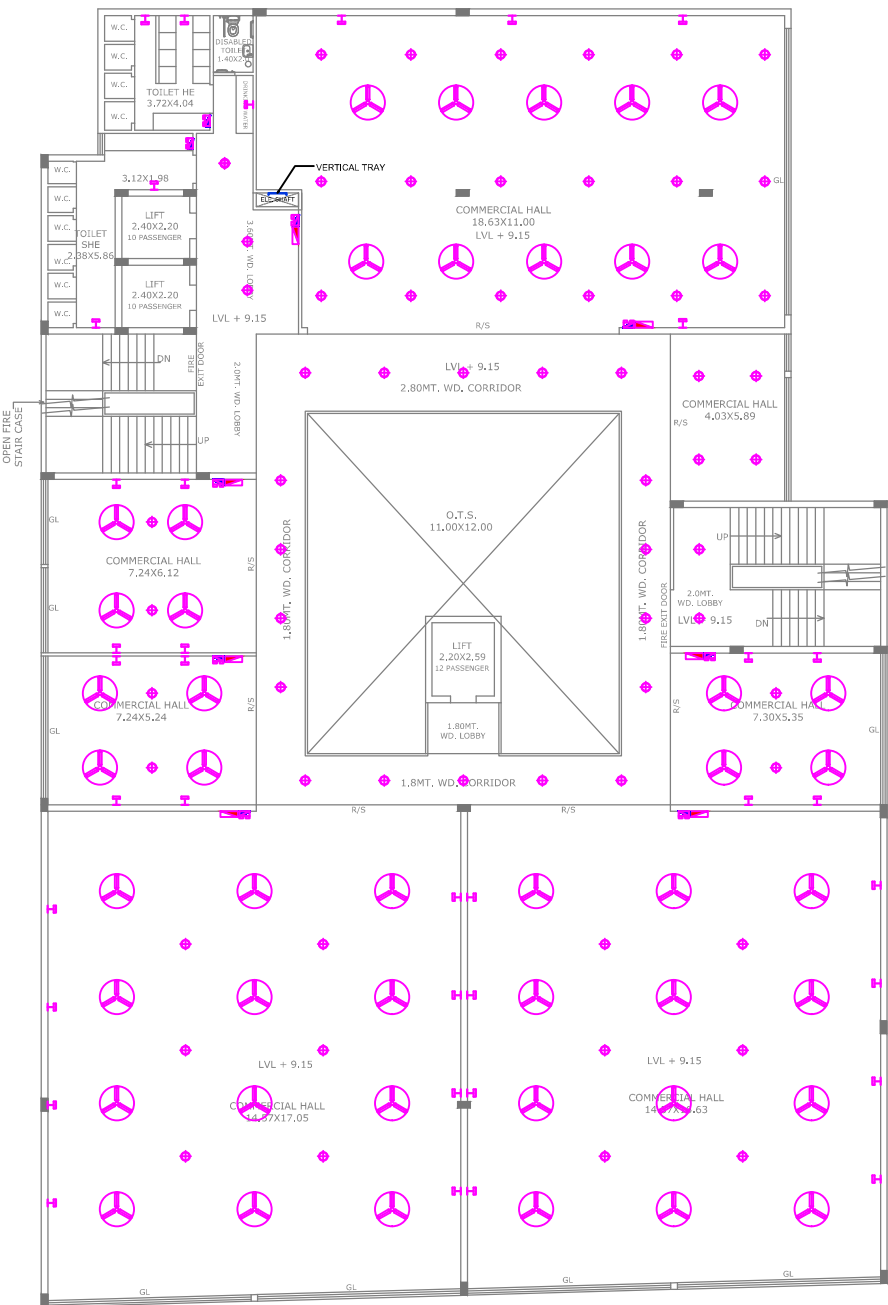


SECOND FLOOR PLAN

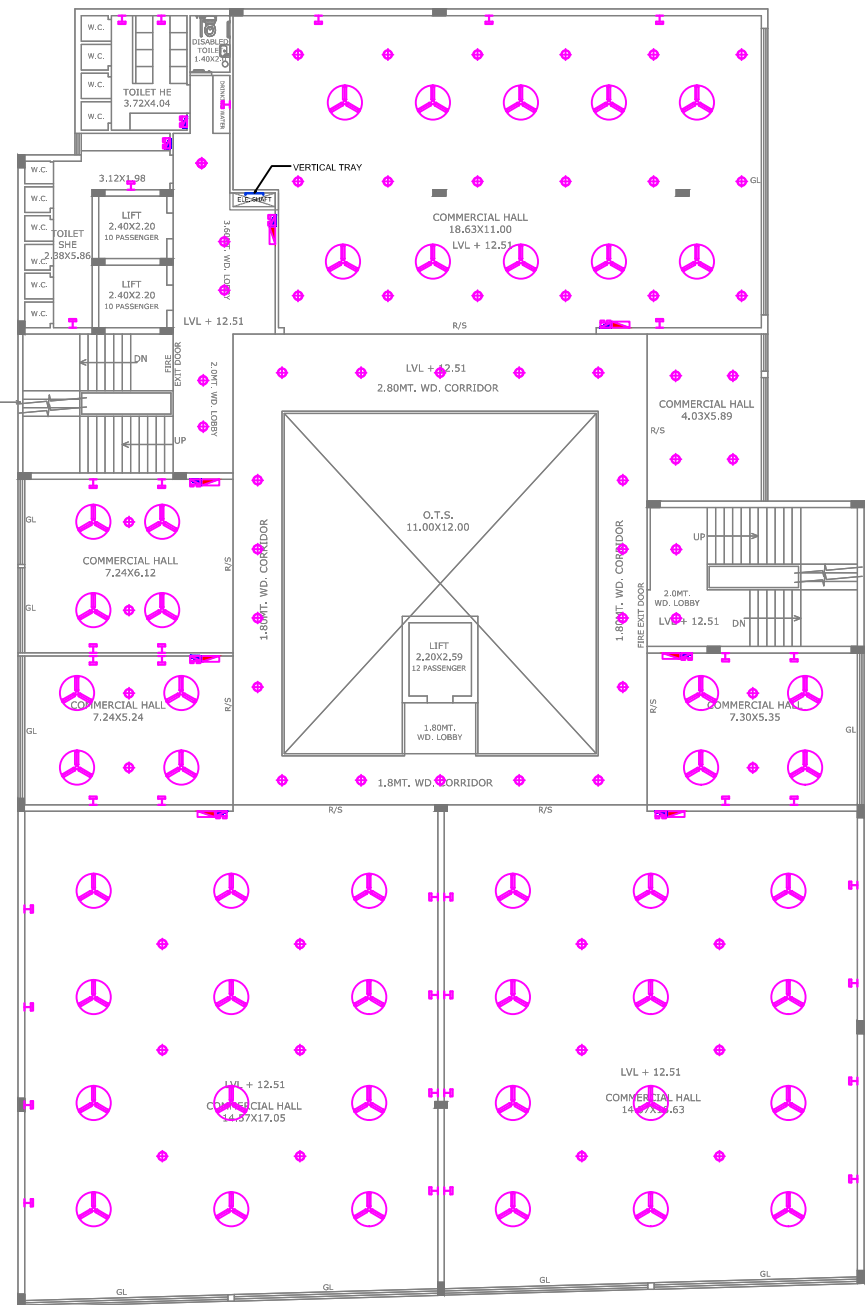


THIRD FLOOR PLAN

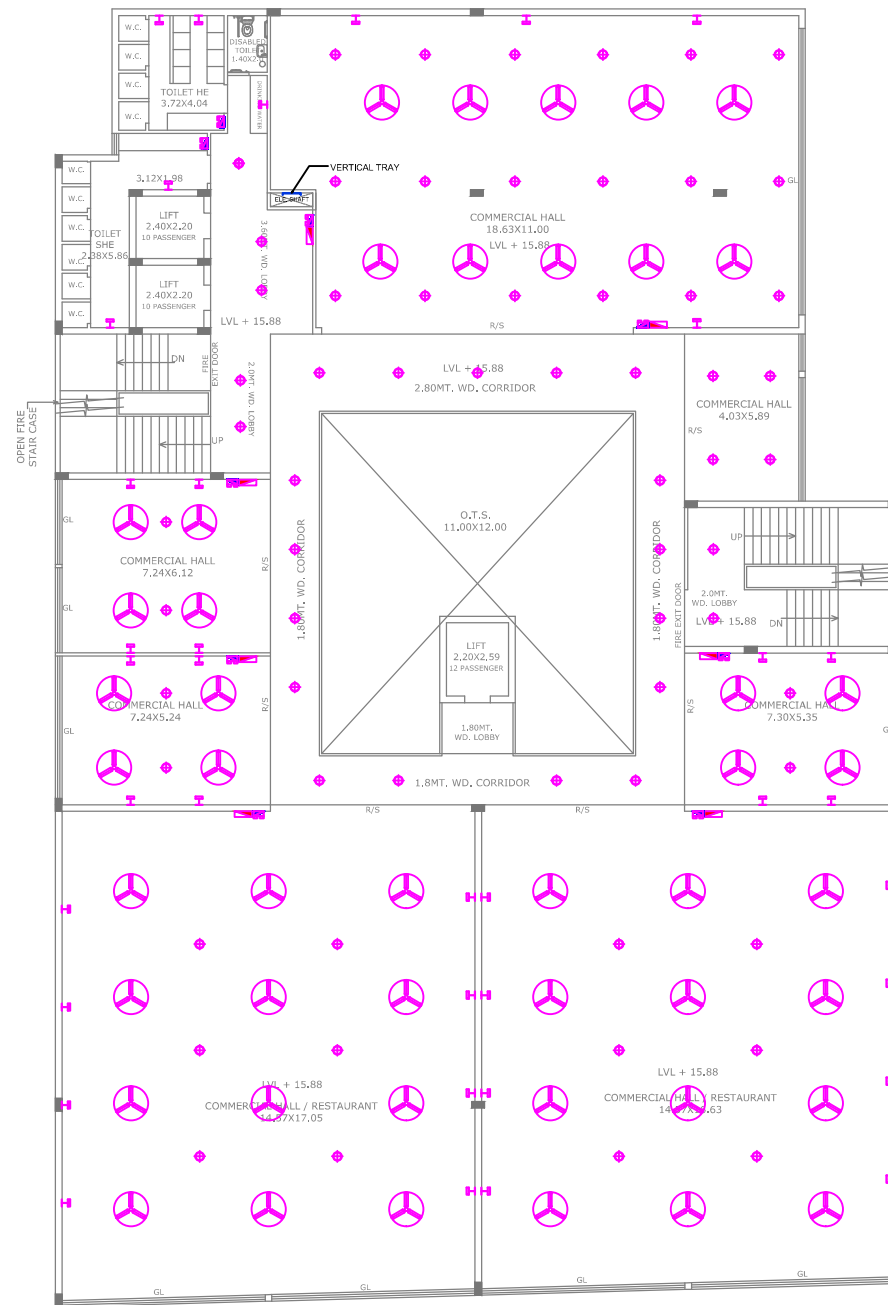

FOURTH FLOOR PLAN

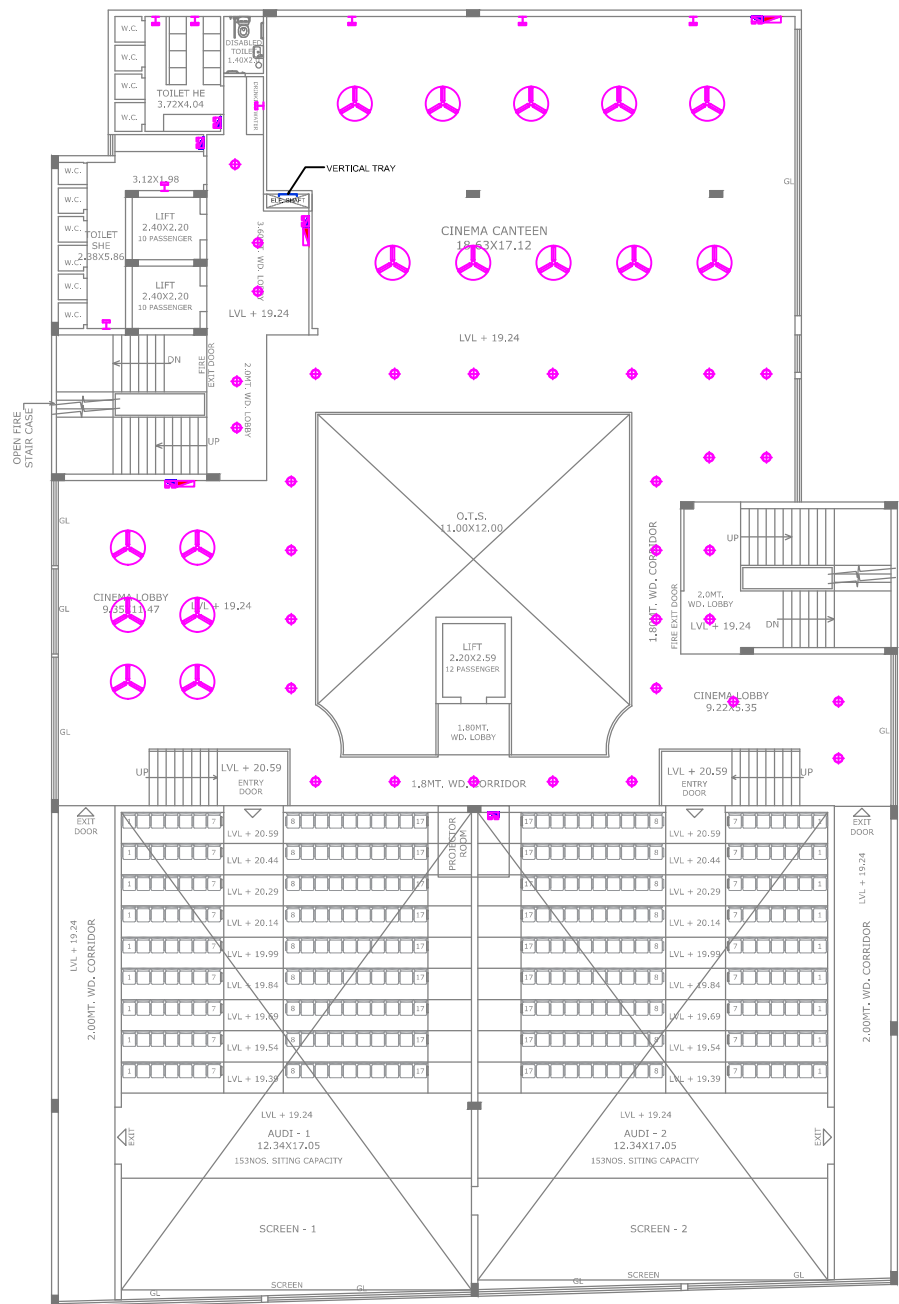


FIFTH FLOOR PLAN

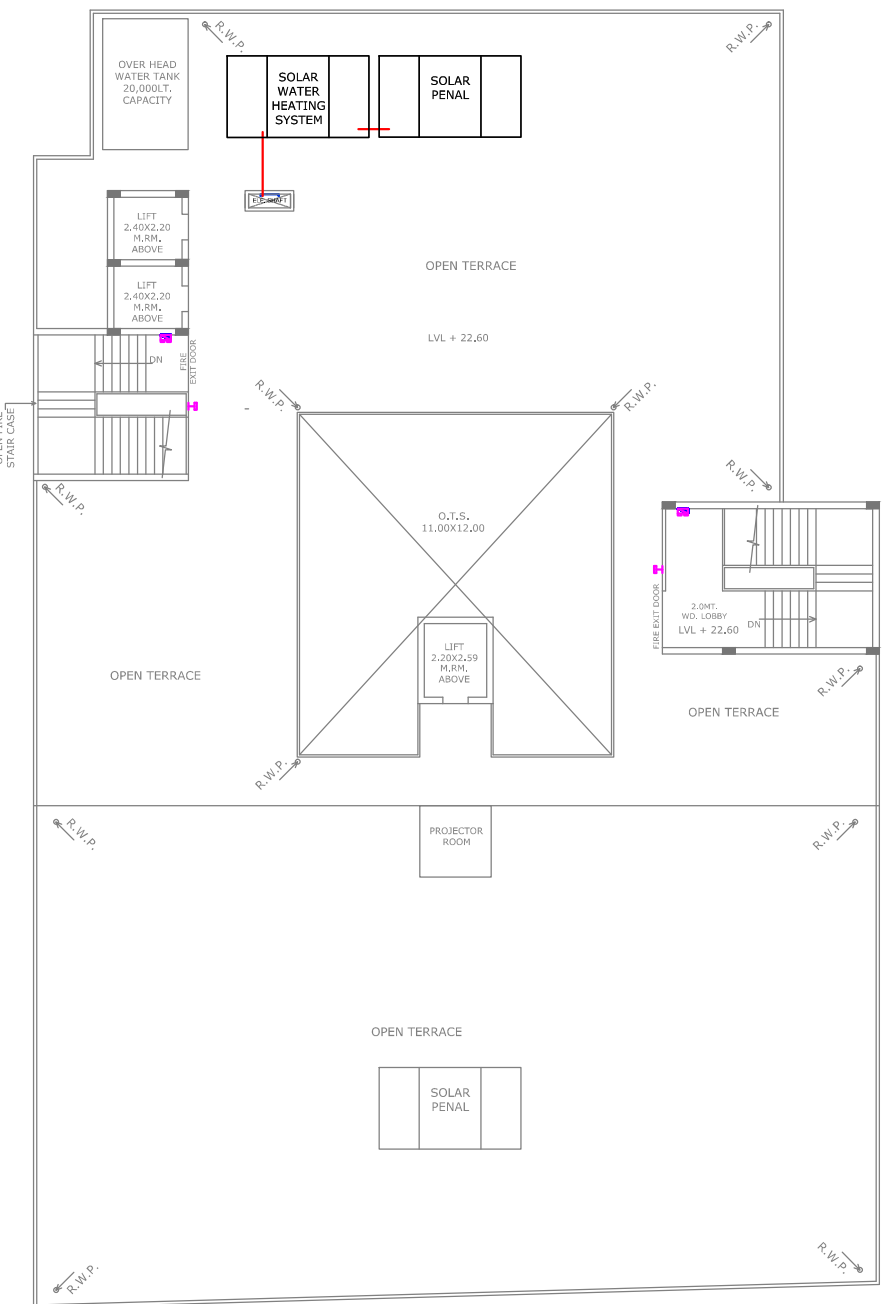

TERRACE PLAN

LEGEND:-	DESCRIPTION
	SURFACE LIGHT
	FAN
	BRACKET LIGHT
	SWITCH BOARD
	DISTRIBUTION BOARD

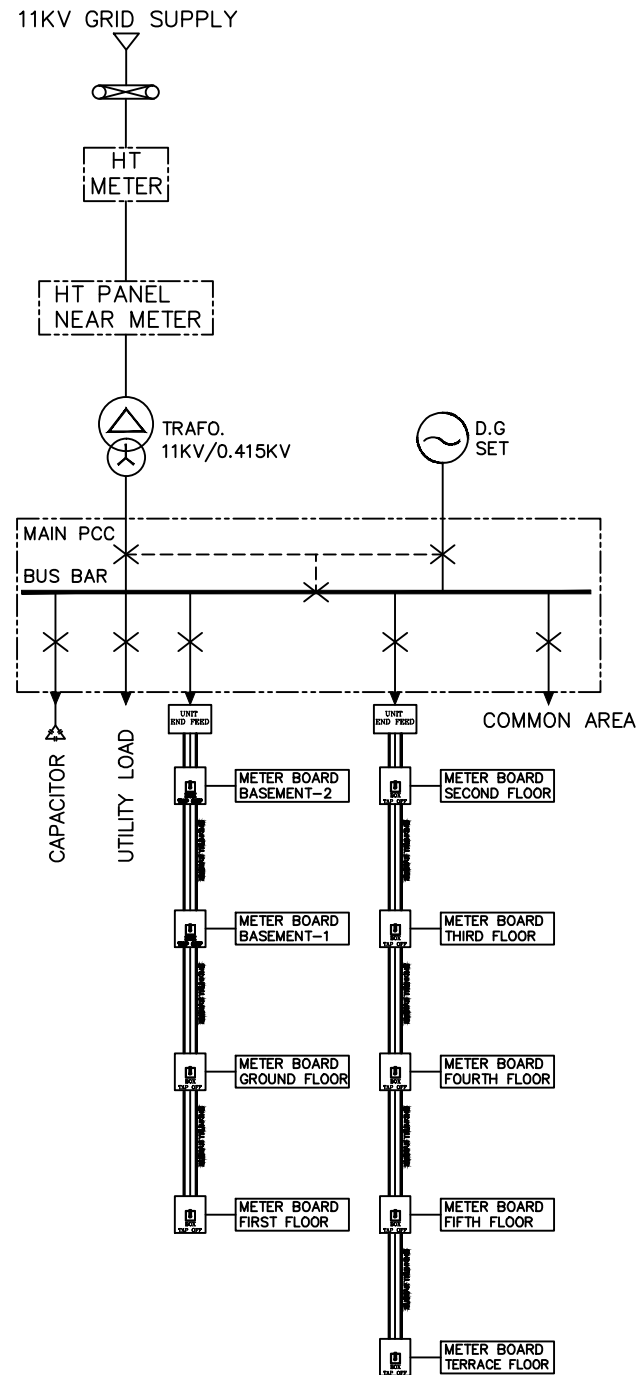

ELECTRICAL SUPPLY SCHEMATIC DIAGRAM

HA -103A, 3rd Floor, Sector -104, Vishwakarma Road, Hazipur, Noida -201304	Scale :- NTS Date:- 19-07-2022 Project no.:-	Drawn by :- Ankit Raj Approved by: Ar. Yeshvir Singh Sheet no: 3	Direction 	Client : Mr. Mohit Agarwal	Project: SHREE RAM TRADE CENTER At Kamla Nagar Bye Pass Road Agra	Drawing Title Electrical Supply Plan	Notes:- All rights reserved. This drawing contains proprietary information which is protected by copyright. No part of this drawing may be reproduced, translated in computer language, or transmitted in any form what- soever without the prior written consent of THEME CONSULTANTS
--	--	--	---------------	-------------------------------	---	--	--