
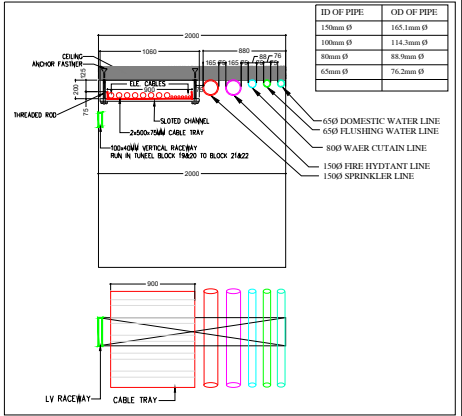


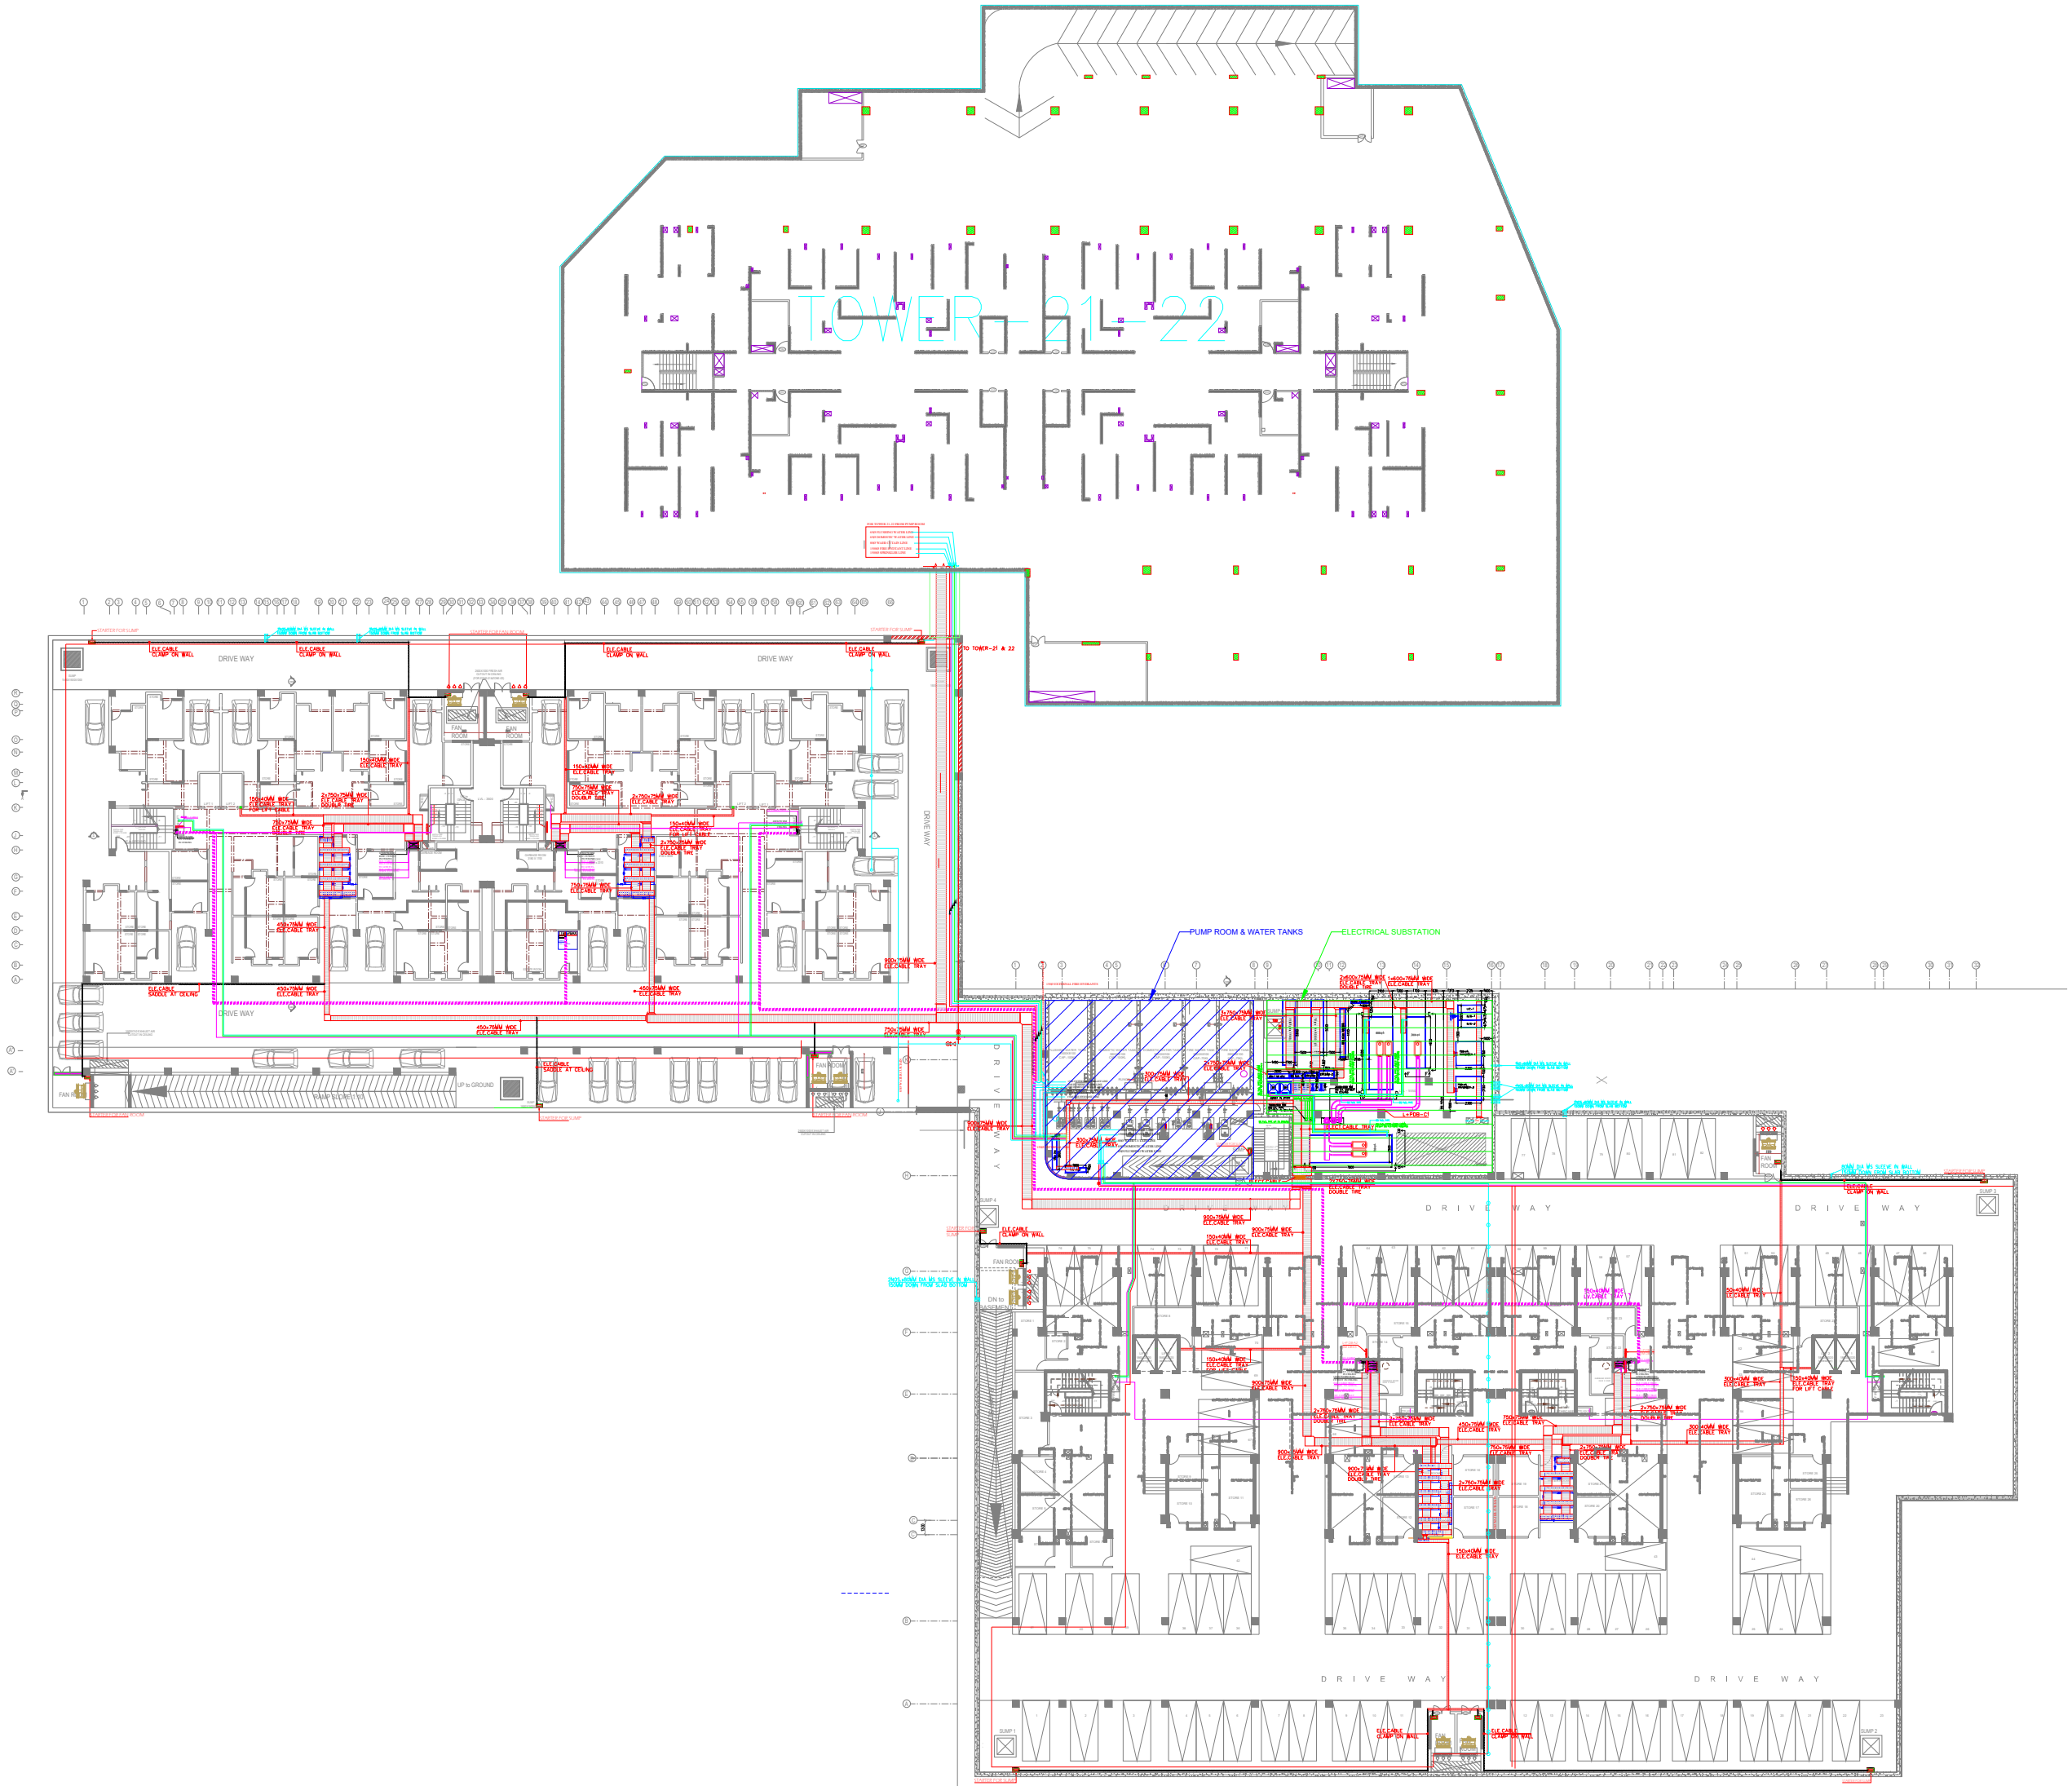

MEP CONSULTANT:
ENVIROCON ENGINEERING SERVICES
MEP CONSULTING ENGINEERS
225, Krishi Apartments, D-Block, Vikaspuri
New Delhi - 110018
Ph. No : 011-4550666/ 9818007611
E-Mail : envirocon23@gmail.com

STRUCTURAL CONSULTANT
ACECON ENGINEERS
A-269, L.G.F. SHIVAJI, MALVIYA NAGAR N. DELHI -17
TEL. +91-11-46080284 S.6. FAX +91-11-46080287
E-Mail - ace@acecon.in, URL: www.acecon.in

ARCHITECTS:-
DESIGN COLLABORATIVE CONSULTING
ENGINEERS, ARCHITECTS, PLANNERS, PROJECT MANAGERS
(An Integrated Real Estate and Infrastructure Consultant)
416, Aggarwal Prestige Mall, Near M2K, Plot No.-2, Road 44, Pitampura,
New Delhi - 110034
EMAIL: designcollaborativeconsulting@gmail.com

ELECTRICAL CONSULTANT:-
ECMS INDIA PVT. LTD.
WP-21 C-282, BASEMENT
NOIDA SECTOR-71,
UTTAR PRADESH-201307
E-mail: ecms.tech01@gmail.com
URL: www.ecmsindia.com

DWG. TITLE- COMBINED SERVICES LAYOUT BASEMENT FLOOR PLAN TOWER- 16,17,18,19,20,21 & 22	
☐ SUBMISSION LAYOUT	☐ ADVANCE COPY
☐ FOR APPROVAL	☒ GOOD FOR CONSTRUCTION
☐ TENDER DRAWING	☐ REFERENCE DRAWING
DRAWN BY MANDEEP SINGH	REV NO. R0(16.11.2021)
CKD BY SANJAY	SCALE 1:200(A1)
FIN. YEAR 2020-21	JOB NO. 2045
DRAWING NO.	GH-1B/ECMS/BAS. FL/EL.01B