
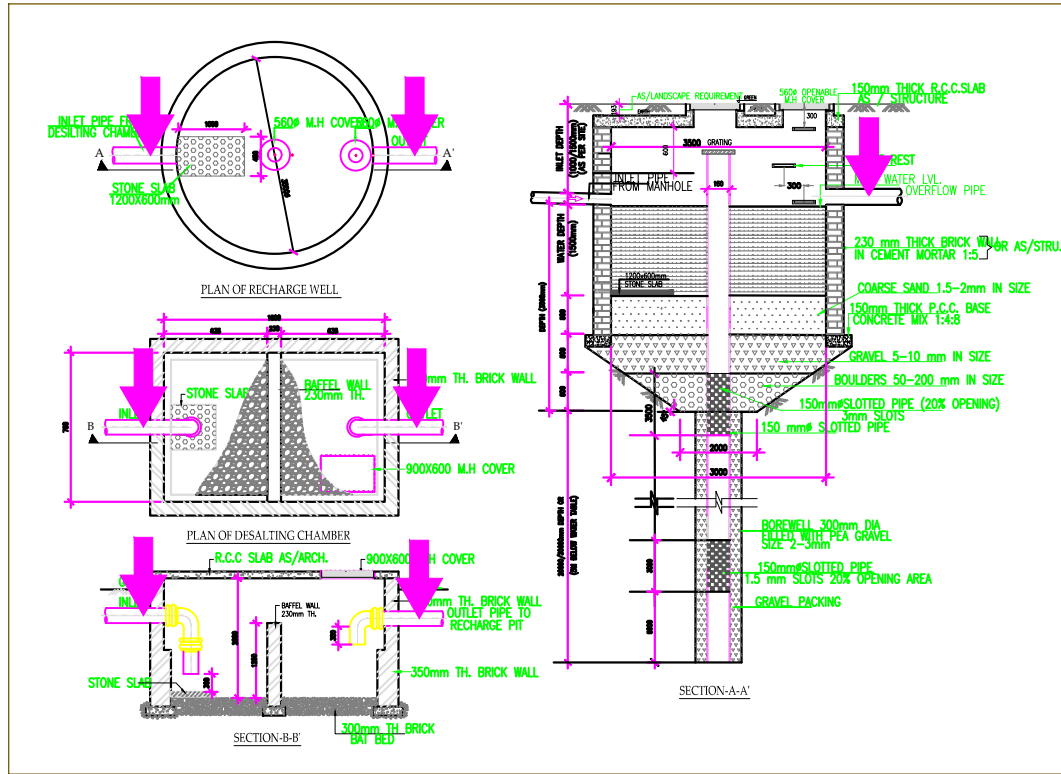


ROAD 30.00 MT WD. LVL ± 00

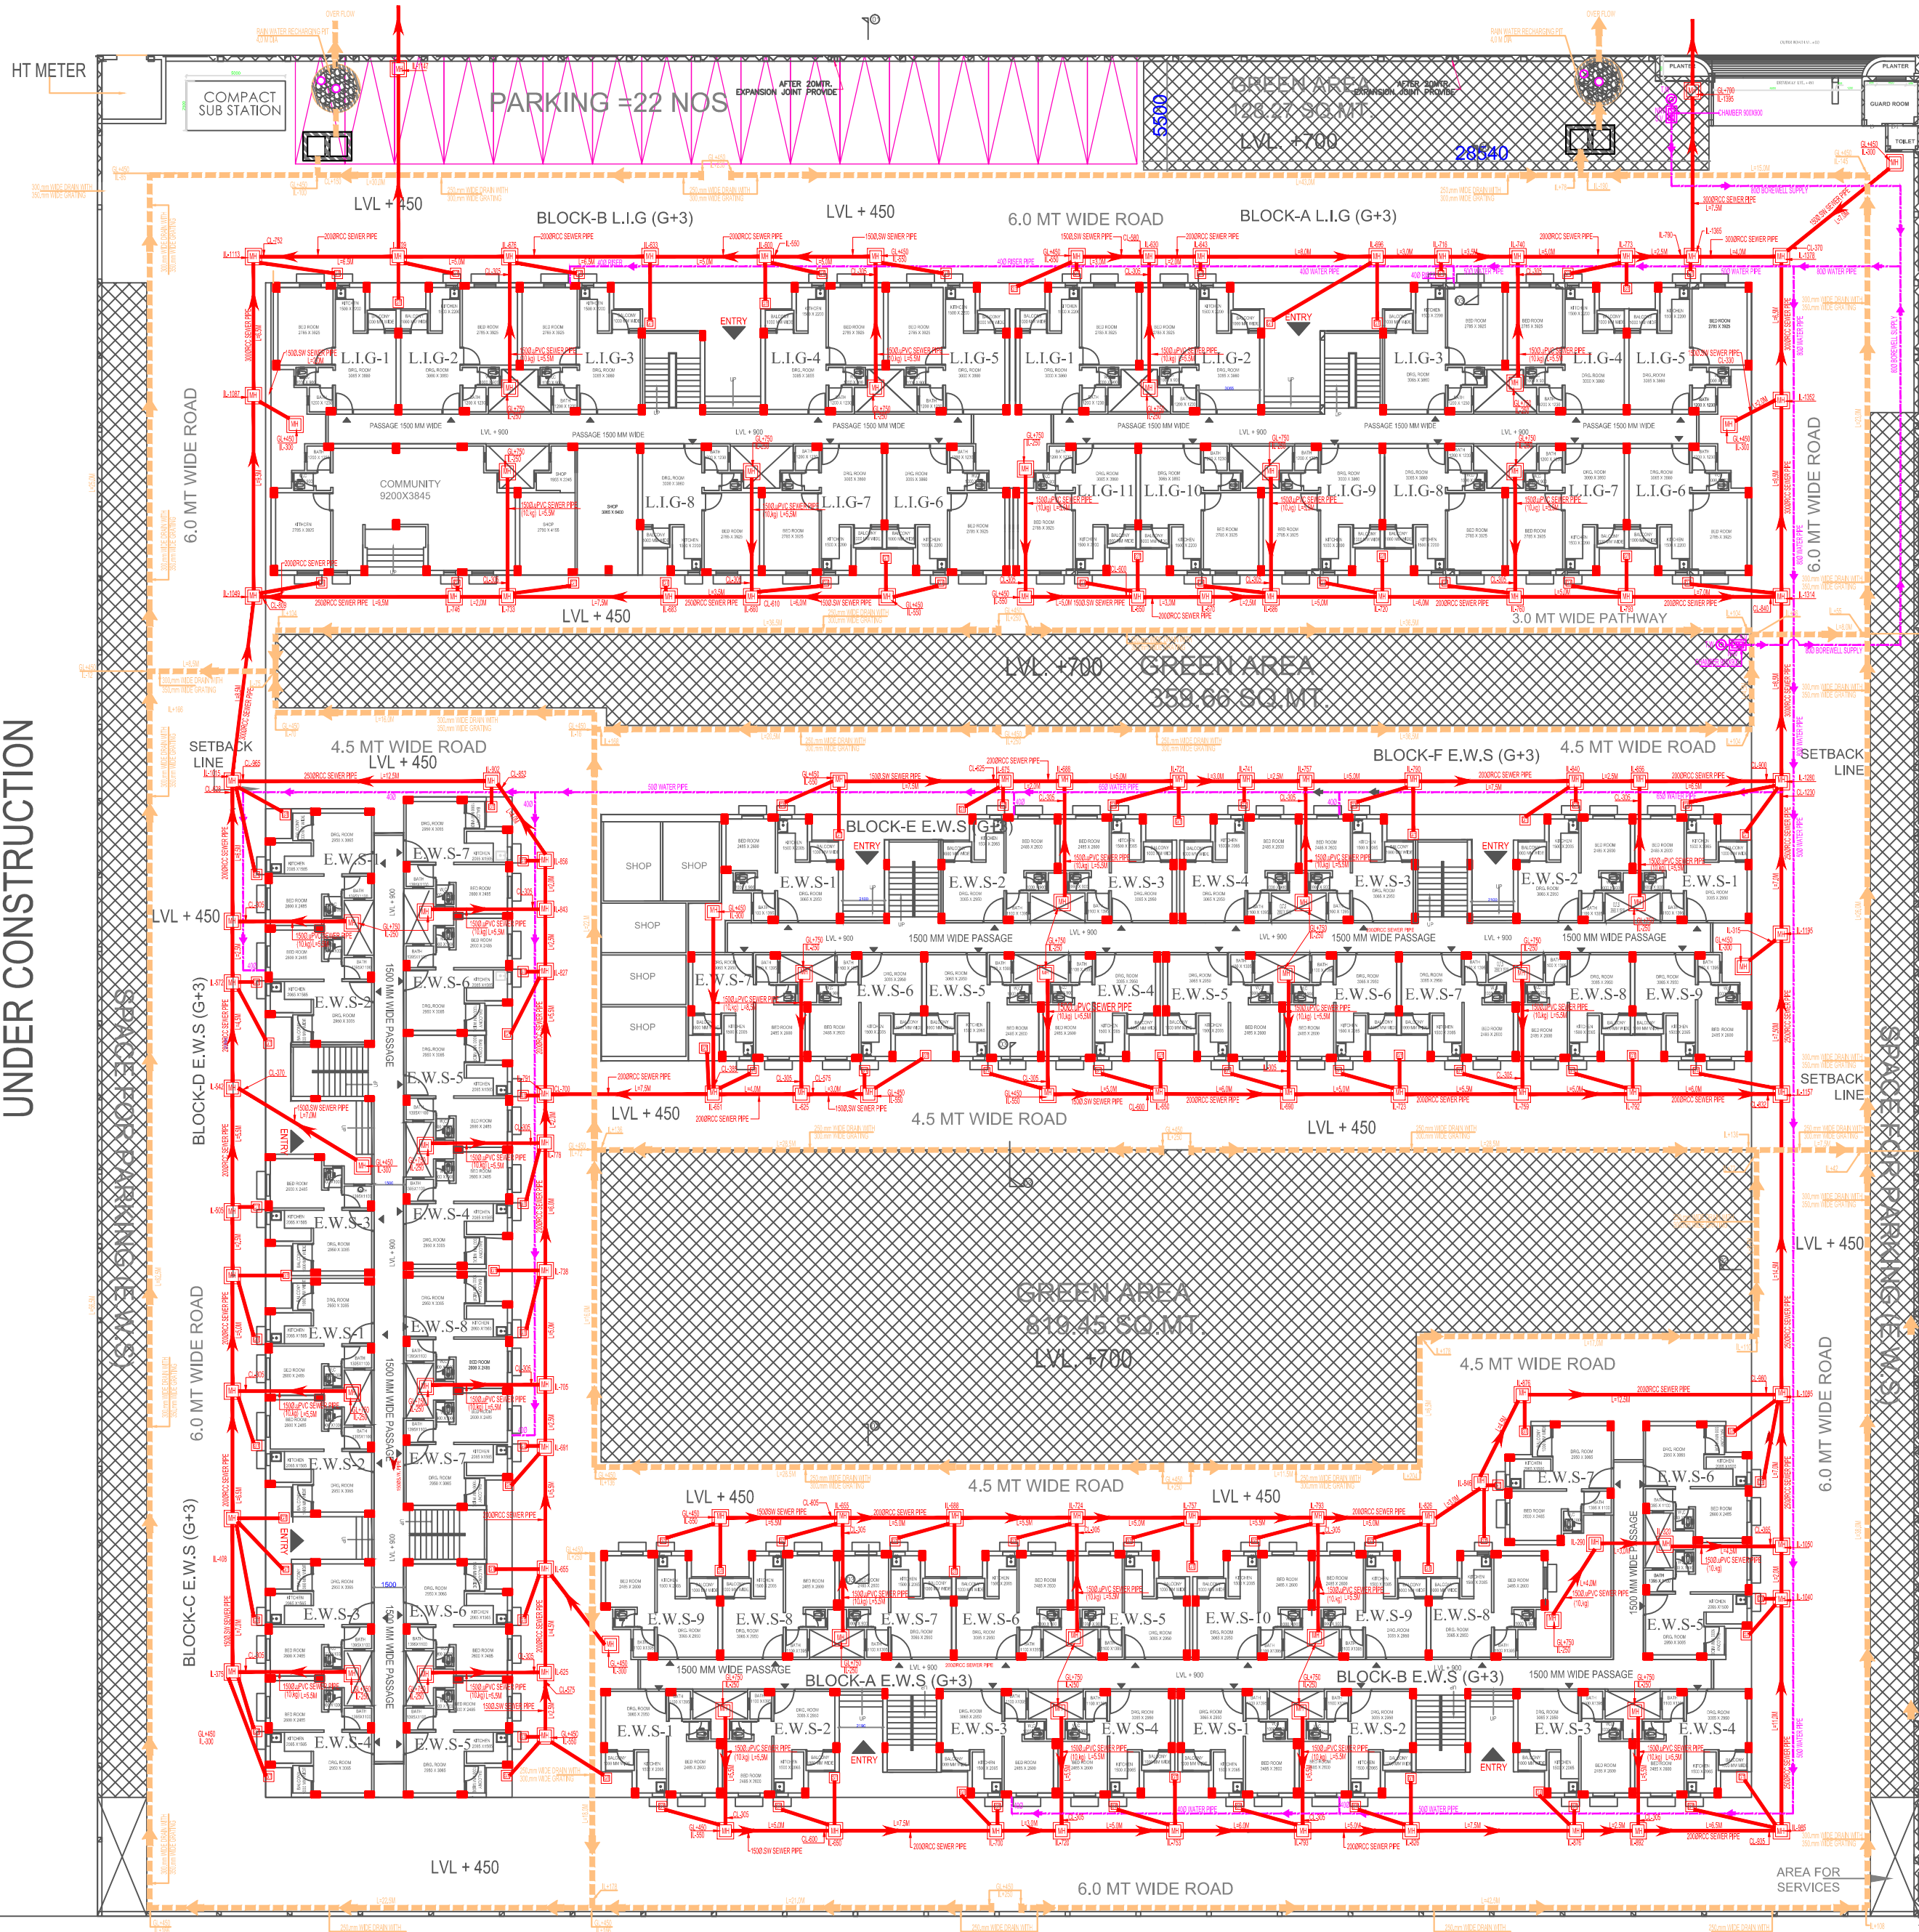

LEGEND :- SEWER PIPE SLOPE

- 1....150ØRCC S.W PIPE SLOPE =1:100
- 2....200ØRCC SEWER PIPE SLOPE =1:150
- 3....250ØRCC SEWER PIPE SLOPE =1:200
- 4....300ØRCC SEWER PIPE SLOPE =1:250

- [MH] SEWER MANHOLE
[GT] GULLY TRAP

ROAD 24.00 Mts WD.

PLUMBING SITE PLAN

ANAND VIHAR RESIDENTIAL SCHEME, HAPUR (BLOCK-H GROUP HOUSING-1)

DRAWING TITLE

SERVICE PLAN (L.I.G & E.W.S)
WATER SUPPLY SYSTEM
(RAIN WATER & WASTE WATER SYSTEM)
(SEWERAGE SYSTEM)
STORM WATER LINE

ARCHITECT SIGN

OWNER SIGN

ANUJ AGARWAL ARCHITECTS
OFFICE:- A-244 KAUSHAMBI GHAZIABAD (U.P.)
Ph:-0120 - 6454182 / 84, 4165716, TEL. FAX - 2773592
e-mail : arch.anujagarwal@gmail.com

SCALE

DEALT BY

DATE

DESIGN BY

CHECKED BY

DRG. No.